


Layout Plan for Mai Wah Industrial Building (G/F)

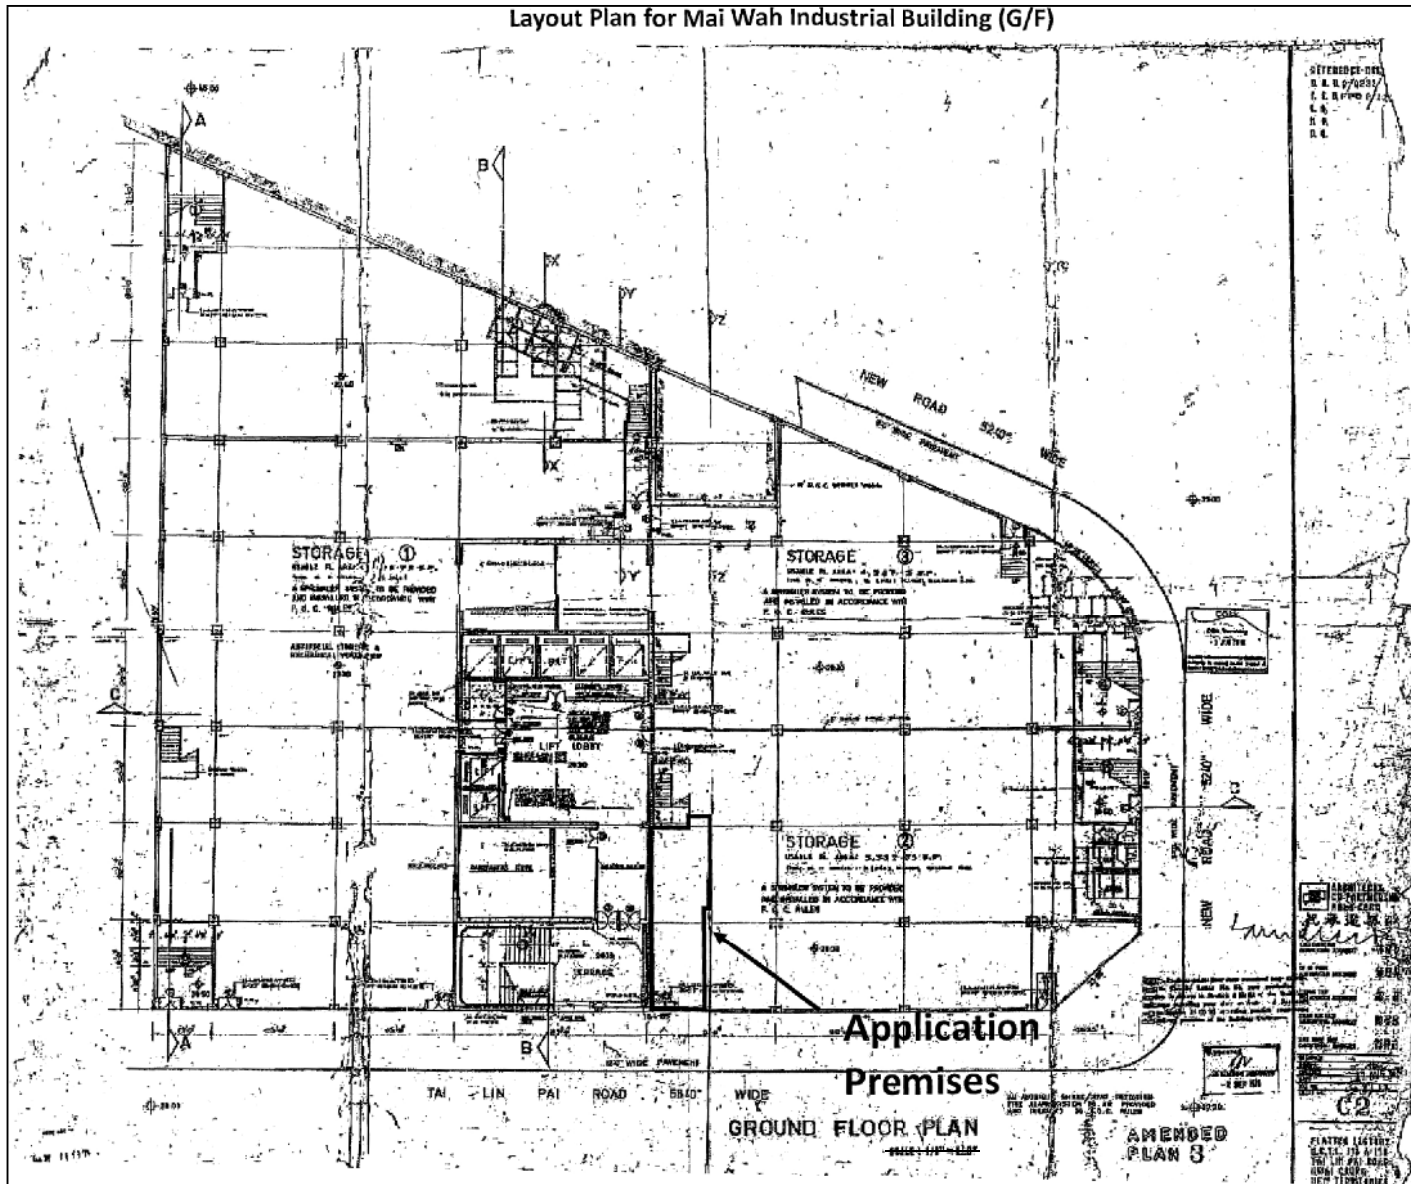

參考編號 REFERENCE No. A/KC/462	繪圖 DRAWING A-1
-----------------------------------	----------------------

(來源：附錄 I)
 (Source : Appendix I)


- NOTES:
- 1) ALL DIMENSIONS SHALL BE GIVEN IN METERS.
 - 2) DRAWING IS NOT VALID FOR CONSTRUCTION UNLESS APPROVED BY THE FIRE DEPARTMENT.
 - 3) DRAWING IS NOT VALID FOR CONSTRUCTION UNLESS APPROVED BY THE FIRE DEPARTMENT.
 - 4) DRAWING IS NOT VALID FOR CONSTRUCTION UNLESS APPROVED BY THE FIRE DEPARTMENT.

LEGEND:


- S.C. WOODEN DOOR
- FULL HT. WOODEN PARTITION
- FULL HT. BRICK WALL PARTITION
- FULL HT. PARTITION
- NEW EXIT SIGN BOX 2 NOS.
新安裝-出口方向指示牌
- NEW EMERGENCY LIGHTING 4 NOS.
新安裝-後備照明燈



Location Plan (N.T.S)
MAI WAH INDUSTRIAL BUILDING,
1-7 WAH SING STREET,
KWAI CHUNG, N.T.

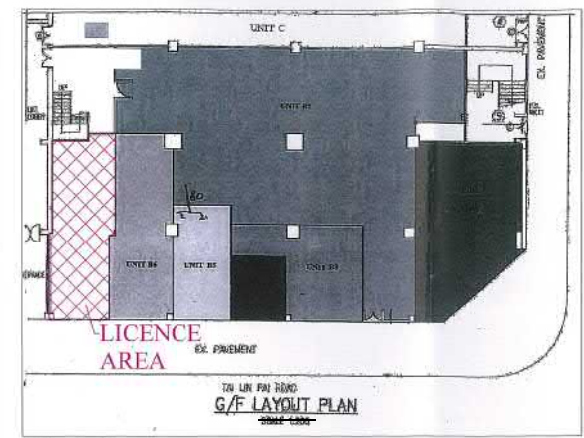

Block Plan (N.T.S)
MAI WAH INDUSTRIAL BUILDING, 1-7 WAH SING STREET,
KWAI CHUNG, N.T.

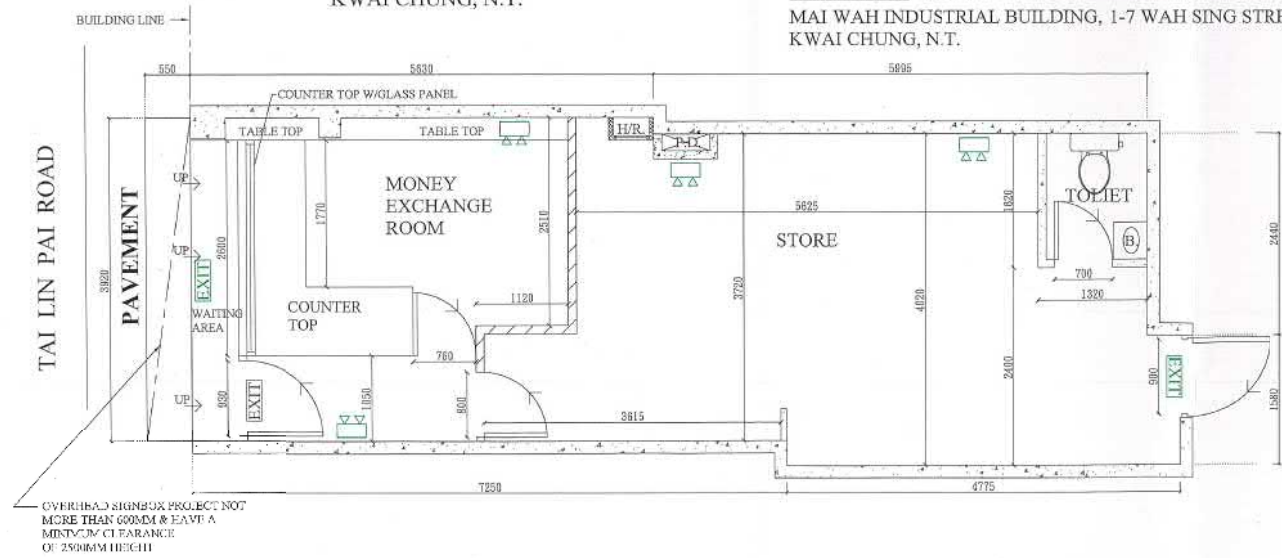


本公司提供24小時緊急服務熱線: 72727070
The company provides 24-hours Emergency Service Hotline: 72727070 如對此圖則有技術上問題, 請聯絡是項工程負責人 張嘉文先生 電話: 9333 5490 傳真: 2396 2900

YOUR REF.:	
OUR REF.:	
NOTES:	
REV.:	DATE:
A	08-04-2019
 張文飲食牌照顧問公司 Cheung Man Catering Licenses Consultant Company Limited 張文消防工程顧問有限公司 Cheung Man Fire Eng. Consultant Company Limited Flat 606, 6/F, Block A, Pak Kwang Industrial Building, 65-68 Tong M. Road, Mong Kok, Kowloon. Tel No.: 2391 1183 Fax No.: 2396 2900 E-mail: info@cheungman.com.hk 張文消防工程顧問有限公司 註冊小型工程承建商(公司) 註冊編號: MWC 4670/2011	
DO NOT SCALE DRAWING, ALL MEASUREMENTS MUST BE VERIFIED AT SITE	
ALL DIMENSIONS ARE IN mm	
PROJECT:	
SHOP B7, G/F, MAI WAH INDUSTRIAL BUILDING, 1-7 WAH SING STREET, KWAI CHUNG, N.T.	
ARCHITECT:	
DRAWING TITLE:	
LAYOUT PLAN	
DWG. NO.:	
201904004	
DESIGN BY:	DRAWN BY:
Cheungman	Wong man kin
DATE:	SCALE:
08-04-2019	1:50 (A3)
CHECK BY:	APR BY:
	REV:
	A

參考編號 REFERENCE No.	繪圖 DRAWING
A/KC/462	A-2

(來源: 附錄 I)
(Source: Appendix I)

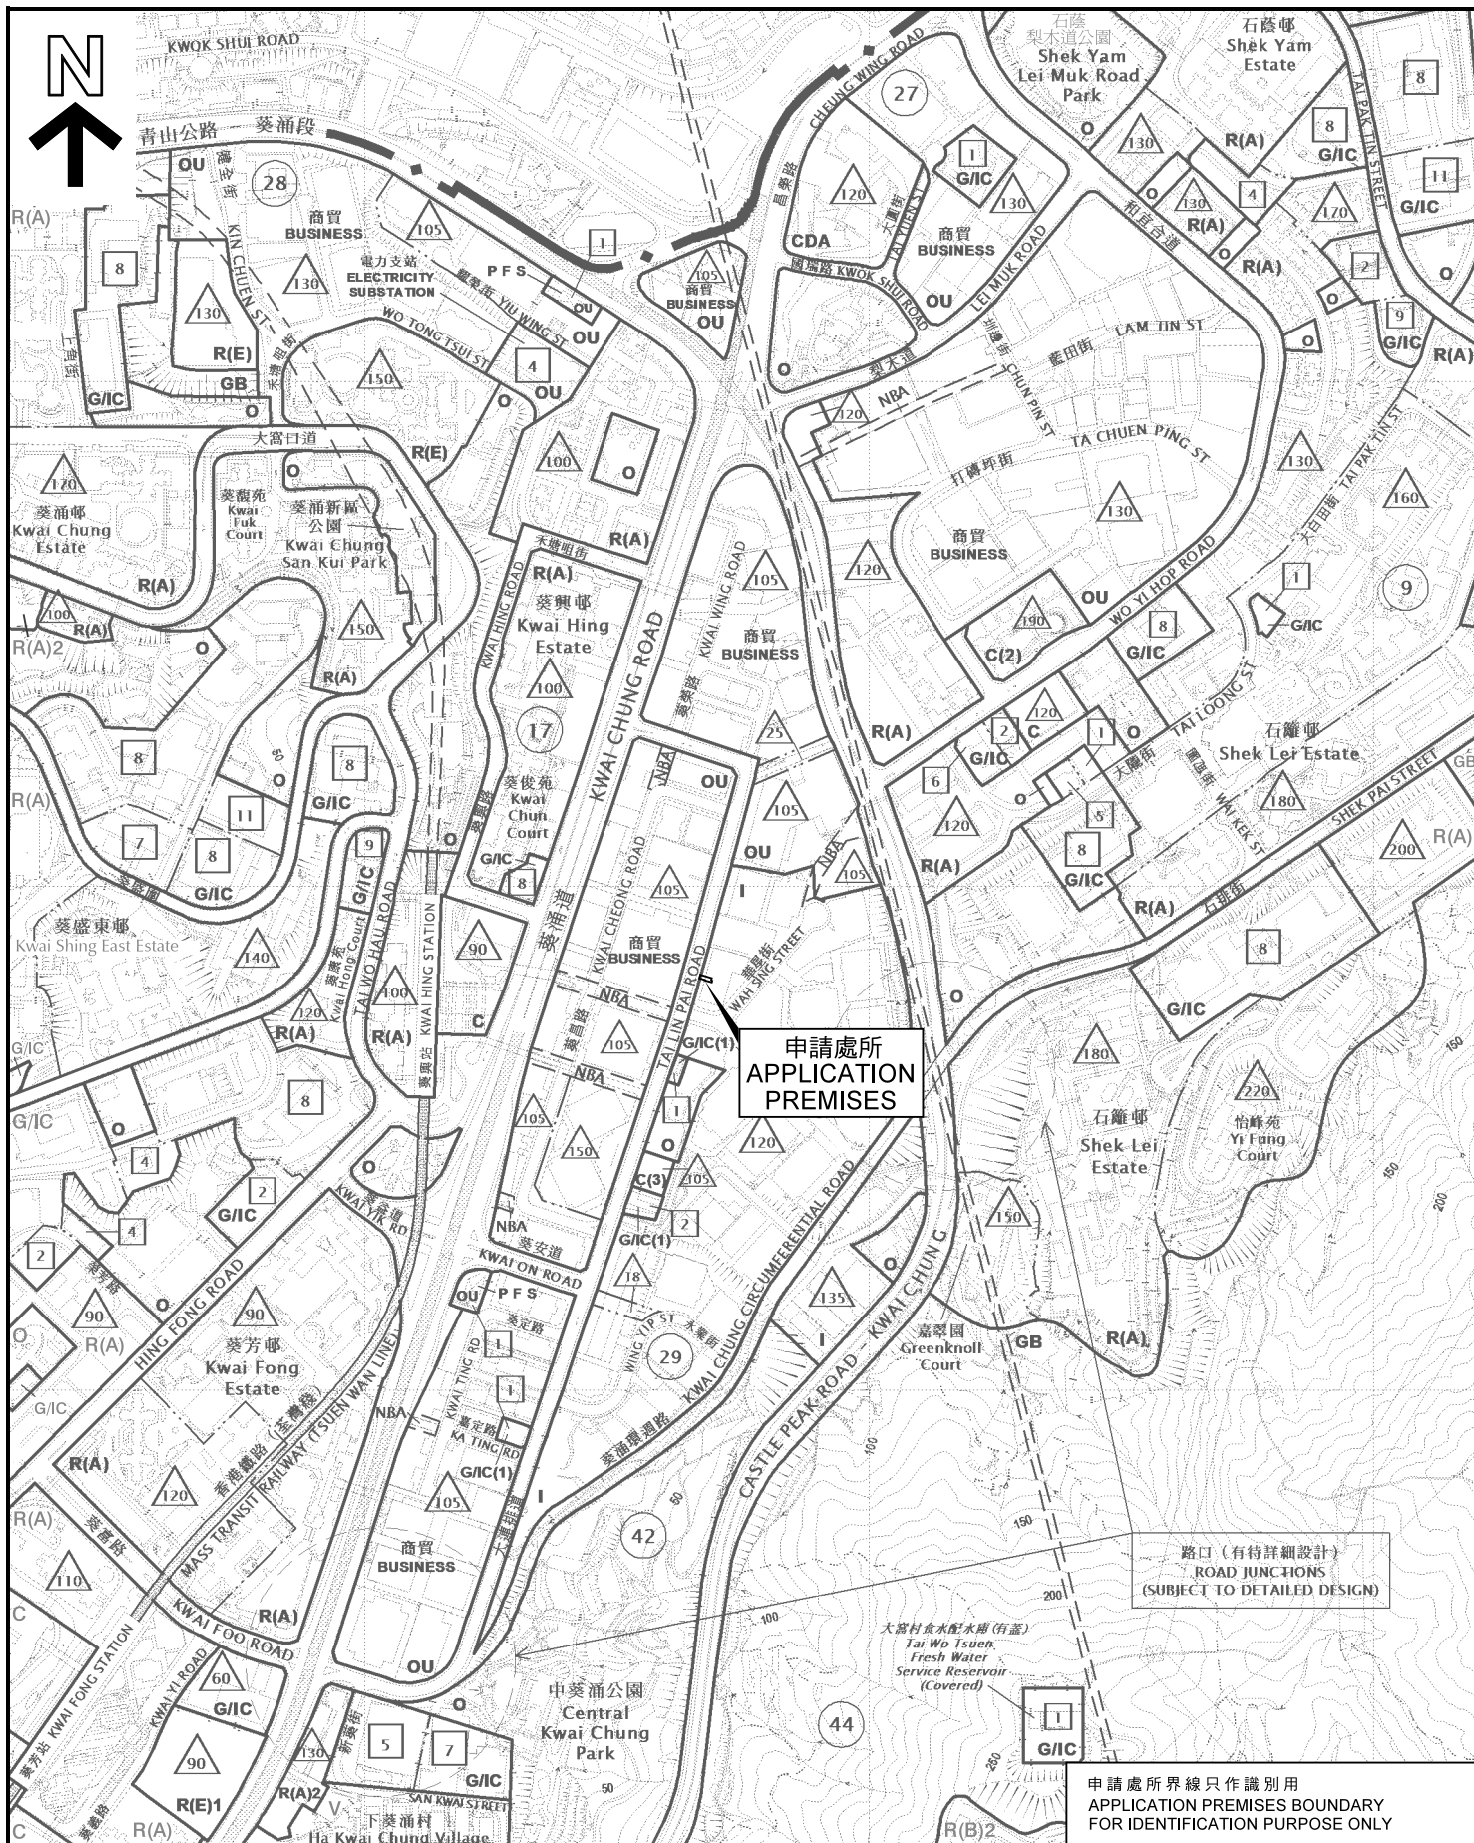

路口 (有特詳細設計)
ROAD JUNCTIONS
(SUBJECT TO DETAILED DESIGN)

大窰村食水配水庫 (有蓋)
Tai Wo Tsuen
Fresh Water
Service Reservoir
(Covered)

申請處所界線只作識別用
APPLICATION PREMISES BOUNDARY
FOR IDENTIFICATION PURPOSE ONLY

位置圖 LOCATION PLAN

商店及服務行業
葵涌華生街1-7號美華工業大廈地下B7號舖

SHOP AND SERVICES
SHOP B7, G/F, MAI WAH INDUSTRIAL BUILDING
1-7 WAH SING STREET, KWAI CHUNG

SCALE 1 : 7 500 比例尺

米 100 0 100 200 300 米
METRES

規劃署
PLANNING
DEPARTMENT



參考編號
REFERENCE No.


A/KC/462

圖 PLAN

A-1

本摘要圖於2019年6月18日擬備，所根據的資料為於2018年1月19日展示的分區計劃大綱圖編號S/KC/29

EXTRACT PLAN PREPARED ON 18.6.2019
BASED ON OUTLINE ZONING PLAN No.
S/KC/29 EXHIBITED ON 19.1.2018

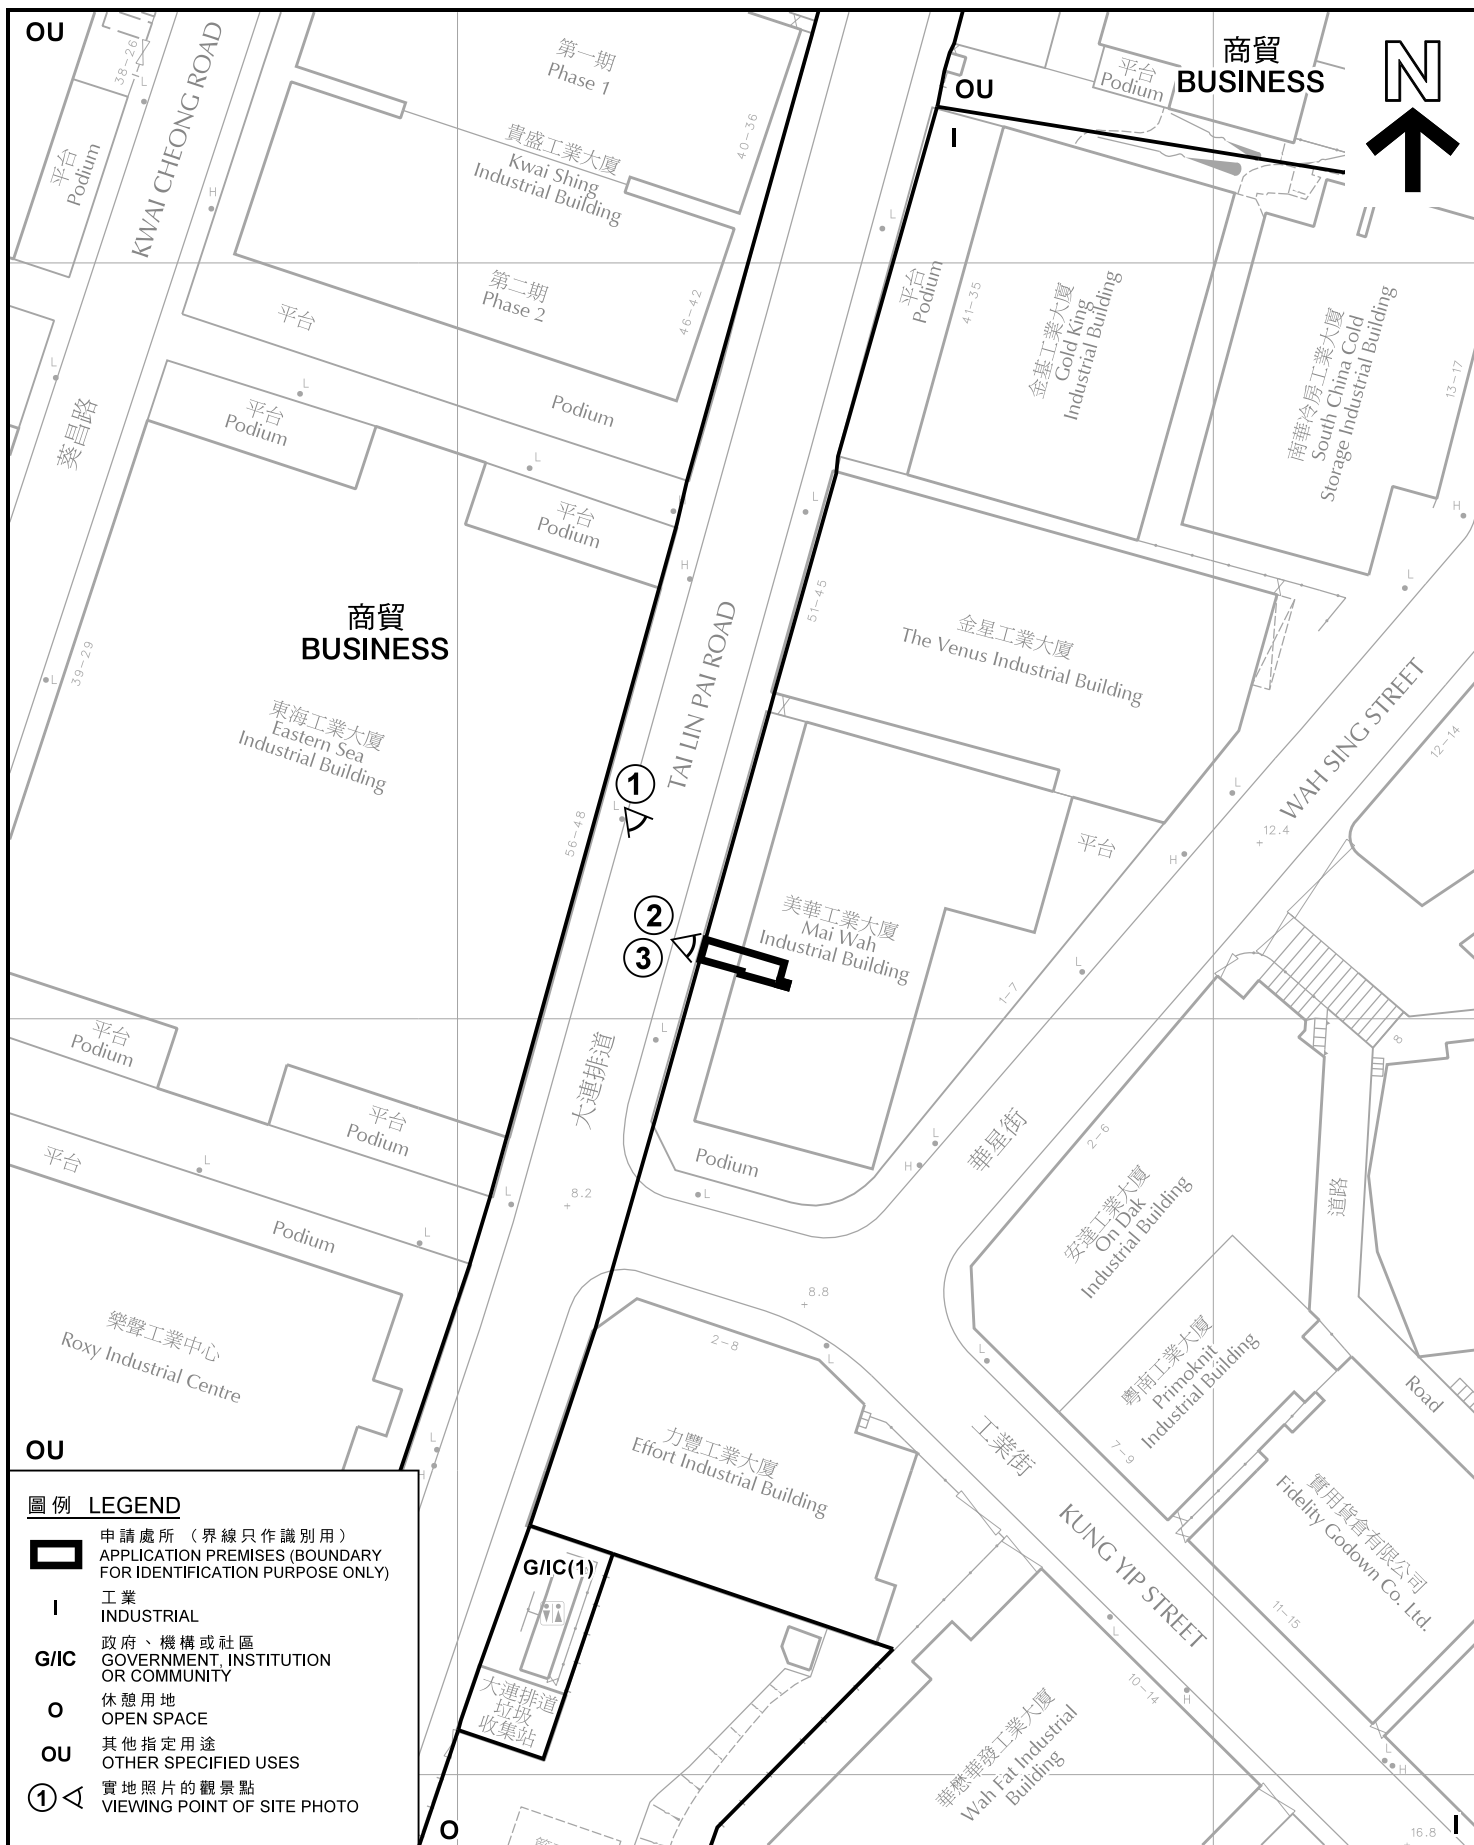

平面圖 SITE PLAN

商店及服務行業
葵涌華星街1-7號美華工業大廈地下B7號舖

SHOP AND SERVICES
SHOP B7, G/F, MAI WAH INDUSTRIAL BUILDING
1-7 WAH SING STREET, KWAI CHUNG

SCALE 1 : 1 000 比例尺

米 20 0 20 40 米 METRES

規劃署
PLANNING
DEPARTMENT



參考編號
REFERENCE No.
A/KC/462


圖 PLAN
A-2

圖例 LEGEND

-  申請處所 (界線只作識別用)
APPLICATION PREMISES (BOUNDARY FOR IDENTIFICATION PURPOSE ONLY)
-  工業
INDUSTRIAL
-  政府、機構或社區
GOVERNMENT, INSTITUTION OR COMMUNITY
-  休憩用地
OPEN SPACE
-  其他指定用途
OTHER SPECIFIED USES
-  實地照片的觀景點
VIEWING POINT OF SITE PHOTO

本摘要圖於2019年6月25日擬備，所根據的資料為測量圖編號 7-SW-22A

EXTRACT PLAN PREPARED ON 25.6.2019
BASED ON SURVEY SHEET No.
7-SW-22A

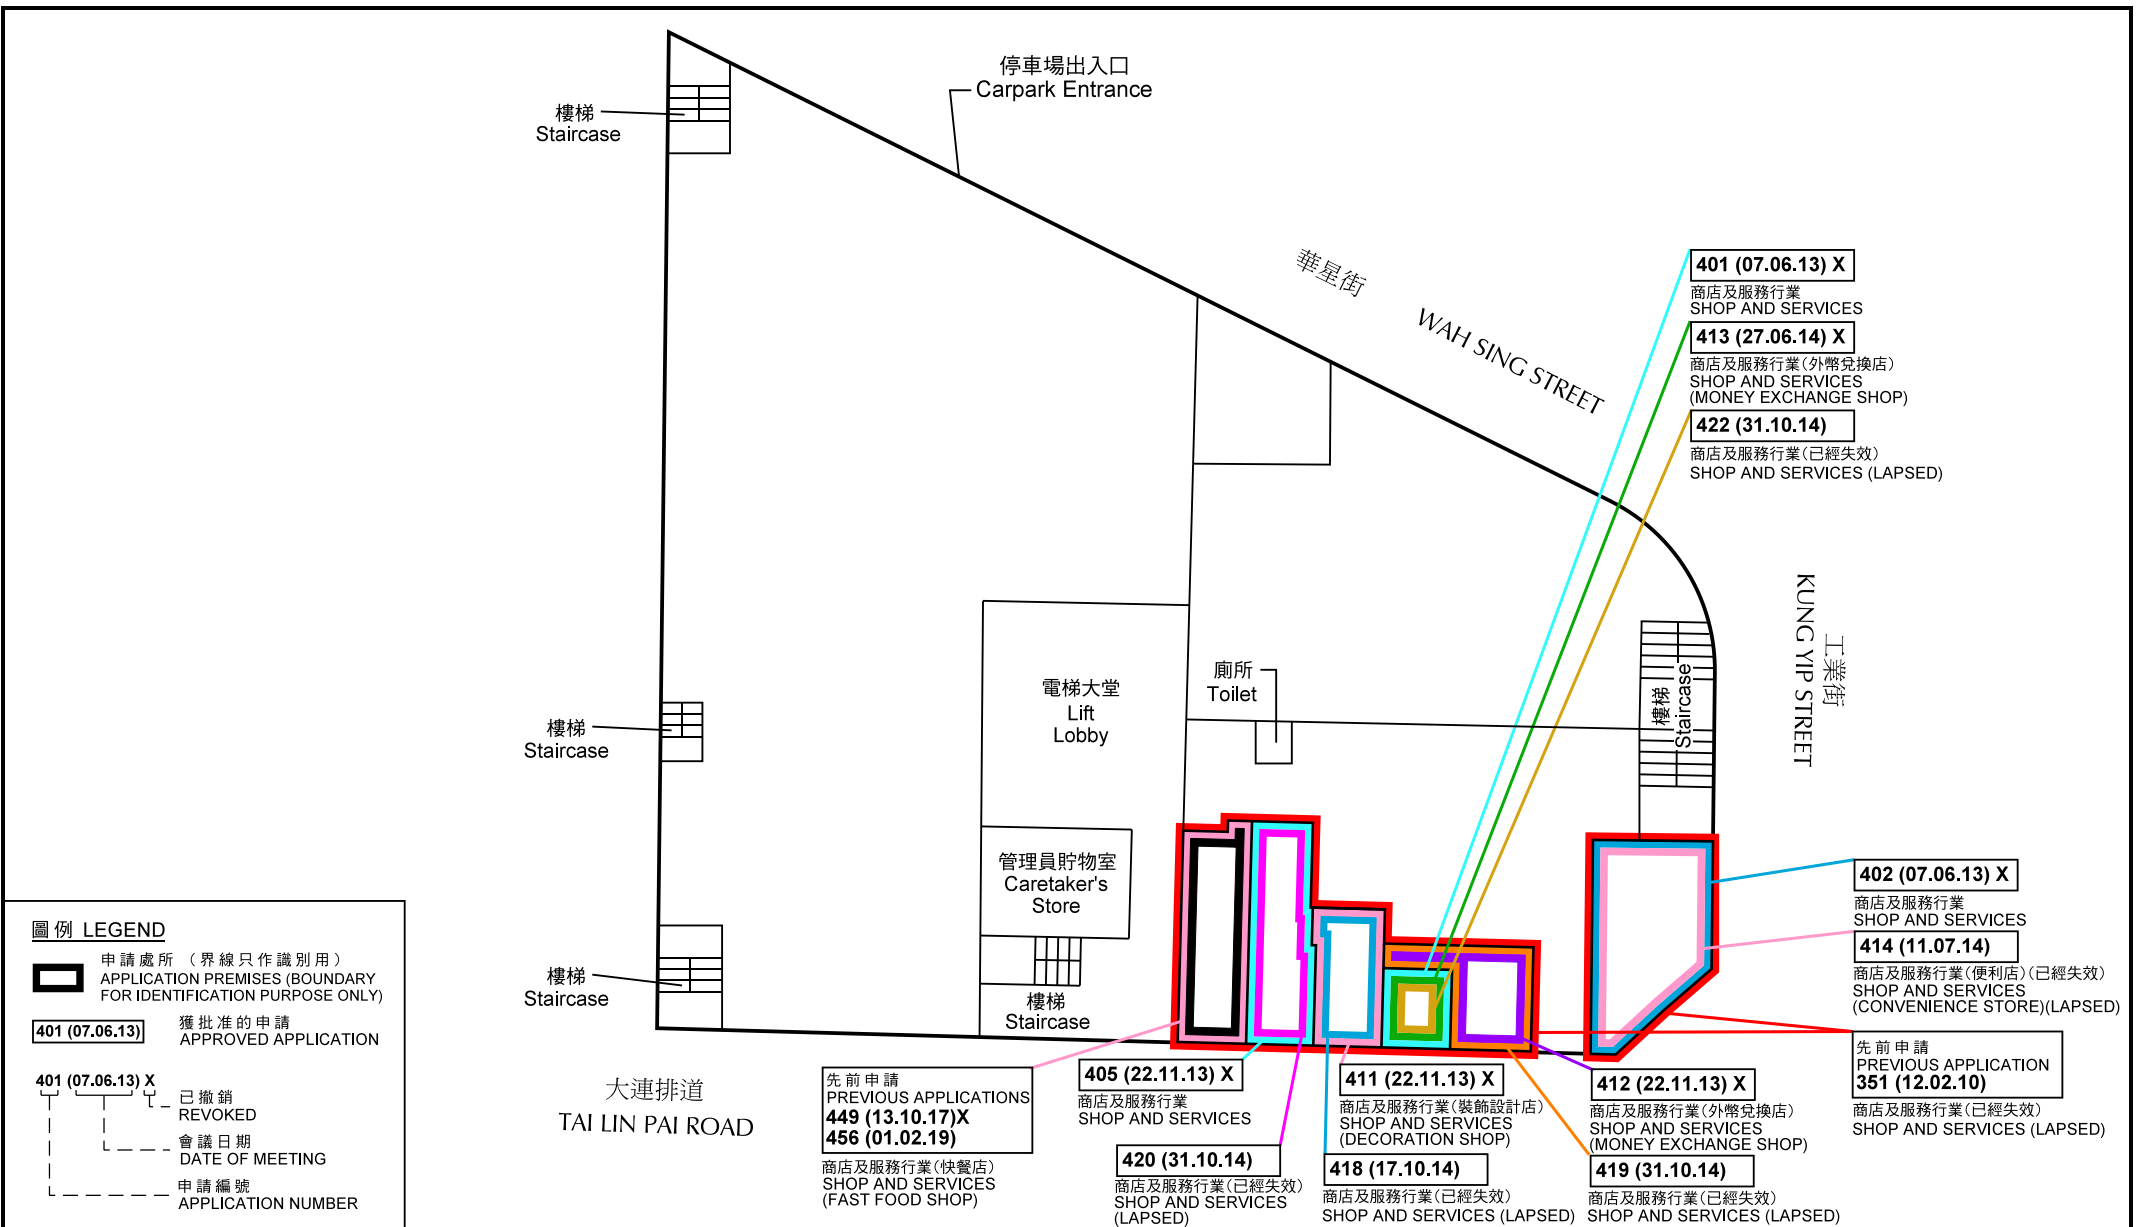

美華工業大廈地下有關申請位置圖
LOCATION PLAN OF APPLICATIONS ON GROUND FLOOR, MAI WAH INDUSTRIAL BUILDING

商店及服務行業
葵涌華星街1-7號美華工業大廈地下B7號舖
SHOP AND SERVICES
SHOP B7, G/F, MAI WAH INDUSTRIAL BUILDING
1-7 WAH SING STREET, KWAI CHUNG

(不按照比例 NOT TO SCALE)

規劃署
PLANNING
DEPARTMENT




參考編號
REFERENCE No.
A/KC/462

圖 PLAN
A-3

本圖於2019年6月18日擬備
PLAN PREPARED ON 18.6.2019



圖例 LEGEND

 申請處所 (界線只作識別用)
APPLICATION PREMISES
(BOUNDARY FOR IDENTIFICATION
PURPOSE ONLY)

本圖於2019年6月25日擬備，所根據的資料為攝於2019年6月24日的實地照片
PLAN PREPARED ON 25.6.2019
BASED ON SITE PHOTOS TAKEN ON 24.6.2019

實地照片 SITE PHOTO

商店及服務行業
葵涌華星街1-7號美華工業大廈地下B7號舖
SHOP AND SERVICES
SHOP B7, G/F, MAI WAH INDUSTRIAL BUILDING
1-7 WAH SING STREET, KWAI CHUNG

規劃署
PLANNING
DEPARTMENT



參考編號
REFERENCE No.
A/KC/462

圖 PLAN
A-4