


## **Appendix I**

Schematic Architectural Drawings

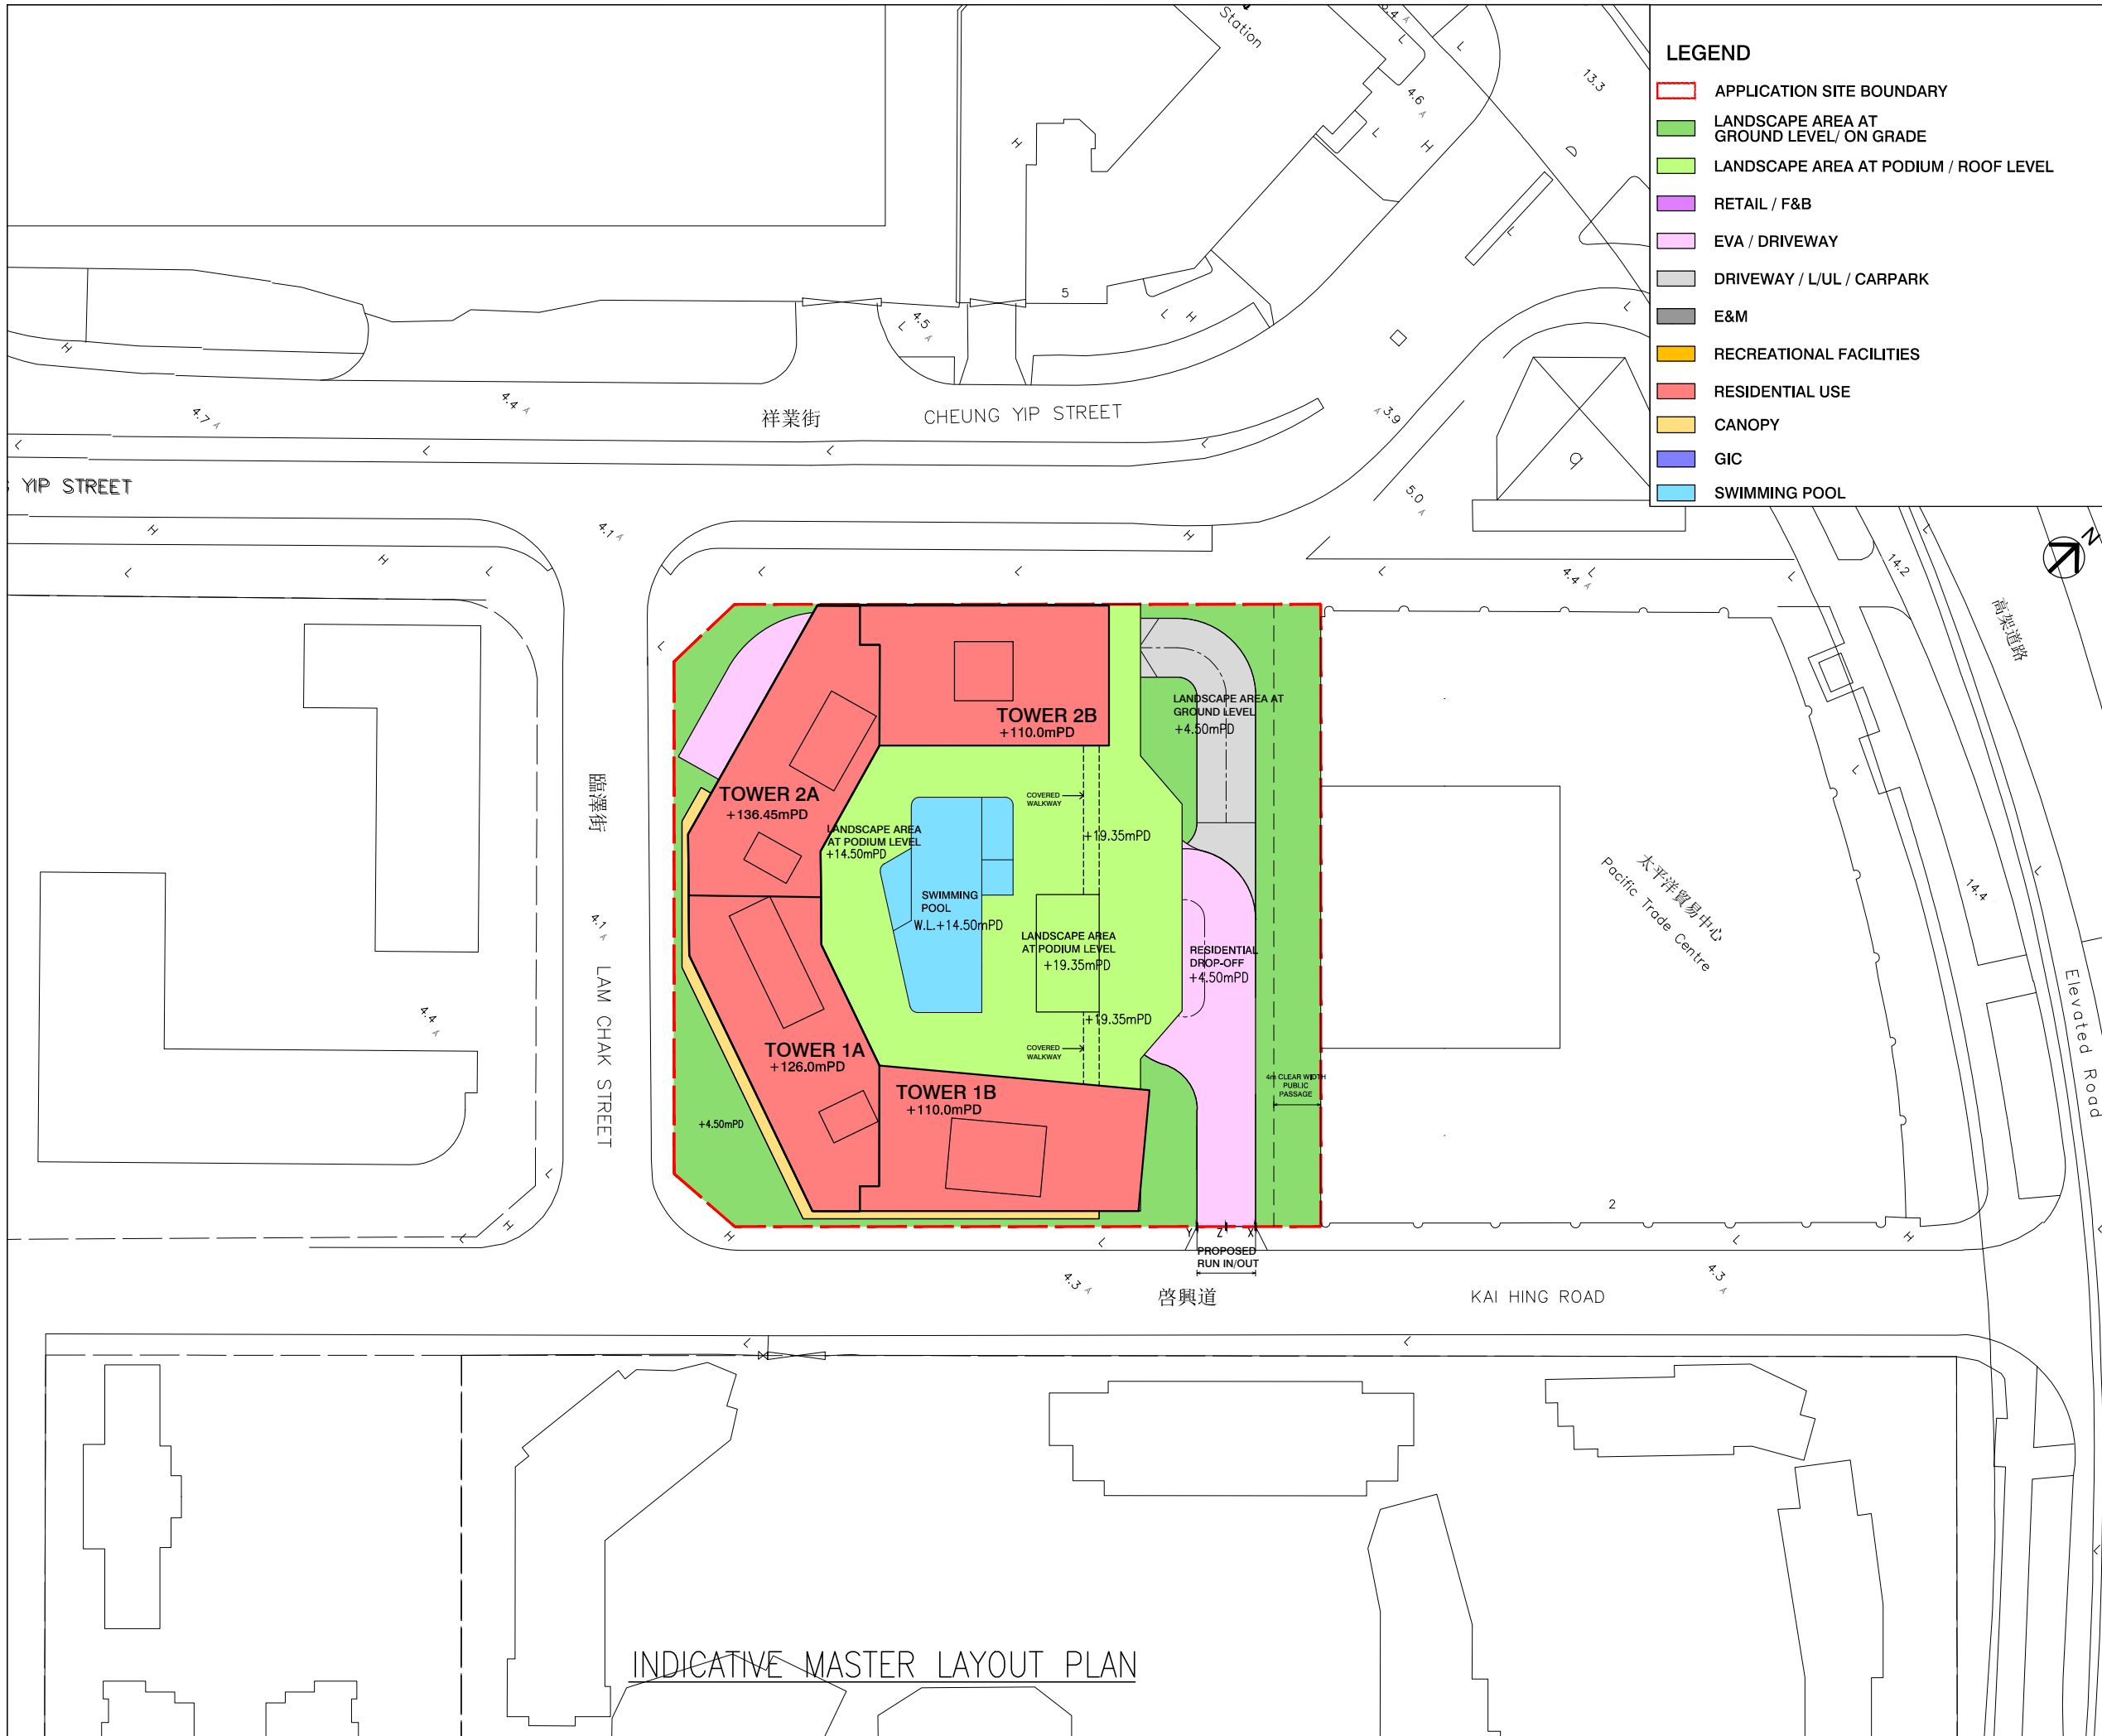

**LEGEND**

- APPLICATION SITE BOUNDARY
- LANDSCAPE AREA AT GROUND LEVEL/ ON GRADE
- LANDSCAPE AREA AT PODIUM / ROOF LEVEL
- RETAIL / F&B
- EVA / DRIVEWAY
- DRIVEWAY / L/UL / CARPARK
- E&M
- RECREATIONAL FACILITIES
- RESIDENTIAL USE
- CANOPY
- GIC
- SWIMMING POOL

B.D. REFERENCE	屋宇署檔案
F.S.D. REFERENCE	消防處檔案
W.W.O. REFERENCE	水務署檔案
CAD FILE NAME	檔案編號

NOTES				注釋
NO. 修定號	REVISIONS 修定內容	DATE 日期	BY 經手人	

**DLN**

**DLN Architects Limited**  
 劉榮廣伍振民建築師有限公司  
 46-47 Floor, Tower One, Times Square  
 Matheson Street, Causeway Bay, Hong Kong  
 香港銅鑼灣勿地臣街  
 時代廣場一座46至47樓  
 t +852 2695 6888 1 +852 2576 4074 email general@dln.com.hk www.dln.com.hk


ALL MEASUREMENTS MUST BE CHECKED AT THE WORK BY THE CONTRACTOR  
 所有尺寸應由承建商於工地核實  
 DO NOT SCALE FROM DRAWINGS 尺寸不應由圖紙直接量度  
 ALL PRINTS, SPECIFICATIONS AND THEIR COPYRIGHT ARE THE PROPERTY OF  
 THE ARCHITECT AND SHALL BE RETURNED AT THE COMPLETION OF THE WORK  
 所有印刷、規格說明及所有的版權屬於建築師及應在工程完結後歸還建築師

PROJECT	項目名稱
PROPOSED COMPOSITE DEVELOPMENT AT 8 LAM CHAK STREET, KOWLOON - N.K.I.L. 6215	

TITLE	標題
INDICATIVE MASTER LAYOUT PLAN	

SCALE	比例	DATE	日期
1:800(A3)		MAY 2026	
DRAWN BY	製作人	CHECKED BY	檢查
DT		-	
JOB NO.	工程項目	DRAWING NO.	圖號
N3591-H		-	

INDICATIVE MASTER LAYOUT PLAN

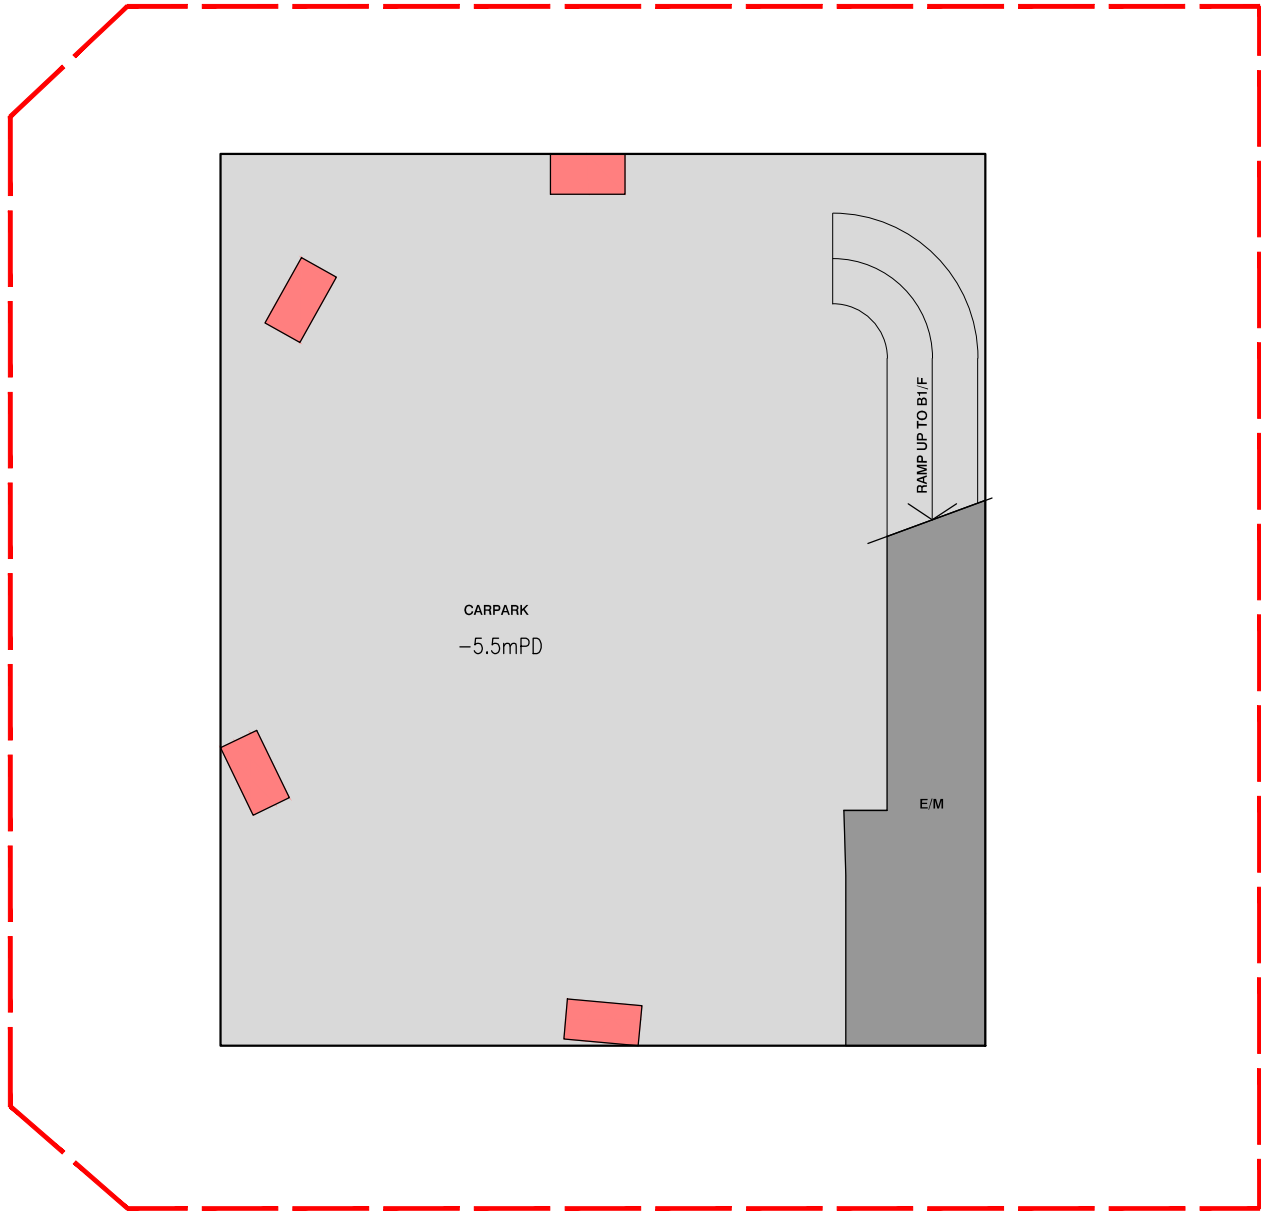

INDICATIVE BASEMENT 2 FLOOR PLAN

**LEGEND**

- APPLICATION SITE BOUNDARY
- LANDSCAPE AREA AT GROUND LEVEL/ ON GRADE
- LANDSCAPE AREA AT PODIUM / ROOF LEVEL
- RETAIL / F&B
- EVA / DRIVEWAY
- DRIVEWAY / L/UL / CARPARK
- E&M
- RECREATIONAL FACILITIES
- RESIDENTIAL USE
- CANOPY
- GIC
- SWIMMING POOL



B.D. REFERENCE	屋宇署檔案
F.S.D. REFERENCE	消防處檔案
W.W.O. REFERENCE	水務署檔案
CAD FILE NAME	檔案編號

NOTES 注釋

NO. 修定號	REVISIONS 修定內容	DATE 日期	BY 經手人

**DLN Architects Limited**  
 劉榮廣伍振民建築師有限公司  
 46-47 Floor, Tower One, Times Square  
 Matheson Street, Causeway Bay, Hong Kong  
 香港銅鑼灣勿地臣街  
 時代廣場一座46至47樓  
 t +852 2695 6888 1 +852 2576 4074 email general@dln.com.hk www.dln.com.hk

ALL MEASUREMENTS MUST BE CHECKED AT THE WORK BY THE CONTRACTOR  
 所有尺寸應由承建商於工地核實  
 DO NOT SCALE FROM DRAWINGS 尺寸不應由圖紙直接量度  
 ALL PRINTS, SPECIFICATIONS AND THEIR COPYRIGHT ARE THE PROPERTY OF  
 THE ARCHITECT AND SHALL BE RETURNED AT THE COMPLETION OF THE WORK  
 所有印刷、規格說明及所有的版權屬於建築師及應在工程完結後歸還建築師


PROJECT 項目名稱  
  
**PROPOSED COMPOSITE DEVELOPMENT  
 AT 8 LAM CHAK STREET, KOWLOON  
 - N.K.I.L. 6215**

TITLE 標題  
  
**INDICATIVE BASEMENT 2 FLOOR PLAN**

SCALE 比例 DATE 日期  
**1:500(A3) MAY 2026**

DRAWN BY 製作人 CHECKED BY 檢查  
**DT -**

JOB NO. 工程項目 DRAWING NO. 圖號  
**N3591-H -**

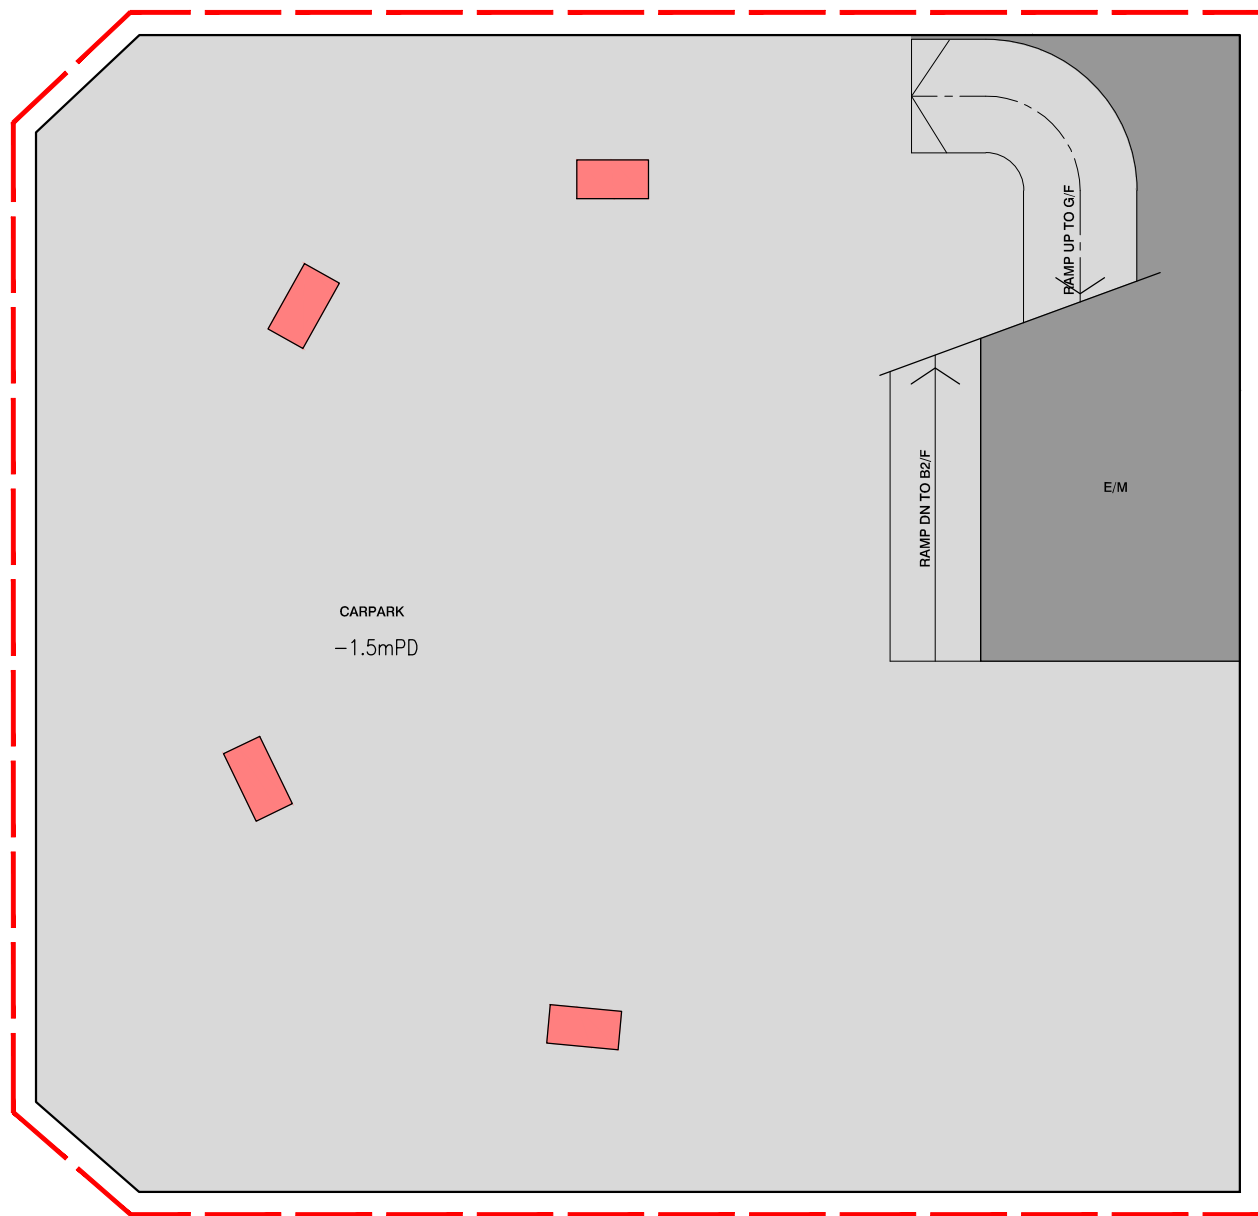

INDICATIVE BASEMENT 1 FLOOR PLAN

**LEGEND**

- APPLICATION SITE BOUNDARY
- LANDSCAPE AREA AT GROUND LEVEL/ ON GRADE
- LANDSCAPE AREA AT PODIUM / ROOF LEVEL
- RETAIL / F&B
- EVA / DRIVEWAY
- DRIVEWAY / L/UL / CARPARK
- E&M
- RECREATIONAL FACILITIES
- RESIDENTIAL USE
- CANOPY
- GIC
- SWIMMING POOL



B.D. REFERENCE	屋宇署檔案
F.S.D. REFERENCE	消防處檔案
W.W.O. REFERENCE	水務署檔案
CAD FILE NAME	檔案編號

NOTES 注釋

NO. 修定號	REVISIONS 修定內容	DATE 日期	BY 經手人




**DLN Architects Limited** 46-47 Floor, Tower One, Times Square  
 劉榮廣伍振民建築師有限公司 Matheson Street, Causeway Bay, Hong Kong  
 香港銅鑼灣勿地臣街 時代廣場一座46至47樓  
 t +852 2695 6888 1 +852 2576 4074 email general@dln.com.hk www.dln.com.hk

ALL MEASUREMENTS MUST BE CHECKED AT THE WORK BY THE CONTRACTOR  
 所有尺寸應由承建商於工地核實  
 DO NOT SCALE FROM DRAWINGS. 尺寸不應由圖紙直接量度  
 ALL PRINTS, SPECIFICATIONS AND THEIR COPYRIGHT ARE THE PROPERTY OF  
 THE ARCHITECT AND SHALL BE RETURNED AT THE COMPLETION OF THE WORK  
 所有印刷、規格說明及所有的版權屬於建築師及應在工程完結後歸還建築師

PROJECT	項目名稱
PROPOSED COMPOSITE DEVELOPMENT AT 8 LAM CHAK STREET, KOWLOON - N.K.I.L. 6215	

TITLE	標題
INDICATIVE BASEMENT 1 FLOOR PLAN	

SCALE	比例	DATE	日期
1:500(A3)		MAY 2026	
DRAWN BY	製作人	CHECKED BY	檢查
DT		-	
JOB NO.	工程項目	DRAWING NO.	圖號
N3591-H		-	

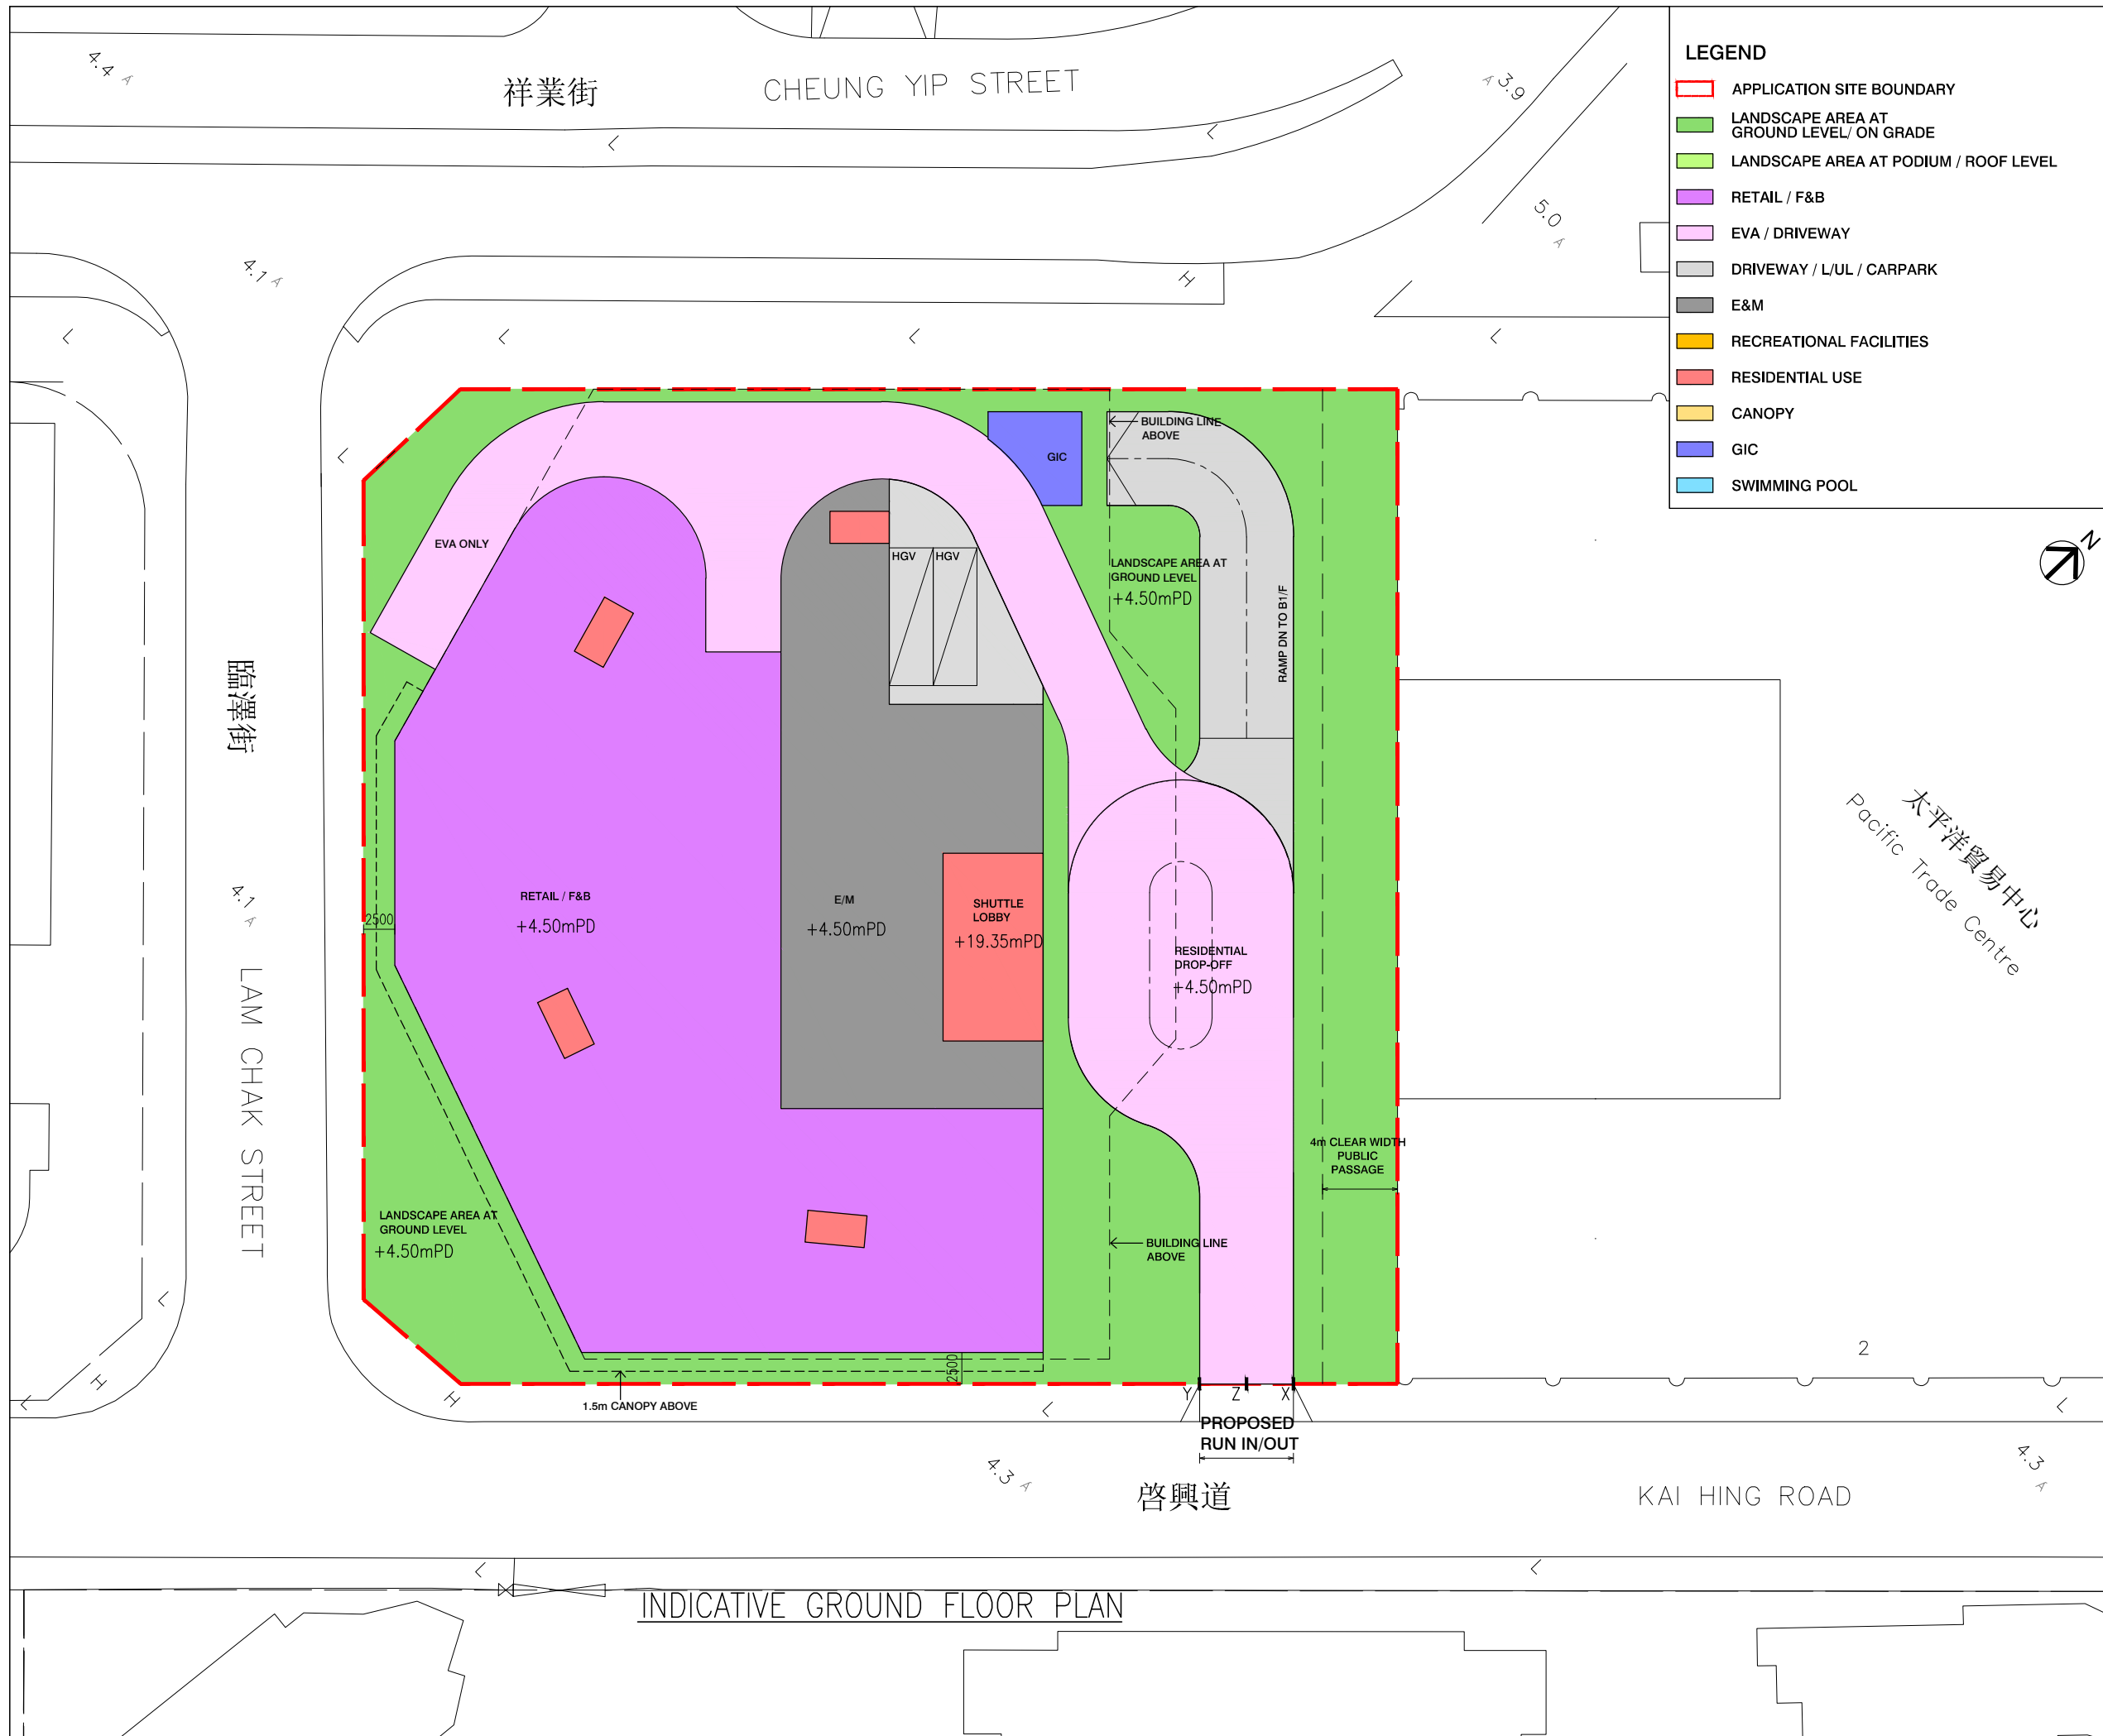

B.D. REFERENCE	屋宇署檔案
F.S.D. REFERENCE	消防處檔案
W.W.O. REFERENCE	水務署檔案
CAD FILE NAME	檔案編號

NOTES				注釋
NO.	REVISIONS	DATE	BY	
修定號	修定內容	日期	經手人	

**DLN**

**DLN Architects Limited**  
劉榮廣伍振民建築師有限公司

46-47 Floor, Tower One, Times Square  
Matheson Street, Causeway Bay, Hong Kong  
香港銅鑼灣勿地臣街  
時代廣場一座46至47樓


t +852 2695 6888 1 +852 2576 4074 email general@dln.com.hk www.dln.com.hk

ALL MEASUREMENTS MUST BE CHECKED AT THE WORK BY THE CONTRACTOR  
所有尺寸應由承建商於工地核實  
DO NOT SCALE FROM DRAWINGS 尺寸不應由圖紙直接量度  
ALL PRINTS, SPECIFICATIONS AND THEIR COPYRIGHT ARE THE PROPERTY OF THE ARCHITECT AND SHALL BE RETURNED AT THE COMPLETION OF THE WORK  
所有印刷、規格說明及所有的版權屬於建築師及應在工程完結後歸還建築師

PROJECT	項目名稱
PROPOSED COMPOSITE DEVELOPMENT AT 8 LAM CHAK STREET, KOWLOON - N.K.I.L. 6215	

TITLE	標題
INDICATIVE GROUND FLOOR PLAN	

SCALE	比例	DATE	日期
1:500(A3)		MAY 2026	
DRAWN BY	製作人	CHECKED BY	檢查
DT		-	
JOB NO.	工程項目	DRAWING NO.	圖號
N3591-H		-	

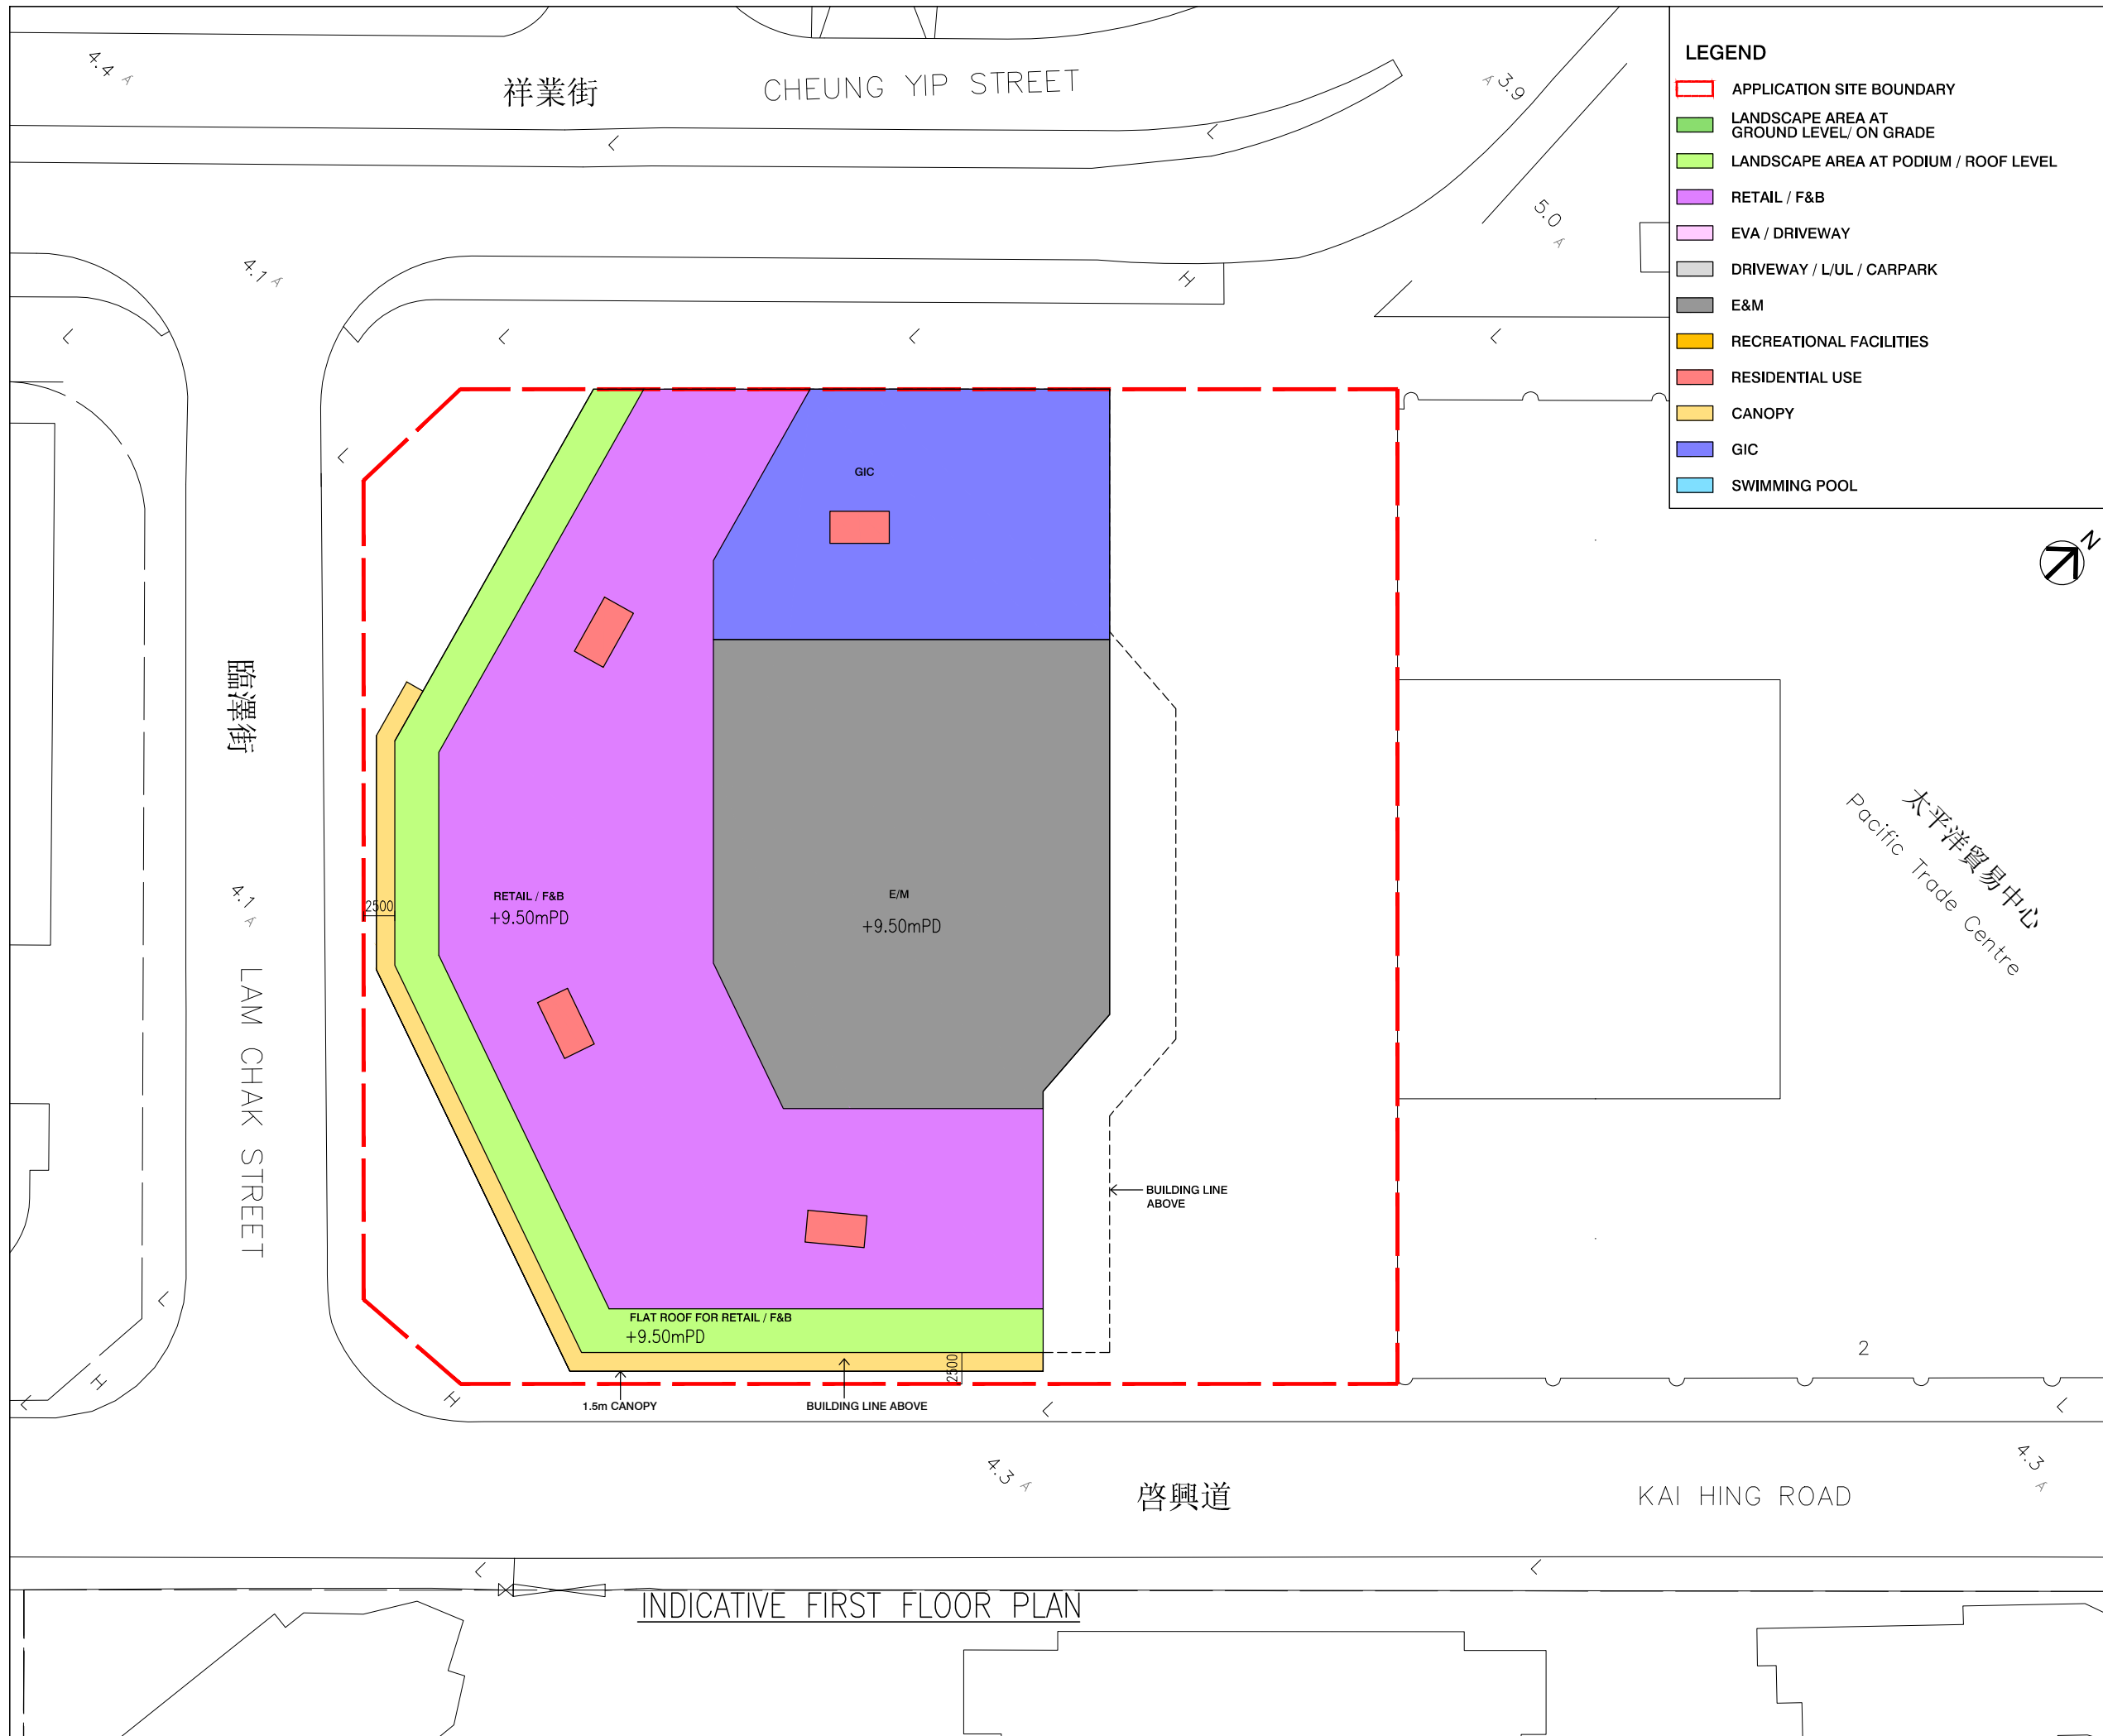

**LEGEND**

- APPLICATION SITE BOUNDARY
- LANDSCAPE AREA AT GROUND LEVEL/ ON GRADE
- LANDSCAPE AREA AT PODIUM / ROOF LEVEL
- RETAIL / F&B
- EVA / DRIVEWAY
- DRIVEWAY / L/UL / CARPARK
- E&M
- RECREATIONAL FACILITIES
- RESIDENTIAL USE
- CANOPY
- GIC
- SWIMMING POOL

B.D. REFERENCE	屋宇署檔案
F.S.D. REFERENCE	消防處檔案
W.W.O. REFERENCE	水務署檔案
CAD FILE NAME	檔案編號

NOTES				注釋
NO. 修定號	REVISIONS 修定內容	DATE 日期	BY 經手人	

# DLN

**DLN Architects Limited**  
 劉榮廣伍振民建築師有限公司

46-47 Floor, Tower One, Times Square  
 Matheson Street, Causeway Bay, Hong Kong  
 香港銅鑼灣勿地臣街  
 時代廣場一座46至47樓


t +852 2695 6888 1 +852 2576 4074 email general@dln.com.hk www.dln.com.hk

ALL MEASUREMENTS MUST BE CHECKED AT THE WORK BY THE CONTRACTOR  
 所有尺寸應由承建商於工地核實  
 DO NOT SCALE FROM DRAWINGS 尺寸不應由圖紙直接量度  
 ALL PRINTS, SPECIFICATIONS AND THEIR COPYRIGHT ARE THE PROPERTY OF  
 THE ARCHITECT AND SHALL BE RETURNED AT THE COMPLETION OF THE WORK  
 所有印刷、規格說明及所有的版權屬於建築師及應在工程完結後歸還建築師

PROJECT	項目名稱
<b>PROPOSED COMPOSITE DEVELOPMENT          AT 8 LAM CHAK STREET, KOWLOON          - N.K.I.L. 6215</b>	

TITLE		標題
INDICATIVE FIRST FLOOR PLAN		
SCALE	比例	DATE
1:500(A3)		MAY 2026
DRAWN BY	製作人	CHECKED BY
DT		-
JOB NO.	工程項目	DRAWING NO.
N3591-H		-

INDICATIVE FIRST FLOOR PLAN

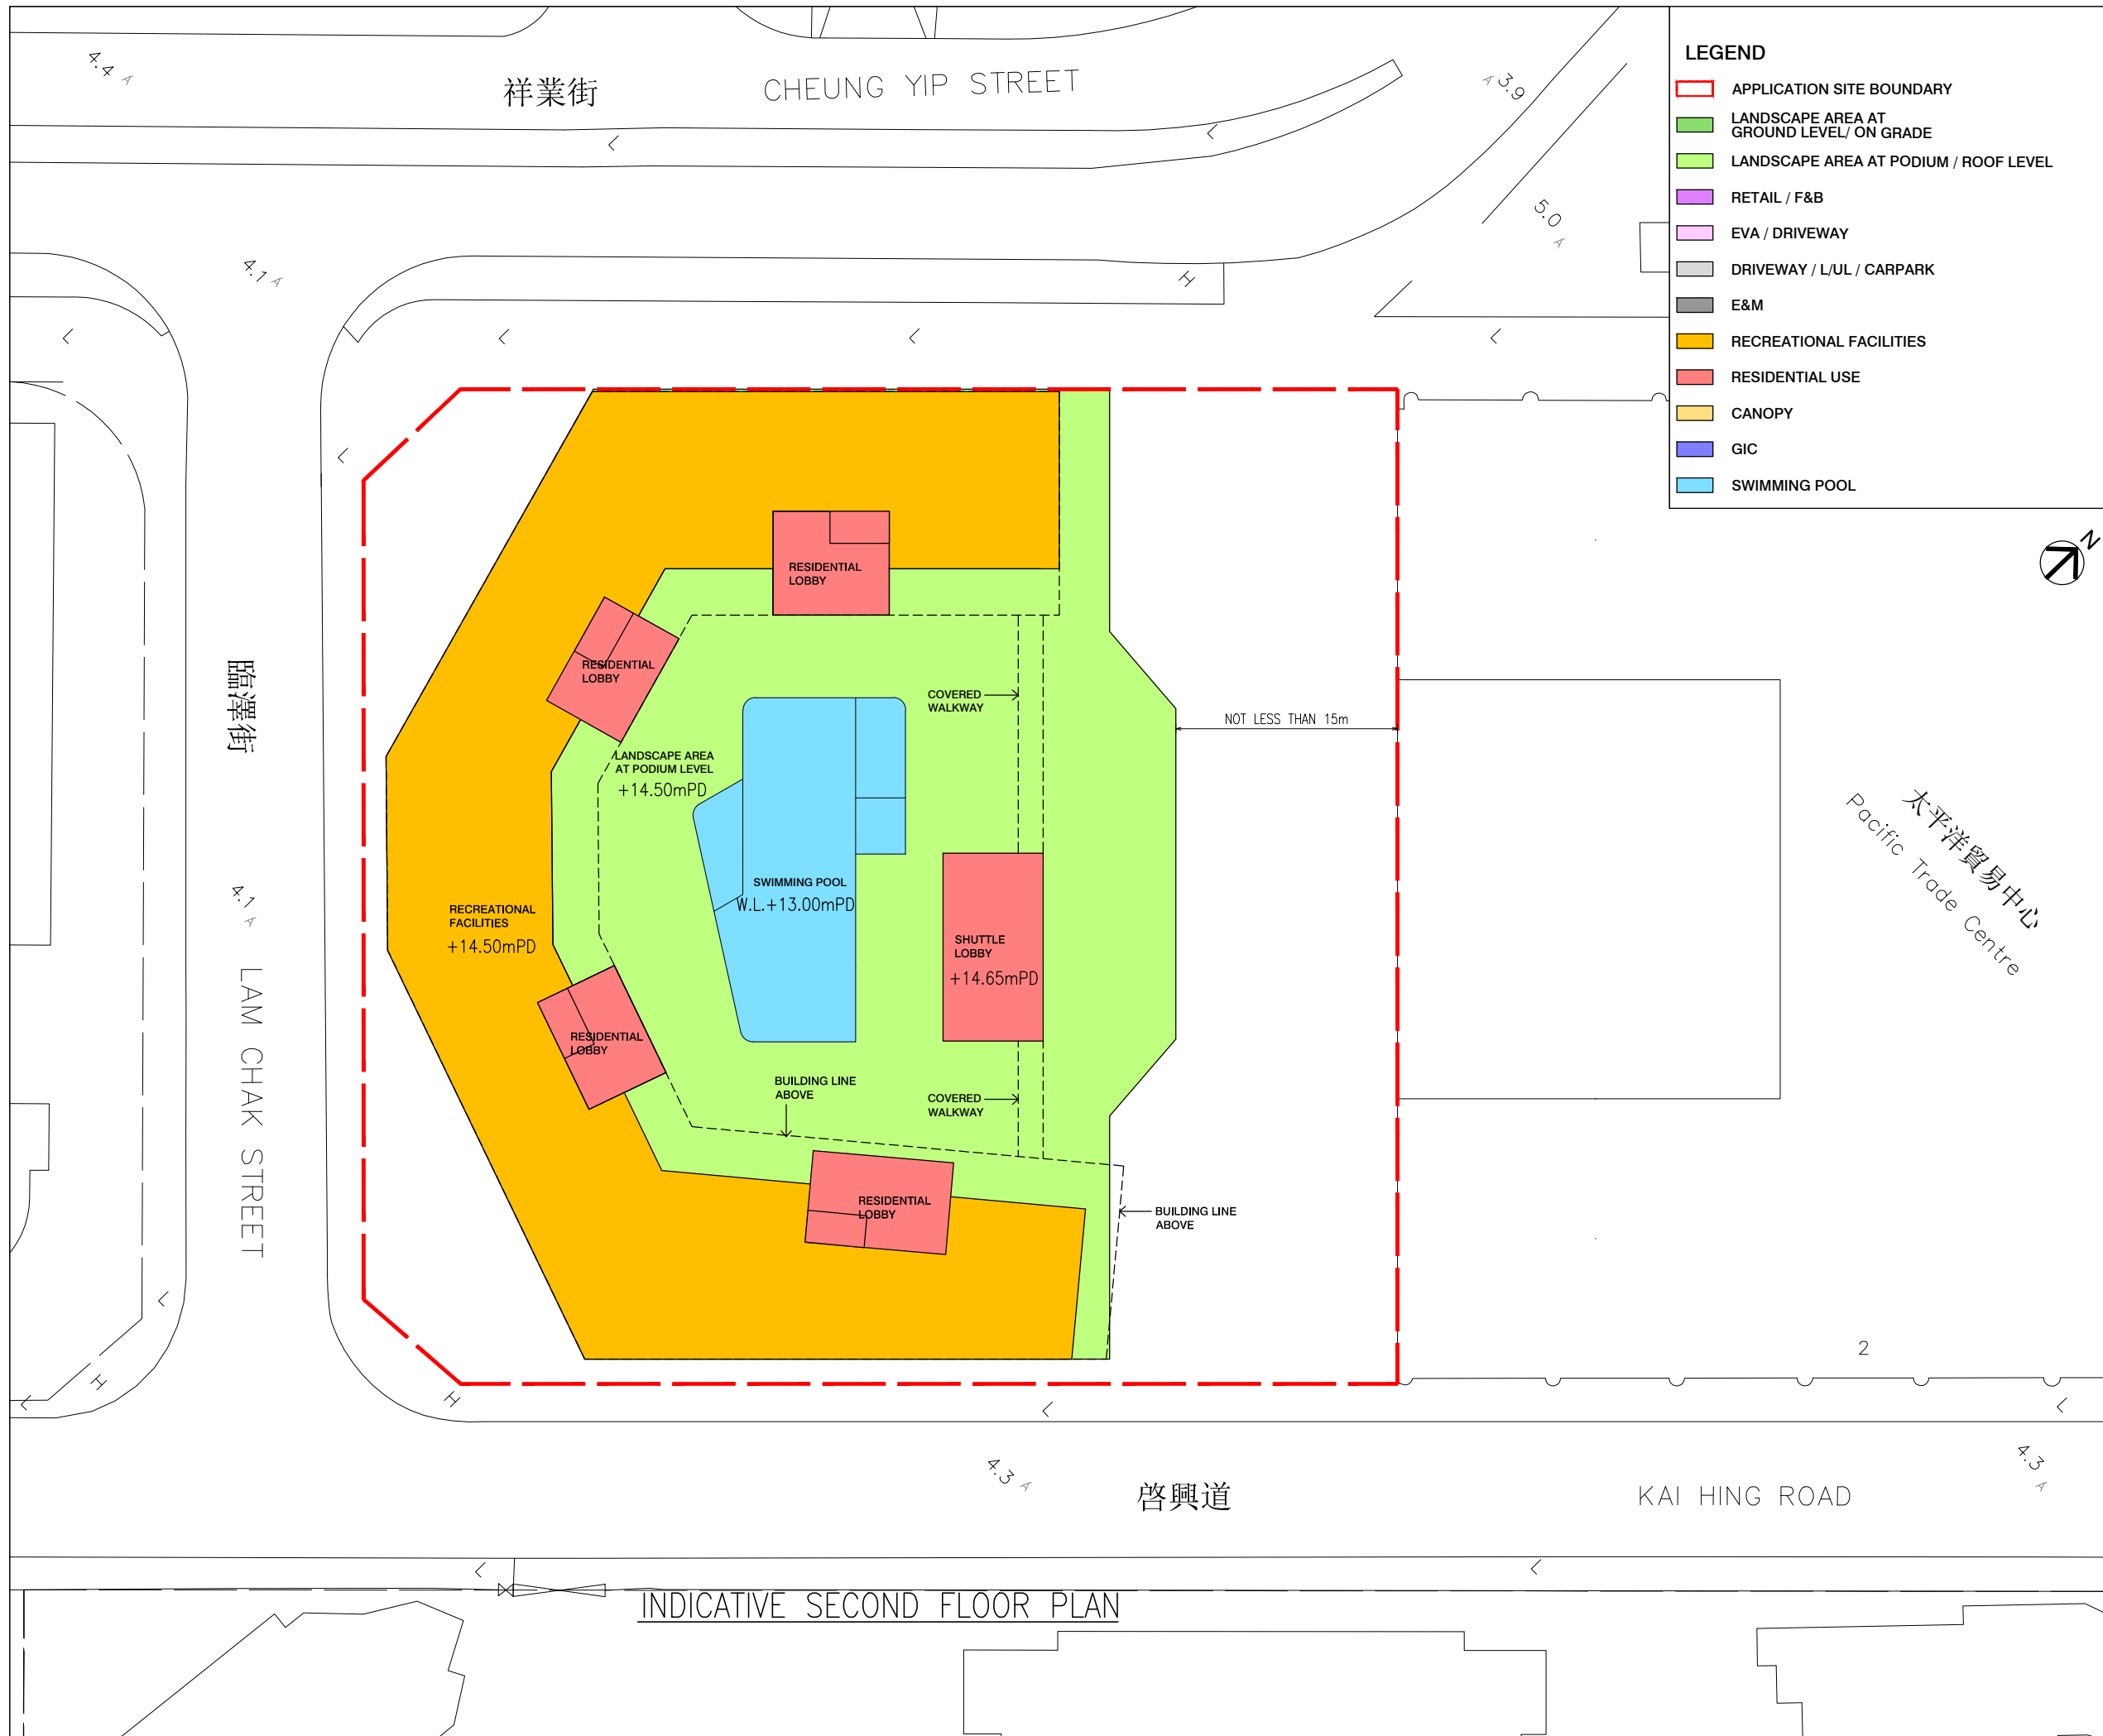

**LEGEND**

- APPLICATION SITE BOUNDARY
- LANDSCAPE AREA AT GROUND LEVEL/ ON GRADE
- LANDSCAPE AREA AT PODIUM / ROOF LEVEL
- RETAIL / F&B
- EVA / DRIVEWAY
- DRIVEWAY / L/UL / CARPARK
- E&M
- RECREATIONAL FACILITIES
- RESIDENTIAL USE
- CANOPY
- GIC
- SWIMMING POOL

B.D. REFERENCE	屋宇署檔案
F.S.D. REFERENCE	消防處檔案
W.W.O. REFERENCE	水務署檔案
CAD FILE NAME	檔案編號

NOTES				注釋
NO.	REVISIONS	DATE	BY	經手人
	修定內容	日期		

# DLN

**DLN Architects Limited**  
 劉榮廣伍振民建築師有限公司

46-47 Floor, Tower One, Times Square  
 Matheson Street, Causeway Bay, Hong Kong  
 香港銅鑼灣勿地臣街  
 時代廣場一座46至47樓


t +852 2895 6888 1 +852 2576 4074 email general@dln.com.hk www.dln.com.hk

ALL MEASUREMENTS MUST BE CHECKED AT THE WORK BY THE CONTRACTOR  
 所有尺寸應由承建商於工地核實  
 DO NOT SCALE FROM DRAWINGS 尺寸不應由圖紙直接量度  
 ALL PRINTS, SPECIFICATIONS AND THEIR COPYRIGHT ARE THE PROPERTY OF  
 THE ARCHITECT AND SHALL BE RETURNED AT THE COMPLETION OF THE WORK  
 所有印刷、規格說明及所有的版權屬於建築師及應在工程完結後歸還建築師

PROJECT	項目名稱
<b>PROPOSED COMPOSITE DEVELOPMENT          AT 8 LAM CHAK STREET, KOWLOON          - N.K.I.L. 6215</b>	

TITLE	標題
<b>INDICATIVE SECOND FLOOR PLAN</b>	

SCALE	比例	DATE	日期
1:500(A3)		MAY 2026	
DRAWN BY	製作人	CHECKED BY	檢查
DT		-	
JOB NO.	工程項目	DRAWING NO.	圖號
N3591-H		-	

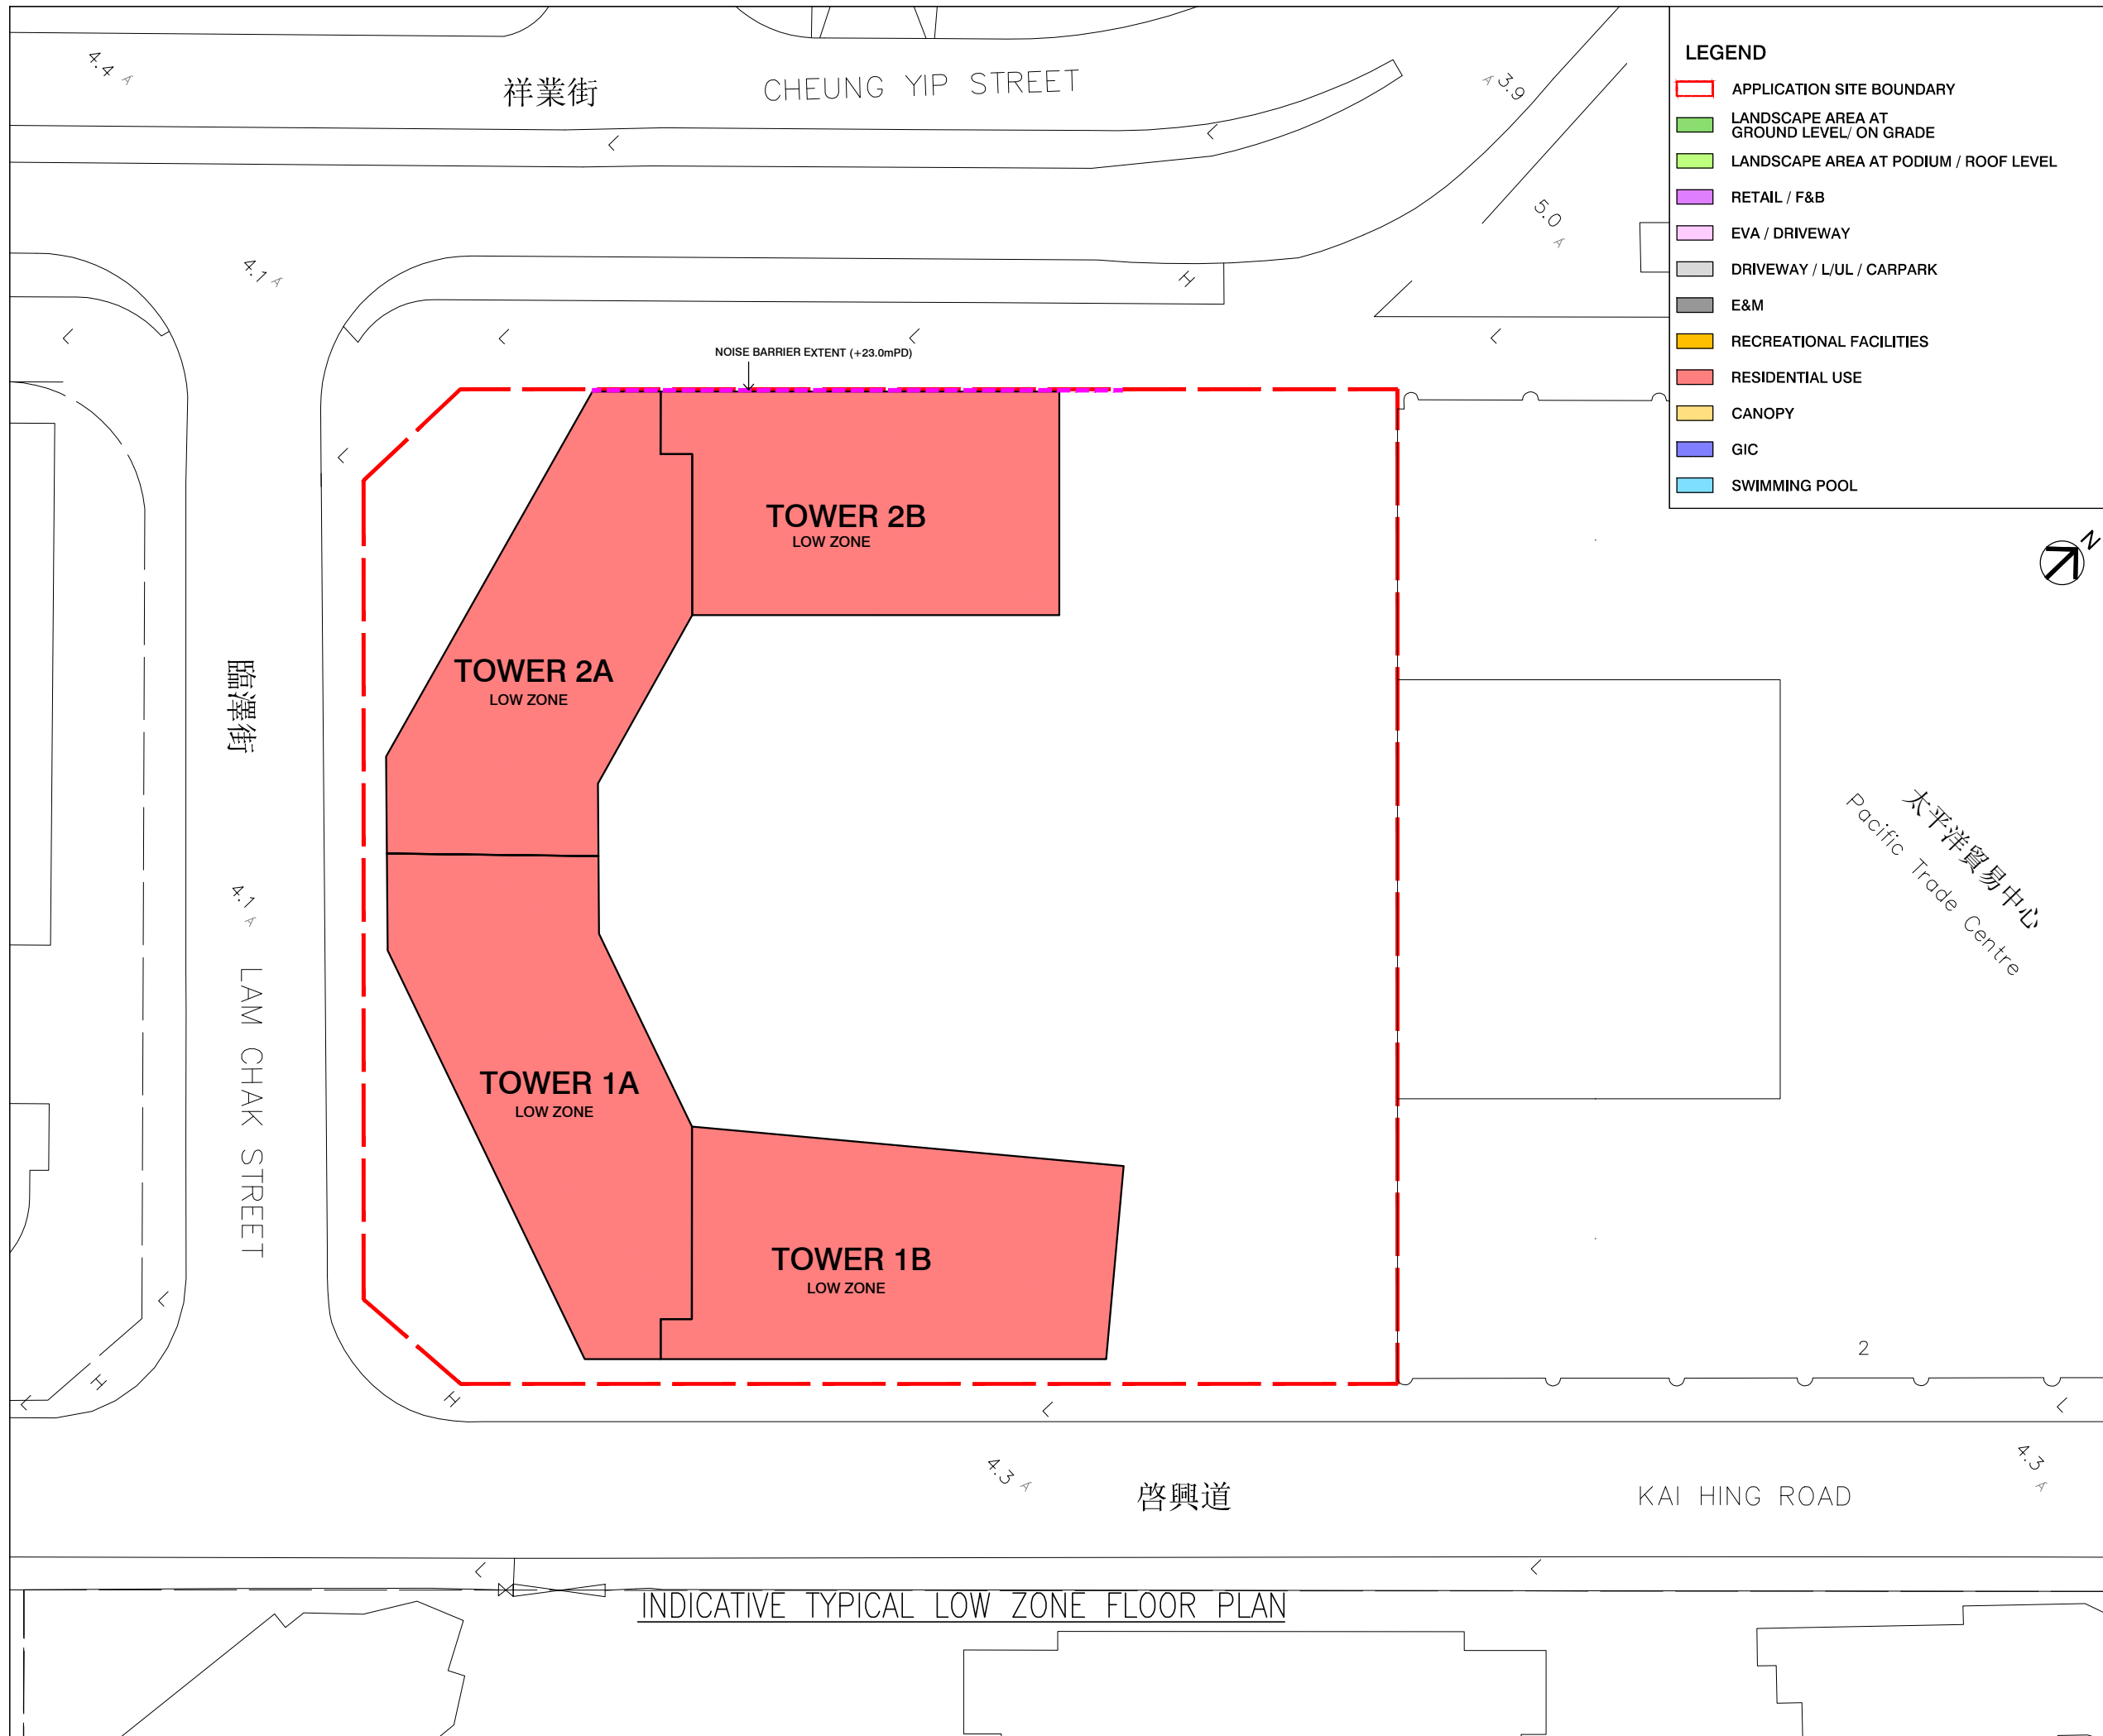

B.D. REFERENCE	屋宇署檔案
F.S.D. REFERENCE	消防處檔案
W.W.O. REFERENCE	水務署檔案
CAD FILE NAME	檔案編號

NOTES				注釋
NO.	REVISIONS	DATE	BY	
修定號	修定內容	日期	經手人	

**DLN**


**DLN Architects Limited**  
 劉榮廣伍振民建築師有限公司  
 46-47 Floor, Tower One, Times Square  
 Matheson Street, Causeway Bay, Hong Kong  
 香港銅鑼灣勿地臣街  
 時代廣場一座46至47樓  
 t +852 2895 6888 f +852 2576 4074 email general@dln.com.hk www.dln.com.hk

ALL MEASUREMENTS MUST BE CHECKED AT THE WORK BY THE CONTRACTOR  
 所有尺寸應由承建商於工地核實  
 DO NOT SCALE FROM DRAWINGS 尺寸不應由圖紙直接量度  
 ALL PRINTS, SPECIFICATIONS AND THEIR COPYRIGHT ARE THE PROPERTY OF THE ARCHITECT AND SHALL BE RETURNED AT THE COMPLETION OF THE WORK  
 所有印刷、規格說明及所有的版權屬於建築師及應在工程完結後歸還建築師

PROJECT	項目名稱
PROPOSED COMPOSITE DEVELOPMENT AT 8 LAM CHAK STREET, KOWLOON - N.K.I.L. 6215	

TITLE	標題
INDICATIVE LOW ZONE FLOOR PLAN	

SCALE	比例	DATE	日期
1:500(A3)		MAY 2026	
DRAWN BY	製作人	CHECKED BY	檢查
DT		-	
JOB NO.	工程項目	DRAWING NO.	圖號
N3591-H		-	

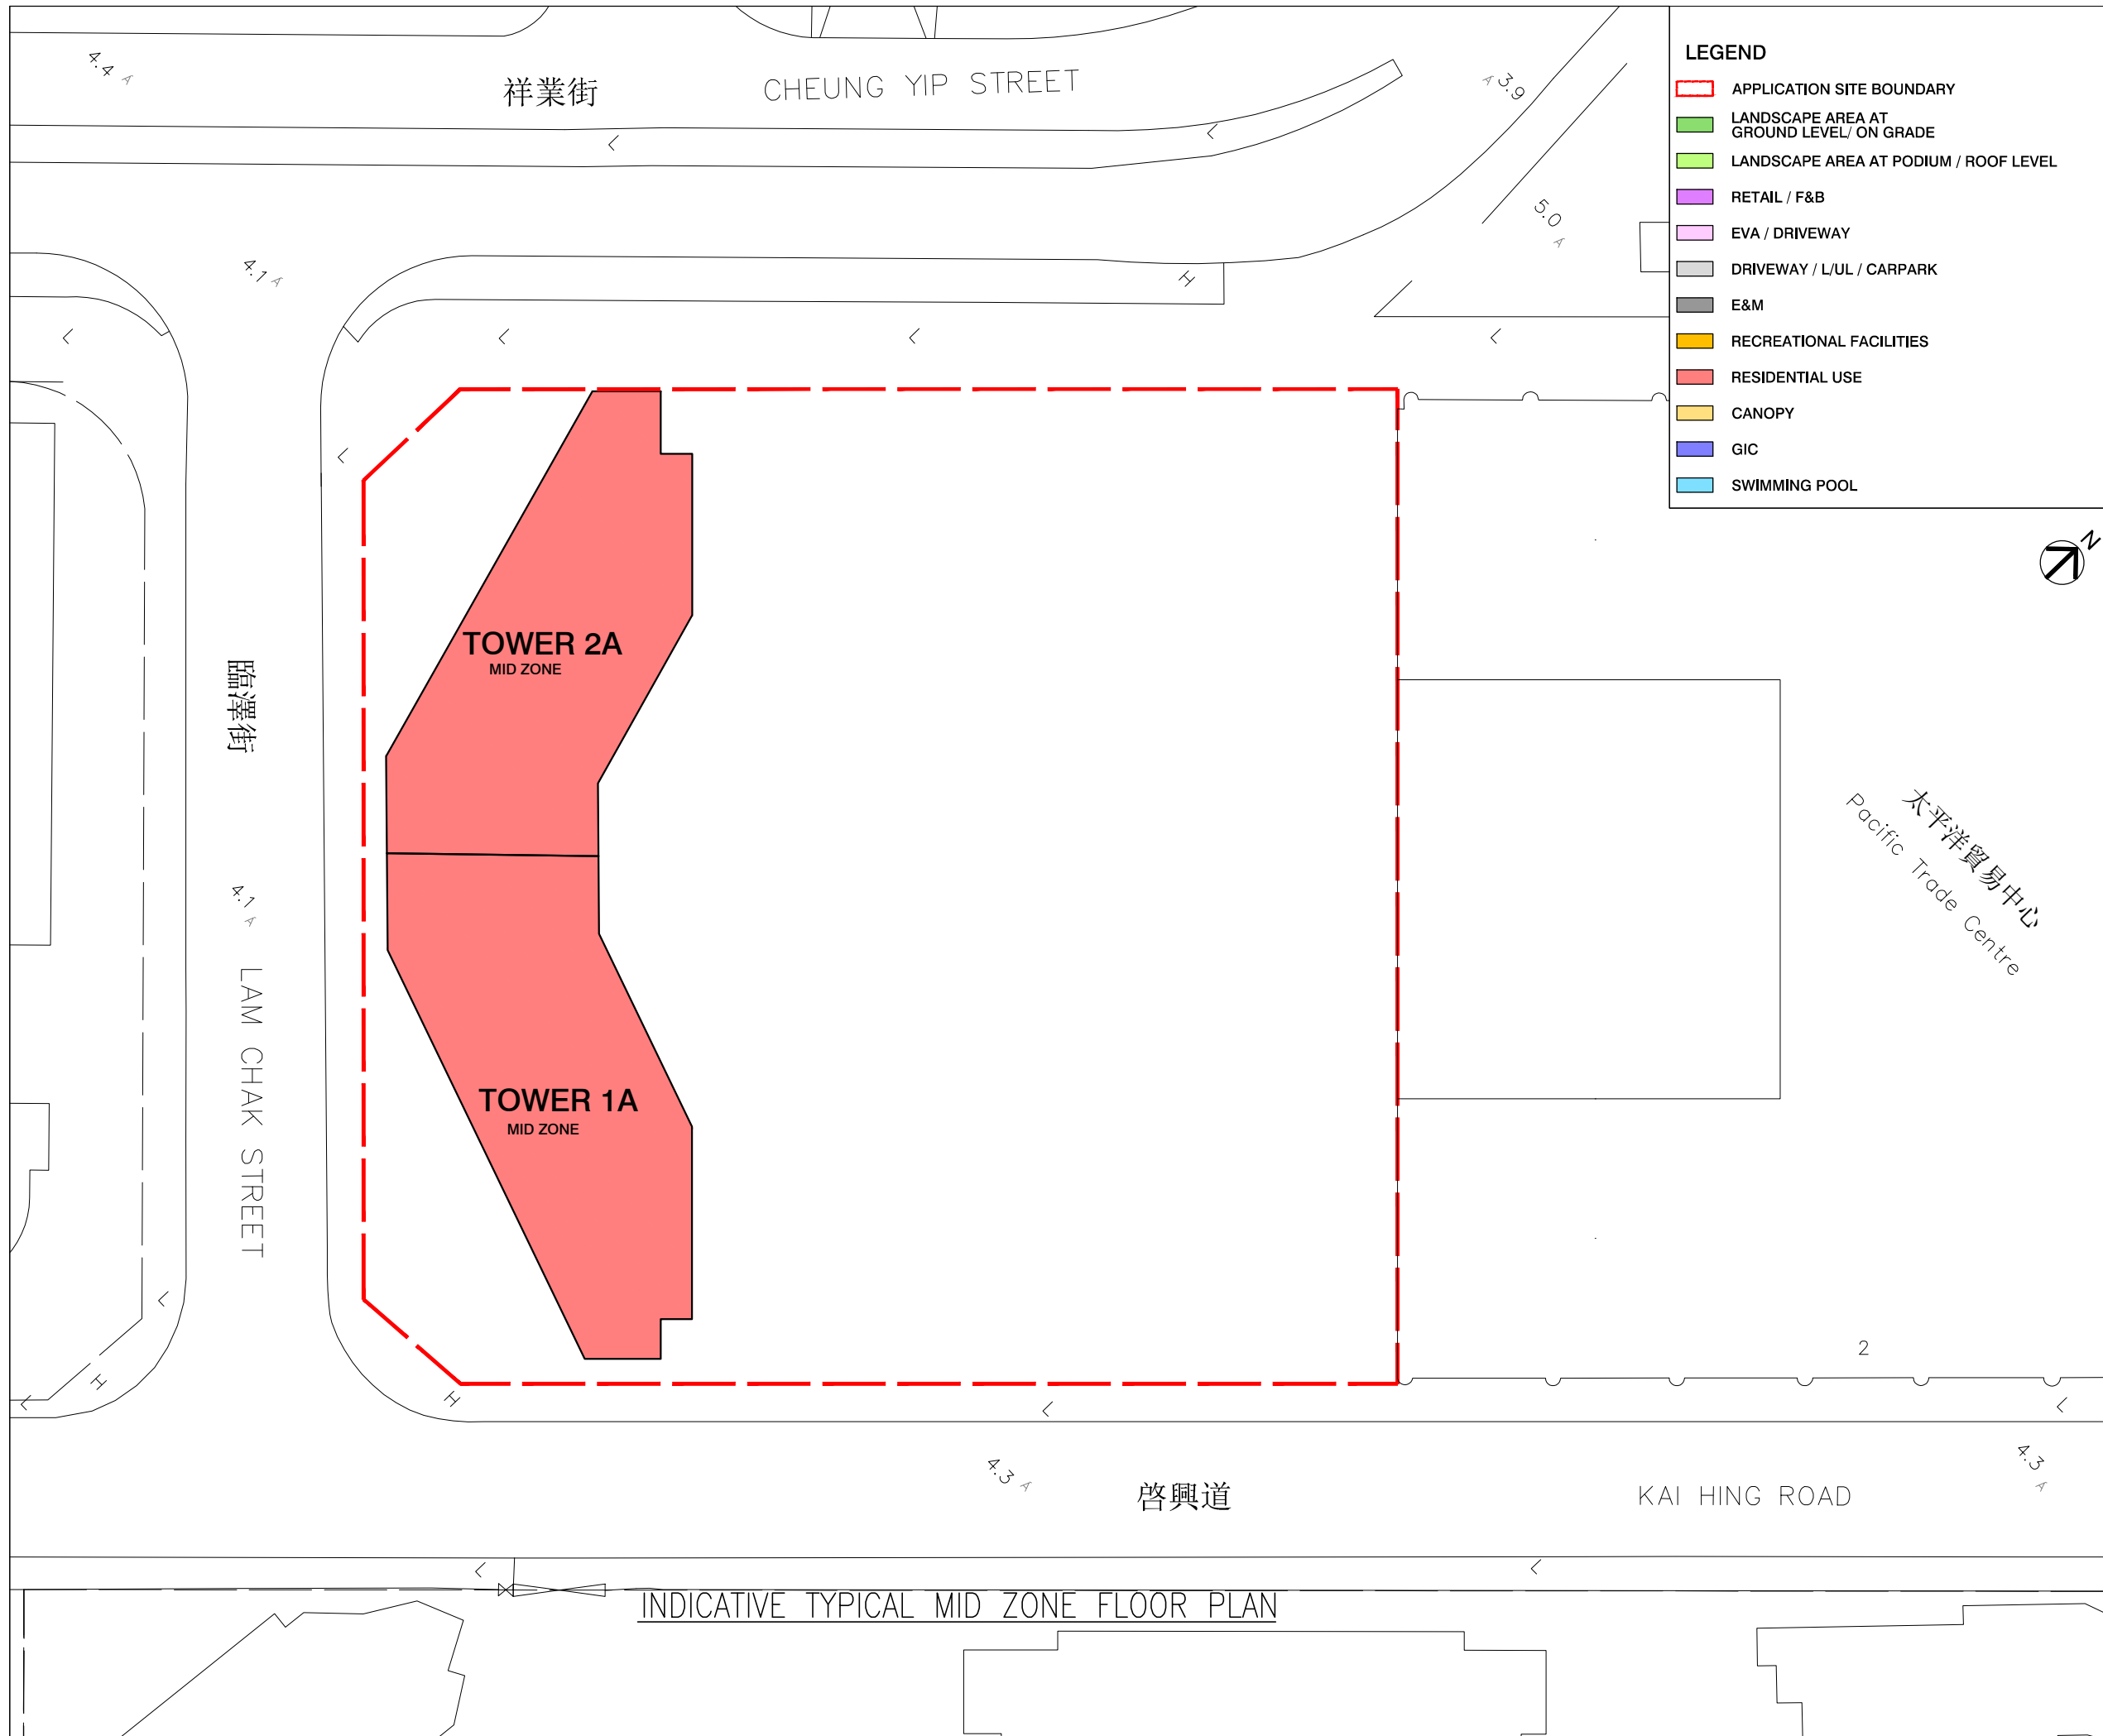

B.D. REFERENCE	屋宇署檔案
F.S.D. REFERENCE	消防處檔案
W.W.O. REFERENCE	水務署檔案
CAD FILE NAME	檔案編號

NOTES				注釋
NO.	REVISIONS	DATE	BY	
修定號	修定內容	日期	經手人	

**DLN**

**DLN Architects Limited**  
劉榮廣伍振民建築師有限公司

46-47 Floor, Tower One, Times Square  
Matheson Street, Causeway Bay, Hong Kong  
香港銅鑼灣勿地臣街  
時代廣場一座46至47樓


t + 852 2895 6888 f + 852 2576 4074  
email general@dln.com.hk www.dln.com.hk

ALL MEASUREMENTS MUST BE CHECKED AT THE WORK BY THE CONTRACTOR  
所有尺寸應由承建商於工地核實  
DO NOT SCALE FROM DRAWINGS. 尺寸不應由圖紙直接量度  
ALL PRINTS, SPECIFICATIONS AND THEIR COPYRIGHT ARE THE PROPERTY OF THE ARCHITECT AND SHALL BE RETURNED AT THE COMPLETION OF THE WORK  
所有印刷、規格說明及所有的版權屬於建築師及應在工程完結後歸還建築師

PROJECT	項目名稱
PROPOSED COMPOSITE DEVELOPMENT AT 8 LAM CHAK STREET, KOWLOON - N.K.I.L. 6215	

TITLE	標題
INDICATIVE MID ZONE FLOOR PLAN	

SCALE	比例	DATE	日期
1:500(A3)		MAY 2026	
DRAWN BY	製作人	CHECKED BY	檢查
DT		-	
JOB NO.	工程項目	DRAWING NO.	圖號
N3591-H		-	

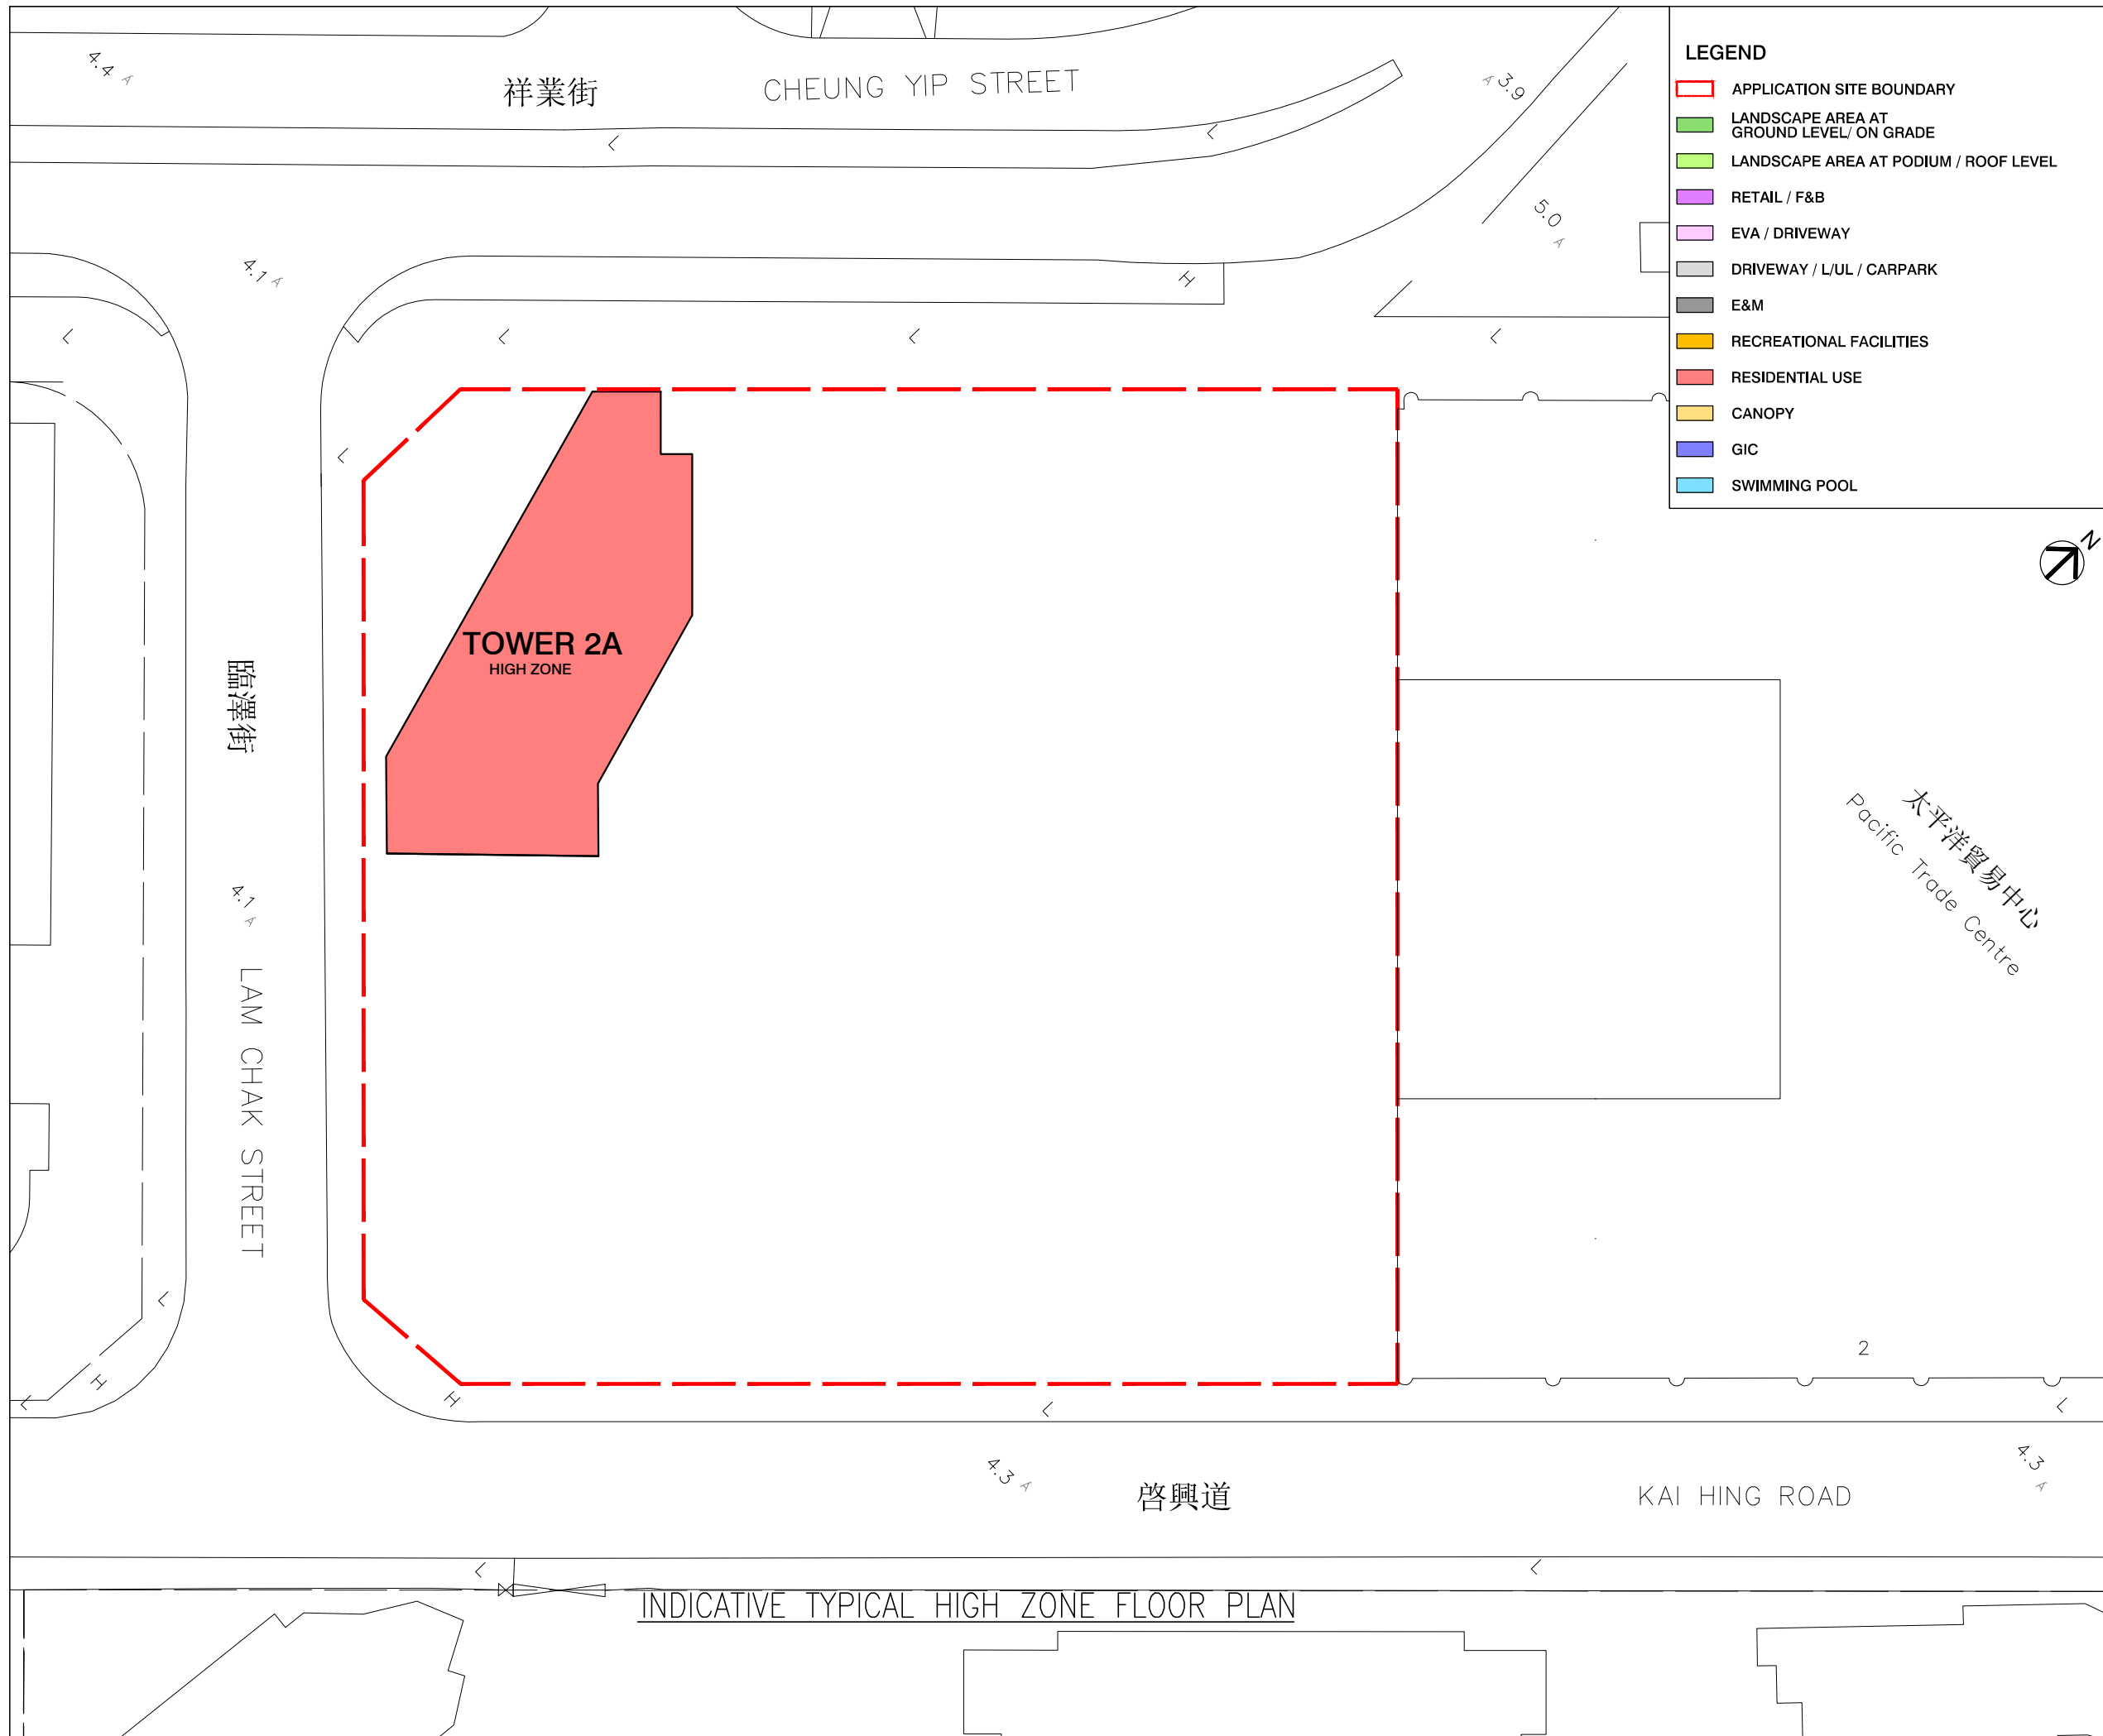

B.D. REFERENCE	屋宇署檔案
F.S.D. REFERENCE	消防處檔案
W.W.O. REFERENCE	水務署檔案
CAD FILE NAME	檔案編號

NOTES 注釋

NO. 修定號	REVISIONS 修定內容	DATE 日期	BY 經手人

**DLN**


**DLN Architects Limited**  
 劉榮廣伍振民建築師有限公司  
 46-47 Floor, Tower One, Times Square  
 Matheson Street, Causeway Bay, Hong Kong  
 香港銅鑼灣勿地臣街  
 時代廣場一座46至47樓  
 t +852 2895 6888 1 +852 2576 4074 email general@dln.com.hk www.dln.com.hk

ALL MEASUREMENTS MUST BE CHECKED AT THE WORK BY THE CONTRACTOR  
 所有尺寸應由承建商於工地核實  
 DO NOT SCALE FROM DRAWINGS 尺寸不應由圖紙直接量度  
 ALL PRINTS, SPECIFICATIONS AND THEIR COPYRIGHT ARE THE PROPERTY OF  
 THE ARCHITECT AND SHALL BE RETURNED AT THE COMPLETION OF THE WORK  
 所有印刷、規格說明及所有的版權屬於建築師及應在工程完結後歸還建築師

PROJECT 項目名稱	PROPOSED COMPOSITE DEVELOPMENT AT 8 LAM CHAK STREET, KOWLOON - N.K.I.L. 6215
--------------	--

TITLE 標題	INDICATIVE HIGH ZONE FLOOR PLAN
----------	---------------------------------

SCALE 比例	1:500(A3)	DATE 日期	MAY 2026
DRAWN BY 製作人	DT	CHECKED BY 檢查	-
JOB NO. 工程項目	N3591-H	DRAWING NO. 圖號	-

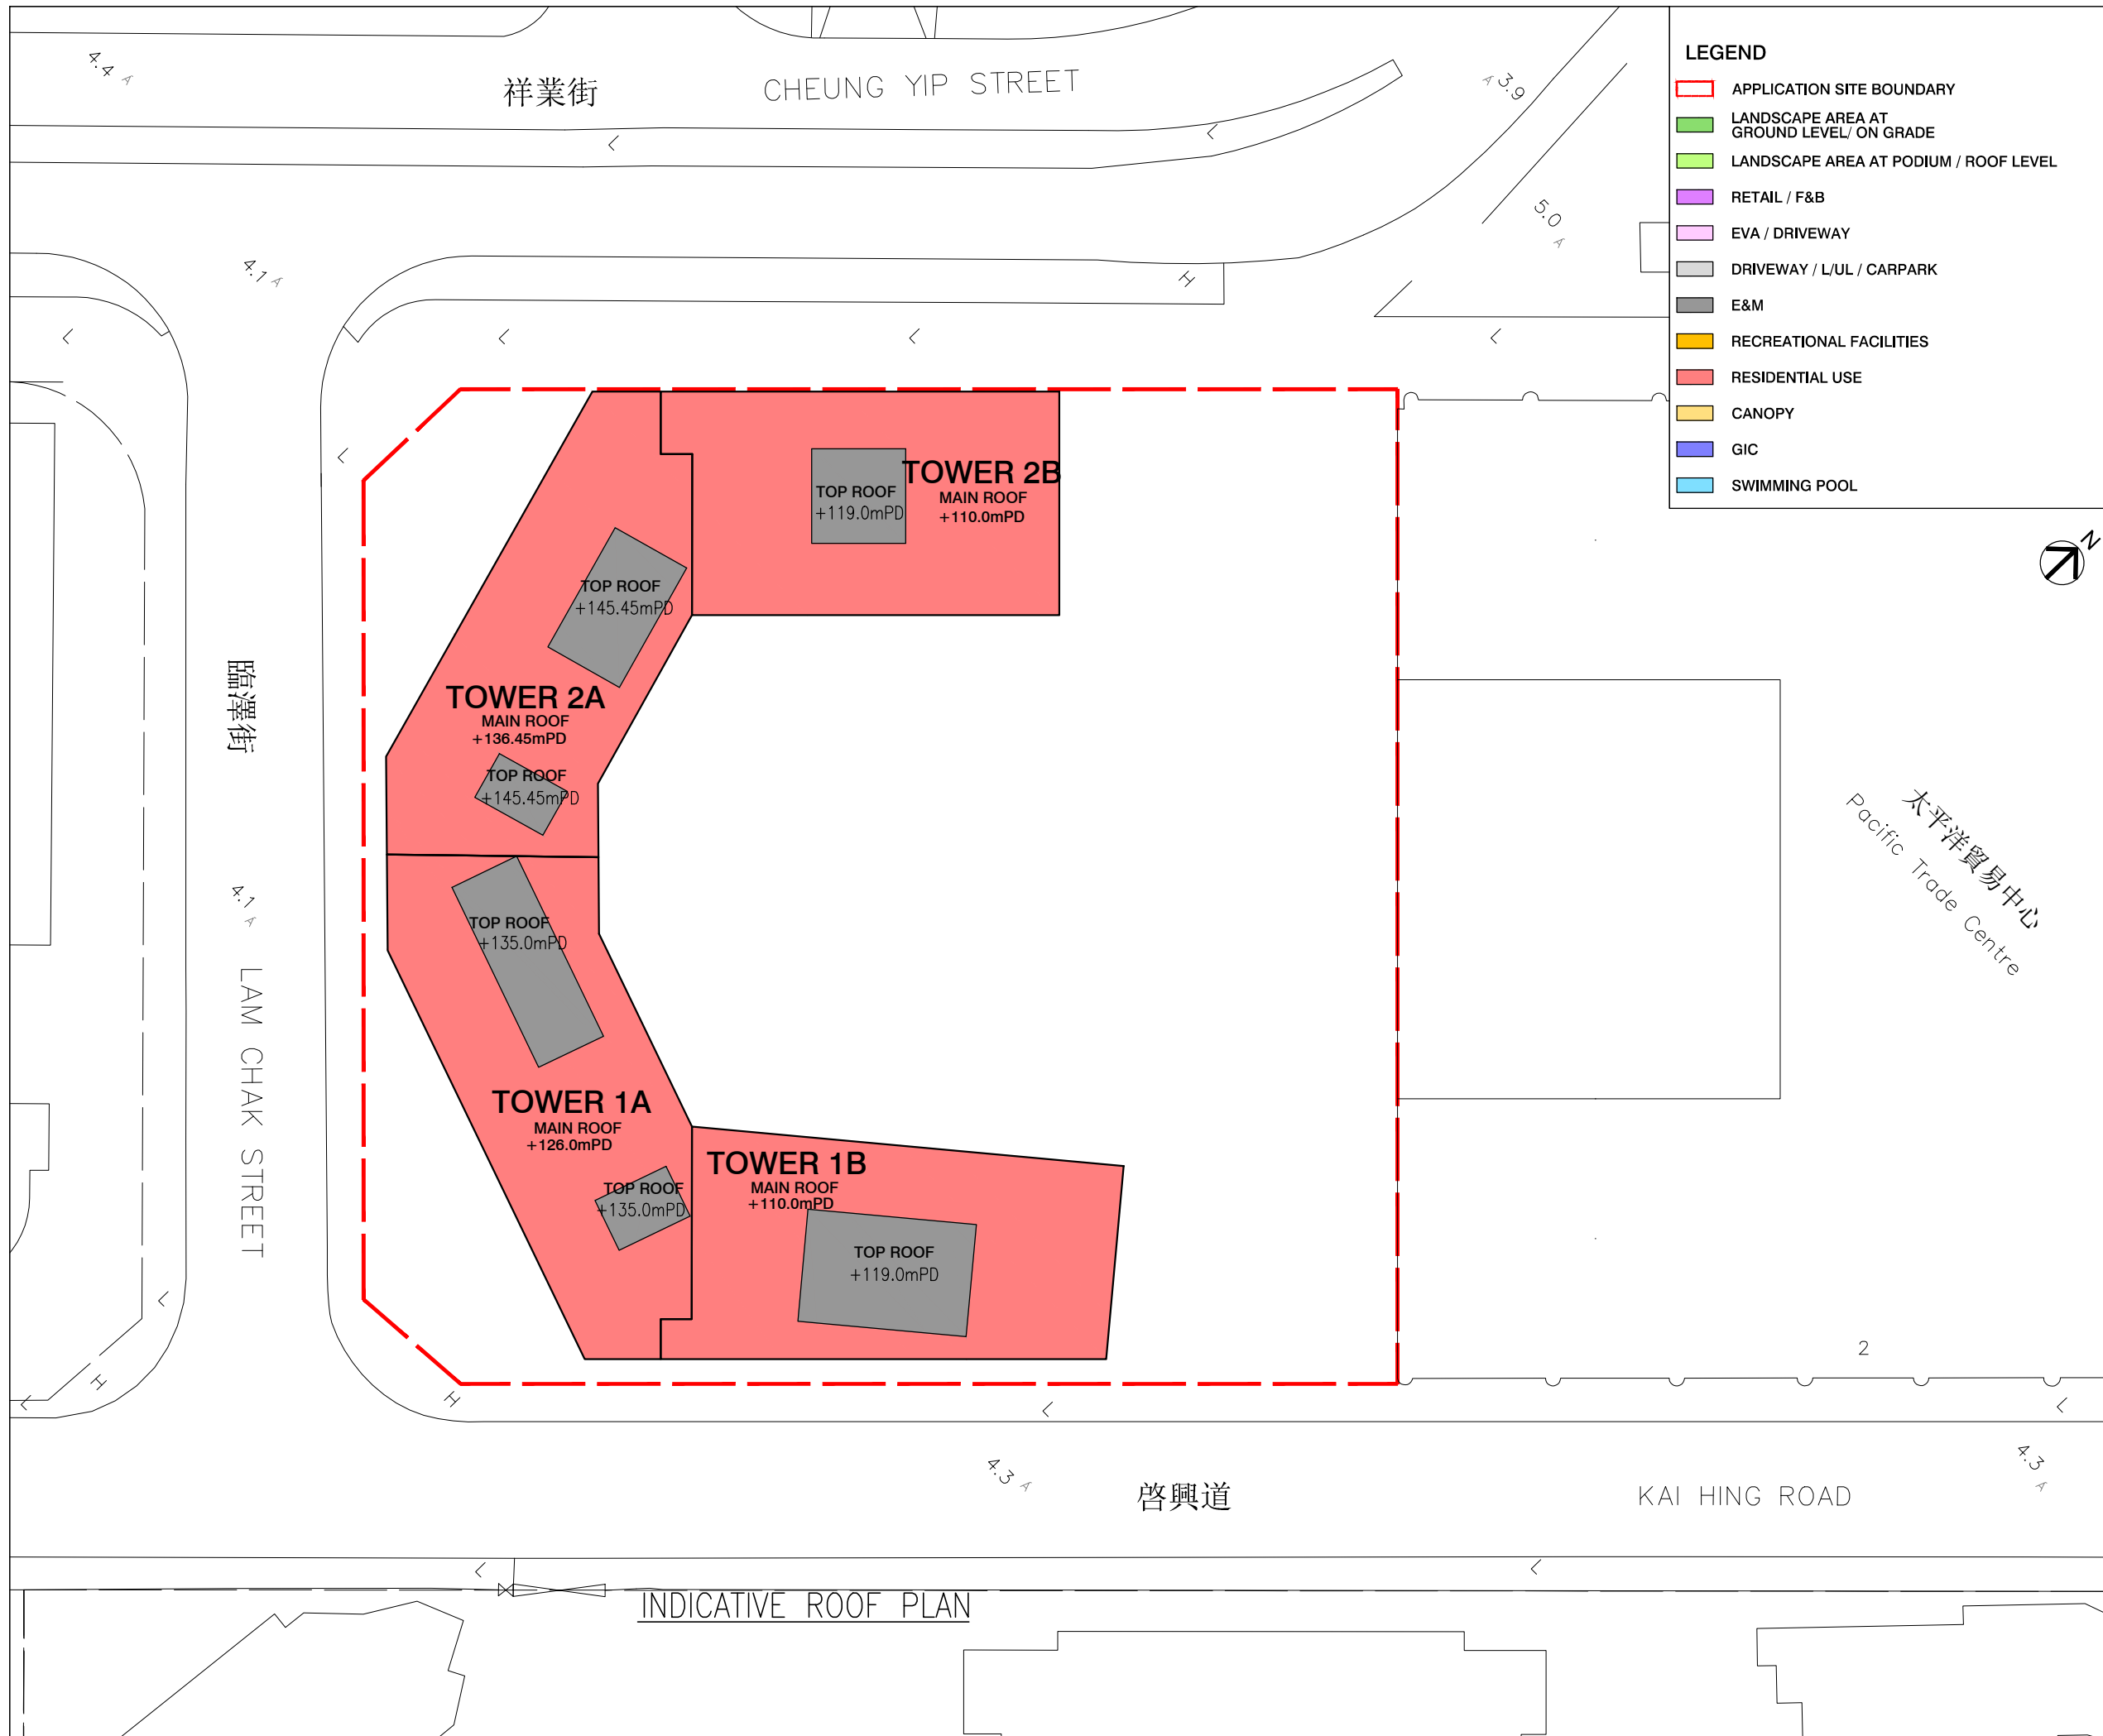

- LEGEND**
- APPLICATION SITE BOUNDARY
  - LANDSCAPE AREA AT GROUND LEVEL/ ON GRADE
  - LANDSCAPE AREA AT PODIUM / ROOF LEVEL
  - RETAIL / F&B
  - EVA / DRIVEWAY
  - DRIVEWAY / L/UL / CARPARK
  - E&M
  - RECREATIONAL FACILITIES
  - RESIDENTIAL USE
  - CANOPY
  - GIC
  - SWIMMING POOL



B.D. REFERENCE	屋宇署檔案
F.S.D. REFERENCE	消防處檔案
W.W.O. REFERENCE	水務署檔案
CAD FILE NAME	檔案編號

NOTES 注釋

NO. 修定號	REVISIONS 修定內容	DATE 日期	BY 經手人

# DLN

**DLN Architects Limited**  
 劉榮廣伍振民建築師有限公司

46-47 Floor, Tower One, Times Square  
 Matheson Street, Causeway Bay, Hong Kong  
 香港銅鑼灣勿地臣街  
 時代廣場一座46至47樓



t +852 2895 6888 f +852 2576 4074 email general@dln.com.hk www.dln.com.hk

ALL MEASUREMENTS MUST BE CHECKED AT THE WORK BY THE CONTRACTOR  
 所有尺寸應由承建商於工地核實  
 DO NOT SCALE FROM DRAWINGS 尺寸不應由圖紙直接量度  
 ALL PRINTS, SPECIFICATIONS AND THEIR COPYRIGHT ARE THE PROPERTY OF  
 THE ARCHITECT AND SHALL BE RETURNED AT THE COMPLETION OF THE WORK  
 所有印刷、規格說明及所有的版權屬於建築師及應在工程完結後歸還建築師

PROJECT	項目名稱
<b>PROPOSED COMPOSITE DEVELOPMENT          AT 8 LAM CHAK STREET, KOWLOON          - N.K.I.L. 6215</b>	

TITLE	標題
<b>INDICATIVE ROOF FLOOR PLAN</b>	

SCALE	比例	DATE	日期
1:500(A3)		MAY 2026	
DRAWN BY	製作人	CHECKED BY	檢查
DT		-	
JOB NO.	工程項目	DRAWING NO.	圖號
N3591-H		-	

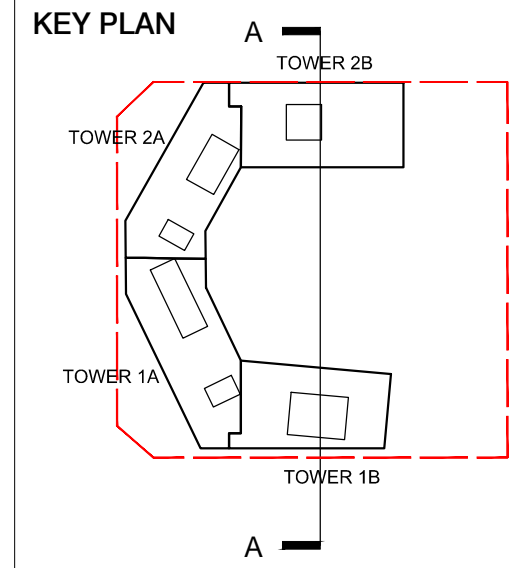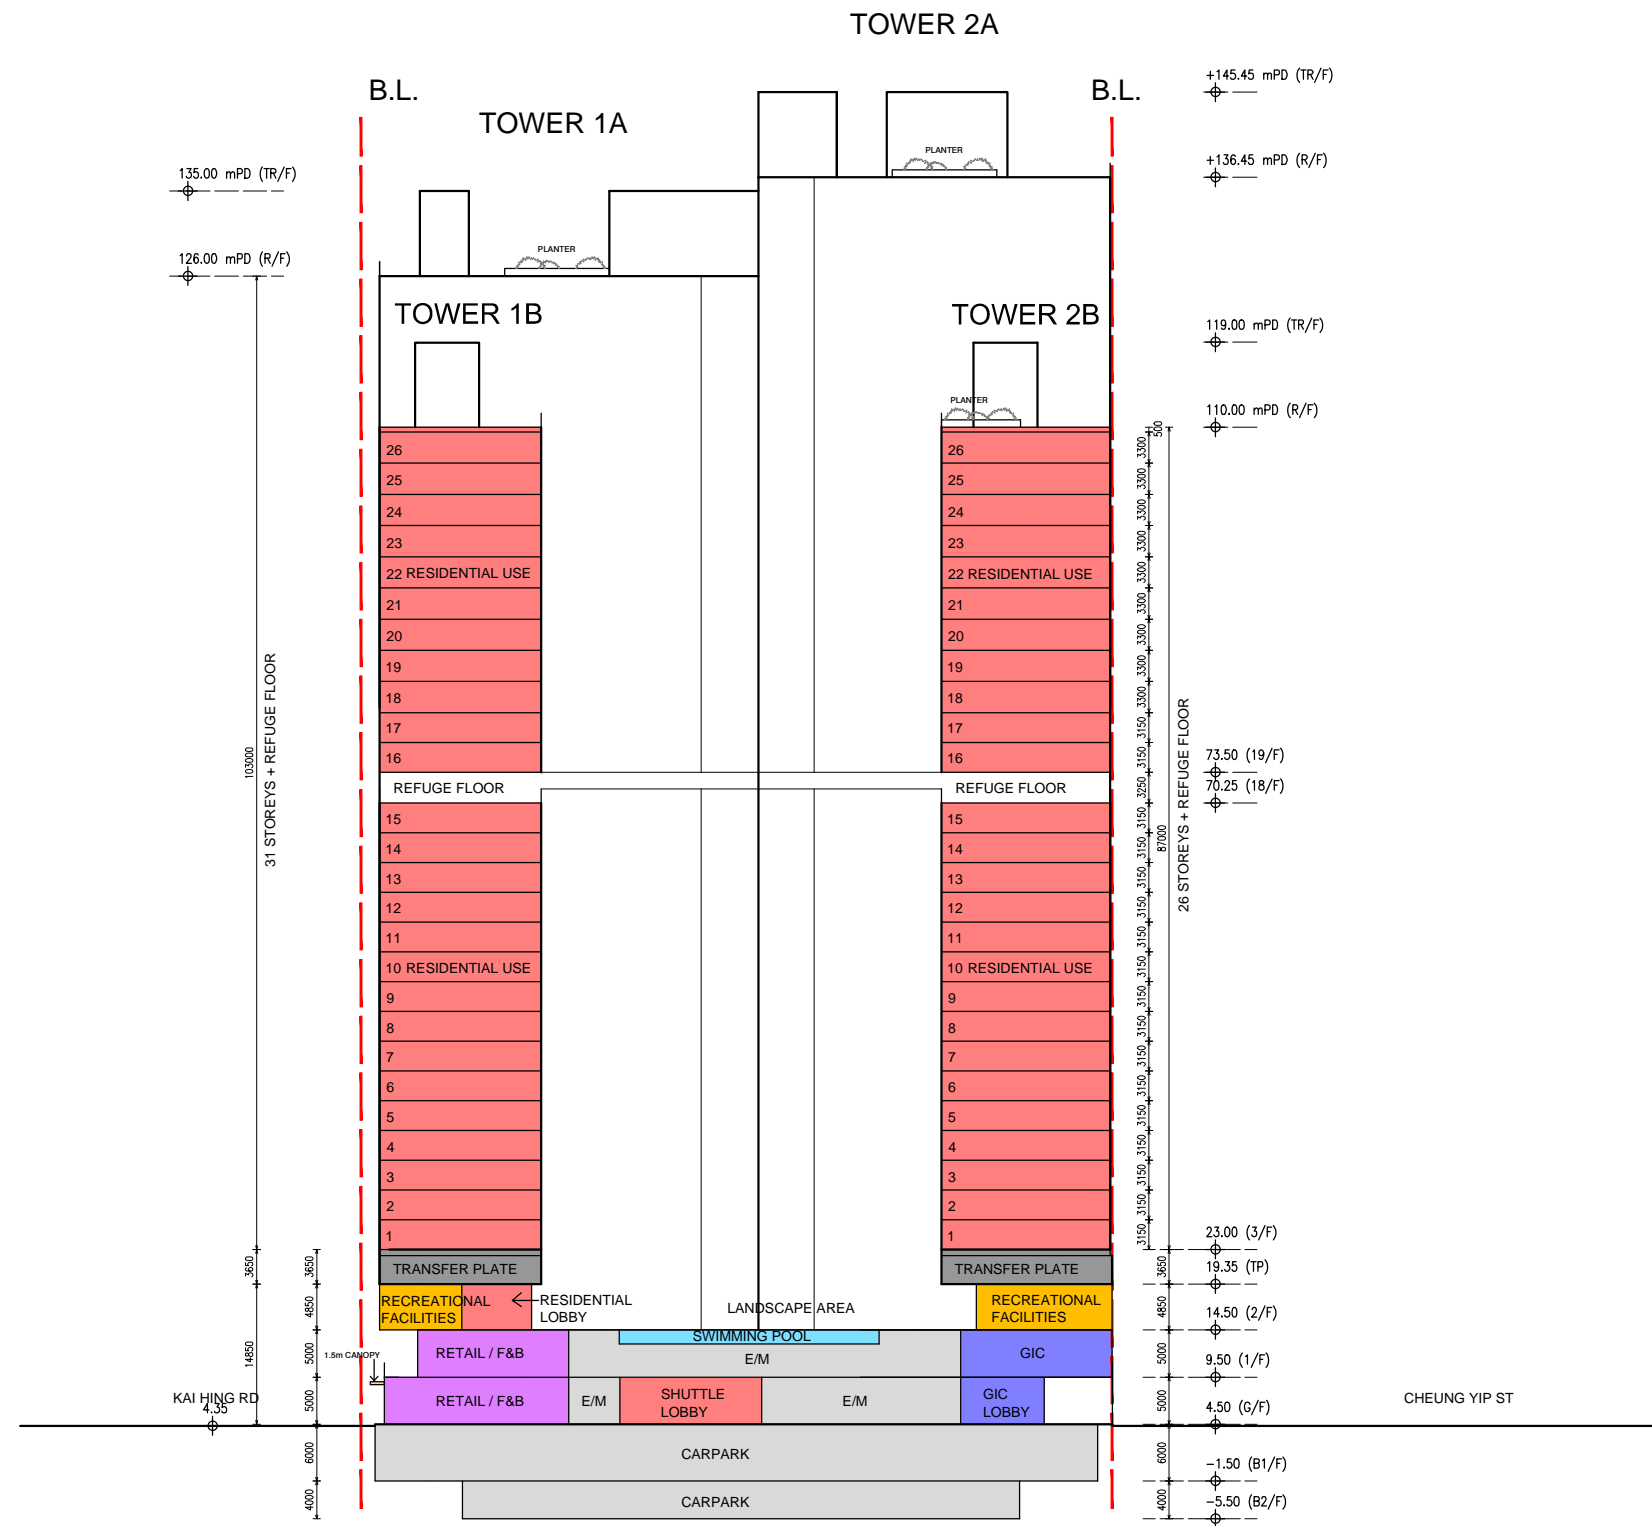

- LEGEND**
- APPLICATION SITE BOUNDARY
  - LANDSCAPE AREA AT GROUND LEVEL / ON GRADE
  - LANDSCAPE AREA AT PODIUM / ROOF LEVEL
  - RETAIL / F&B
  - EVA / DRIVEWAY
  - DRIVEWAY / L/UL / CARPARK
  - E&M
  - RECREATIONAL FACILITIES
  - RESIDENTIAL USE
  - CANOPY
  - GIC
  - SWIMMING POOL

B.D. REFERENCE	屋宇署檔案		
F.S.D. REFERENCE	消防處檔案		
W.W.O. REFERENCE	水務署檔案		
CAD FILE NAME	檔案編號		
NOTES	注釋		
NO.	REVISIONS	DATE	BY
修定號	修定內容	日期	經手人

**DLN**

**DLN Architects Limited**  
 劉榮廣伍振民建築師有限公司  
 46-47 Floor, Tower One, Times Square  
 Matheson Street, Causeway Bay, Hong Kong  
 香港銅鑼灣勿地臣街  
 時代廣場一座46至47樓  
 t +852 2695 6888 1 +852 2576 4074 email general@dln.com.hk www.dln.com.hk

ALL MEASUREMENTS MUST BE CHECKED AT THE WORK BY THE CONTRACTOR  
 所有尺寸應由承建商於工地核實  
 DO NOT SCALE FROM DRAWINGS 尺寸不應由圖紙直接量度  
 ALL PRINTS, SPECIFICATIONS AND THEIR COPYRIGHT ARE THE PROPERTY OF  
 THE ARCHITECT AND SHALL BE RETURNED AT THE COMPLETION OF THE WORK  
 所有印刷、規格說明及所有的版權屬於建築師及應在工程完結後歸還建築師


PROJECT 項目名稱

PROPOSED COMPOSITE DEVELOPMENT  
 AT 8 LAM CHAK STREET, KOWLOON  
 - N.K.I.L. 6215


TITLE 標題

INDICATIVE SECTION A-A

SCALE 比例	DATE 日期
1:800(A3)	MAY 2026
DRAWN BY 製作人	CHECKED BY 檢查
DT	-
JOB NO. 工程項目	DRAWING NO. 圖號
N3591-H	-

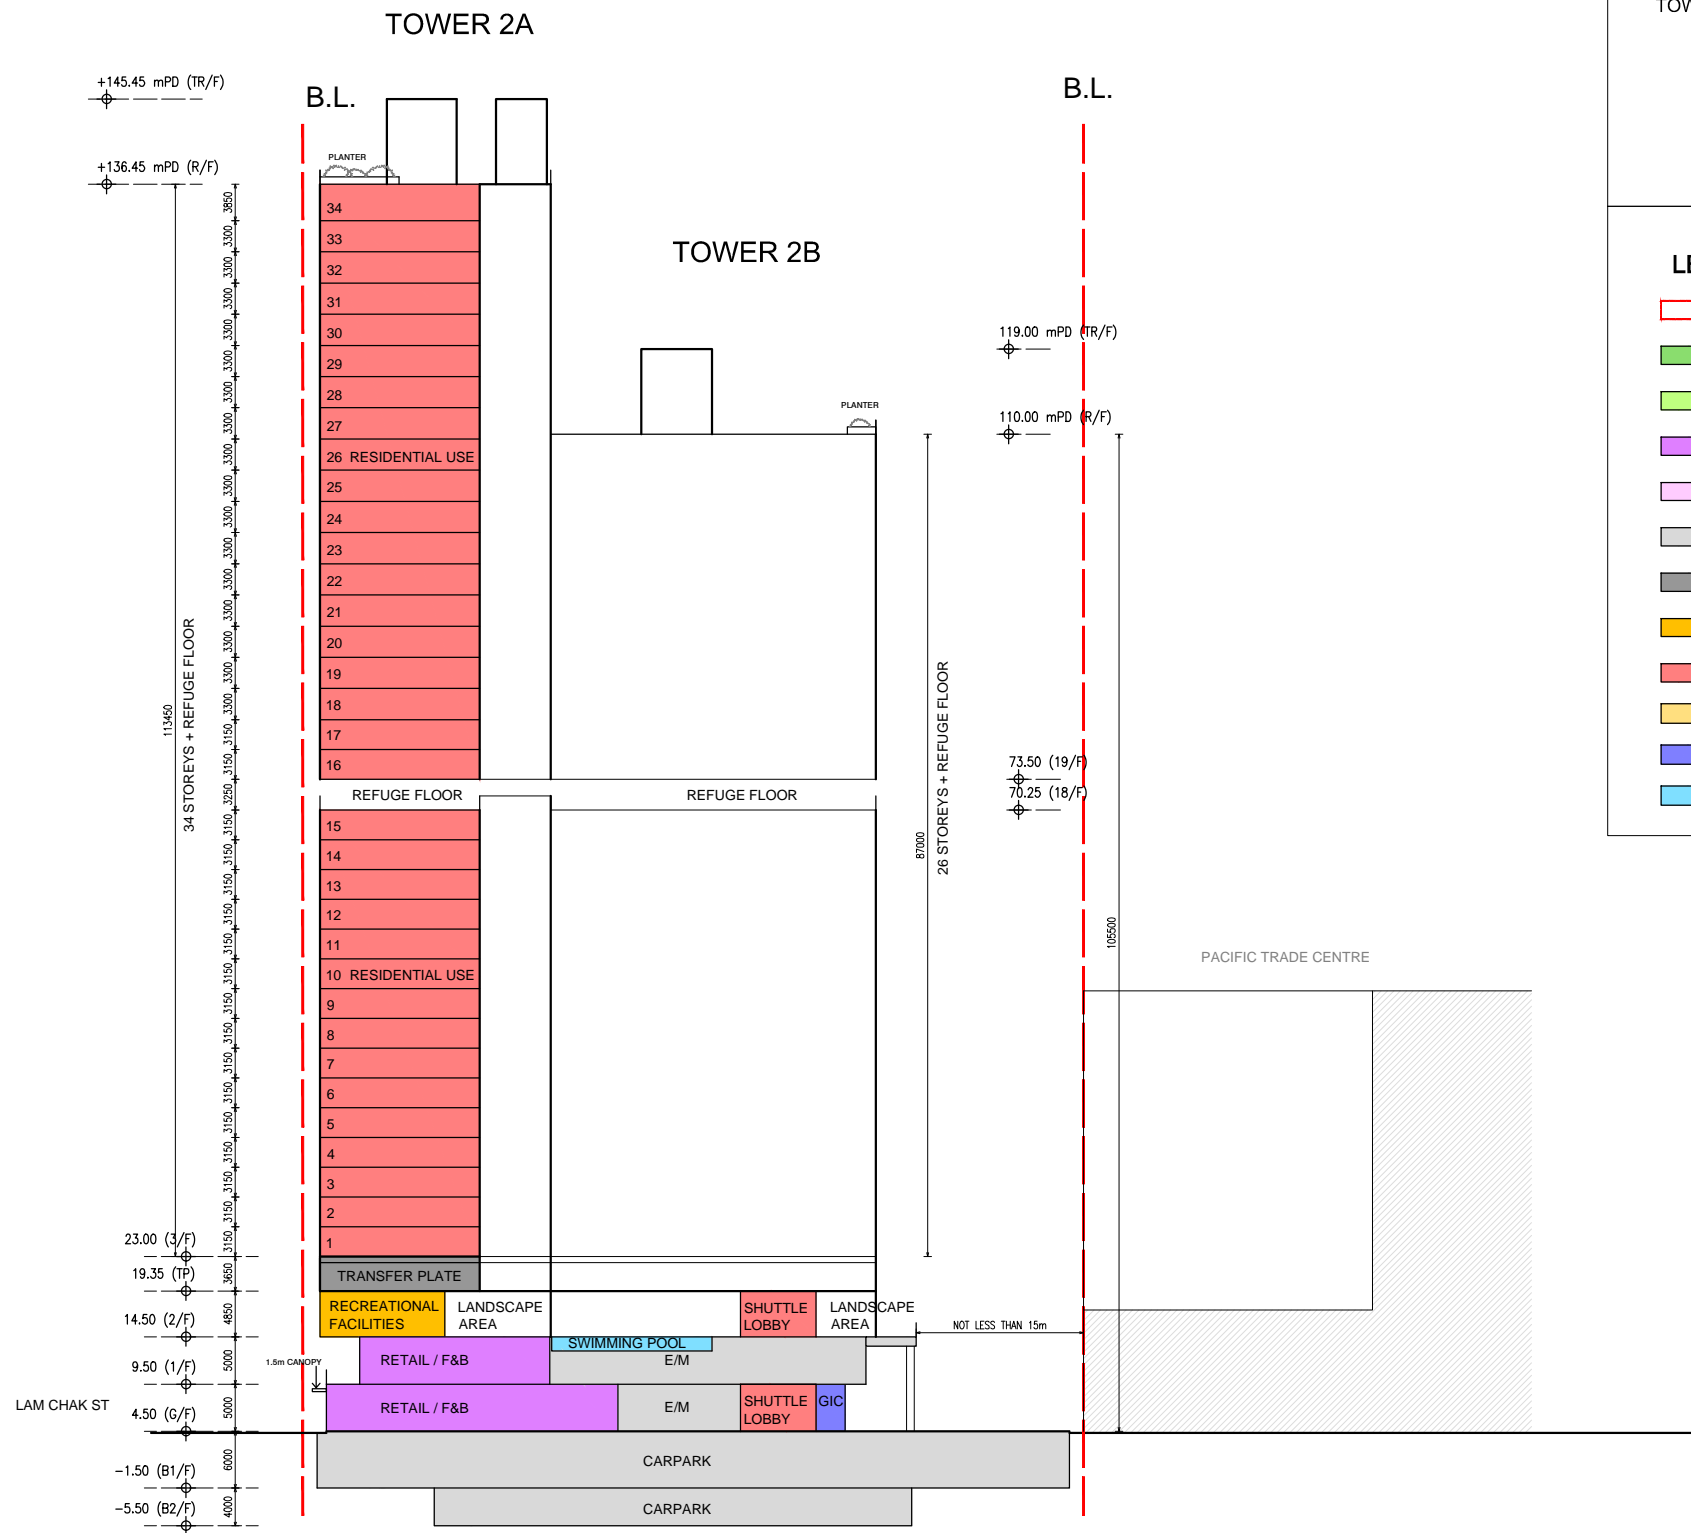

**KEY PLAN**

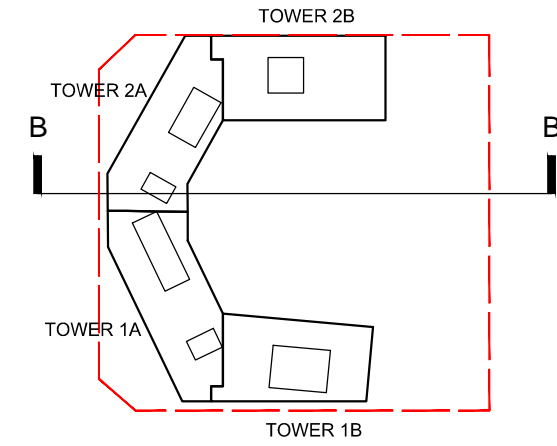

**LEGEND**

- APPLICATION SITE BOUNDARY
- LANDSCAPE AREA AT GROUND LEVEL/ ON GRADE
- LANDSCAPE AREA AT PODIUM / ROOF LEVEL
- RETAIL / F&B
- EVA / DRIVEWAY
- DRIVEWAY / L/UL / CARPARK
- E&M
- RECREATIONAL FACILITIES
- RESIDENTIAL USE
- CANOPY
- GIC
- SWIMMING POOL

B.D. REFERENCE		屋宇署檔案	
F.S.D. REFERENCE		消防處檔案	
W.W.O. REFERENCE		水務署檔案	
CAD FILE NAME		檔案編號	
NOTES		注釋	
NO.	REVISIONS	DATE	BY
修定號	修定內容	日期	經手人




**DLN Architects Limited**  
 劉樂廣伍振民建築師有限公司  
 46-47 Floor, Tower One, Times Square  
 Matheson Street, Causeway Bay, Hong Kong  
 香港銅鑼灣勿地申街  
 時代廣場一座46至47樓  
 t +852 2895 6888 f +852 2576 4074 email general@dln.com.hk www.dln.com.hk

ALL MEASUREMENTS MUST BE CHECKED AT THE WORK BY THE CONTRACTOR  
 所有尺寸應由承建商於工地核實  
 DO NOT SCALE FROM DRAWINGS 尺寸不應由圖紙直接量度  
 ALL PRINTS, SPECIFICATIONS AND THEIR COPYRIGHT ARE THE PROPERTY OF  
 THE ARCHITECT AND SHALL BE RETURNED AT THE COMPLETION OF THE WORK  
 所有印刷、規格說明及所有的版權屬於建築師及應在工程完結後歸還建築師


PROJECT 項目名稱  
**PROPOSED COMPOSITE DEVELOPMENT  
 AT 8 LAM CHAK STREET, KOWLOON  
 - N.K.I.L. 6215**

TITLE 標題  
**INDICATIVE SECTION B-B**

SCALE 比例	DATE 日期
1:800(A3)	MAY 2026
DRAWN BY 製作人	CHECKED BY 檢查
DT	-
JOB NO. 工程項目	DRAWING NO. 圖號
N3591-H	-

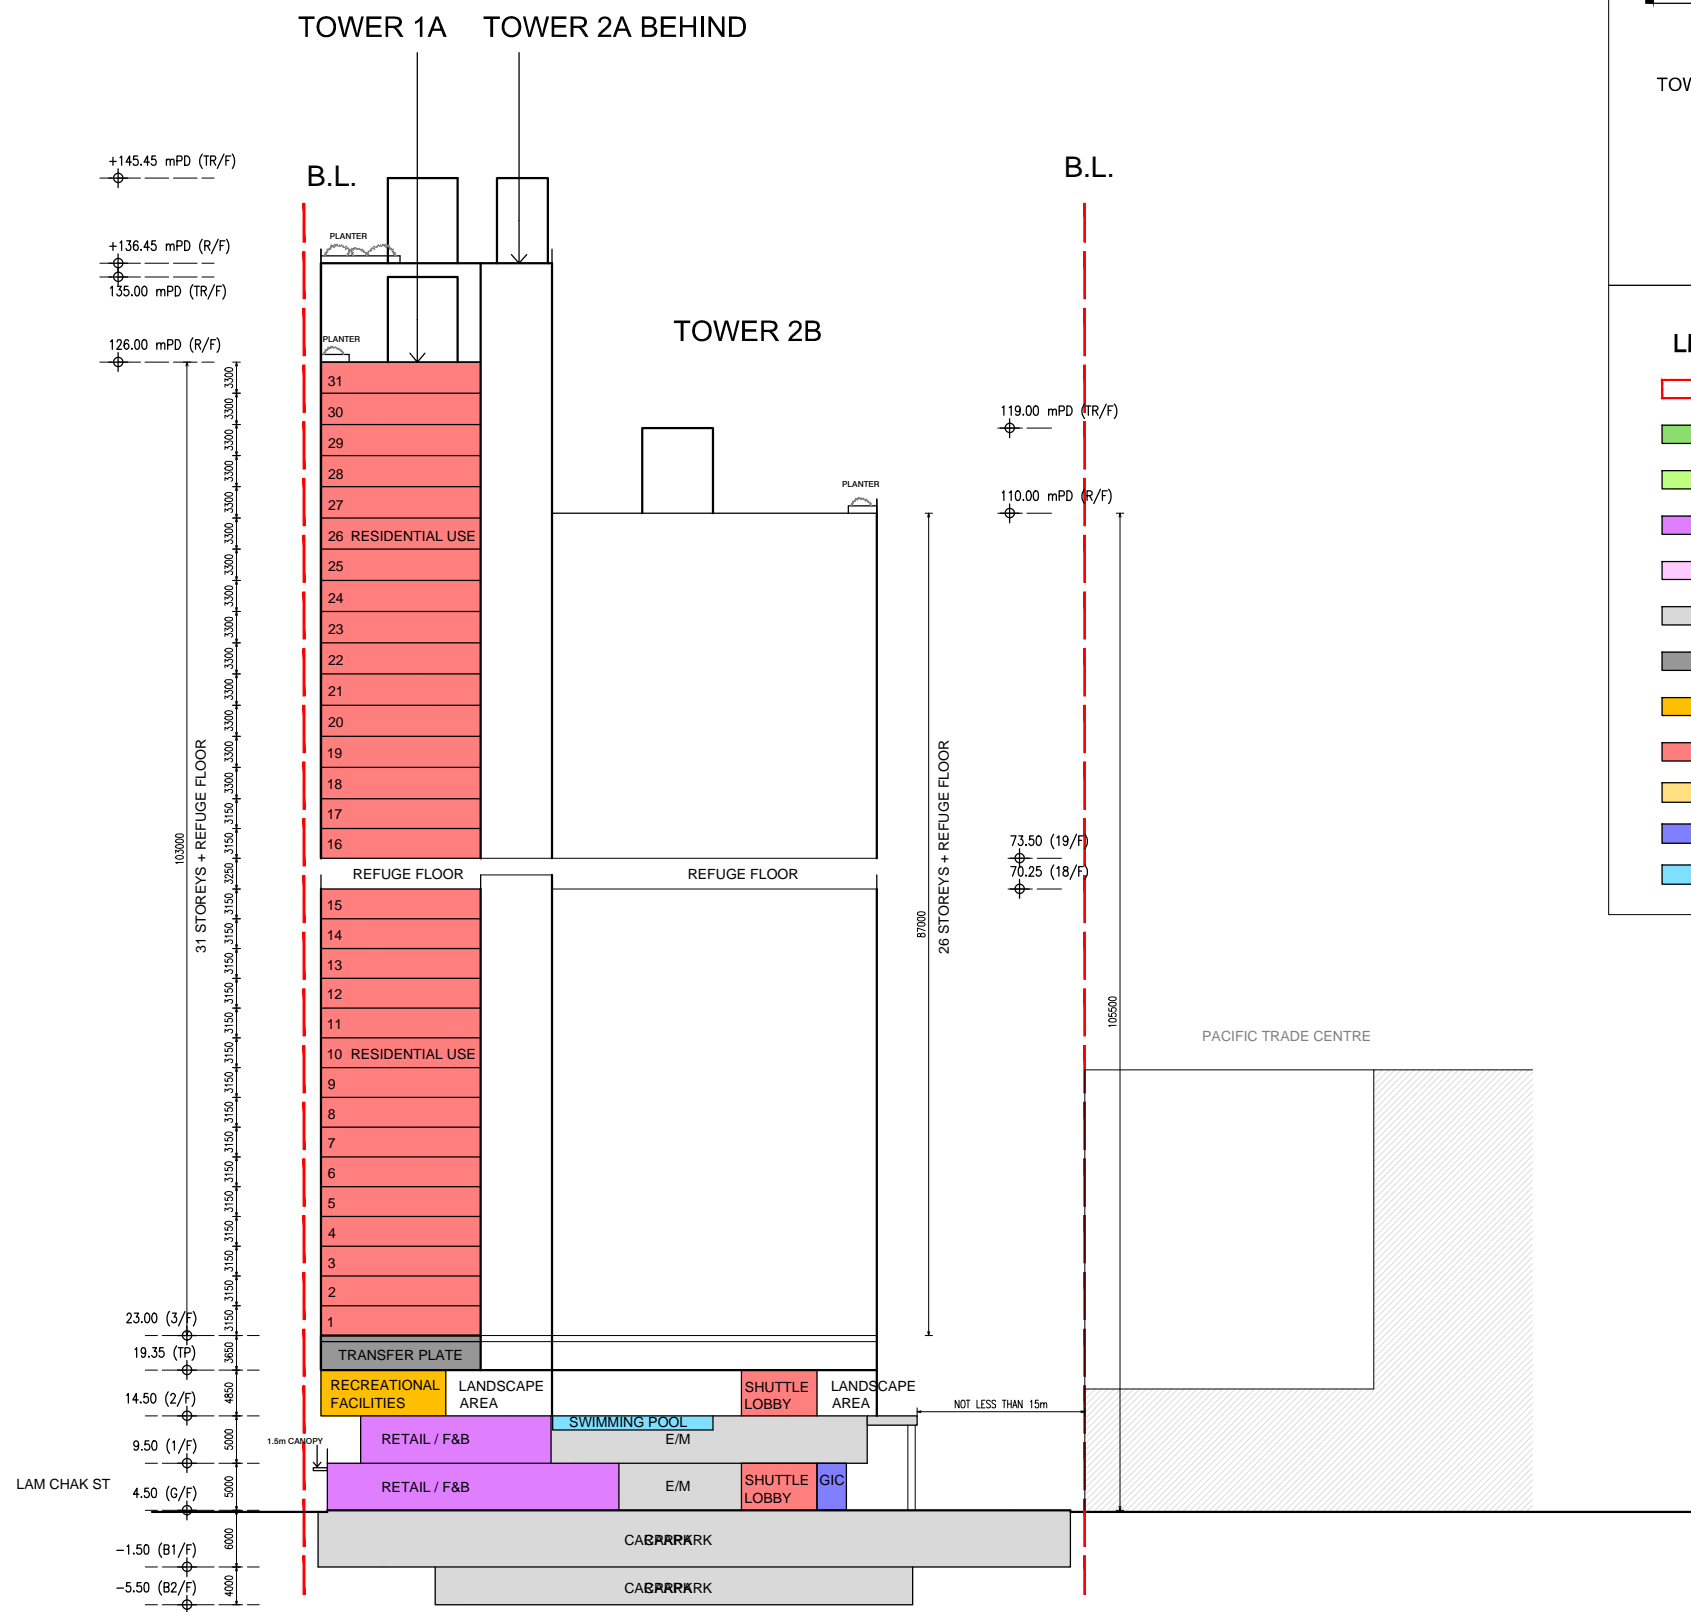

**KEY PLAN**

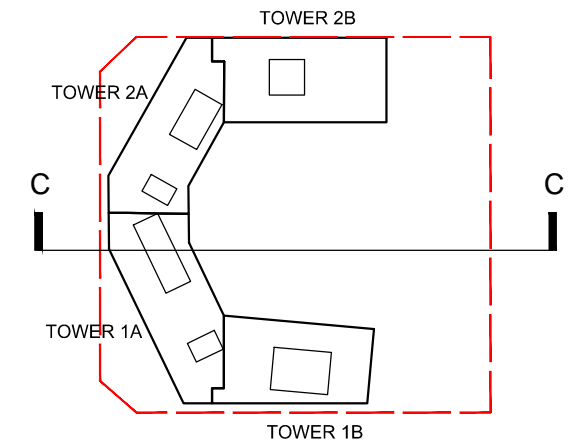

**LEGEND**

- APPLICATION SITE BOUNDARY
- LANDSCAPE AREA AT GROUND LEVEL / ON GRADE
- LANDSCAPE AREA AT PODIUM / ROOF LEVEL
- RETAIL / F&B
- EVA / DRIVEWAY
- DRIVEWAY / L/UL / CARPARK
- E&M
- RECREATIONAL FACILITIES
- RESIDENTIAL USE
- CANOPY
- GIC
- SWIMMING POOL

B.D. REFERENCE	屋宇署檔案
F.S.D. REFERENCE	消防處檔案
W.W.O. REFERENCE	水務署檔案
CAD FILE NAME	檔案編號

NOTES				注釋
NO.	REVISIONS	DATE	BY	
修定號	修定內容	日期	經手人	

**DLN**

**DLN Architects Limited**  
劉榮廣伍振民建築師有限公司

46-47 Floor, Tower One, Times Square  
Matheson Street, Causeway Bay, Hong Kong  
香港銅鑼灣勿地臣街  
時代廣場一座46至47樓

t +852 2695 6888 1 +852 2576 4074    email general@dln.com.hk    www.dln.com.hk

ALL MEASUREMENTS MUST BE CHECKED AT THE WORK BY THE CONTRACTOR  
所有尺寸應由承建商於工地核實  
DO NOT SCALE FROM DRAWINGS 尺寸不應由圖紙直接量度  
ALL PRINTS, SPECIFICATIONS AND THEIR COPYRIGHT ARE THE PROPERTY OF THE ARCHITECT AND SHALL BE RETURNED AT THE COMPLETION OF THE WORK  
所有印刷、規格說明及所有的版權屬於建築師及應在工程完結後歸還建築師

PROJECT	項目名稱
PROPOSED COMPOSITE DEVELOPMENT AT 8 LAM CHAK STREET, KOWLOON - N.K.I.L. 6215	

TITLE	標題
INDICATIVE SECTION C-C	

SCALE	比例	DATE	日期
1:800(A3)		MAY 2026	
DRAWN BY	製作人	CHECKED BY	檢查
DT		-	
JOB NO.	工程項目	DRAWING NO.	圖號
N3591-H		-	