


**Proposed Composite Development (with Flat and Retail/F&B)
with Minor Relaxation of Plot Ratio Restriction
in “Commercial (2)” Zone at 8 Lam Chak Street, Kowloon
S16 Planning Application**


(Planning Application No: A/K22/50)

Appendix I


Updated Architectural Drawings

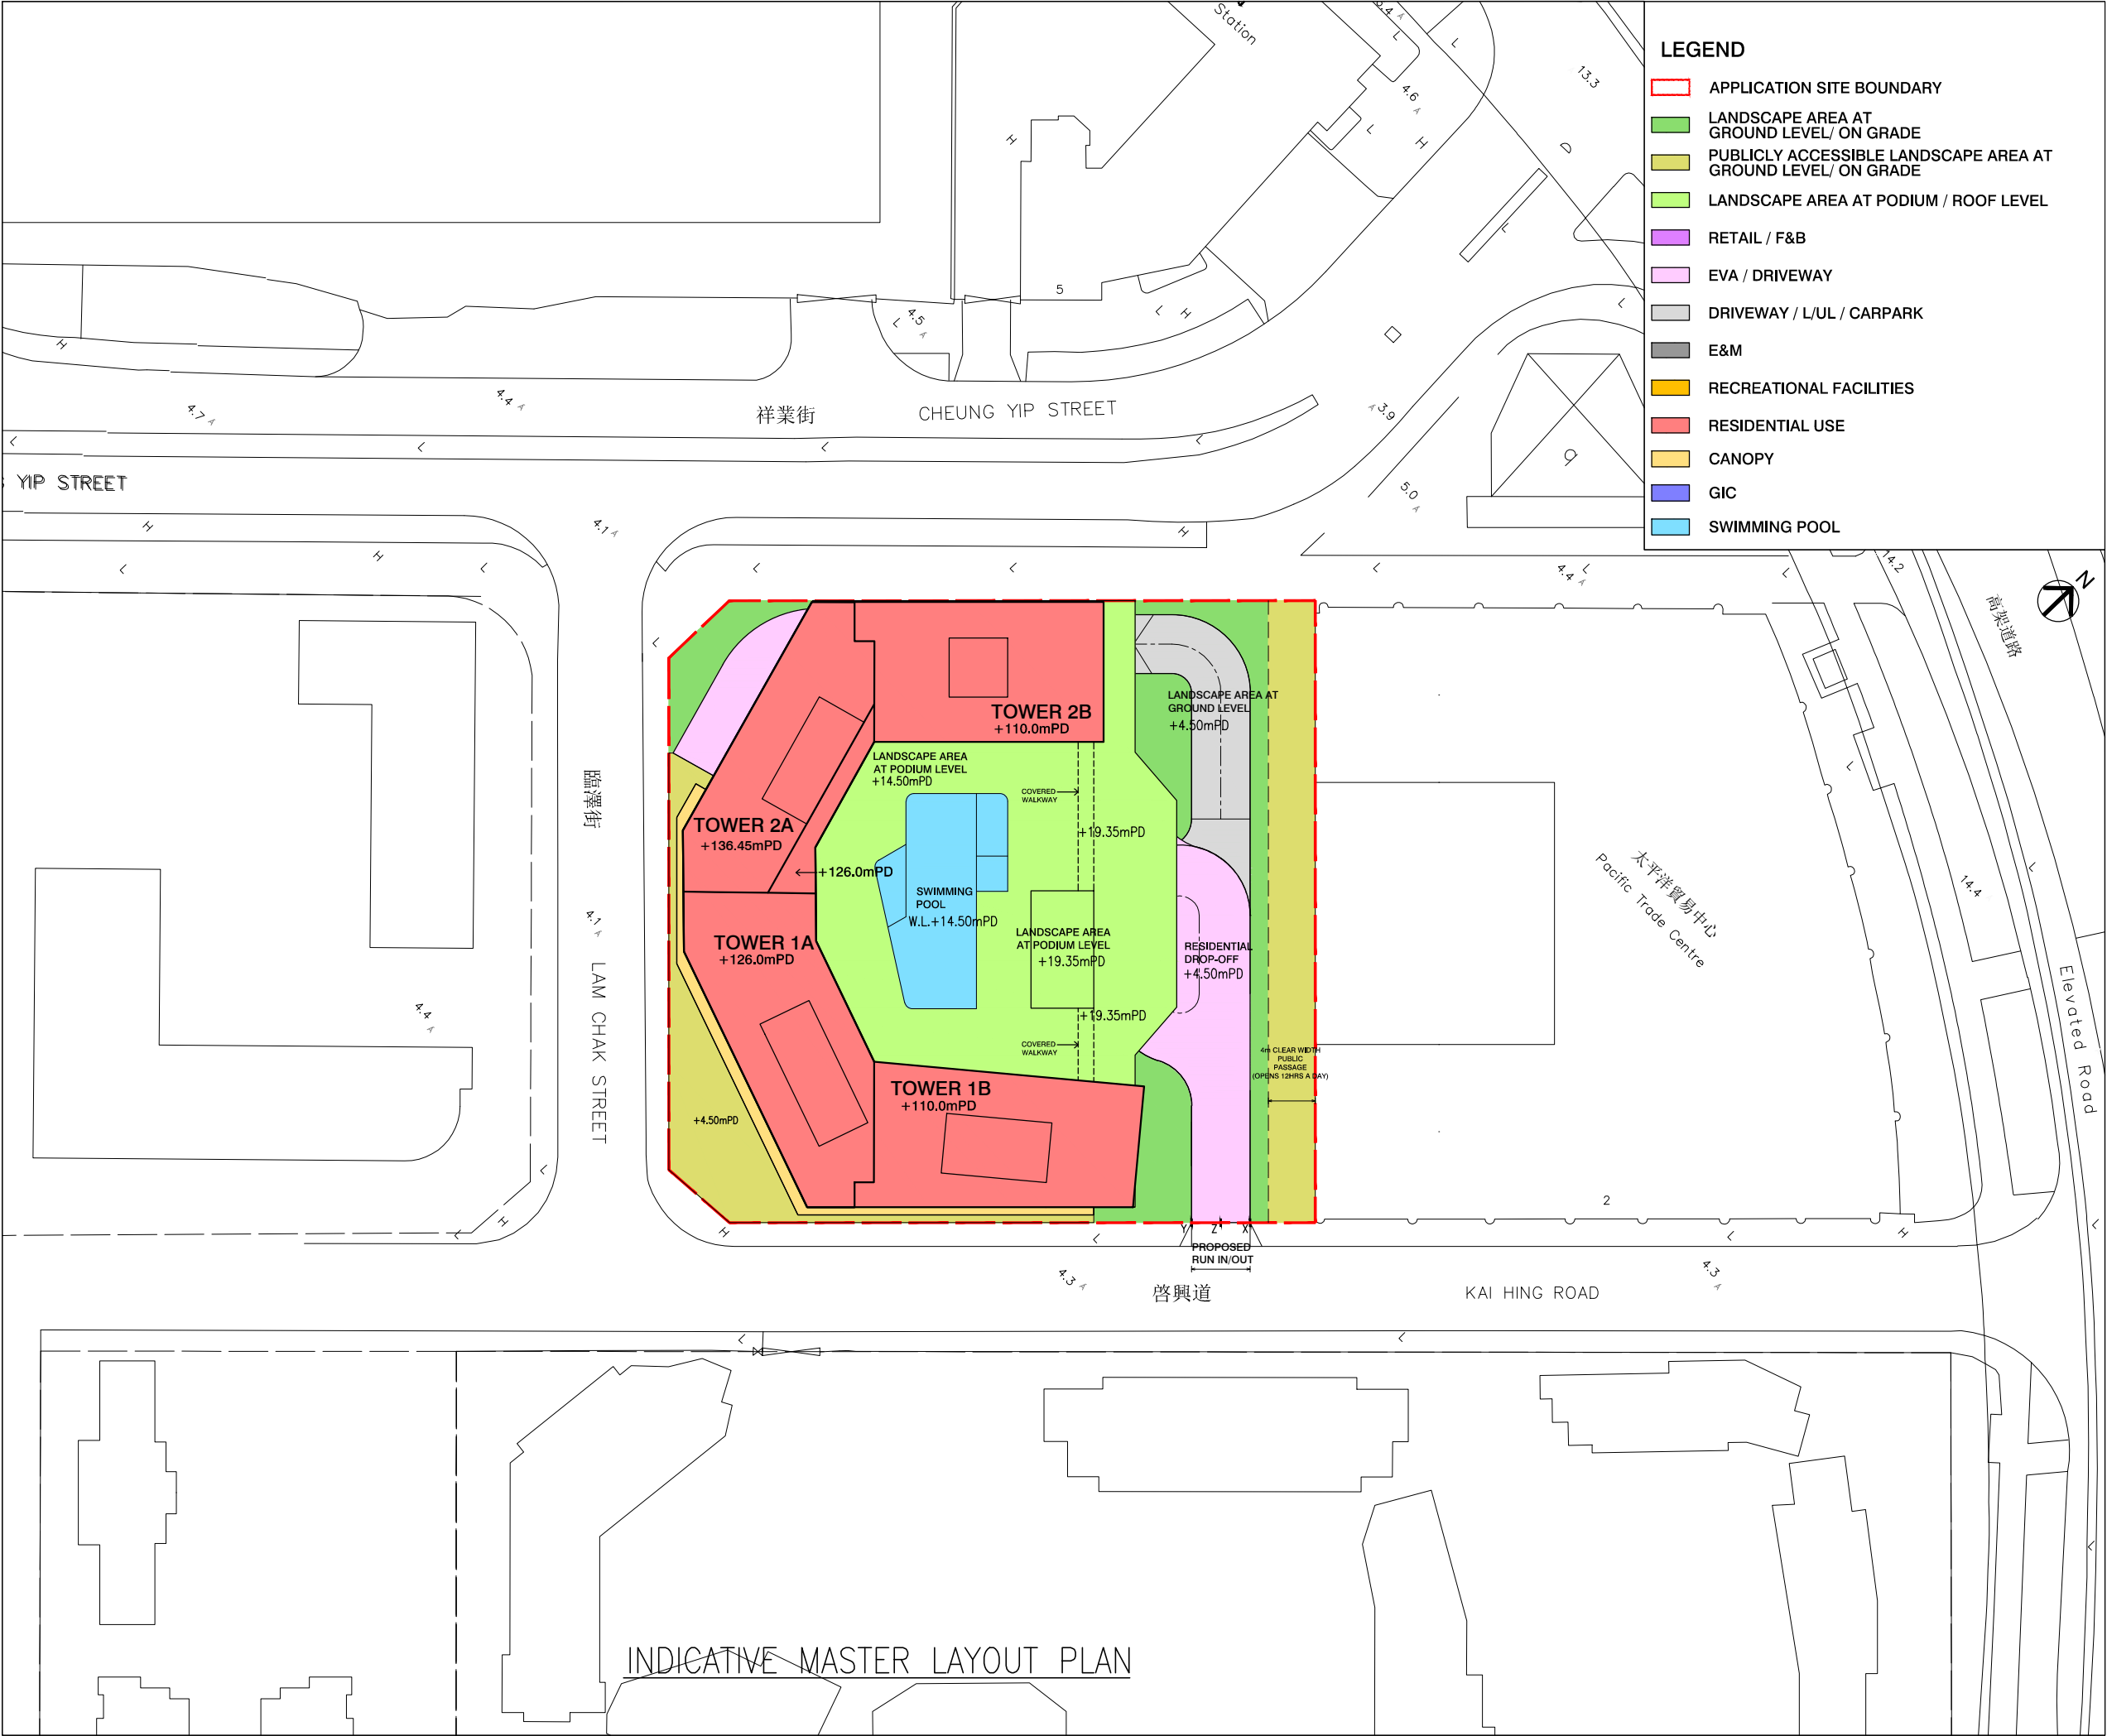


B.D. REFERENCE		屋宇署檔案	
F.S.D. REFERENCE		消防處檔案	
W.W.O. REFERENCE		水務署檔案	
CAD FILE NAME		檔案編號	
NOTES		注釋	
NO. 修定號	REVISIONS 修定內容	DATE 日期	BY 經手人
DLN DLN Architects Limited 劉榮廣伍振民建築師有限公司 46-47 Floor, Tower One, Times Square Matheson Street, Causeway Bay, Hong Kong 香港銅鑼灣勿地申街 時代廣場一座46至47樓 t +852 2695 6888 f +852 2576 4074 email general@dln.com.hk www.dln.com.hk			
ALL MEASUREMENTS MUST BE CHECKED AT THE WORK BY THE CONTRACTOR 所有尺寸應由承建商於工地核實 DO NOT SCALE FROM DRAWINGS 尺寸不應由圖紙直接量度 ALL PRINTS, SPECIFICATIONS AND THEIR COPYRIGHT ARE THE PROPERTY OF THE ARCHITECT AND SHALL BE RETURNED AT THE COMPLETION OF THE WORK 所有印刷、規格說明及所有的版權屬於建築師及應在工程完結後歸還建築師			
PROJECT		項目名稱	
PROPOSED COMPOSITE DEVELOPMENT AT 8 LAM CHAK STREET, KOWLOON – N.K.I.L. 6215			
TITLE		標題	
INDICATIVE MASTER LAYOUT PLAN			
SCALE 1:800(A3)	比例	DATE MAY 2026	日期
DRAWN BY DT	製作人	CHECKED BY –	檢查
JOB NO. N3591–H	工程項目	DRAWING NO. –	圖號

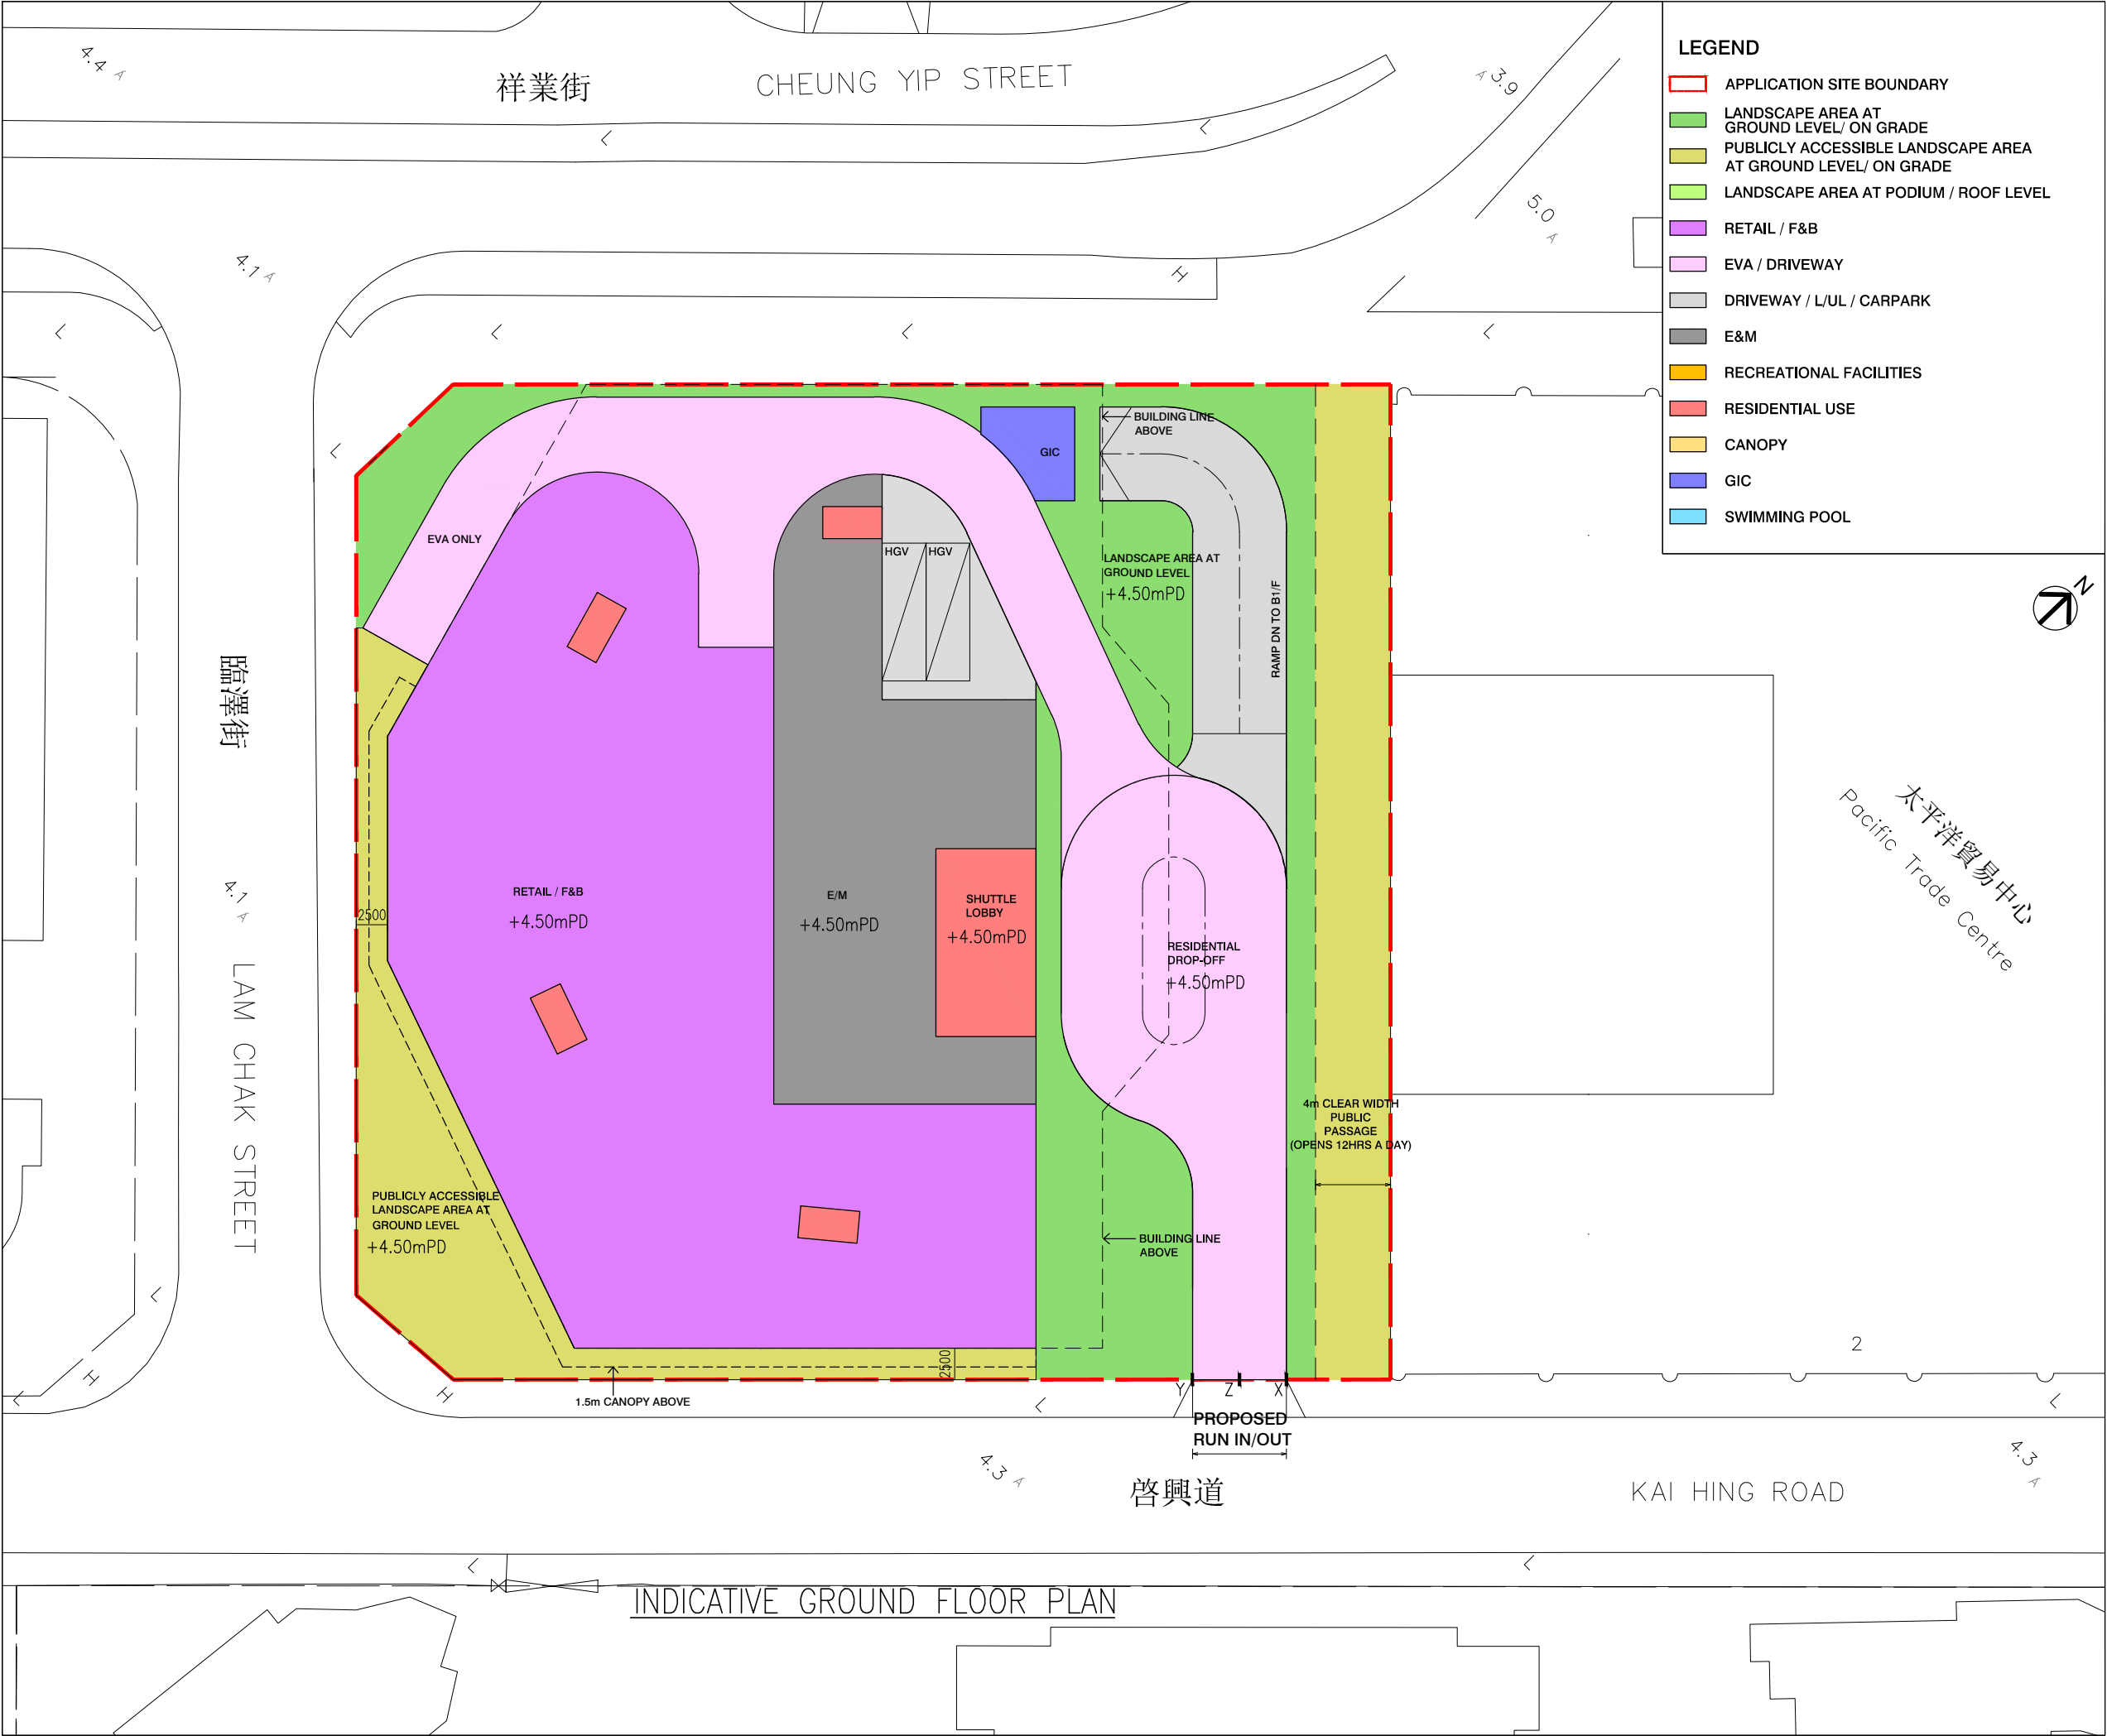


B.D. REFERENCE		屋宇署檔案	
F.S.D. REFERENCE		消防處檔案	
W.W.O. REFERENCE		水務署檔案	
CAD FILE NAME		檔案編號	
NOTES		注釋	
NO. 修定號	REVISIONS 修定內容	DATE 日期	BY 經手人
DLN DLN Architects Limited 劉榮廣伍振民建築師有限公司 46-47 Floor, Tower One, Times Square Matheson Street, Causeway Bay, Hong Kong 香港銅鑼灣勿地臣街 時代廣場一座46至47樓 t +852 2695 6888 f +852 2576 4074 email general@dln.com.hk www.dln.com.hk			
ALL MEASUREMENTS MUST BE CHECKED AT THE WORK BY THE CONTRACTOR 所有尺寸應由承建商於工地核實 DO NOT SCALE FROM DRAWINGS 尺寸不應由圖紙直接量度 ALL PRINTS, SPECIFICATIONS AND THEIR COPYRIGHT ARE THE PROPERTY OF THE ARCHITECT AND SHALL BE RETURNED AT THE COMPLETION OF THE WORK 所有印刷、規格說明及所有的版權屬於建築師及應在工程完結後歸還建築師			
PROJECT		項目名稱	
PROPOSED COMPOSITE DEVELOPMENT AT 8 LAM CHAK STREET, KOWLOON – N.K.I.L. 6215			
TITLE		標題	
INDICATIVE GROUND FLOOR PLAN			
SCALE 1:500(A3)	比例	DATE MAY 2026	日期
DRAWN BY DT	製作人	CHECKED BY –	檢查
JOB NO. N3591–H	工程項目	DRAWING NO. –	圖號

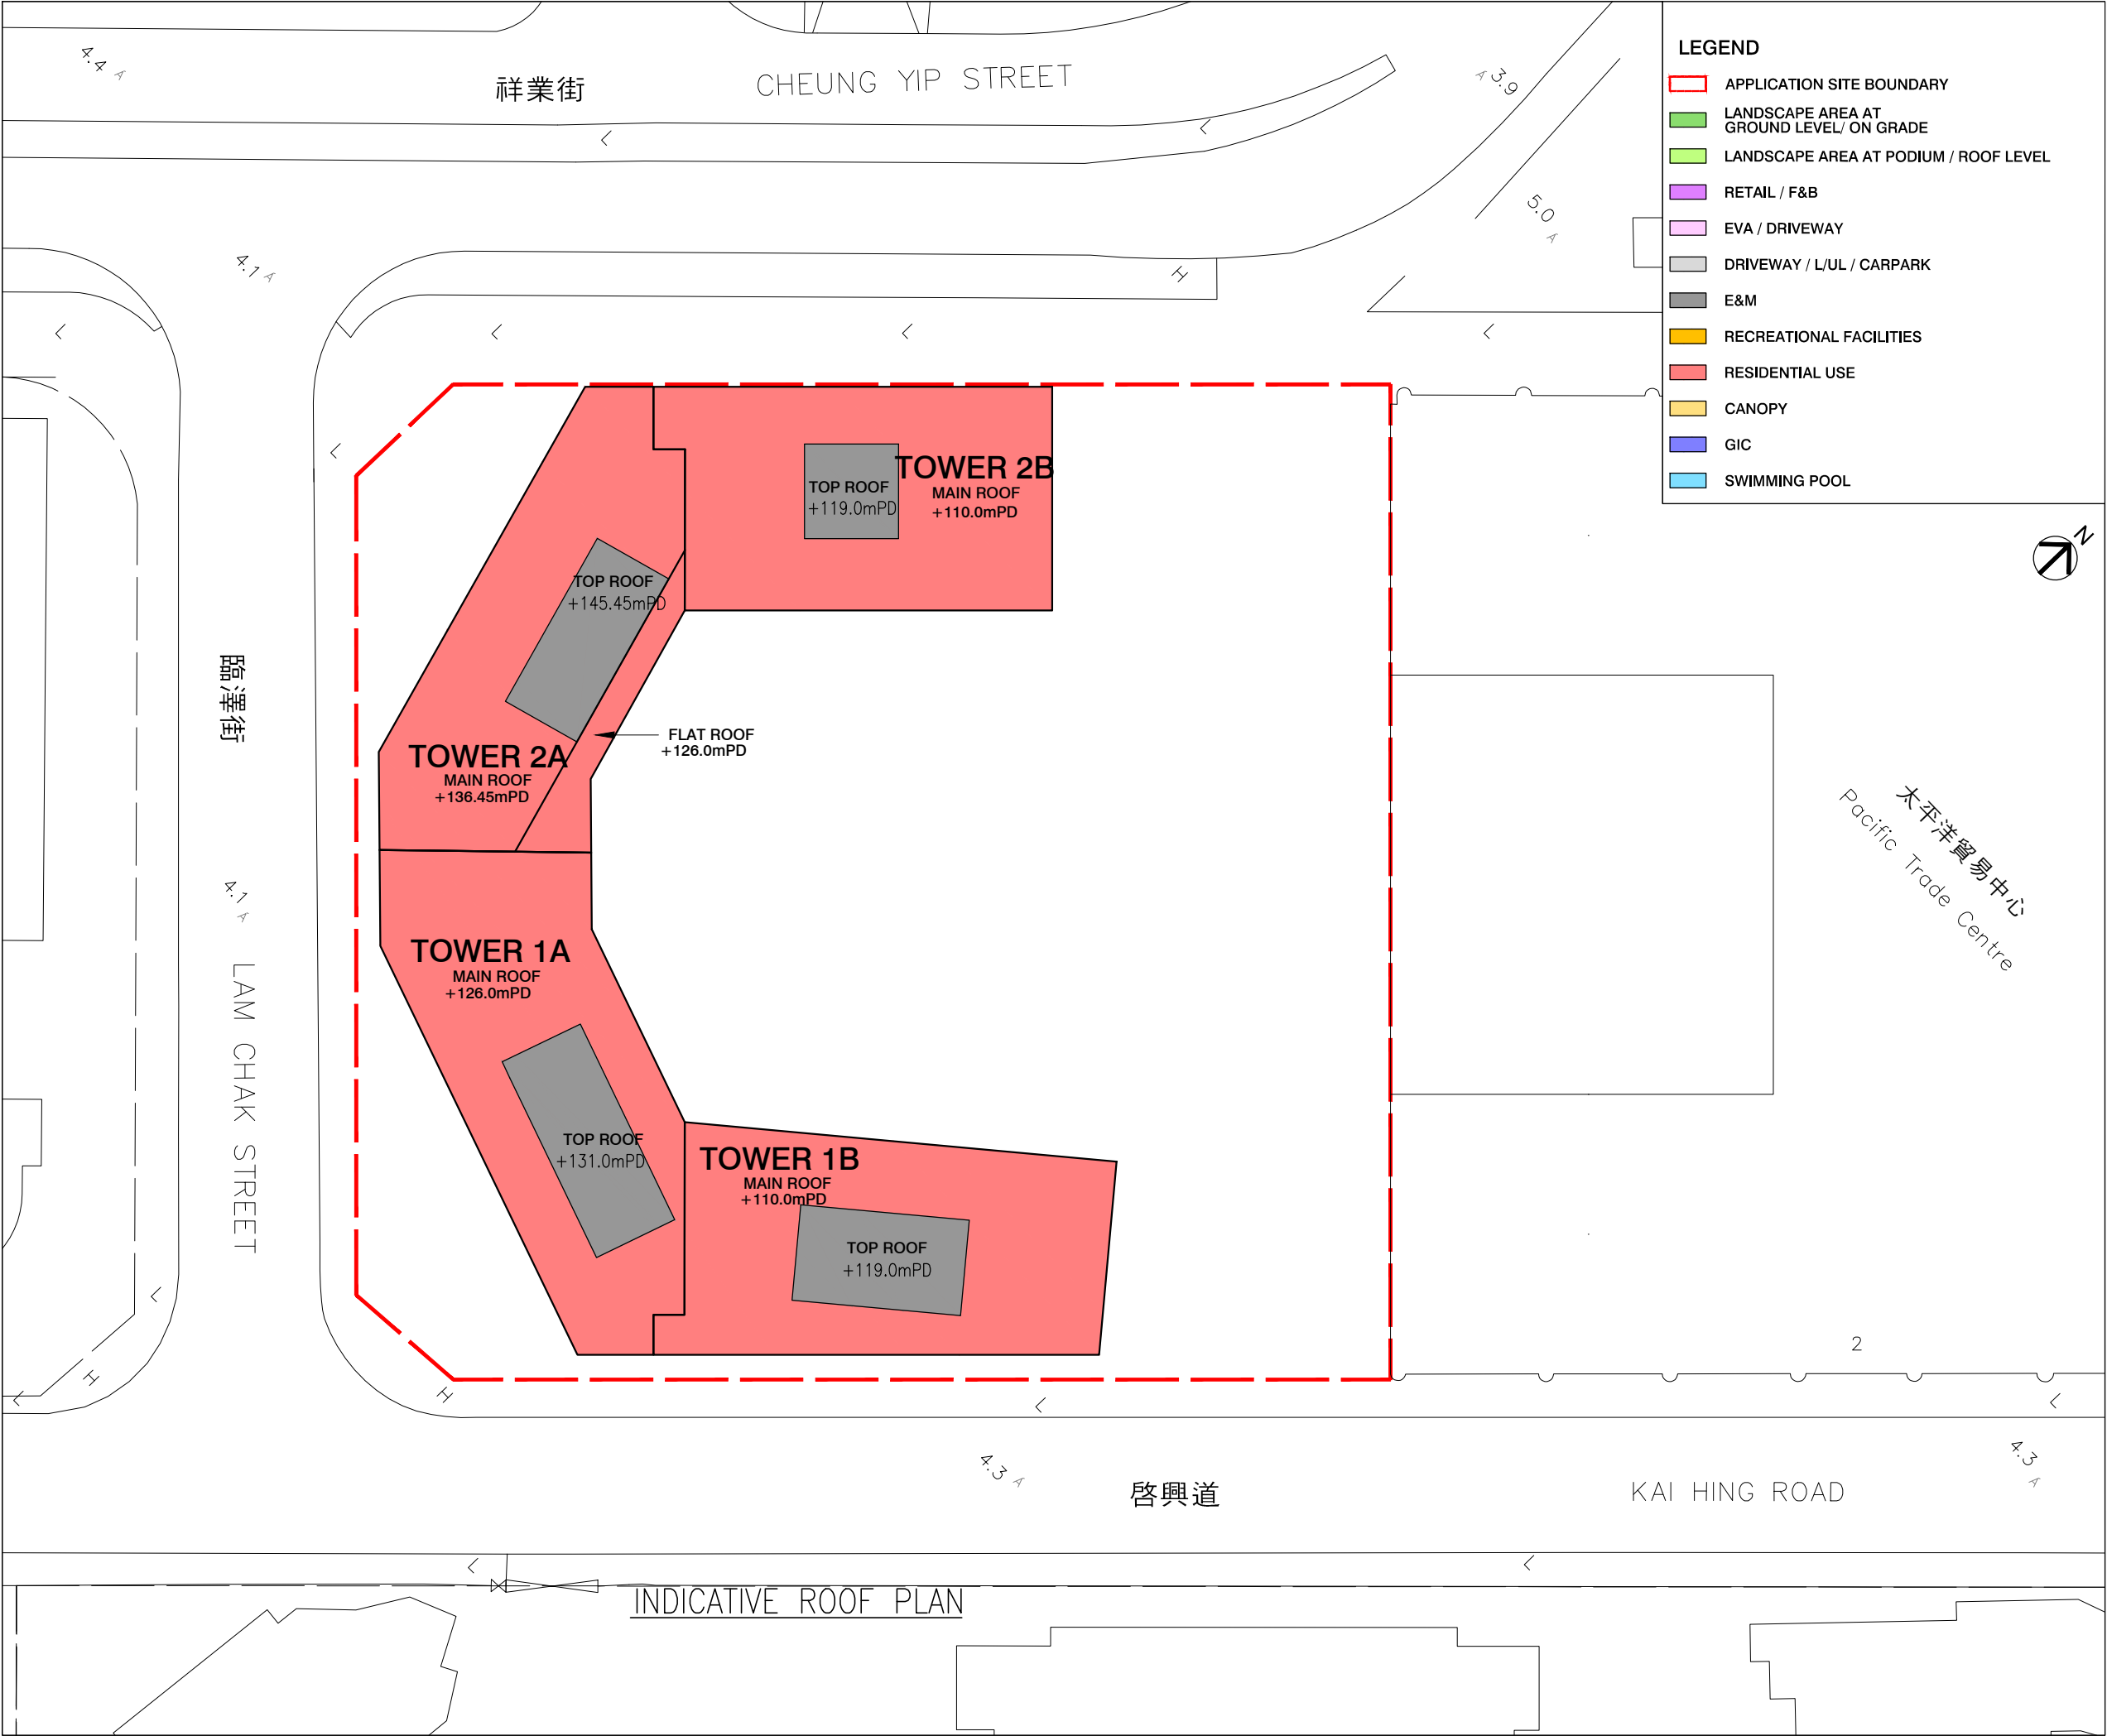

B.D. REFERENCE		屋宇署檔案	
F.S.D. REFERENCE		消防處檔案	
W.W.O. REFERENCE		水務署檔案	
CAD FILE NAME		檔案編號	
NOTES		注釋	
NO. 修定號	REVISIONS 修定內容	DATE 日期	BY 經手人
DLN DLN Architects Limited 劉樂廣伍振民建築師有限公司 46-47 Floor, Tower One, Times Square Matheson Street, Causeway Bay, Hong Kong 香港銅鑼灣勿地臣街 時代廣場一座46至47樓 t +852 2695 6888 f +852 2576 4074 email general@dln.com.hk www.dln.com.hk			
ALL MEASUREMENTS MUST BE CHECKED AT THE WORK BY THE CONTRACTOR 所有尺寸應由承建商於工地核實 DO NOT SCALE FROM DRAWINGS 尺寸不應由圖紙直接量度 ALL PRINTS, SPECIFICATIONS AND THEIR COPYRIGHT ARE THE PROPERTY OF THE ARCHITECT AND SHALL BE RETURNED AT THE COMPLETION OF THE WORK 所有印刷、規格說明及所有的版權屬於建築師及應在工程完結後歸還建築師			
PROJECT		項目名稱	
PROPOSED COMPOSITE DEVELOPMENT AT 8 LAM CHAK STREET, KOWLOON – N.K.I.L. 6215			
TITLE		標題	
INDICATIVE ROOF FLOOR PLAN			
SCALE 1:500(A3)	比例	DATE MAY 2026	日期
DRAWN BY DT	製作人	CHECKED BY –	檢查
JOB NO. N3591–H	工程項目	DRAWING NO. –	圖號

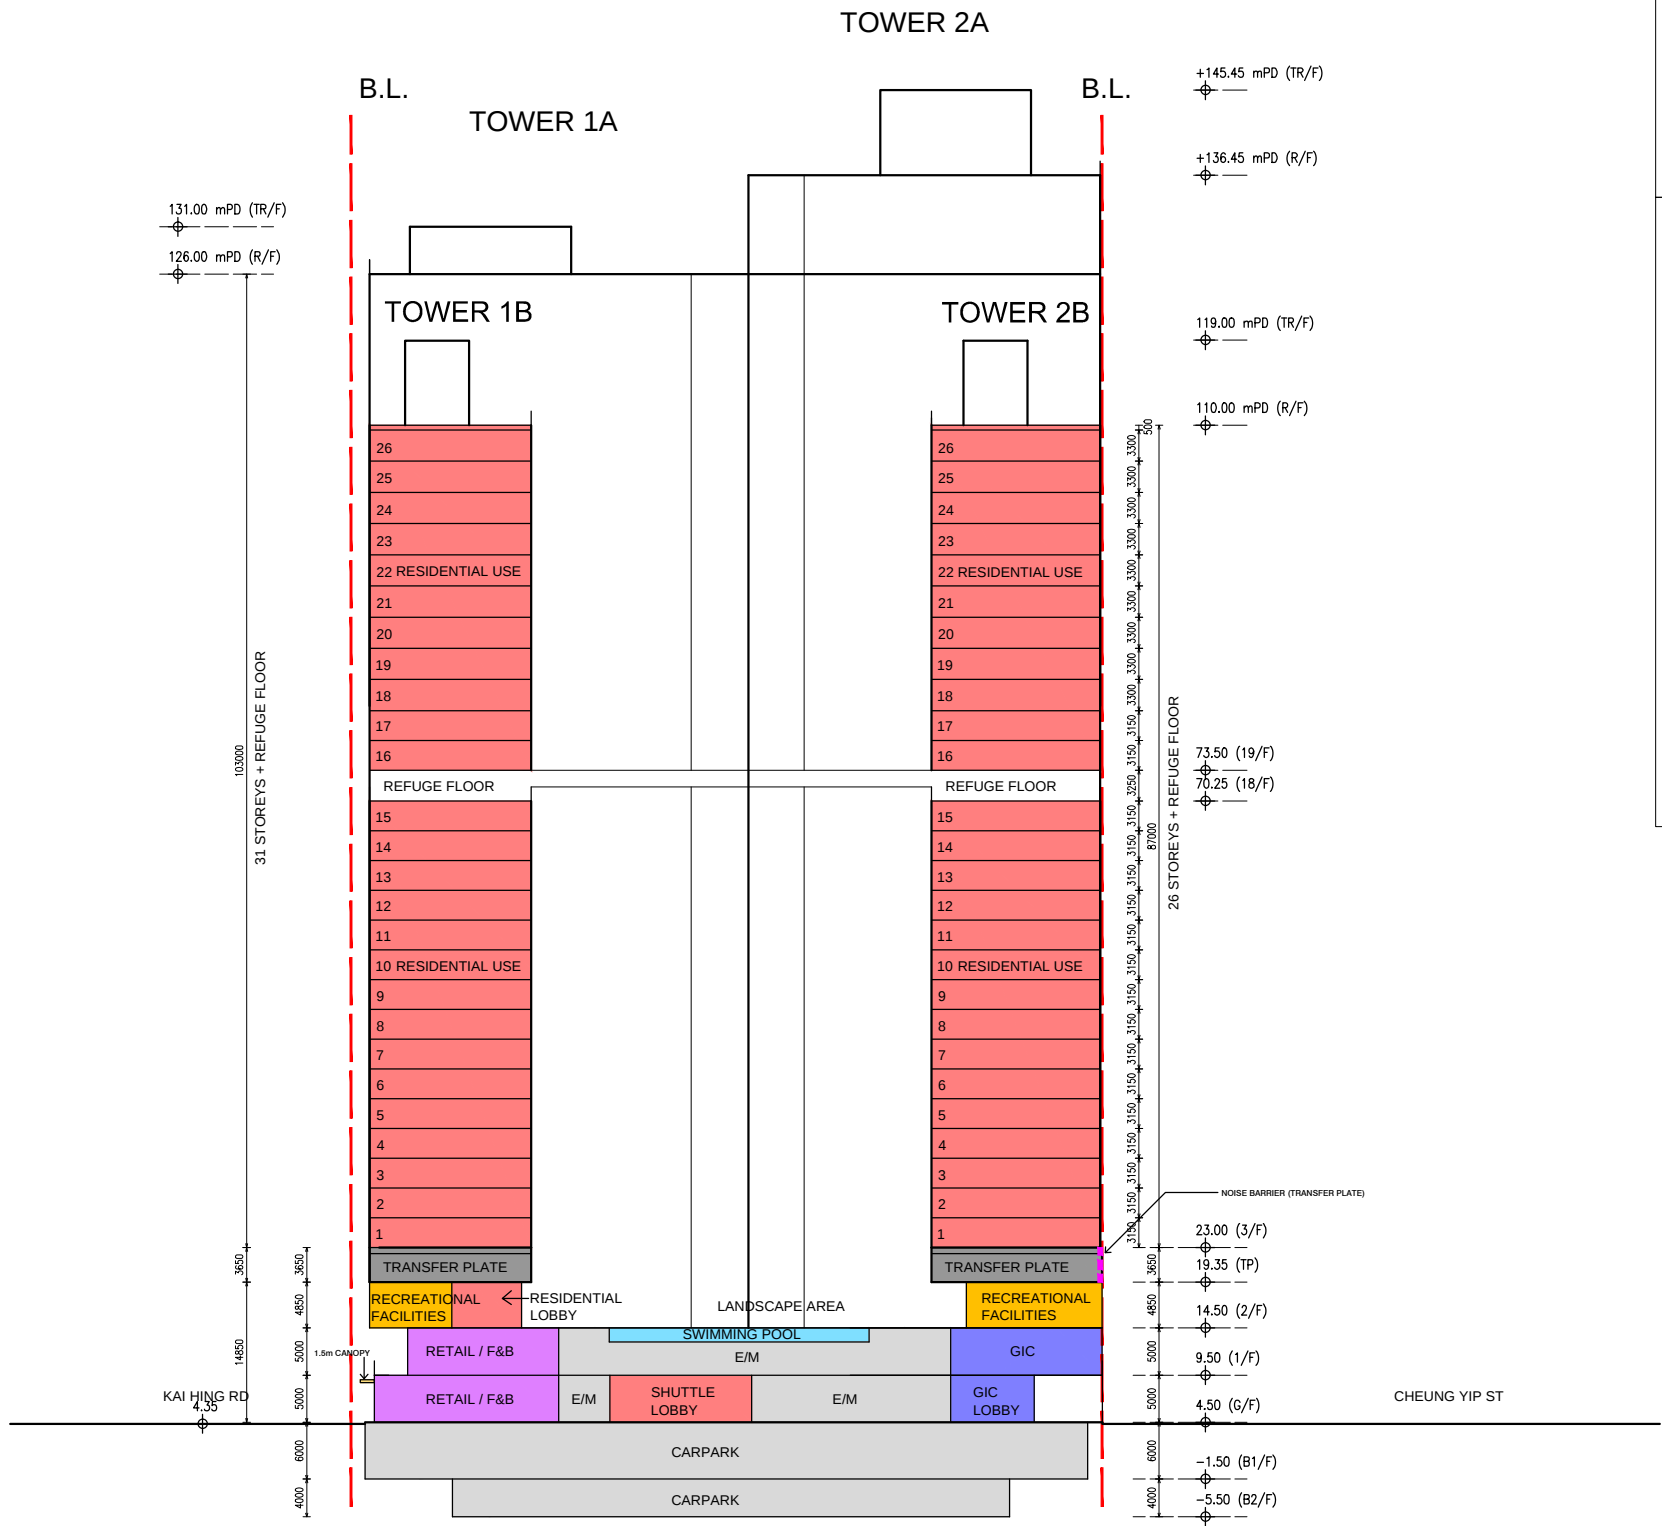

KEY PLAN

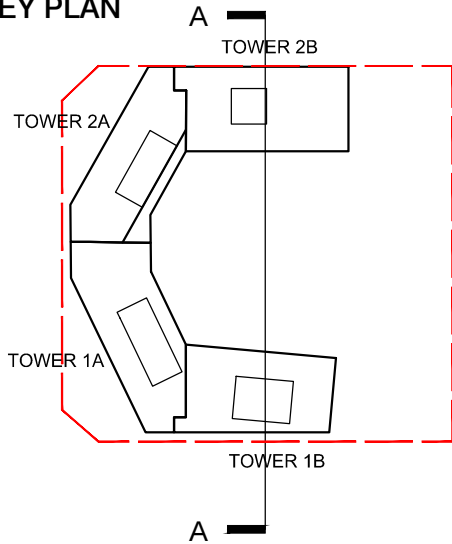

LEGEND

- APPLICATION SITE BOUNDARY
- LANDSCAPE AREA AT GROUND LEVEL/ ON GRADE
- LANDSCAPE AREA AT PODIUM / ROOF LEVEL
- RETAIL / F&B
- EVA / DRIVEWAY
- DRIVEWAY / L/UL / CARPARK
- E&M
- RECREATIONAL FACILITIES
- RESIDENTIAL USE
- CANOPY
- GIC
- SWIMMING POOL

B.D. REFERENCE		屋宇署檔案	
F.S.D. REFERENCE		消防處檔案	
W.W.O. REFERENCE		水務署檔案	
CAD FILE NAME		檔案編號	
NOTES		注釋	
NO. 修定號	REVISIONS 修定內容	DATE 日期	BY 經手人

DLN

DLN Architects Limited
劉樂廣伍振民建築師有限公司


46-47 Floor, Tower One, Times Square
Matheson Street, Causeway Bay, Hong Kong
香港銅鑼灣勿地臣街
時代廣場一座46至47樓
t +852 2695 6888 f +852 2576 4074
email general@dln.com.hk www.dln.com.hk

ALL MEASUREMENTS MUST BE CHECKED AT THE WORK BY THE CONTRACTOR
所有尺寸應由承建商於工地核實
DO NOT SCALE FROM DRAWINGS 尺寸不應由圖紙直接量度
ALL PRINTS, SPECIFICATIONS AND THEIR COPYRIGHT ARE THE PROPERTY OF
THE ARCHITECT AND SHALL BE RETURNED AT THE COMPLETION OF THE WORK
所有印刷, 規格說明及所有的版權屬於建築師及應在工程完結後歸還建築師


PROJECT	項目名稱
PROPOSED COMPOSITE DEVELOPMENT AT 8 LAM CHAK STREET, KOWLOON - N.K.I.L. 6215	

TITLE	標題
INDICATIVE SECTION A-A	

SCALE 1:800(A3)	比例	DATE MAY 2026	日期
DRAWN BY DT	製作人	CHECKED BY -	檢查
JOB NO. N3591-H	工程項目	DRAWING NO. -	圖號

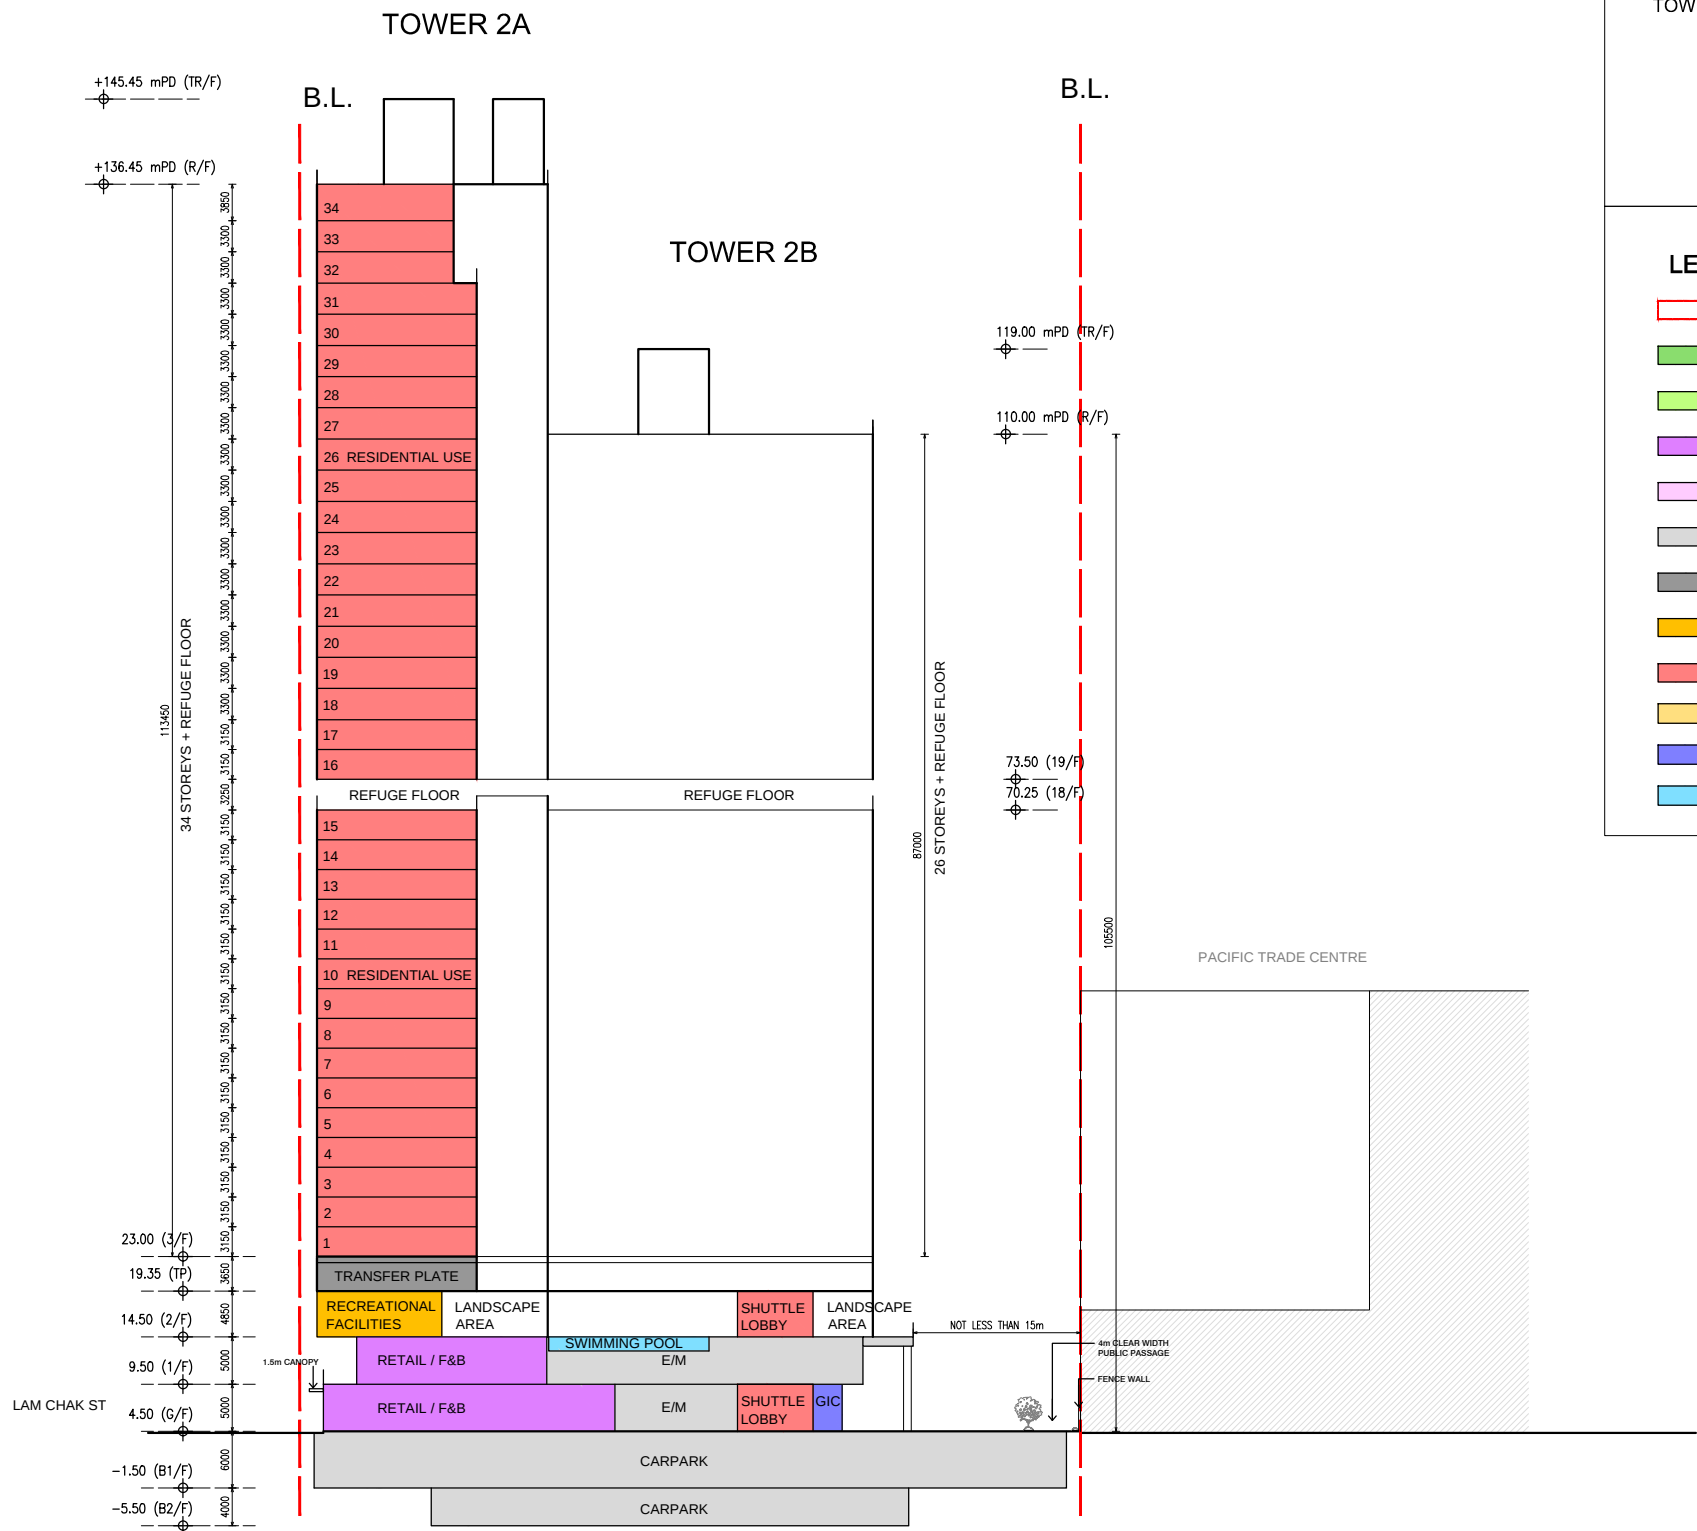


KEY PLAN

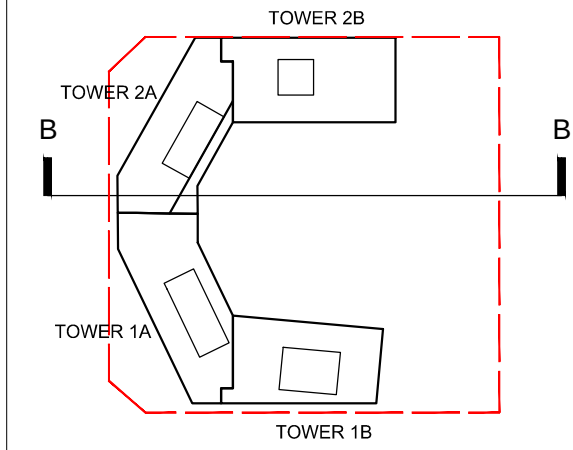


LEGEND

- APPLICATION SITE BOUNDARY
- LANDSCAPE AREA AT GROUND LEVEL/ ON GRADE
- LANDSCAPE AREA AT PODIUM / ROOF LEVEL
- RETAIL / F&B
- EVA / DRIVEWAY
- DRIVEWAY / L/UL / CARPARK
- E&M
- RECREATIONAL FACILITIES
- RESIDENTIAL USE
- CANOPY
- GIC
- SWIMMING POOL

B.D. REFERENCE		屋宇署檔案	
F.S.D. REFERENCE		消防處檔案	
W.W.O. REFERENCE		水務署檔案	
CAD FILE NAME		檔案編號	
NOTES		注釋	
NO. 修定號	REVISIONS 修定內容	DATE 日期	BY 經手人
DLN DLN Architects Limited 劉樂廣伍振民建築師有限公司 46-47 Floor, Tower One, Times Square Matheson Street, Causeway Bay, Hong Kong 香港銅鑼灣勿地申街 時代廣場一座46至47樓 t +852 2895 6888 f +852 2576 4074 email general@dln.com.hk www.dln.com.hk			
ALL MEASUREMENTS MUST BE CHECKED AT THE WORK BY THE CONTRACTOR 所有尺寸應由承建商於工地核實 DO NOT SCALE FROM DRAWINGS 尺寸不應由圖紙直接量度 ALL PRINTS, SPECIFICATIONS AND THEIR COPYRIGHT ARE THE PROPERTY OF THE ARCHITECT AND SHALL BE RETURNED AT THE COMPLETION OF THE WORK 所有印刷, 規格說明及所有的版權屬於建築師及應在工程完結後歸還建築師			
PROJECT		項目名稱	
PROPOSED COMPOSITE DEVELOPMENT AT 8 LAM CHAK STREET, KOWLOON - N.K.I.L. 6215			
TITLE		標題	
INDICATIVE SECTION B-B			
SCALE 1:800(A3)	比例	DATE MAY 2026	日期
DRAWN BY DT	製作人	CHECKED BY -	檢查
JOB NO. N3591-H	工程項目	DRAWING NO. -	圖號

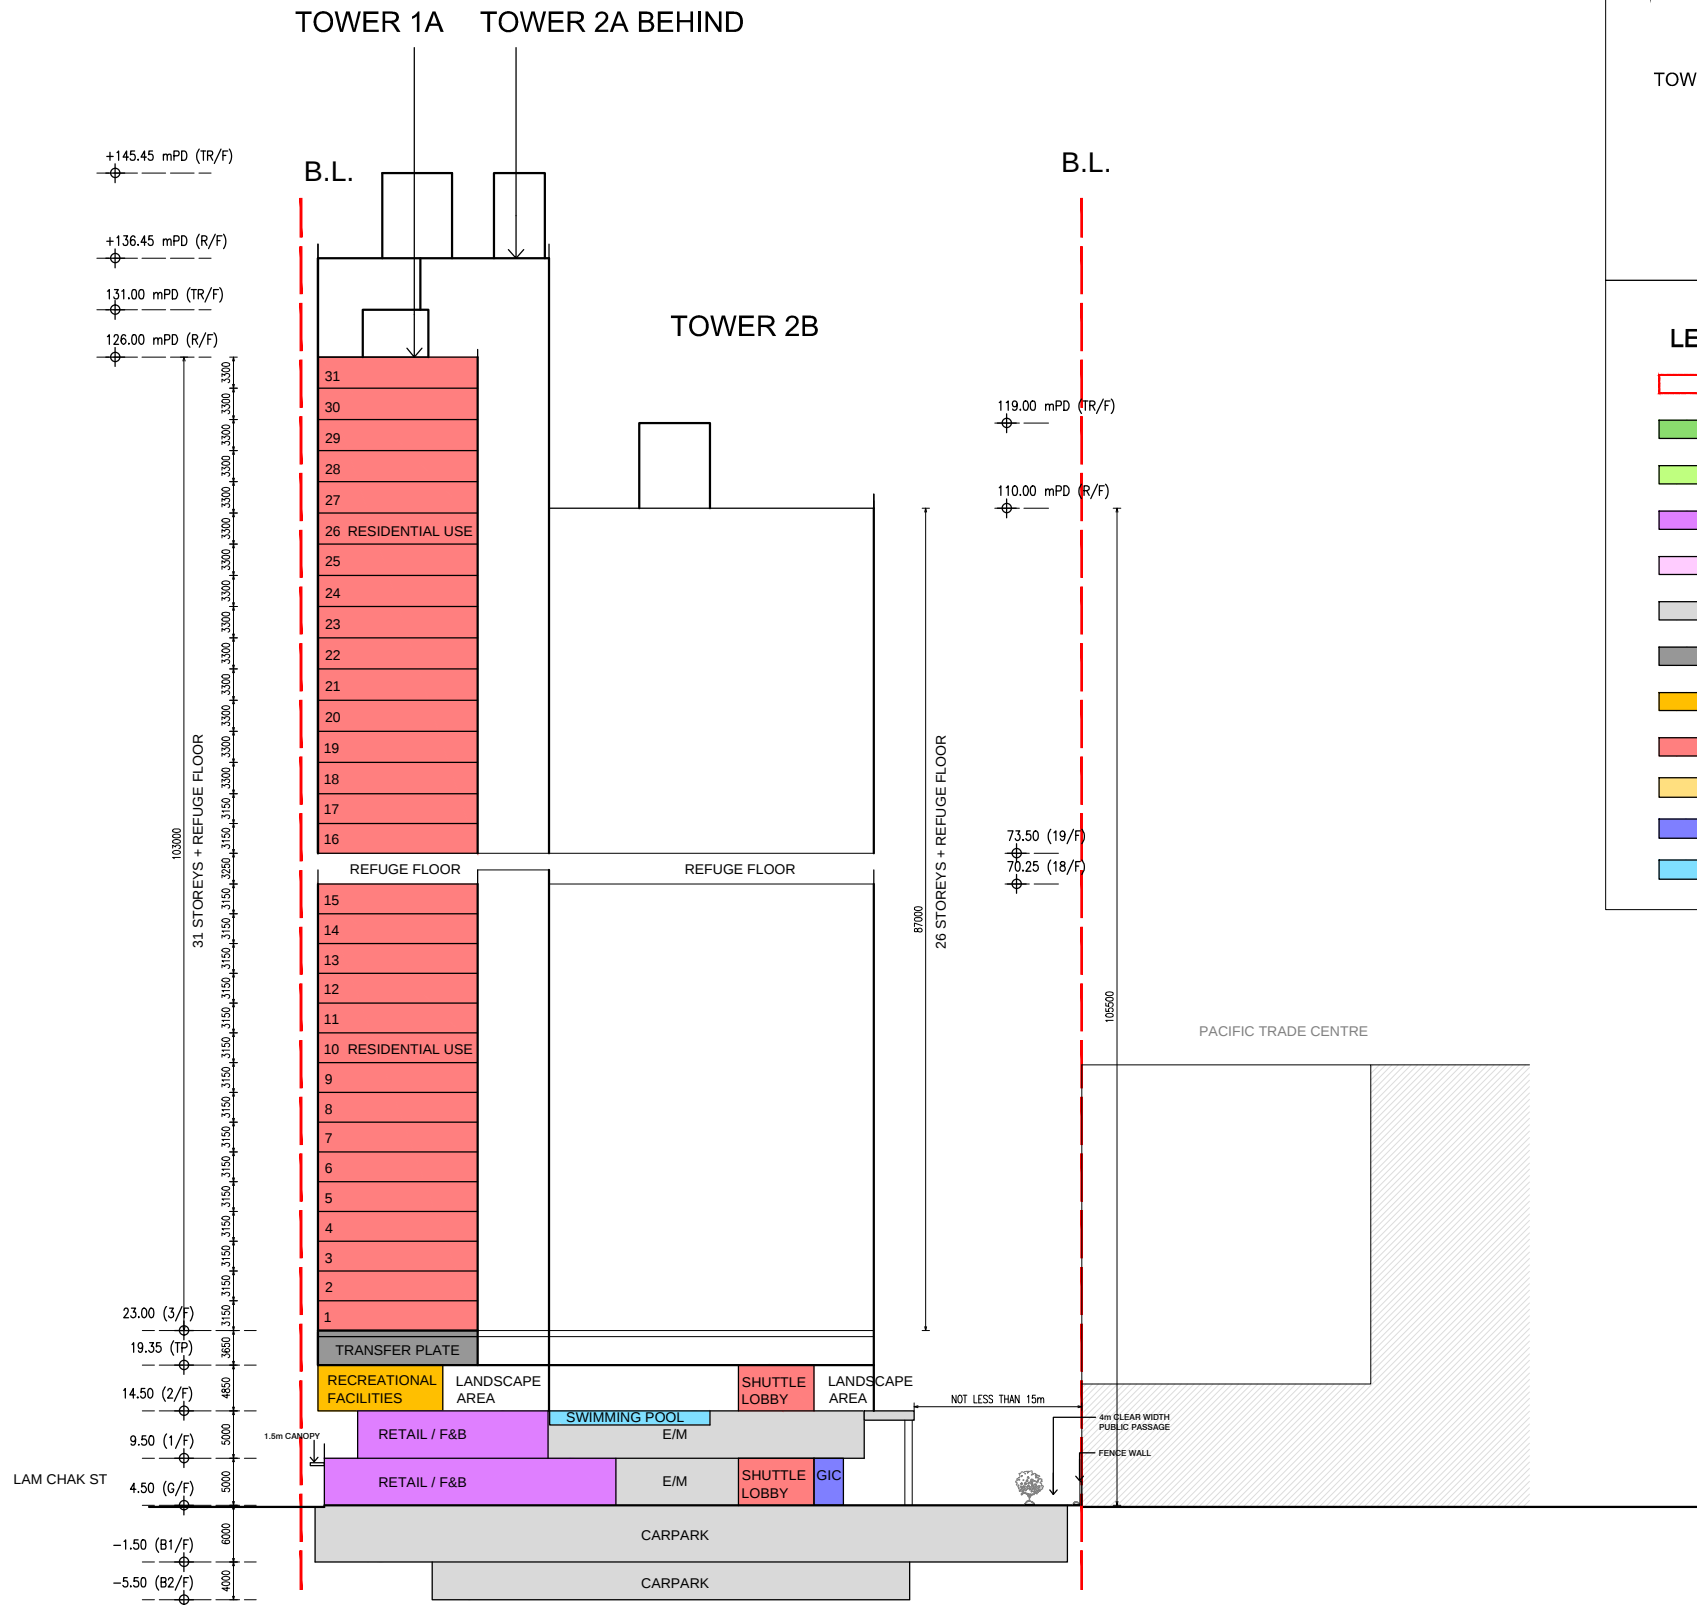

KEY PLAN

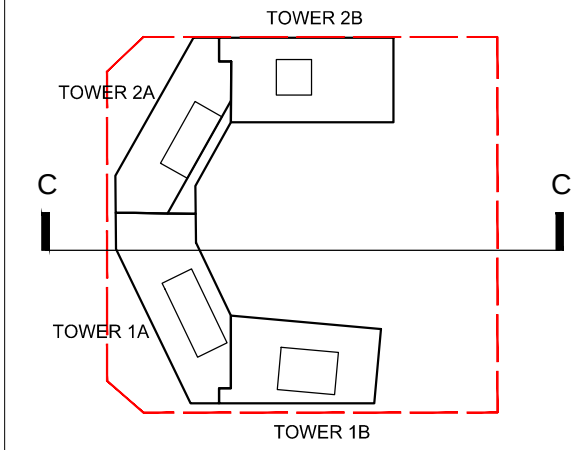

LEGEND

- APPLICATION SITE BOUNDARY
- LANDSCAPE AREA AT GROUND LEVEL/ ON GRADE
- LANDSCAPE AREA AT PODIUM / ROOF LEVEL
- RETAIL / F&B
- EVA / DRIVEWAY
- DRIVEWAY / L/UL / CARPARK
- E&M
- RECREATIONAL FACILITIES
- RESIDENTIAL USE
- CANOPY
- GIC
- SWIMMING POOL

B.D. REFERENCE		屋宇署檔案	
F.S.D. REFERENCE		消防處檔案	
W.W.O. REFERENCE		水務署檔案	
CAD FILE NAME		檔案編號	
NOTES		注釋	
NO. 修定號	REVISIONS 修定內容	DATE 日期	BY 經手人
DLN DLN Architects Limited 劉榮廣伍振民建築師有限公司 46-47 Floor, Tower One, Times Square Matheson Street, Causeway Bay, Hong Kong 香港銅鑼灣勿地臣街 時代廣場一座46至47樓 t +852 2695 6888 f +852 2576 4074 email general@dln.com.hk www.dln.com.hk			
ALL MEASUREMENTS MUST BE CHECKED AT THE WORK BY THE CONTRACTOR 所有尺寸應由承建商於工地核實 DO NOT SCALE FROM DRAWINGS 尺寸不應由圖紙直接量度 ALL PRINTS, SPECIFICATIONS AND THEIR COPYRIGHT ARE THE PROPERTY OF THE ARCHITECT AND SHALL BE RETURNED AT THE COMPLETION OF THE WORK 所有印刷、規格說明及所有的版權屬於建築師及應在工程完結後歸還建築師			
PROJECT		項目名稱	
PROPOSED COMPOSITE DEVELOPMENT AT 8 LAM CHAK STREET, KOWLOON - N.K.I.L. 6215			
TITLE		標題	
INDICATIVE SECTION C-C			
SCALE 1:800(A3)	比例	DATE MAY 2026	日期
DRAWN BY DT	製作人	CHECKED BY -	檢查
JOB NO. N3591-H	工程項目	DRAWING NO. -	圖號