

Appendix 1

Architectural Drawings



Legend

P = Private Car Parking Spaces

M = Motorcycle Parking Spaces

L = Loading and Unloading Bay

DLN

DLN Architects Limited 46-47 Floor, Tower One, Times Square
劉榮廣伍振民建築師有限公司 Matheson Street, Causeway Bay, Hong Kong
 香港銅鑼灣勿地臣街
 時代廣場一座46至47樓
 t +852 2895 6888 f +852 2576 4074 email general@dlh.com.hk www.dln.com.hk

ALL MEASUREMENTS MUST BE CHECKED AT THE WORK BY THE CONTRACTOR
所有尺寸應由承建商於工地核實

DO NOT SCALE FROM DRAWINGS 尺寸不應由圖紙直接量度

ALL PRINTS, SPECIFICATIONS AND THEIR COPYRIGHT ARE THE PROPERTY OF THE ARCHITECT AND SHALL BE RETURNED AT THE COMPLETION OF THE WORK
所有印刷、規格說明及所有的版權屬於建築師及應在工程完結後歸還建築師

 
PROJECT	項目名稱
REVITALISATION OF FORMER NORTH KOWLOON MAGISTRACY INTO NK FUTURE – JUDICIAL EDUCATION CENTRE, NO.292 TAI PO ROAD, SHAM SHUI PO, KOWLOON	

DRAWING TITLE	標題
---------------	----

BLOCK PLAN & E.V.A. PLAN

SCALE	比例	DATE	日期
1:250(A1)		2025-6	
DRAWN BY 製作人	CHECKED BY		檢查
SZ			
JOB NO. 工程項目	DRAWING NO.		圖號
N3484-H	G-2		

SCALE 比例	DATE	日期
1:100(A1)	2025-6	
DRAWN BY 製作人	CHECKED BY	檢查
SZ		
JOB NO. 工程項目	DRAWING NO.	圖號
N3484-H	G-4	




DLN


DLN Architects Limited
劉景廣伍振民建築師有限公司

46-47 Floor, Tower One, Times Square
Matheson Street, Causeway Bay, Hong Kong
香港銅鑼灣勿地臣街
時代廣場一座46至47樓
email: general@dln.com.hk www.dln.com.hk


PROJECT	項目名稱
REVITALISATION OF FORMER NORTH KOWLOON MAGISTRACY INTO NK FUTURE – JUDICIAL EDUCATION CENTRE, NO.292 TAI PO ROAD, SHAM SHUI PO, KOWLOON	

SCALE 比例 1:100(A1)	DATE 2025-6	日期
DRAWN BY 製作人 SZ	CHECKED BY	檢查
JOB NO. 工程項目 N3484-H	DRAWING NO. G-5	圖號

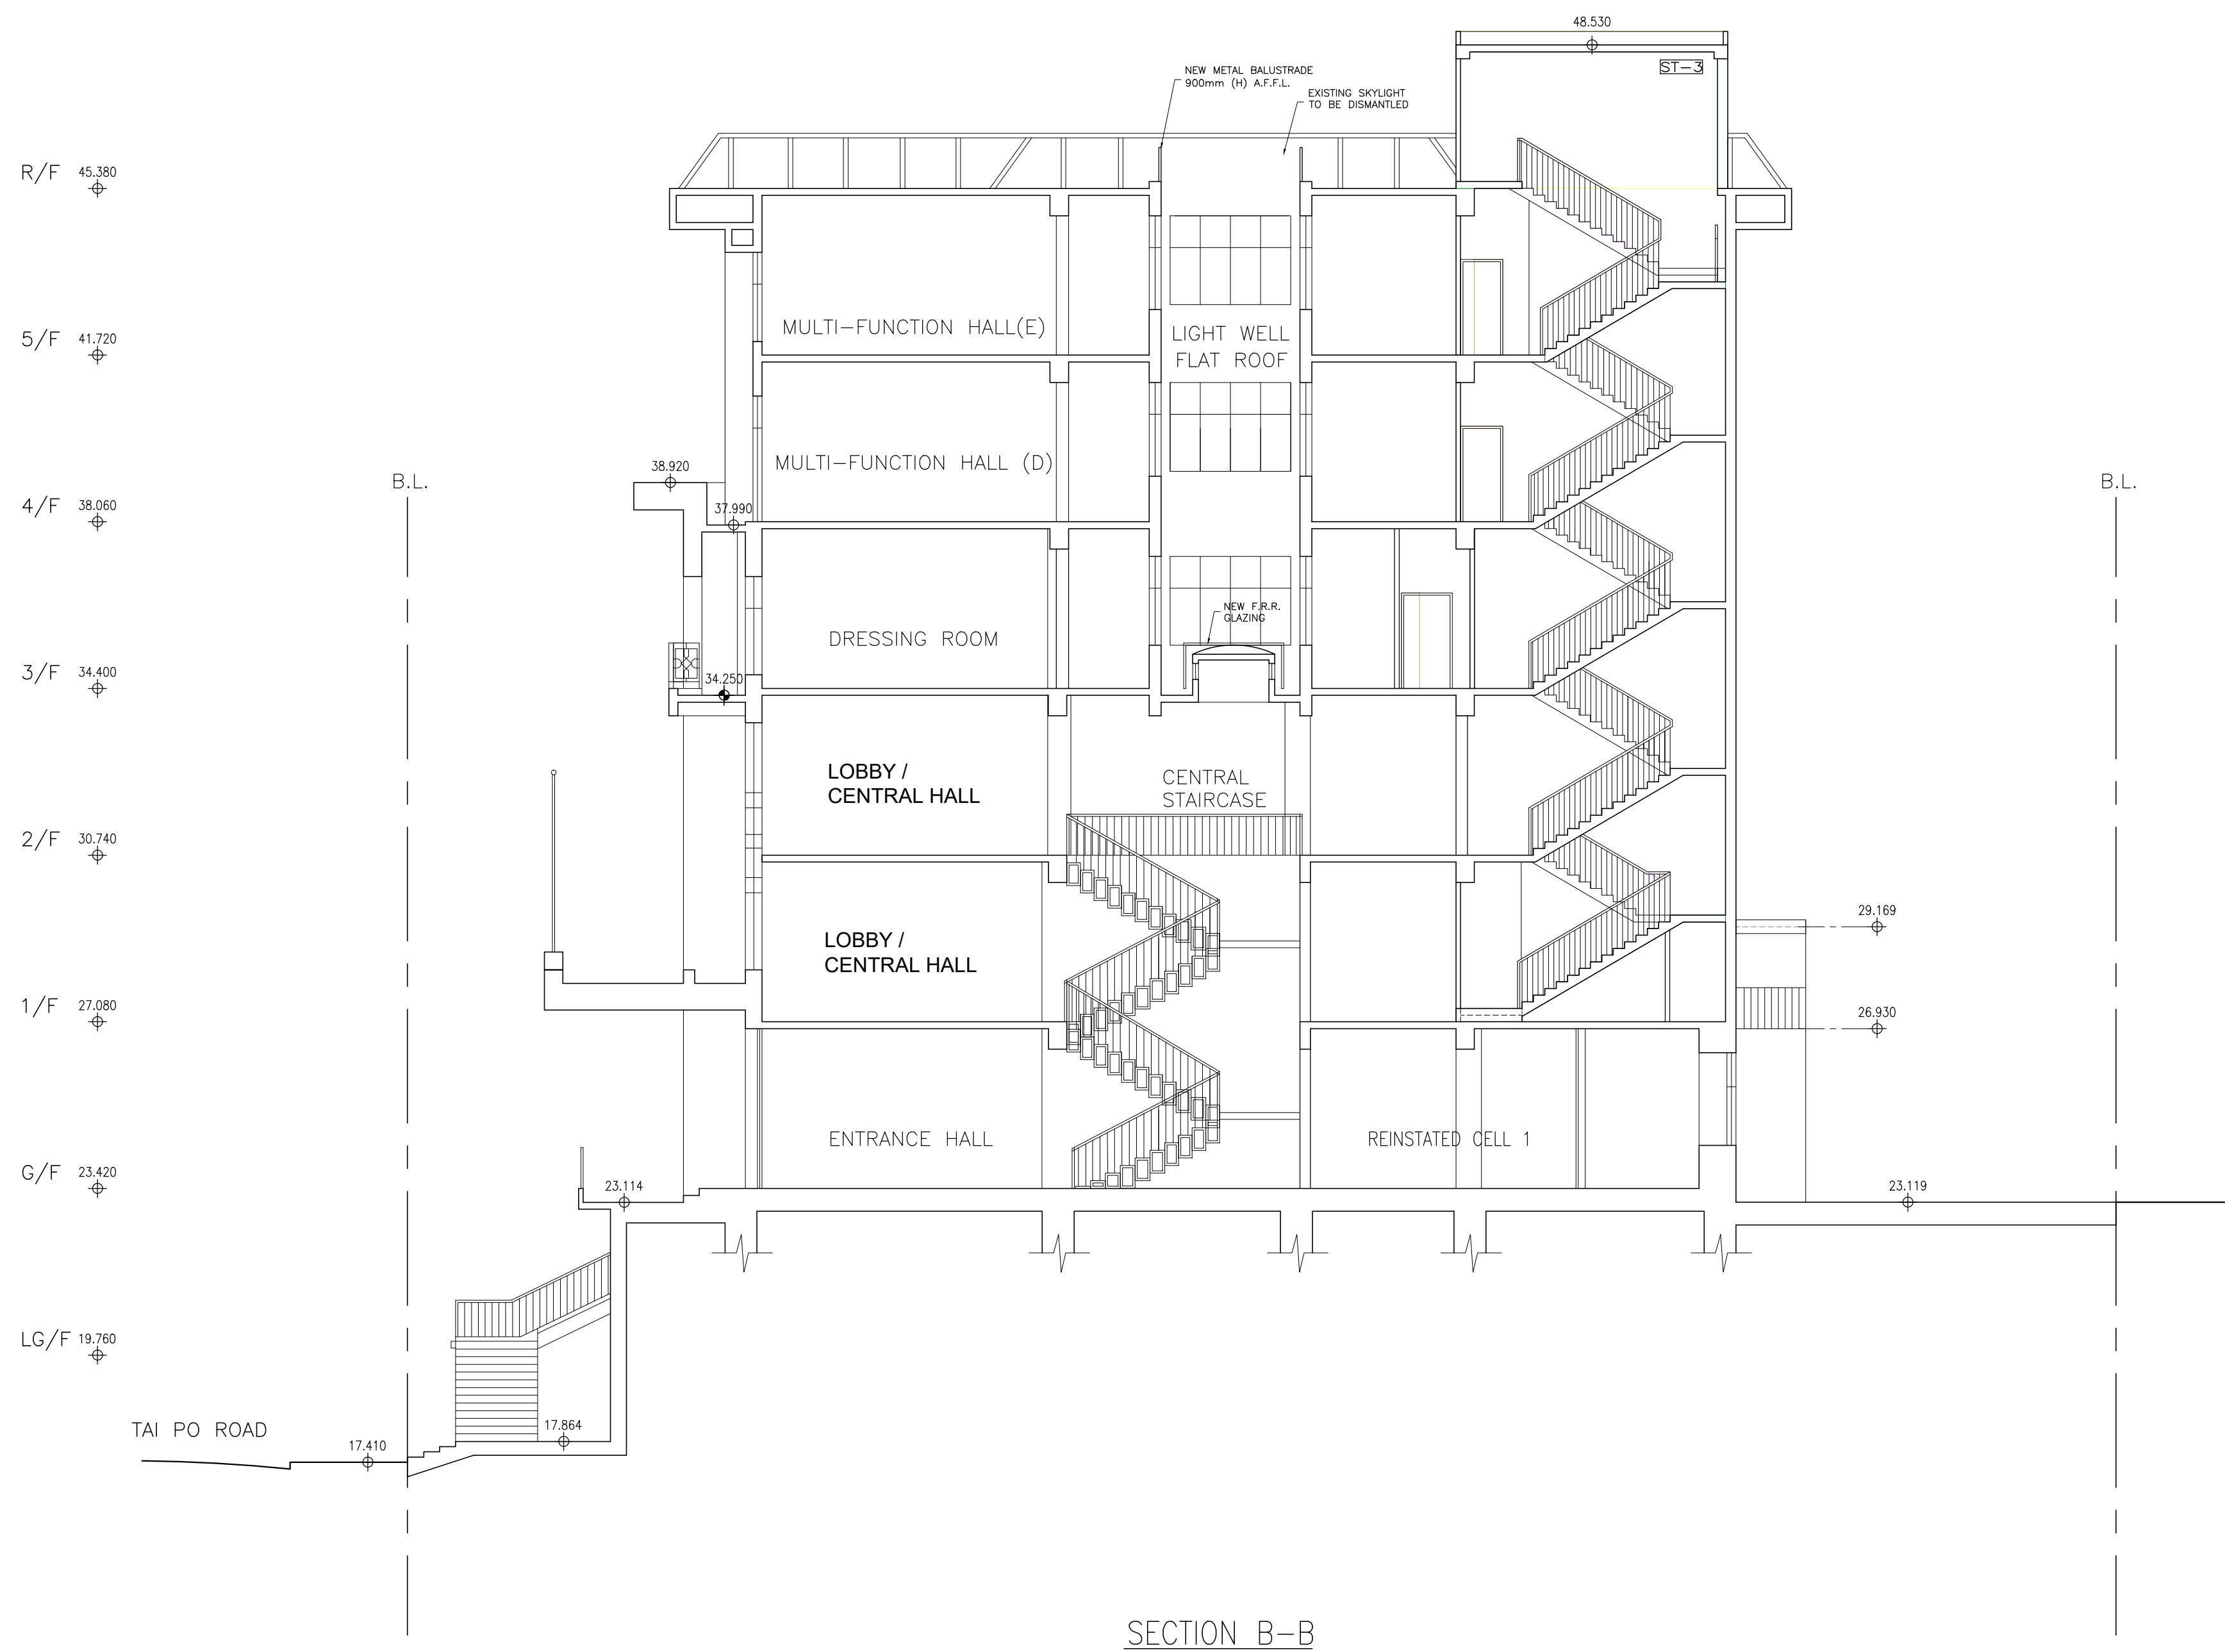[illegible]

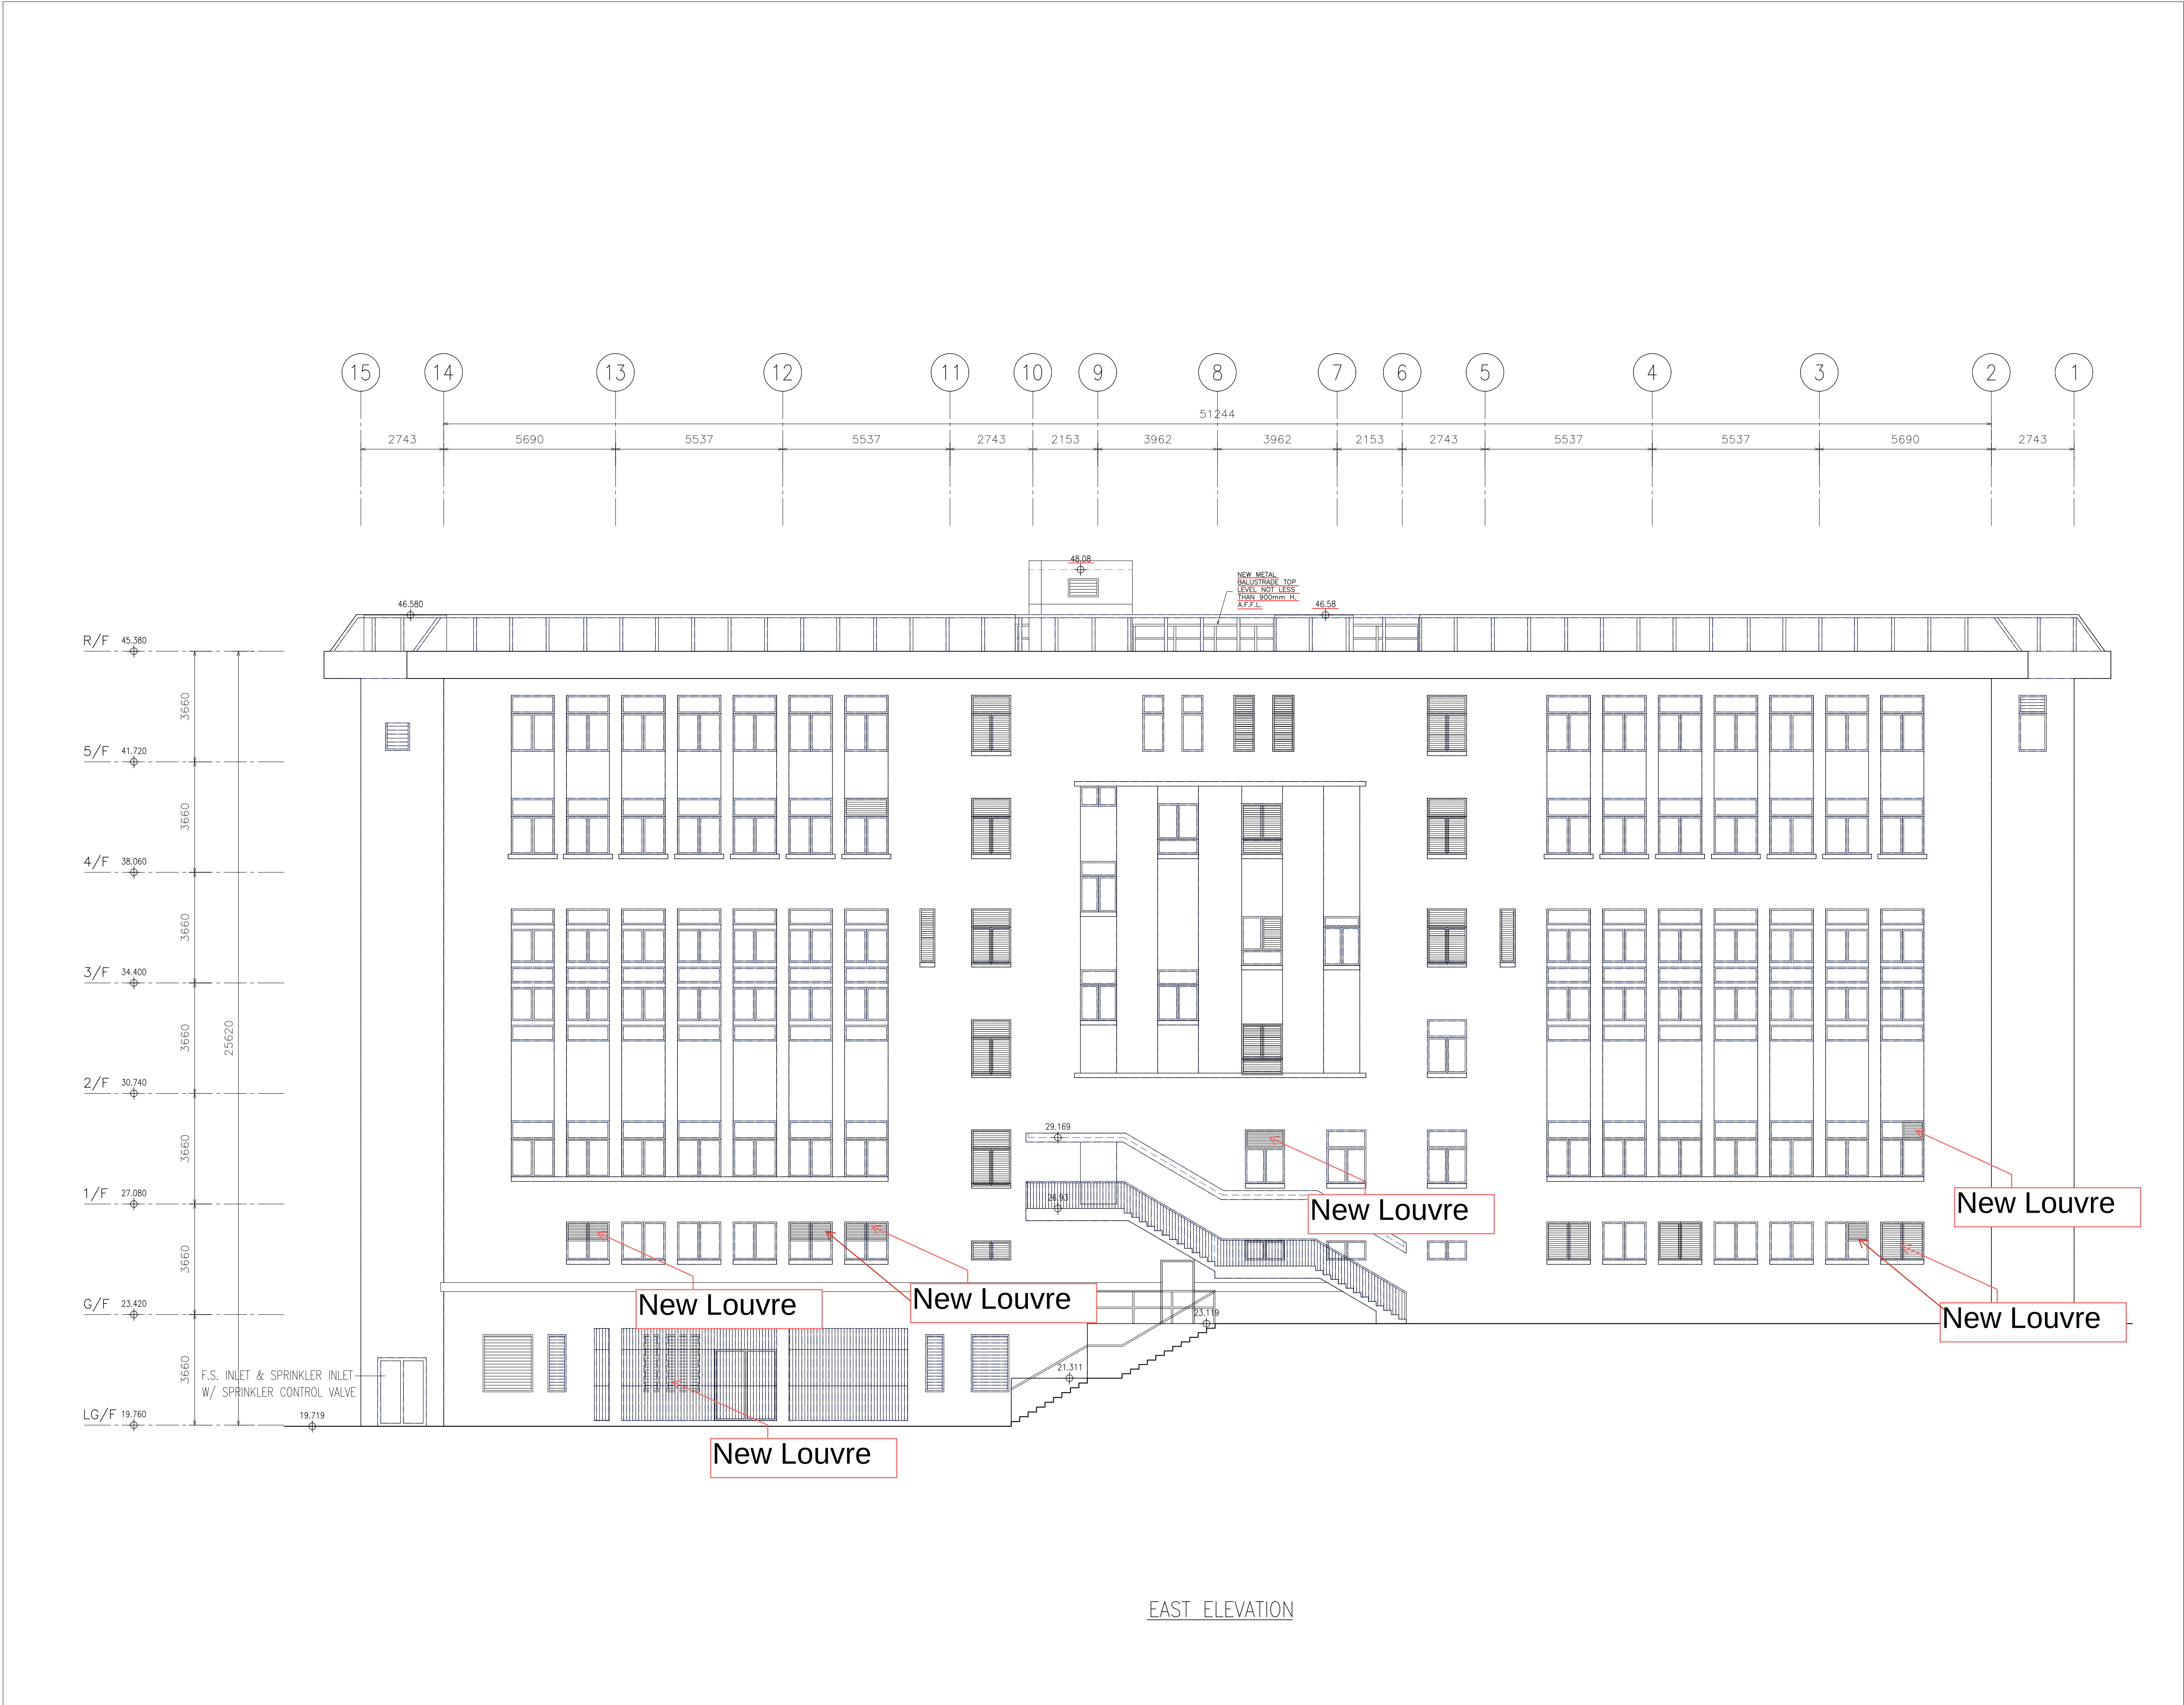

D. REFERENCE			屋宇署檔案
F.S.D. REFERENCE			消防處檔案
W.W.O. REFERENCE			水務署檔案
CAD FILE NAME			檔案編號
NOTES			注釋
LEGEND EXTENT OF A&A WORKS AREA TO REMAIN UNCHANGED AS PREVIOUS ASD APPROVED DRAWINGS			
NO. 修定號	REVISIONS 修定內容	DATE 日期	BY 經手人
	</		

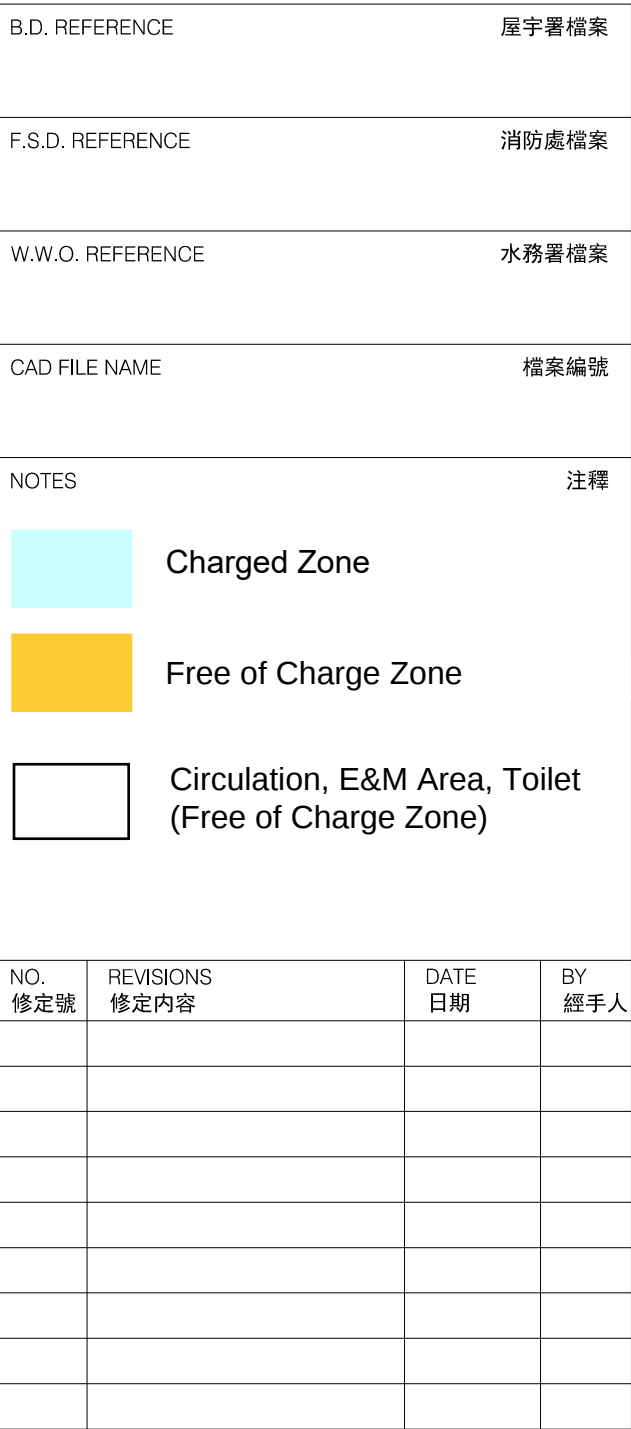

ALL MEASUREMENTS MUST BE CHECKED AT THE WORK BY THE CONTRACTOR
所有尺寸應由承建商於工地核實


DO NOT SCALE FROM DRAWINGS 尺寸不應由圖紙直接量度

ALL PRINTS, SPECIFICATIONS AND THEIR COPYRIGHT ARE THE PROPERTY OF
THE ARCHITECT AND SHALL BE RETURNED AT THE COMPLETION OF THE WORK
所有印刷、規格說明及所有的版權屬於建築師及應在工程完結後歸還建築師

PROJECT
REVITALISATION OF FORMER NORTH
KOWLOON MAGISTRACY INTO NK
FUTURE – JUDICIAL EDUCATION
CENTRE, NO.292 TAI PO ROAD, SHAM
SHUI PO, KOWLOON

DRAWING TITLE	標題
GROUND FLOOR PLAN	

SCALE 比例	DATE	日期
1:100(A1)	2025-6	
DRAWN BY 製作人	CHECKED BY	檢查
SZ		
JOB NO. 工程項目	DRAWING NO.	圖號
N3484-H	G-4	

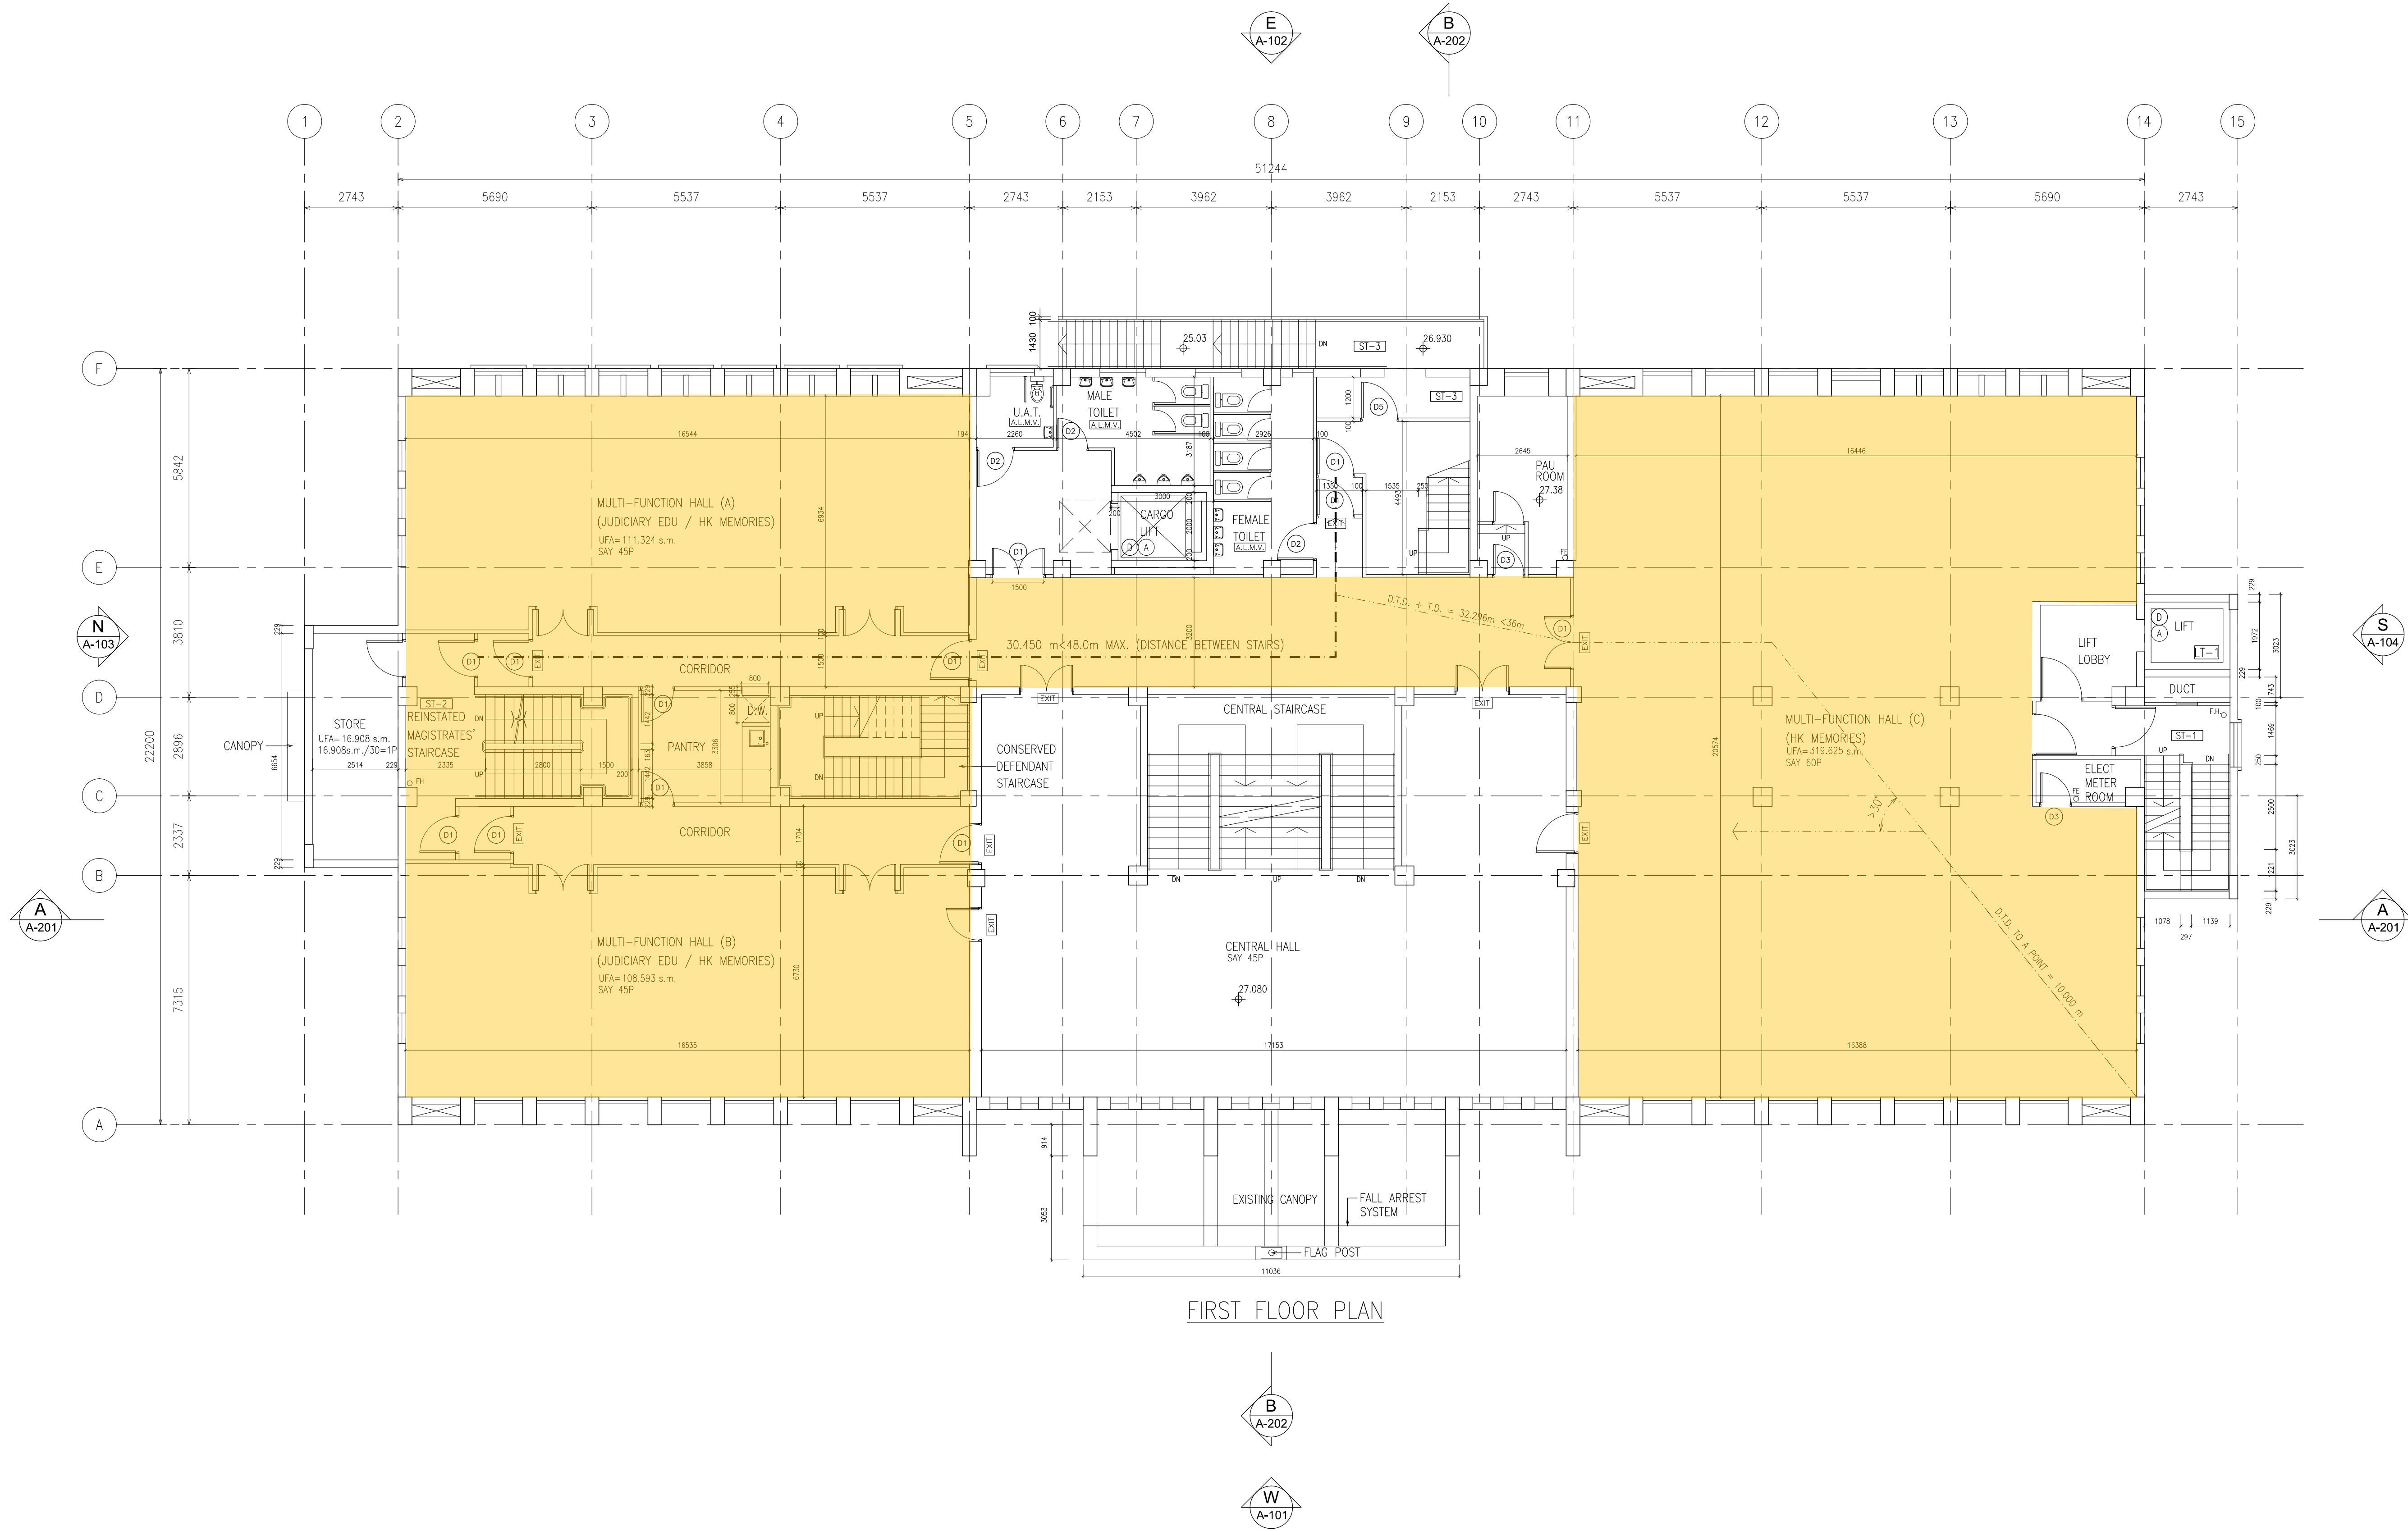

FIRST FLOOR PLAN

B.D. REFERENCE

屋宇署檔案

F.S.D. REFERENCE

消防處檔案

W.W.O. REFERENCE

水務署檔案

CAD FILE NAME

檔案編號

NOTES

注釋

Free of Charge Zone

Circulation, E&M Area, Toilet
(Free of Charge Zone)

NO. 修定號	REVISIONS 修定內容	DATE 日期	BY 經手人

DLN

DLN Architects Limited

劉榮廣伍振民建築師有限公司

45-47 Floor, Tower One, Times Square

Matheson Street, Causeway Bay, Hong Kong

香港銅鑼灣勿拉士街

時代廣場一座45至47樓

t + 852 2895 6888 f + 852 2576 4074 email general@dln.com.hk www.dln.com.hk

ALL MEASUREMENTS MUST BE CHECKED AT THE WORK BY THE CONTRACTOR
所有尺寸應由承建商於工地核實
DO NOT SCALE FROM DRAWINGS 尺寸不應由圖紙直接量取
ALL PRINTS, SPECIFICATIONS AND THEIR COPYRIGHT ARE THE PROPERTY OF THE ARCHITECT AND SHALL BE RETURNED AT THE COMPLETION OF THE WORK
所有印圖、規格說明及所有的版權屬於建築師及應在工程完竣後歸還建築師

PROJECT 項目名稱
REVITALISATION OF FORMER NORTH KOWLOON MAGISTRACY INTO NK FUTURE – JUDICIAL EDUCATION CENTRE, NO.292 TAI PO ROAD, SHAM SHUI PO, KOWLOON
DRAWING TITLE 標題

FIRST FLOOR PLAN

SCALE 比例 1:100(A1)	DATE 2025-6	日期
DRAWN BY 製作人 SZ	CHECKED BY	檢查
JOB NO. 工程項目 N3484-H	DRAWING NO. G-5	圖號



ALL MEASUREMENTS MUST BE CHECKED AT THE WORK BY THE CONTRACTOR 所有尺寸應由承造商於工地核實			
DO NOT SCALE FROM DRAWINGS 尺寸不能由圖紙直接量度			
PROJECT REVISALISATION OF FORMER NORTH KOWLOON MAGISTRACY INTO NK FUTURE - JUDICIAL EDUCATION CENTRE, NO.292 TAI PO ROAD, SHAM SHUI PO, KOWLOON		項目名稱	
DRAWING TITLE		標題	
THIRD FLOOR PLAN			
SCALE 1:100(A1)	比例	DATE 2025-6	日期
DRAWN BY 製作人 SZ	CHECKED BY	檢查	
JOB NO. 工程項目 N3484-H	DRAWING NO. G-7	圖號	

