


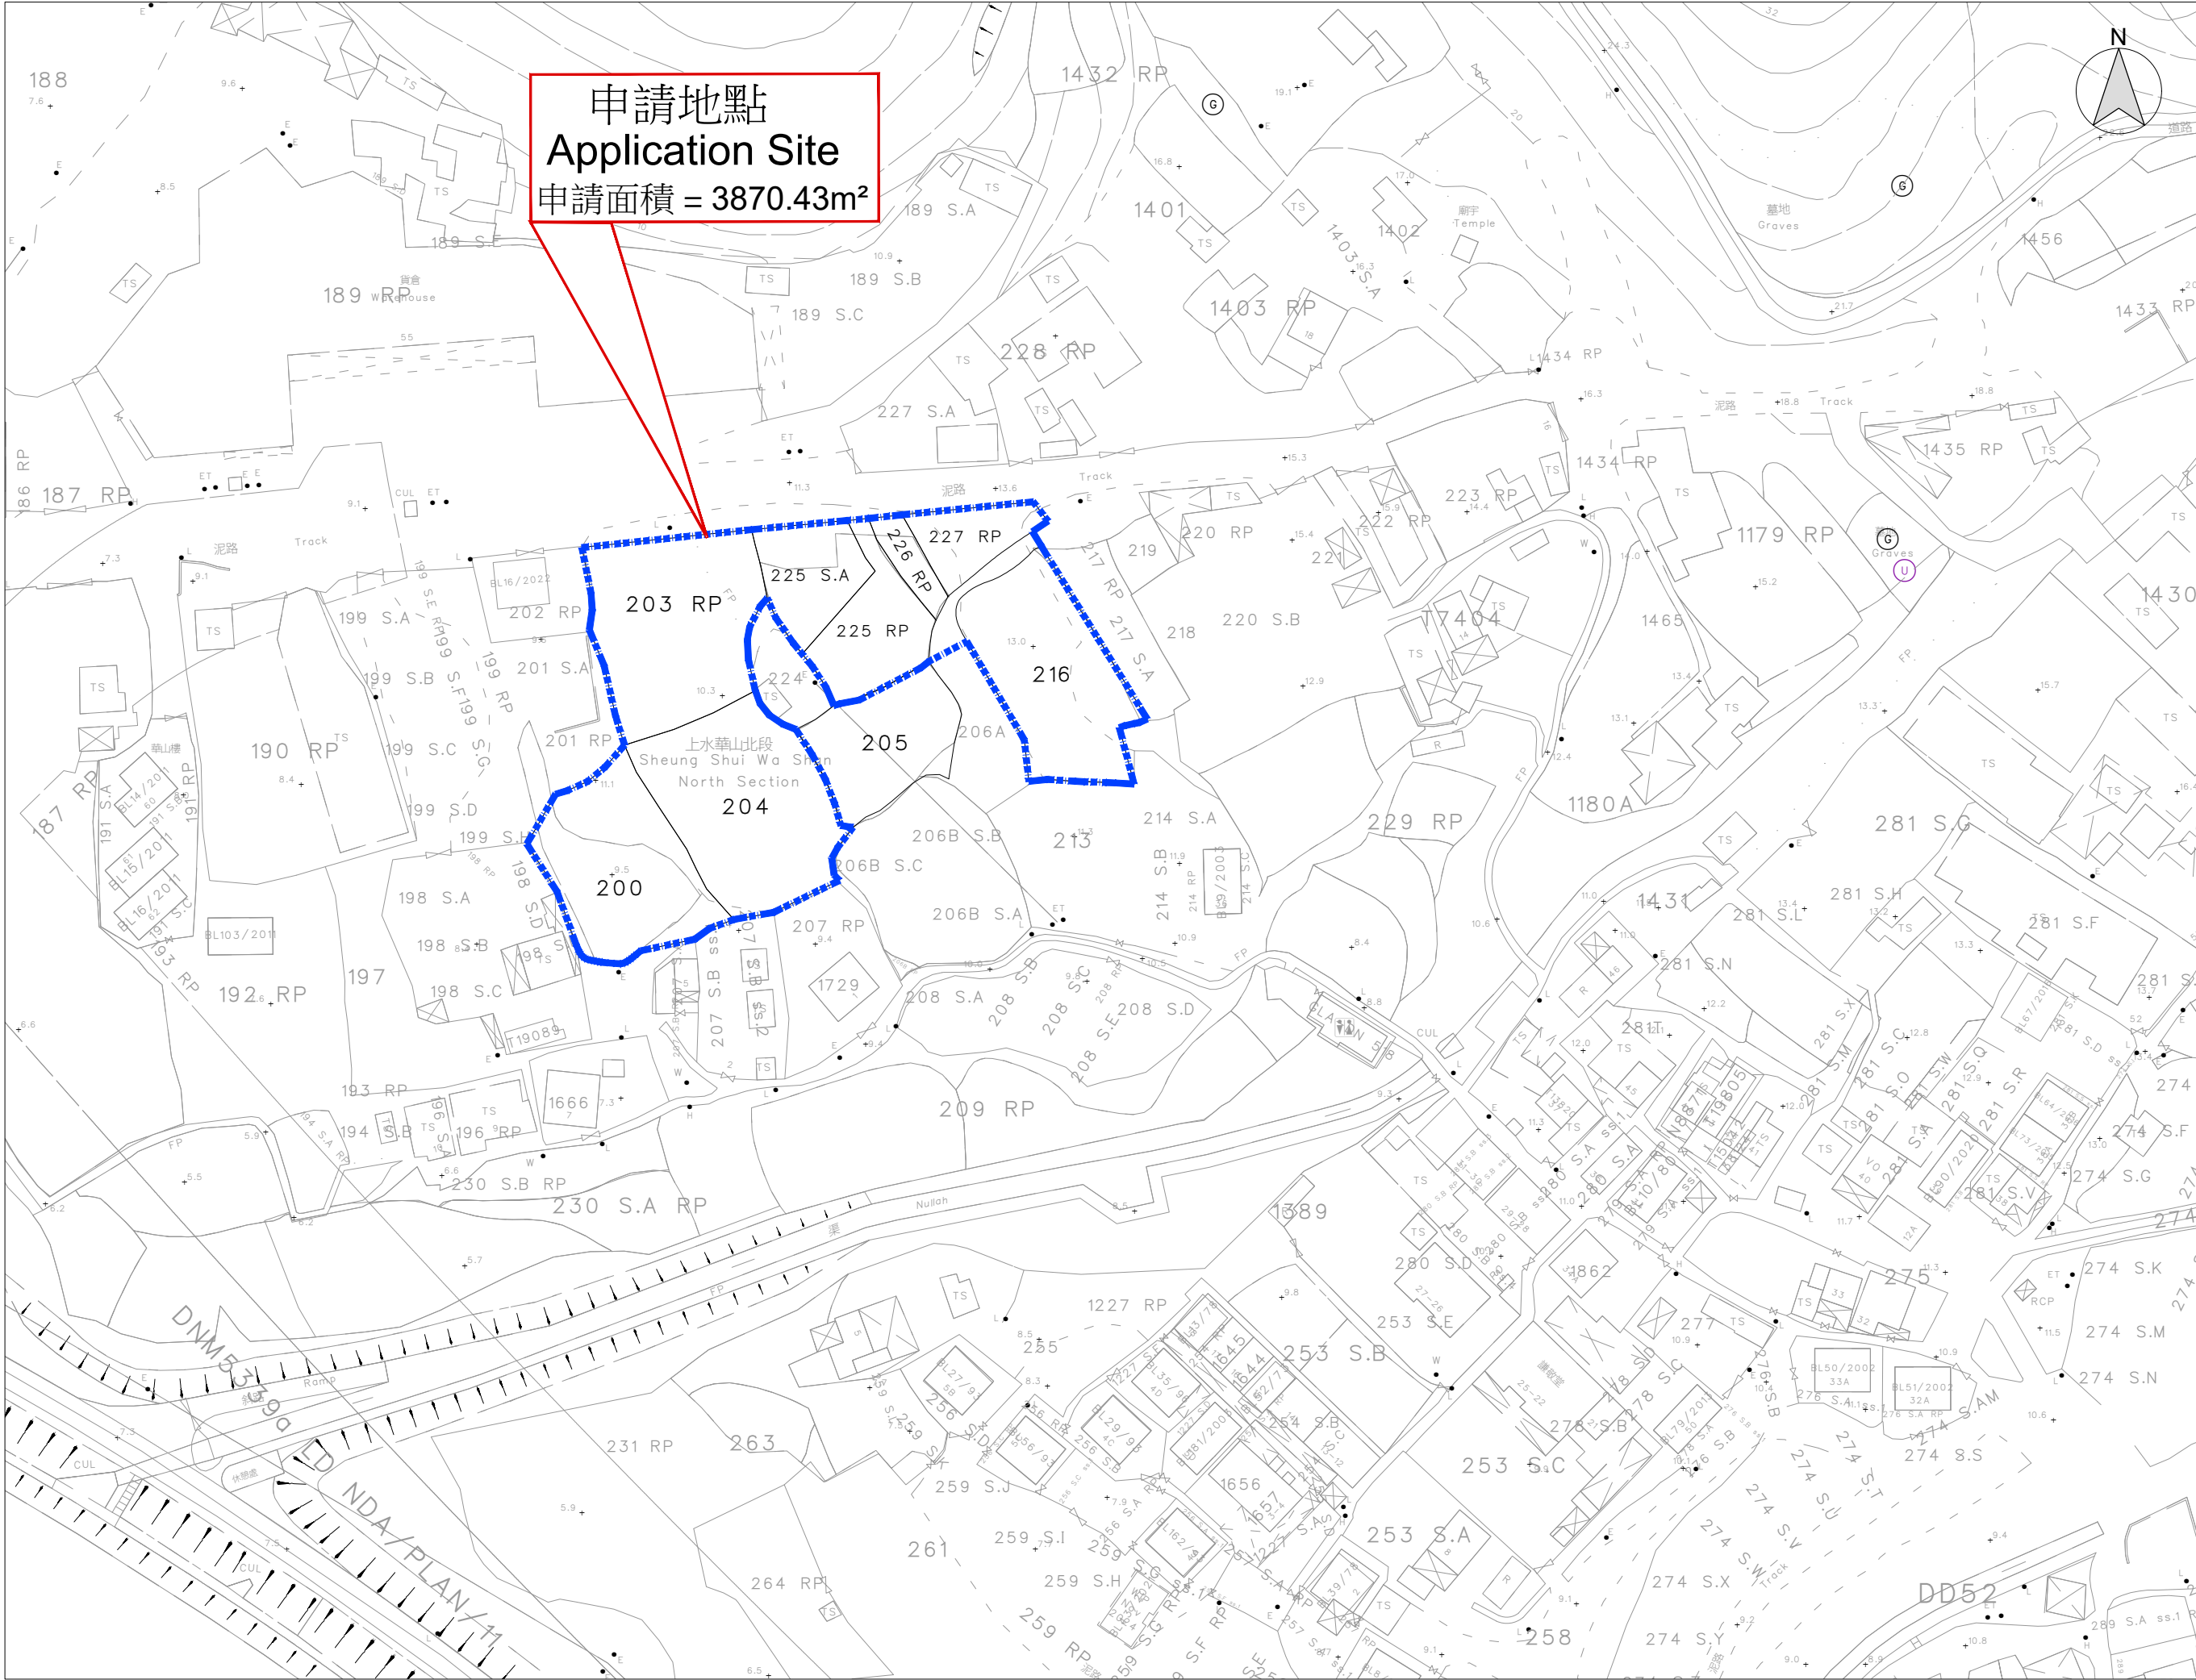

B.D. Reference	基本圖則
M.W. Reference	小型工程圖則
L.D. Reference	地政署圖則
F.S.D. Reference	消防處圖則

Notes
Copyright Reserved nothing may be reprinted or utilized in any form or by any means without written permission from the M&D.

REV	DESCRIPTION	DATE

M&D
Planning and
Construction
Consultant Ltd.

Tel: 2191 4088
Fax: 3105 0810
Email: sales@moderneng.com.hk

Project
LOTS 200, 203R.P., 204, 225S.A., 225R.P., 226R.P., 227RP AND 216 AND ADJOINING GOVERNMENT LAND IN D.D.52, FU TEI AU, SHEUNG SHUI, NEW TERRITORIES

Application
TEMPORARY PLANNING APPLICATION TO PROPOSED TEMPORARY CARGO HANDLING AND FORWARDING FACILITY USE AND ASSOCIATED FILLING OF LAND FOR A PERIOD OF 3 YEARS

Drawing Title
LOCATION PLAN

Scale	比例	Revisions	修訂
1:1000 (A3)		—	
Designed by	設計者	Drawn by	制圖人
LW		Arthur	
Checked by	校核	Date	日期
LW		15-AUG-2025	
Job No.	工程項目	Drawing No.	圖號
—		LP-01	

