
 


布局圖

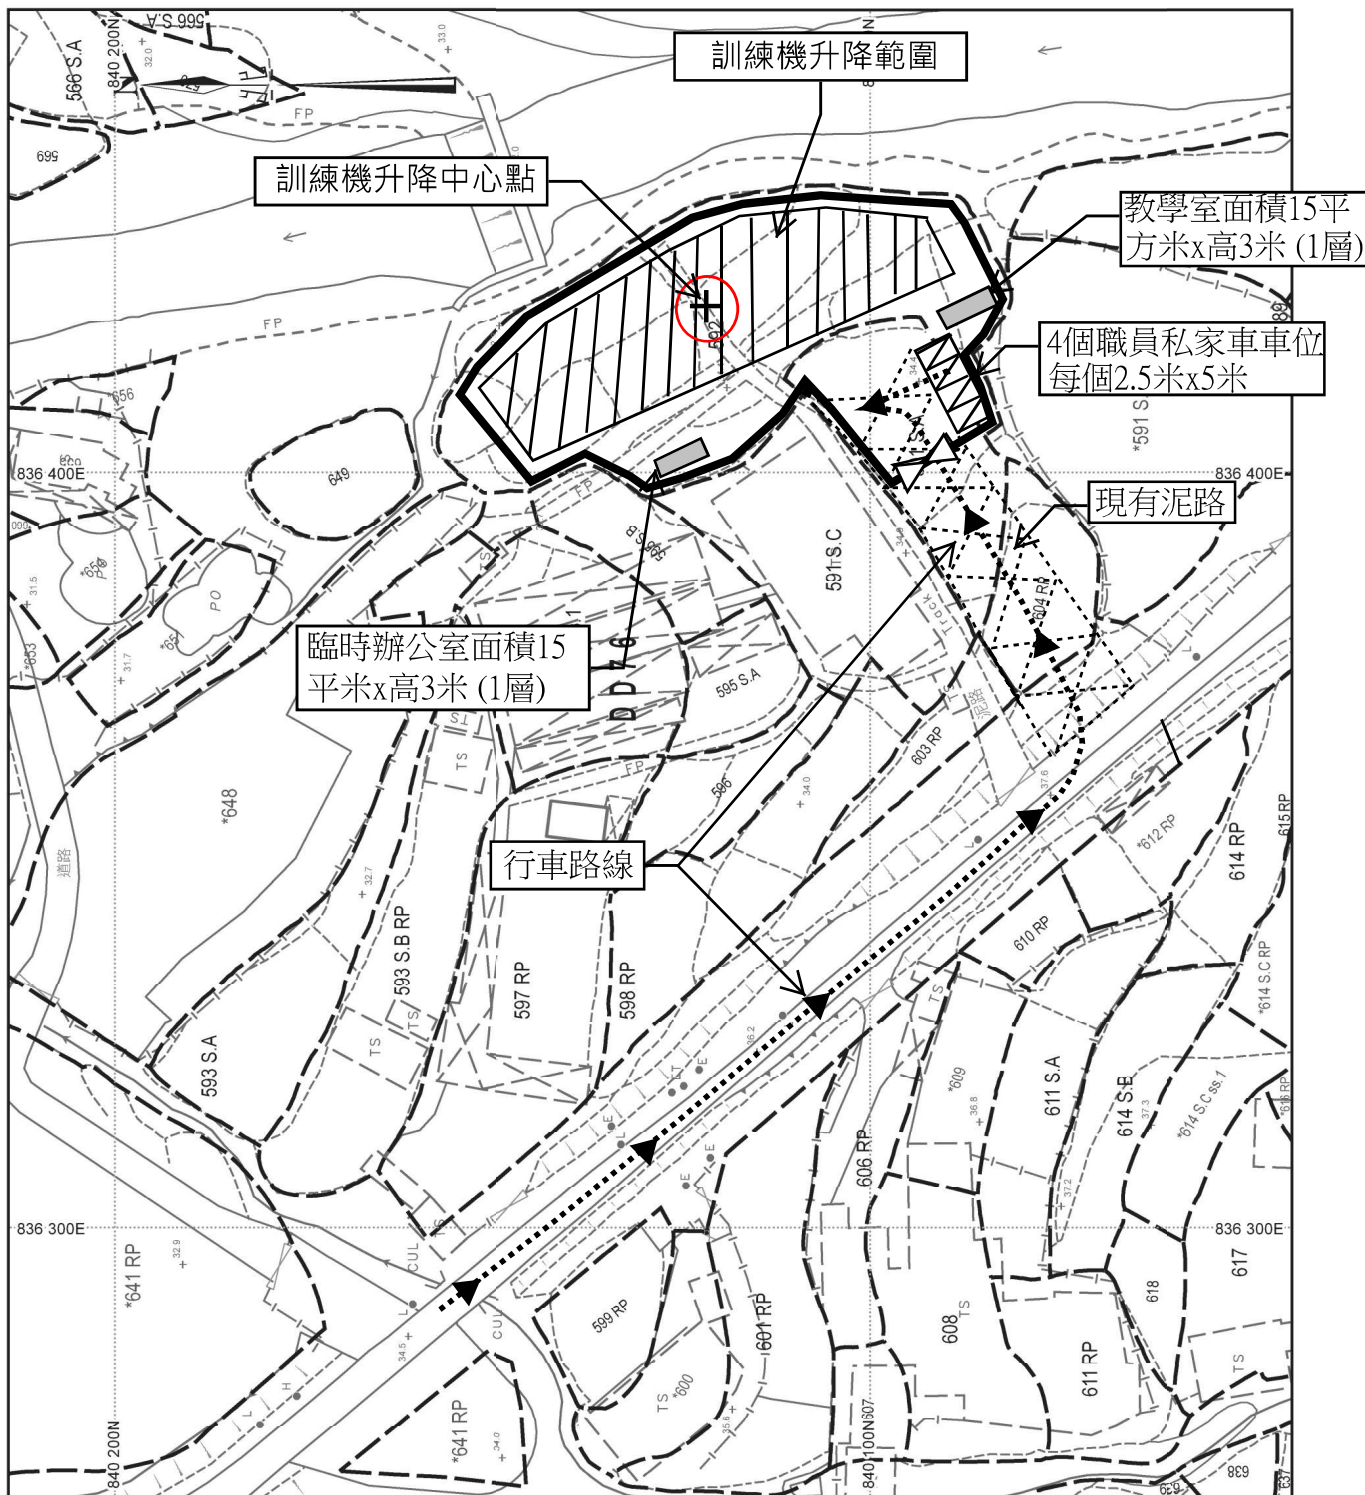


地政總署測繪處 Survey and Mapping Office, Lands Department

比例尺 SCALE 1:1 000




消防裝置建議圖

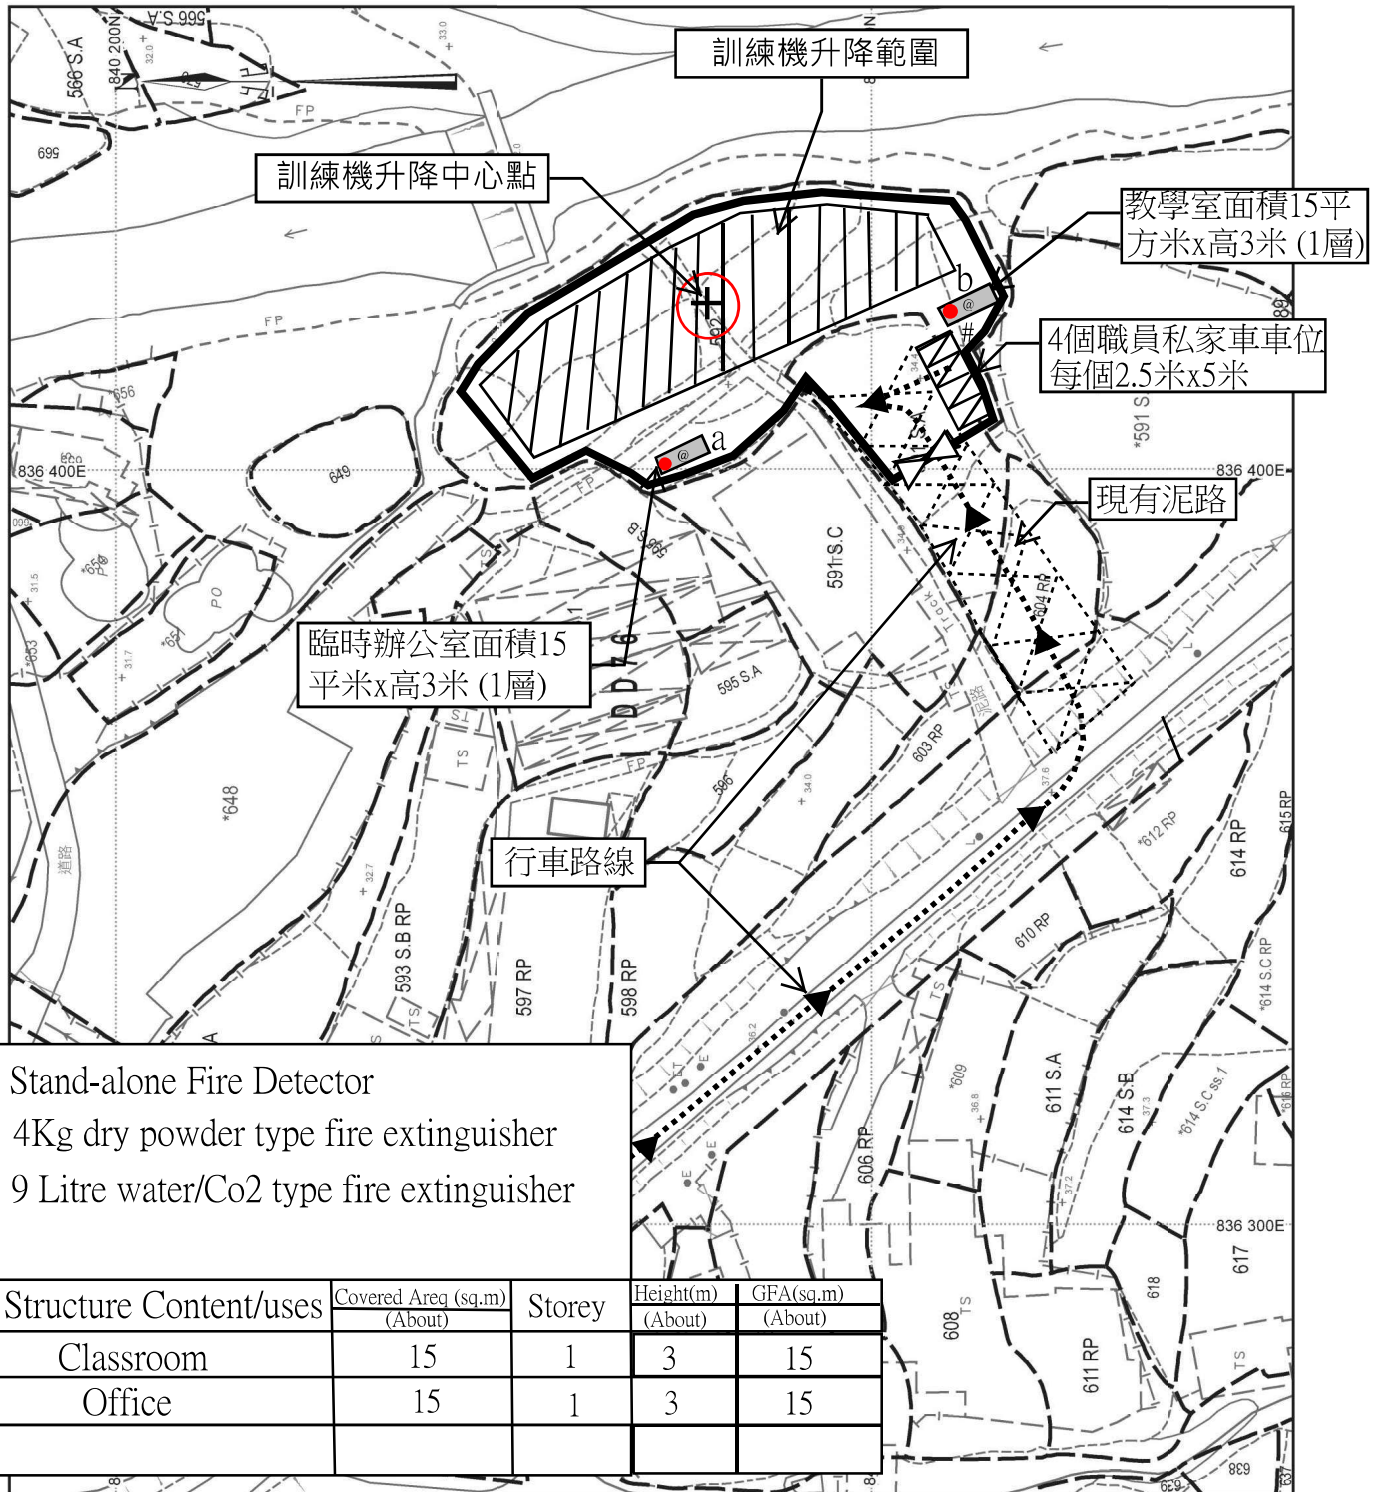

地政總署測繪處 Survey and Mapping Office, Lands Department

 
比例尺 SCALE 1:1 000



Fire Notes:


1. Sufficient portable hand-operated approved appliance shall be provided as required by occupancy and as marked on plans
2. Stand-alone fire detector shall be provided for each structure as marked on plans. where two or more stand-alone fire detectors are installed in an enclosed structure, all detectors shall be interconnected(either wire or wirelessly) such that when one of the detectors is triggered, all connected detectors shall sound an alarm simultaneously and
3. The Stand-alone fire detector shall be provided in accordance with the "Stand-alone Fire Detector General Guidelines on Purchase, installation & Maintenance [Sep 2021]".

申請地點位置圖

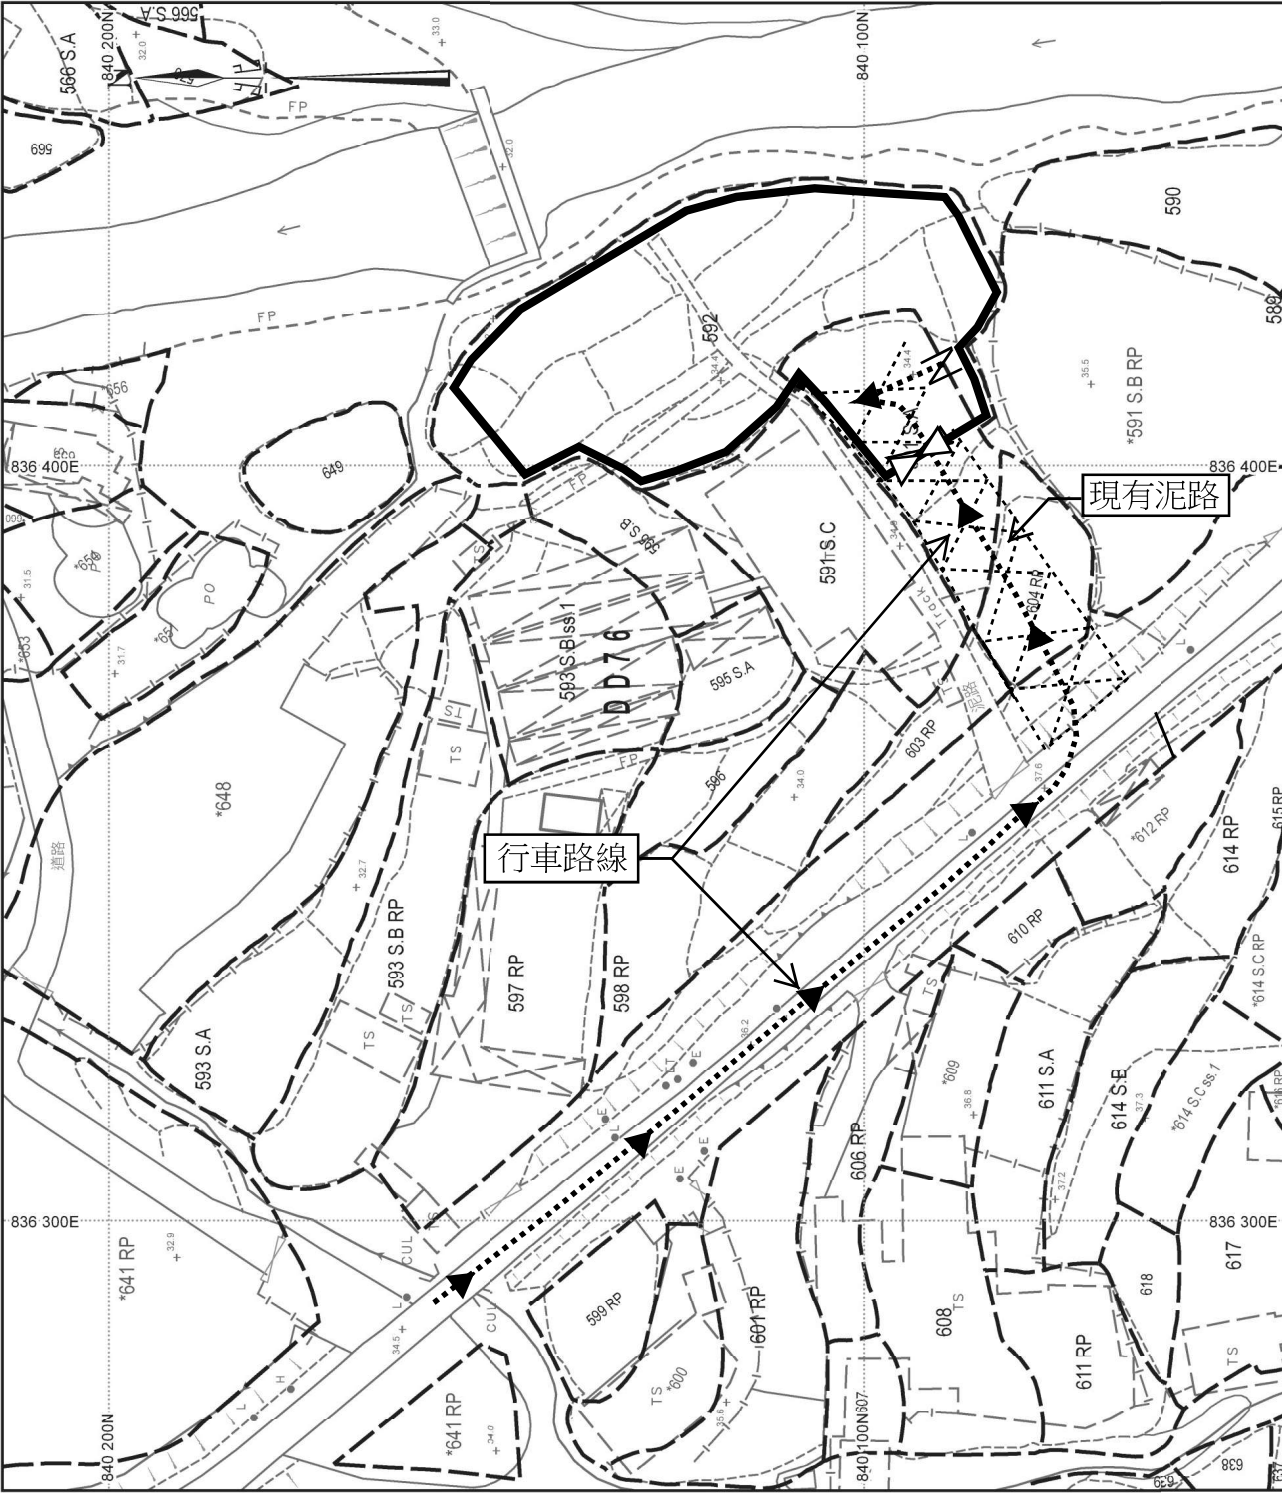


地政總署測繪處 Survey and Mapping Office, Lands Department

 比例尺 SCALE 1:1 000



雨水排放建議圖

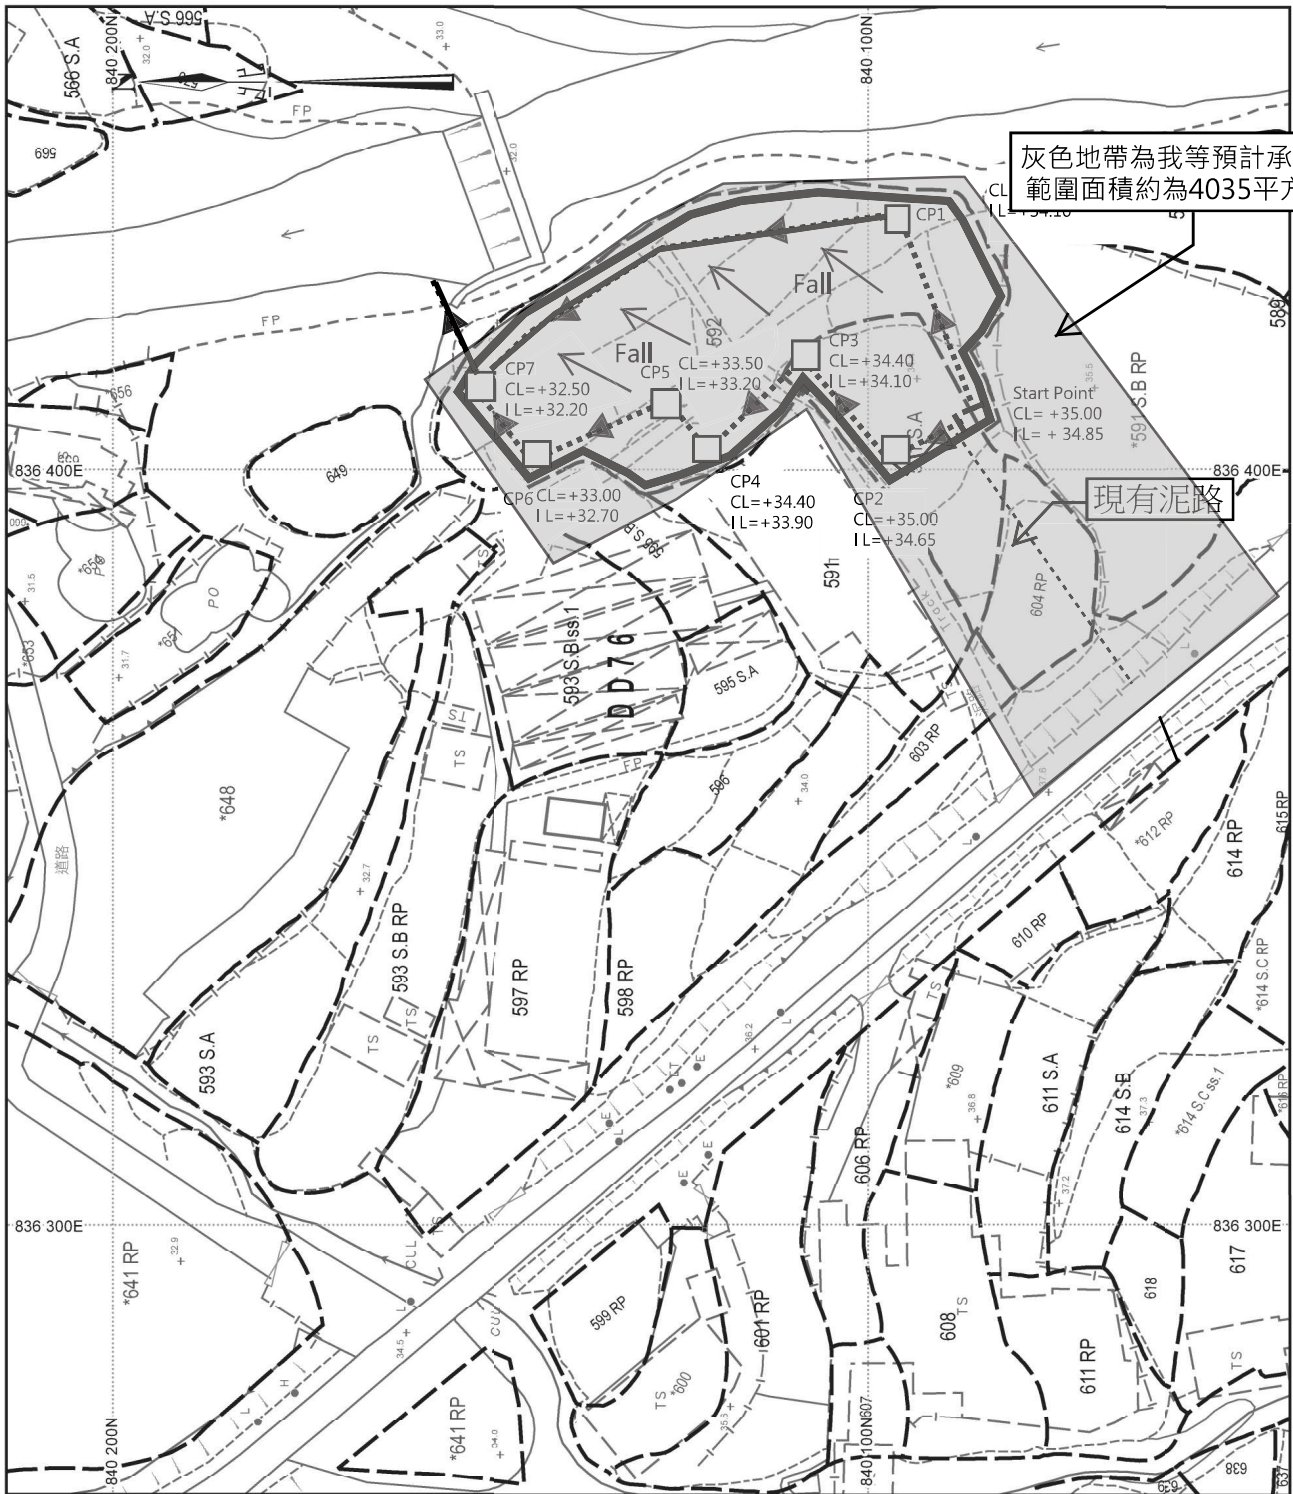

灰色地帶為我等預計承接雨
範圍面積約為4035平方米

現有泥路

地政總署測繪處 Survey and Mapping Office, Lands Department

Proposed 300UC (1:100) with concrete cover

Proposed 400UC (1:100) with concrete cover

比例尺 SCALE 1:1000

metres 10 0 10 20 30 40 50 metres



Catchment Area

Site Catchment Area = $4035 \text{ m}^2 = 0.004035 \text{ km}^2$

Peak runoff in $\text{m}^3/\text{s} = 0.278 \times 0.95 \times 240 \text{ mm/hr} \times 0.004035 \text{ km}^2 = 0.25575 \text{ m}^3/\text{s}$

= 15985 liter/min

Note :

1. Catchpit (CP1-CP7) with desilting facility shall follow CEDD's standard drawing No. C2406/1. C2406/2A
2. Catchpit and UC follows Typical Details of Geotechnical Manual for Slope Fig.8.10 and Fig.8.11 respectively.
3. The inverted level of the connection point shall be verified on site prior the commencement of work
4. Grating Concrete Cover follows CEDD's standard drawing No. C2412E: U-CHANNELS WITH PRECAST CONCRETE SLABS