


B. D. REFERENCE :

F. S. D. REFERENCE :
FP 19 / 24422

NOTES :

1. ALL DIMENSIONS ARE IN MILLIMETER.

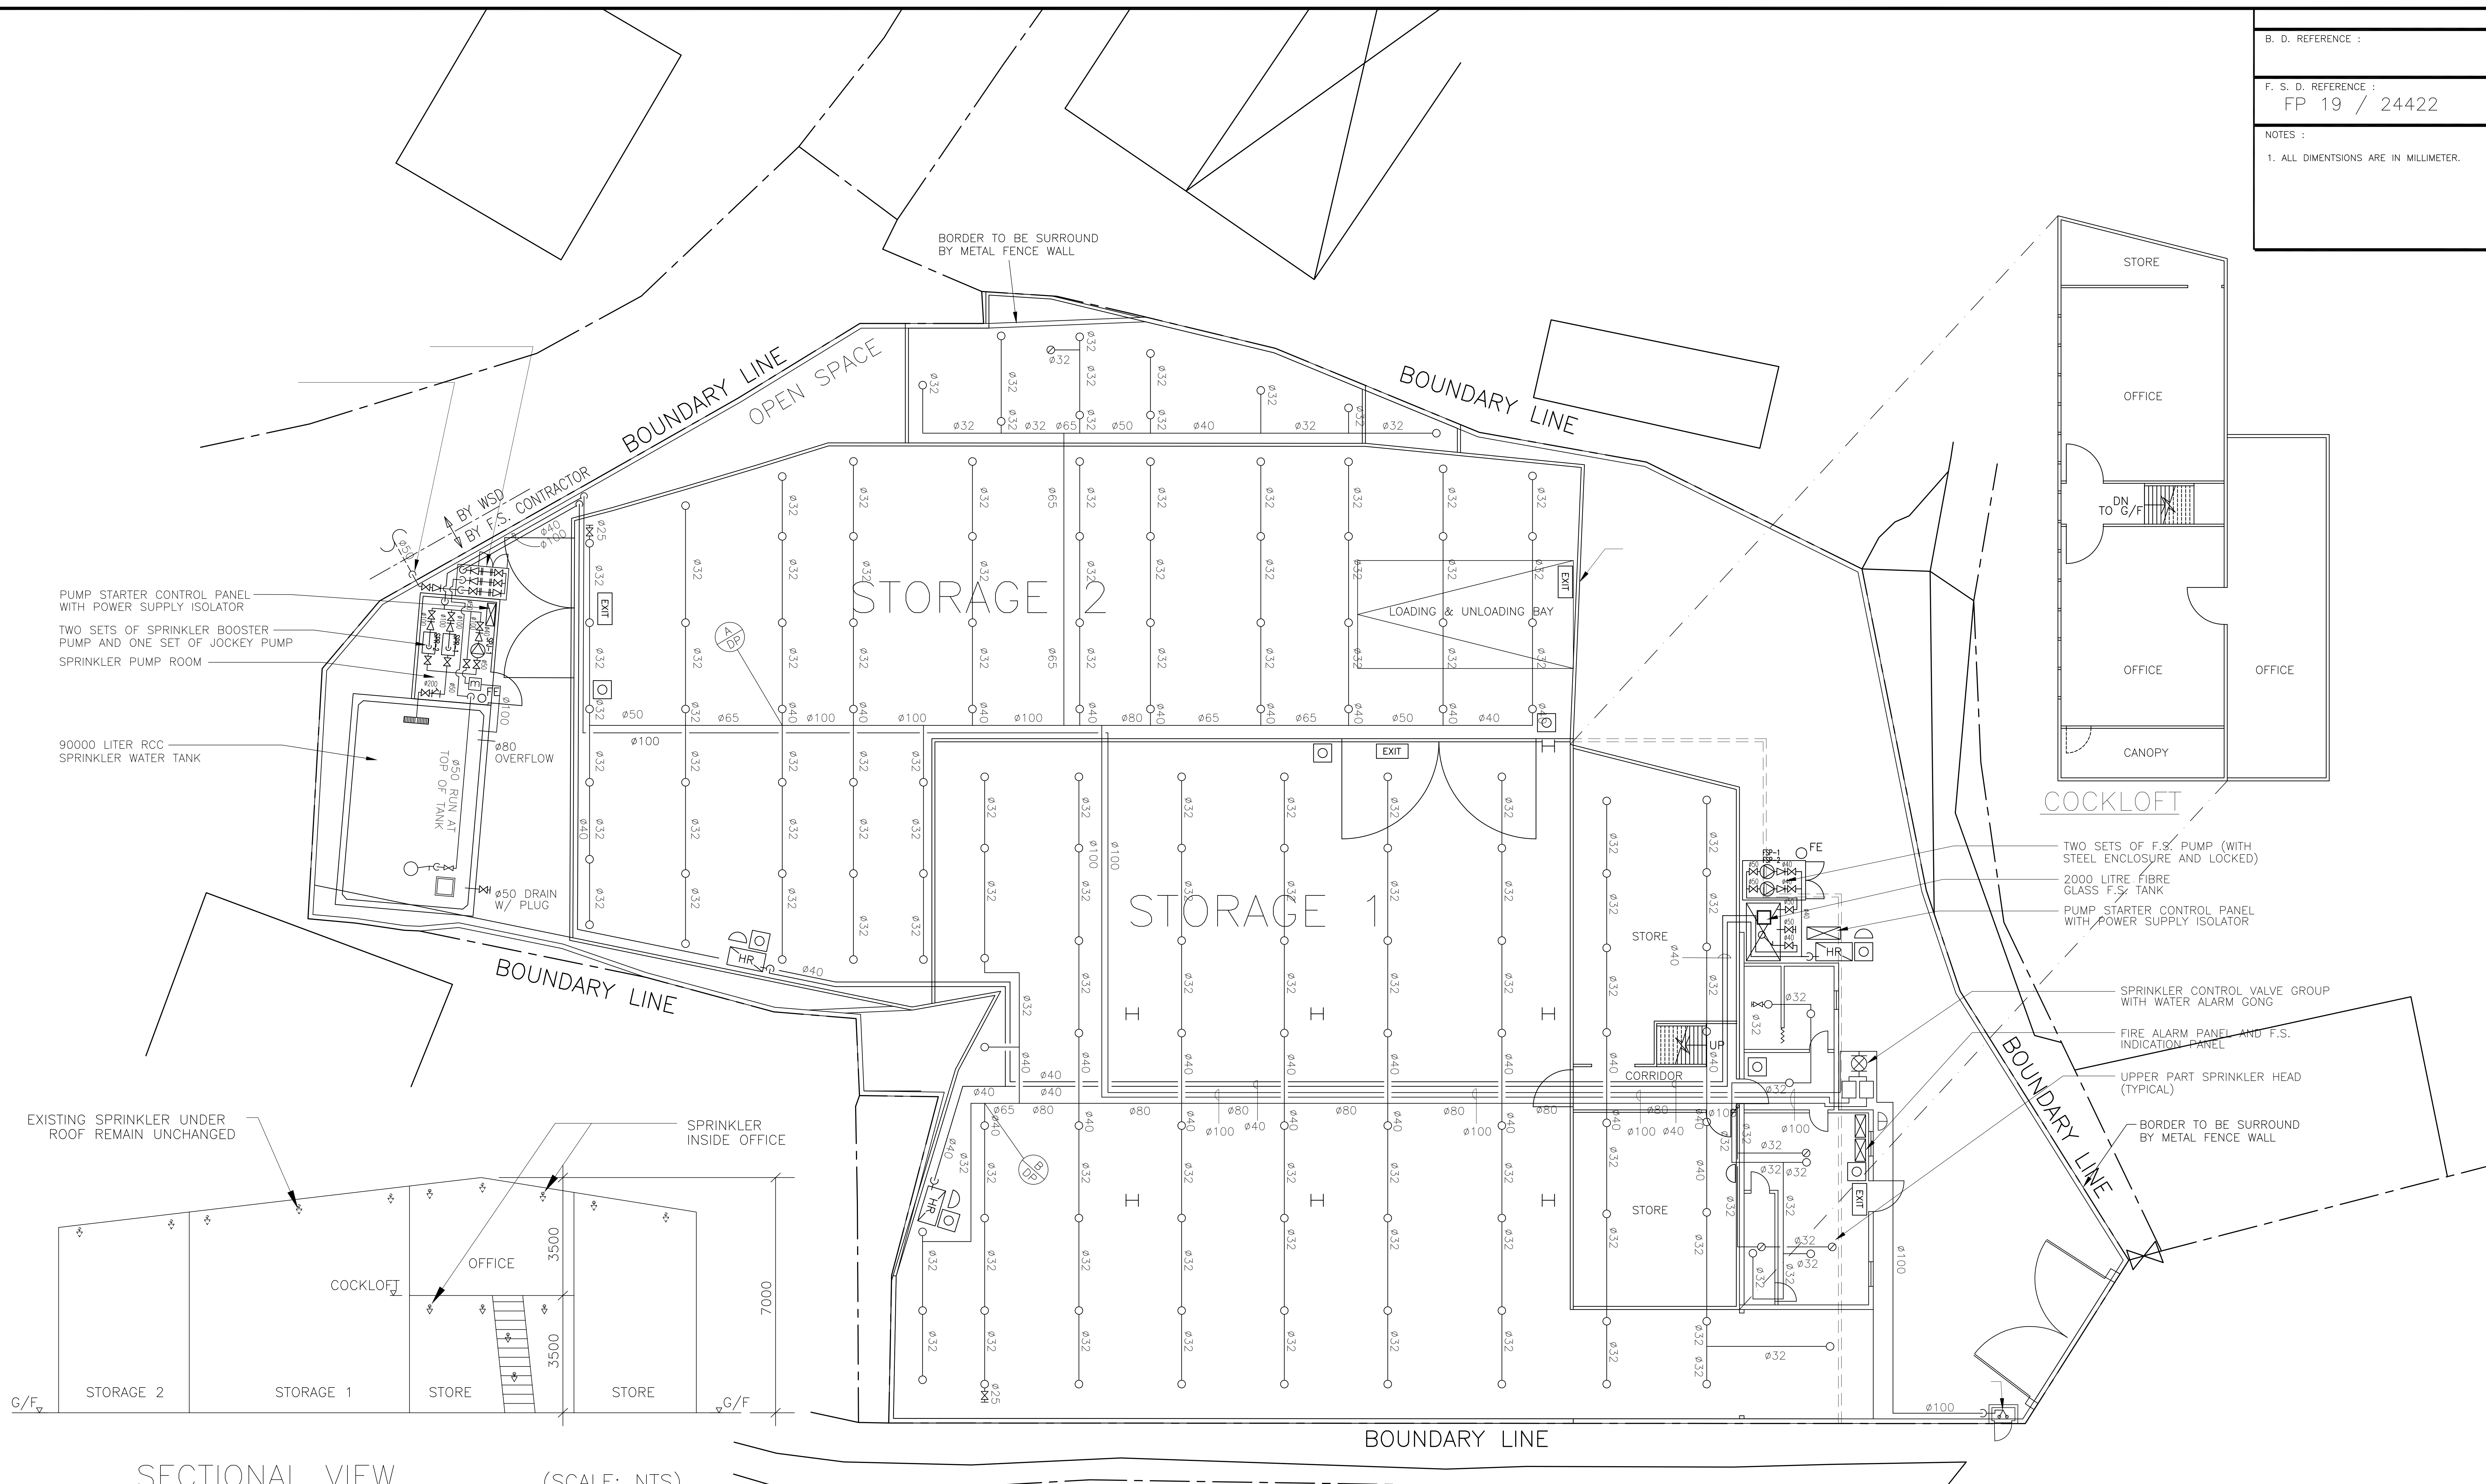

SECTIONAL VIEW

(SCALE: NTS)

GROUND FLOOR PLAN

REMARK:
ALL FS AND SPRINKLER INSTALLATION ARE EXISTING INSTALLATION.

F.S. CONSULTANT :		PROJECT : LAYOUT PLAN FOR LOTS NOS. 1618(PART), 1619, 1620(PART) IN D.D.100 AND ADJOINING GOVERNMENT LAND, YING PUN, KWU TUNG SOUTH, SHEUNG SHUI, N.T.		TITLE : FIRE SERVICES LAYOUT PLAN		JOB NO. : WK240205		DRAWING NO. : FS-2	
REV.	DESCRIPTION	BY	DATE	REV.	DESCRIPTION	BY	DATE	DATE :	REVISION : 1
R3			3/25	R1			9/24	SEP. 2024	
R2				R2			1/25		