


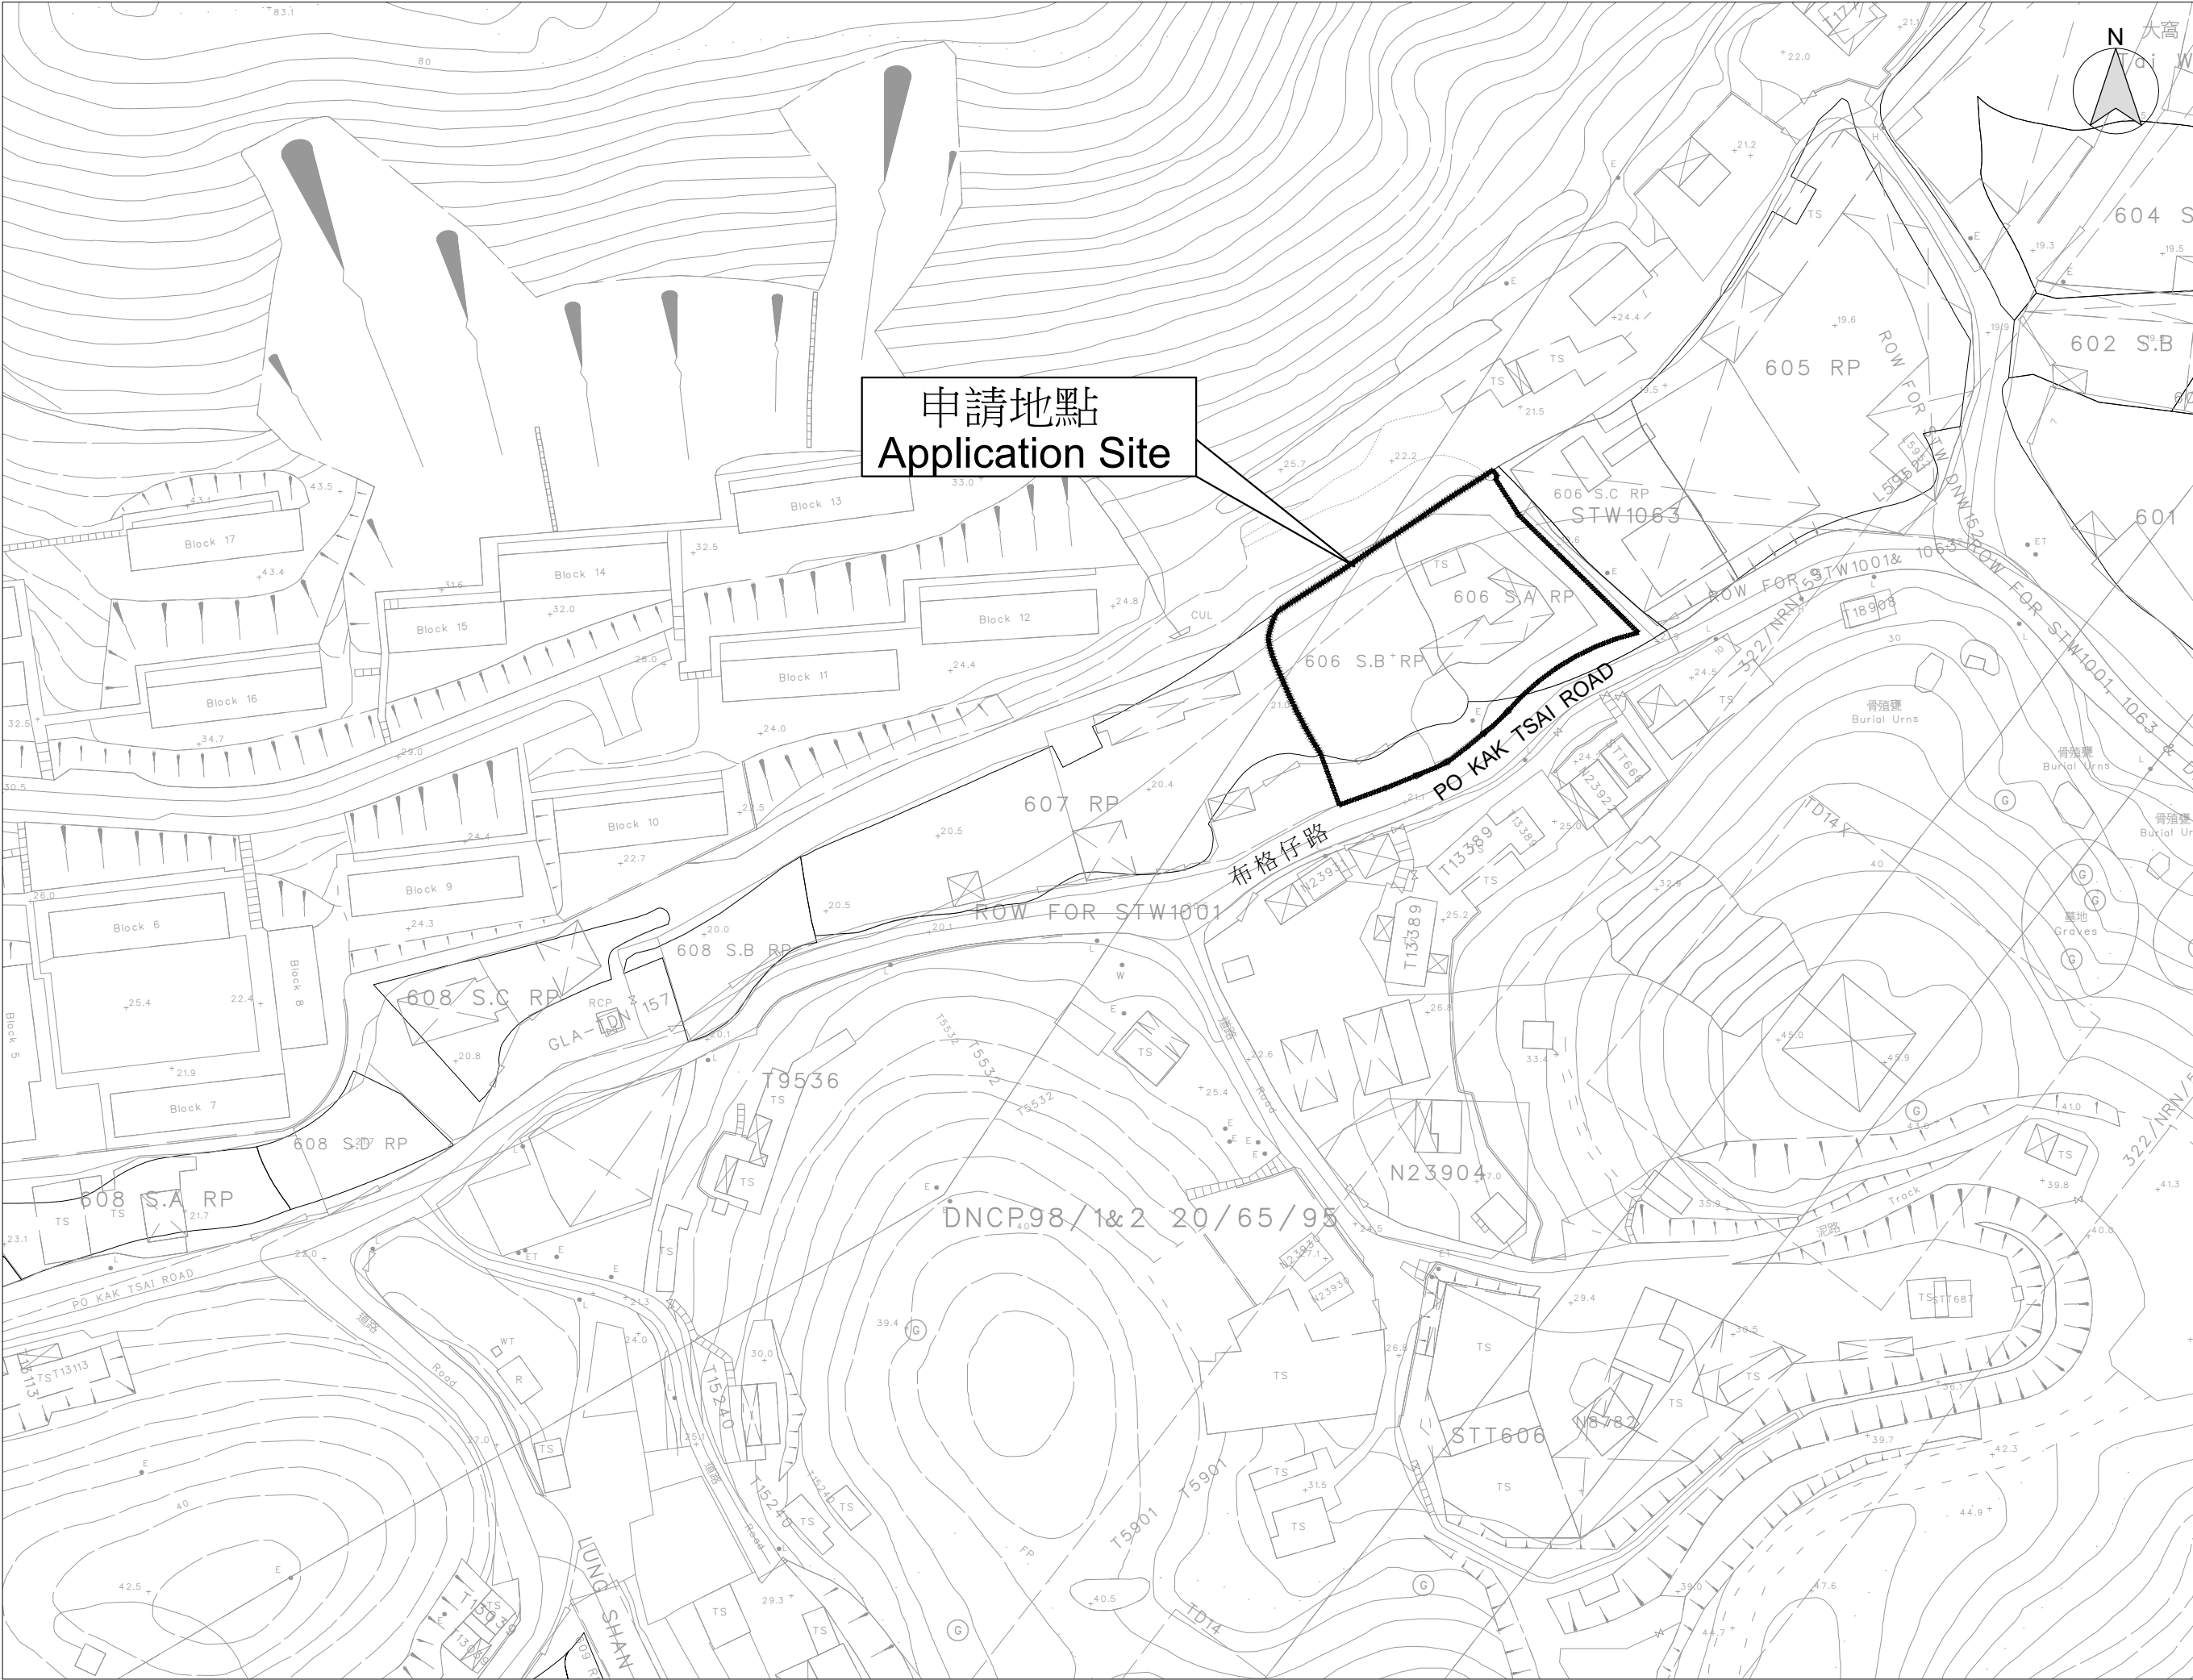

B.D. Reference	地形圖參考
M.W. Reference	小區工程圖參考
L.D. Reference	地政署圖參考
F.S.D. Reference	消防處圖參考

Notes
Copyright Reserved nothing may be reprinted or utilized in any form or by any means without written permission from the M&D.

REV	DESCRIPTION	DATE



Tel: 2191 4088
Fax: 3105 0810
Email: sales@moderneng.com.hk

Project
新界粉嶺丈量約份第85約地段第606號A分段餘段(部分)、606號B分段餘段及毗連政府土地

Application
擬議臨時貨物裝卸及貨運設施(為期3年)

Drawing Title
LOCATION PLAN

Scale	比例	Revisions	修訂
1:1000 (A3)		—	
Designed by	設計者	Drawn by	繪圖人
LW		Arthur	
Checked by	校核	Date	日期
LW		12-MAY-2025	
Job No.	工程項目	Drawing No.	圖號
—		LP-01	