

Appendix 5

Fire Service Installations Proposal

FIRE SERVICES NOTES:

1. HOSE REEL SYSTEM
- 1.1

HOSE REEL SHALL BE PROVIDED AT POSITIONS AS INDICATED ON PLANS.
- 1.2

THERE SHALL BE SUFFICIENT HOSE REELS TO ENSURE THAT EVERY PART OF THE BUILDING CAN BE REACHED BY A LENGTH OF NOT MORE THAN 30M OF HOSE REEL TUBING. ONE ACTUATING POINT AND ONE AUDIO WARNING DEVICE TO BE LOCATED AT EACH HR POINT. THE ACTUATING POINT SHOULD INCLUDE FACILITIES FOR THE FIRE PUMP START DEVICE INITIATION.
- 1.3

A MODIFIED HOSE REEL SYSTEM OF 2000 LITRES WATER TANK TO BE PROVIDED FOR THE ENTIRE BUILDING AS INDICATED ON PLAN.
- 1.4

NO FIRE SERVICES INLET TO BE PROVIDED FOR THE MODIFIED HOSE REEL SYSTEM.
- 1.5

TWO FIXED FIRE PUMPS (DUTY/STANDBY) TO BE PROVIDED AT SPR. & FS. PUMP ROOM.
- 1.6

THE HR SYSTEM INSTALLED SHOULD BE IN ACCORDANCE WITH PARA. 5.14 OF THE CODE OF PRACTICE FOR MINIMUM FIRE SERVICE INSTALLATION AND EQUIPMENT 2022.
- 1.7

AN INSTRUCTION PLATE SHALL BE PROVIDED NEXT TO THE BREAK GLASS UNIT FOR OPERATION OF HOSE REEL.

2. AUTOMATIC SPRINKLER SYSTEM
- 2.1

AUTOMATIC SPRINKLER SYSTEM SUPPLIED BY A 135,000L SPRINKLER WATER TANK AND HAZARD CLASS OH3 SHALL BE PROVIDED TO THE ENTIRE BUILDING/STRUCTURE IN ACCORDANCE WITH LPC RULES INCORPORATING BS EN12845 : 2015 AND FSD CIRCULAR LETTER 5/2020. THE SPRINKLER TANK, SPRINKLER PUMP ROOM, SPRINKLER INLET AND SPRINKLER CONTROL VALVE GROUP SHALL BE CLEARLY MARKED ON PLANS.
- 2.2

THE CLASSIFICATION OF THE AUTOMATIC SPRINKLER INSTALLATION TO BE ORDINARY HAZARD GROUP 3.
- 2.3

ONE NUMBER 135,000 LITRES SPRINKLER WATER TANK TO BE PROVIDED AS INDICATED ON PLANS.
- 2.4

ALL INSTALLED SPRINKLER SHOULD BE PENDENT TYPE AND THE TEMPERATURE RATING OF SPRINKLER HEAD SHALL BE 68 °C UNLESS OTHERWISE SPECIFIED.
- 2.5

SPRINKLER CONTROL VALVE SET AND SPRINKLER INLET TO BE PROVIDED AS INDICATED ON PLANS.
- 2.6

ALL SPRINKLER PIPE SIZE SHOULD BE ø32mm UNLESS SPECIFY.
- 2.7

TYPE OF STORAGE METHOD FOR THE BUILDING IS AS FOLLOWS:
(A) STORAGE CATEGORY : CATEGORY (I)
(B) STORAGE HEIGHT : NOT EXCEEDING 4M
(C) STORAGE : ST1
- 2.8

STORAGE BLOCK SHOULD BE SEPARATED BY AISLES NO LESS THAN 2.4m WIDE.
- 2.9

STORAGE SHOULD BE CONFINED TO BLOCKS NOT EXCEEDING 150m² IN PLAN AREA FOR CATEGORY I.

3. FIRE ALARM SYSTEM
- 3.1

FIRE ALARM SYSTEM SHALL BE PROVIDED THROUGHOUT THE ENTIRE BUILDING IN ACCORDANCE WITH BS 5839-1 : 2017 AND FSD CIRCULAR LETTER NO. 6/2021. ONE ACTUATING POINT AND ONE AUDIO WARNING DEVICE SHOULD BE LOCATED AT EACH HOSE REEL POINT. THE ACTUATION POINT SHOULD INCLUDE FACILITIES FOR FIRE PUMP START AND AUDIO / VISUAL WARNING DEVICE INITIATION.
- 3.2

AN ADDRESSABLE TYPE FIRE ALARM PANEL TO BE PROVIDED AND LOCATED INSIDE G/F SPR. & F.S. PUMP ROOM.
4. MISCELLANEOUS F.S. INSTALLATION

4.1

PORTABLE FIRE EXTINGUISHER WITH SPECIFIED TYPE AND CAPACITY TO BE PROVIDED AT LOCATIONS AS INDICATED ON PLANS.

4.2

SUFFICIENT EMERGENCY LIGHTING SHALL BE PROVIDED THROUGHOUT THE ENTIRE BUILDINGS/STRUCTURES IN ACCORDANCE WITH BS 5266-1:2016, BS EN 1838:2013 AND FSD CIRCULAR LETTER NO. 4/2021.

4.3

SUFFICIENT DIRECTIONAL AND EXIT SIGN SHALL BE PROVIDED IN ACCORDANCE WITH BS 5266-1:2016 AND FSD CIRCULAR LETTER 5/2008.

4.4

NO EMERGENCY GENERATOR TO BE PROVIDED FOR SERVING THE EMERGENCY POWER. DUPLICATED POWER SUPPLIES FOR ALL FIRE SERVICES INSTALLATIONS COMPRISING A CABLE CONNECTED FROM ELECTRICITY MAINS DIRECTLY BEFORE THE MAIN SWITCH.

4.5

WHEN A VENTILATION/AIR CONDITIONING CONTROL IS PROVIDED, IT SHALL STOP MECHANICALLY INDUCED AIR MOVEMENT WITHIN A DESIGNATED FIR COMPARTMENT.

 
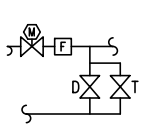
 
4.6

NO DYNAMIC SMOKE EXTRACTION SYSTEM SHALL BE PROVIDED SINCE EITHER THERE BE NO FIRE COMPARTMENT EXCEEDING 7000 CUBIC METRES OR THE AGGREGATE AREA OF OPENABLE WINDOWS OF THE RESPECTIVE COMPARTMENT EXCEEDS 6.25% OF THE FLOOR AREA OF THAT COMPARTMENT.

4.7

THE AGGREGATE AREA OF OPENABLE WINDOWS ABOUT 298 SQUARE METRES EXCEEDING 6.25% OF THE FLOOR AREA OF THE STRUCTURE 1

 
 
 
LEGEND (FOR SCHEMATIC DIAGRAM)

	HOSE REEL W/ LOCKABLE GLASS FRONTED NOZZLE BOX, STRIKER, C/W FIRE ALARM BELL & BREAK GLASS UNIT
	150mm FIRE ALARM BELL
	BREAK GLASS UNIT
	FAST RESPONSE TYPE SPRINKLER HEAD
	FLOW SWITCH
	MONITORED GATE VALVE
	SPRINKLER ZONE SUBSIDIARY CONTROL VALVE ASSEMBLY INCLUDES ZONE SUBSIDIARY CONTROL VALVE, FLOW SWITCH, TEST GATE VALVE AND DRAIN VALVE
	GATE VALVE
	NON RETURN VALVE
	VORTEX INHIBITOR
	BALL FLOAT VALVE
	PRESSURE SWITCH
	PRESSURE GAUGE WITH COCK
	AUTOMATIC AIR VENT WITH COCK
	SPRINKLER / HOSE REEL PIPE
	SPRINKLER CONTROL VALVE SET
	LEVEL SWITCH (HIGH LEVEL SIGNAL & LOW LEVEL SIGNAL)
	FLEXIBLE CONNECTOR
	CHECK METER POSITION
	PLUG
	Y-STRAINER
	SPRINKLER / F.S. INLET
	SPRINKLER PROVING PIPE

DRAWING LIST:

DRAWING NO.	REVISION	DRAWING TITLE
FS-01	B	F.S. NOTES., BLOCK PLAN, LEGEND, ABBREVIATION, DRAWING LIST, PIPE MATERIAL SCHEDULE, PUMP SCHEDULE, VERTICAL LINE DIAGRAM,
FS-02	B	FIRE SERVICES INSTALLATION LAYOUT PLAN

LEGEND (FOR LAYOUT PLAN)

	HOSE REEL W/ LOCKABLE GLASS FRONTED NOZZLE BOX, STRIKER, C/W FIRE ALARM BELL & BREAK GLASS UNIT
	150mm FIRE ALARM BELL
	BREAK GLASS UNIT
	SPRINKLER HEAD
	SPRINKLER HEAD (DOUBLE LAYER)
	FLOW SWITCH
	MONITORED GATE VALVE
	SPRINKLER ZONE SUBSIDIARY CONTROL VALVE ASSEMBLY INCLUDES ZONE SUBSIDIARY CONTROL VALVE, FLOW SWITCH, TEST GATE VALVE AND DRAIN VALVE
	GATE VALVE
	NON RETURN VALVE
	VORTEX INHIBITOR
	BALL FLOAT VALVE
	SPRINKLER / HOSE REEL PIPE
	PRESSURE SWITCH
	SPRINKLER CONTROL VALVE SET
	CHECK METER POSITION
	SPRINKLER / F.S. INLET
	5Kg CO2 TYPE FIRE EXTINGUISHER
	4Kg DRY POWDER TYPE FIRE EXTINGUISHER
	PUMP
	150mm WATER ALARM GONG
	EMERGENCY LIGHTING
	EXIT SIGN
	ADDRESSABLE TYPE FIRE ALARM PANEL
	PUMP CONTROL PANEL



LOCATION PLAN

ABBREVIATION

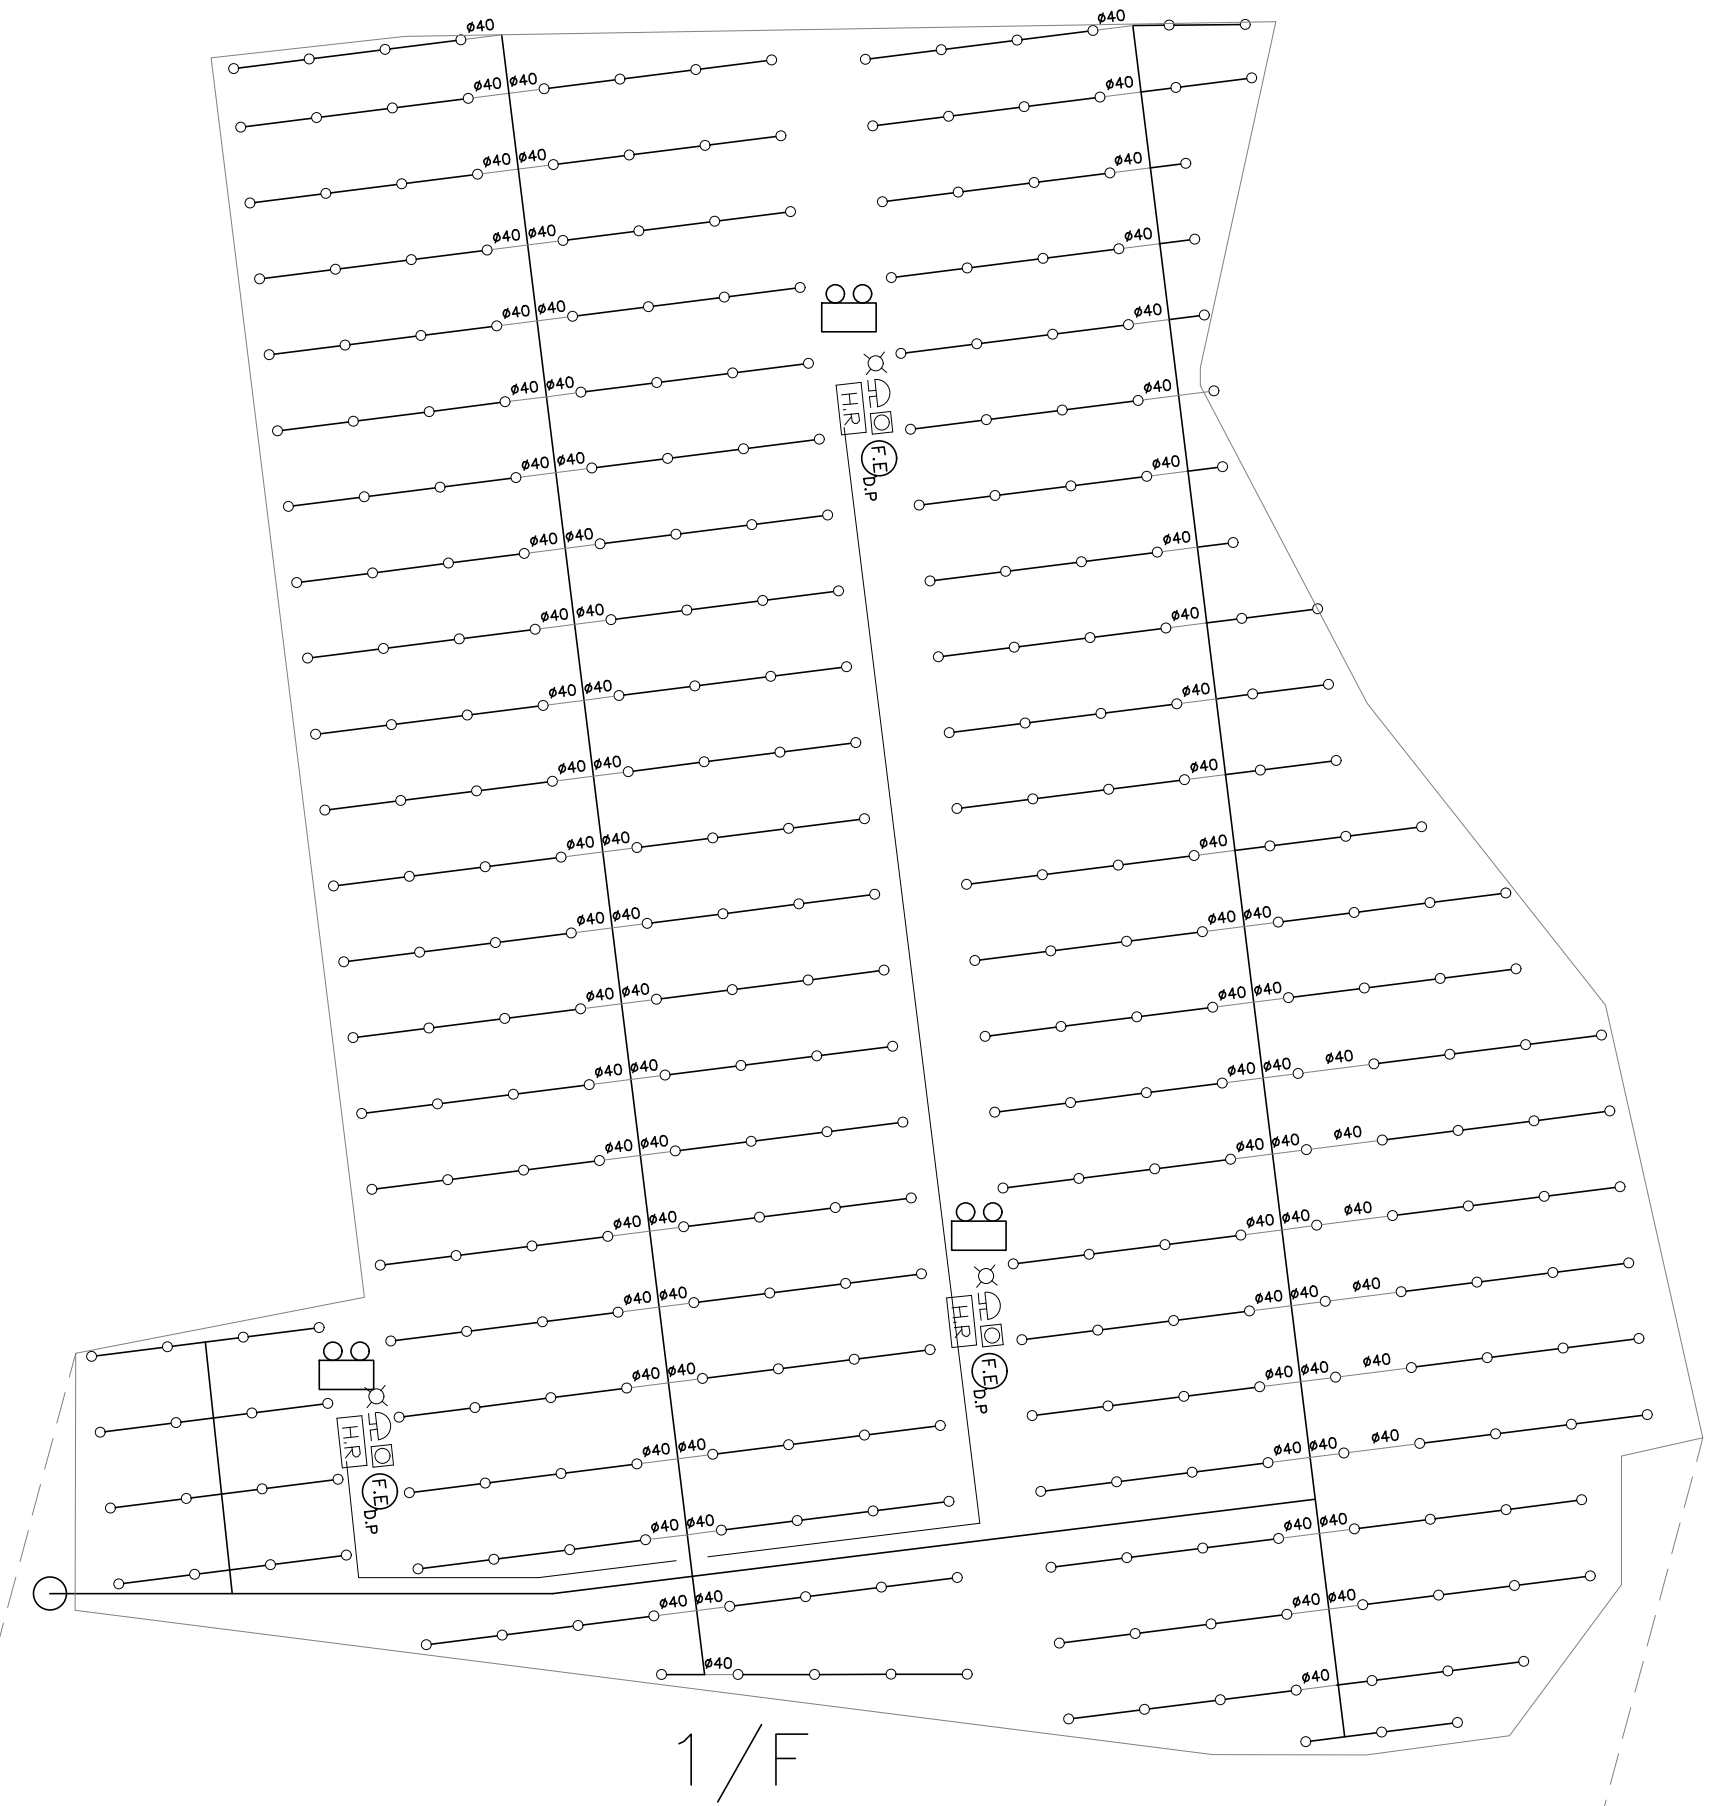
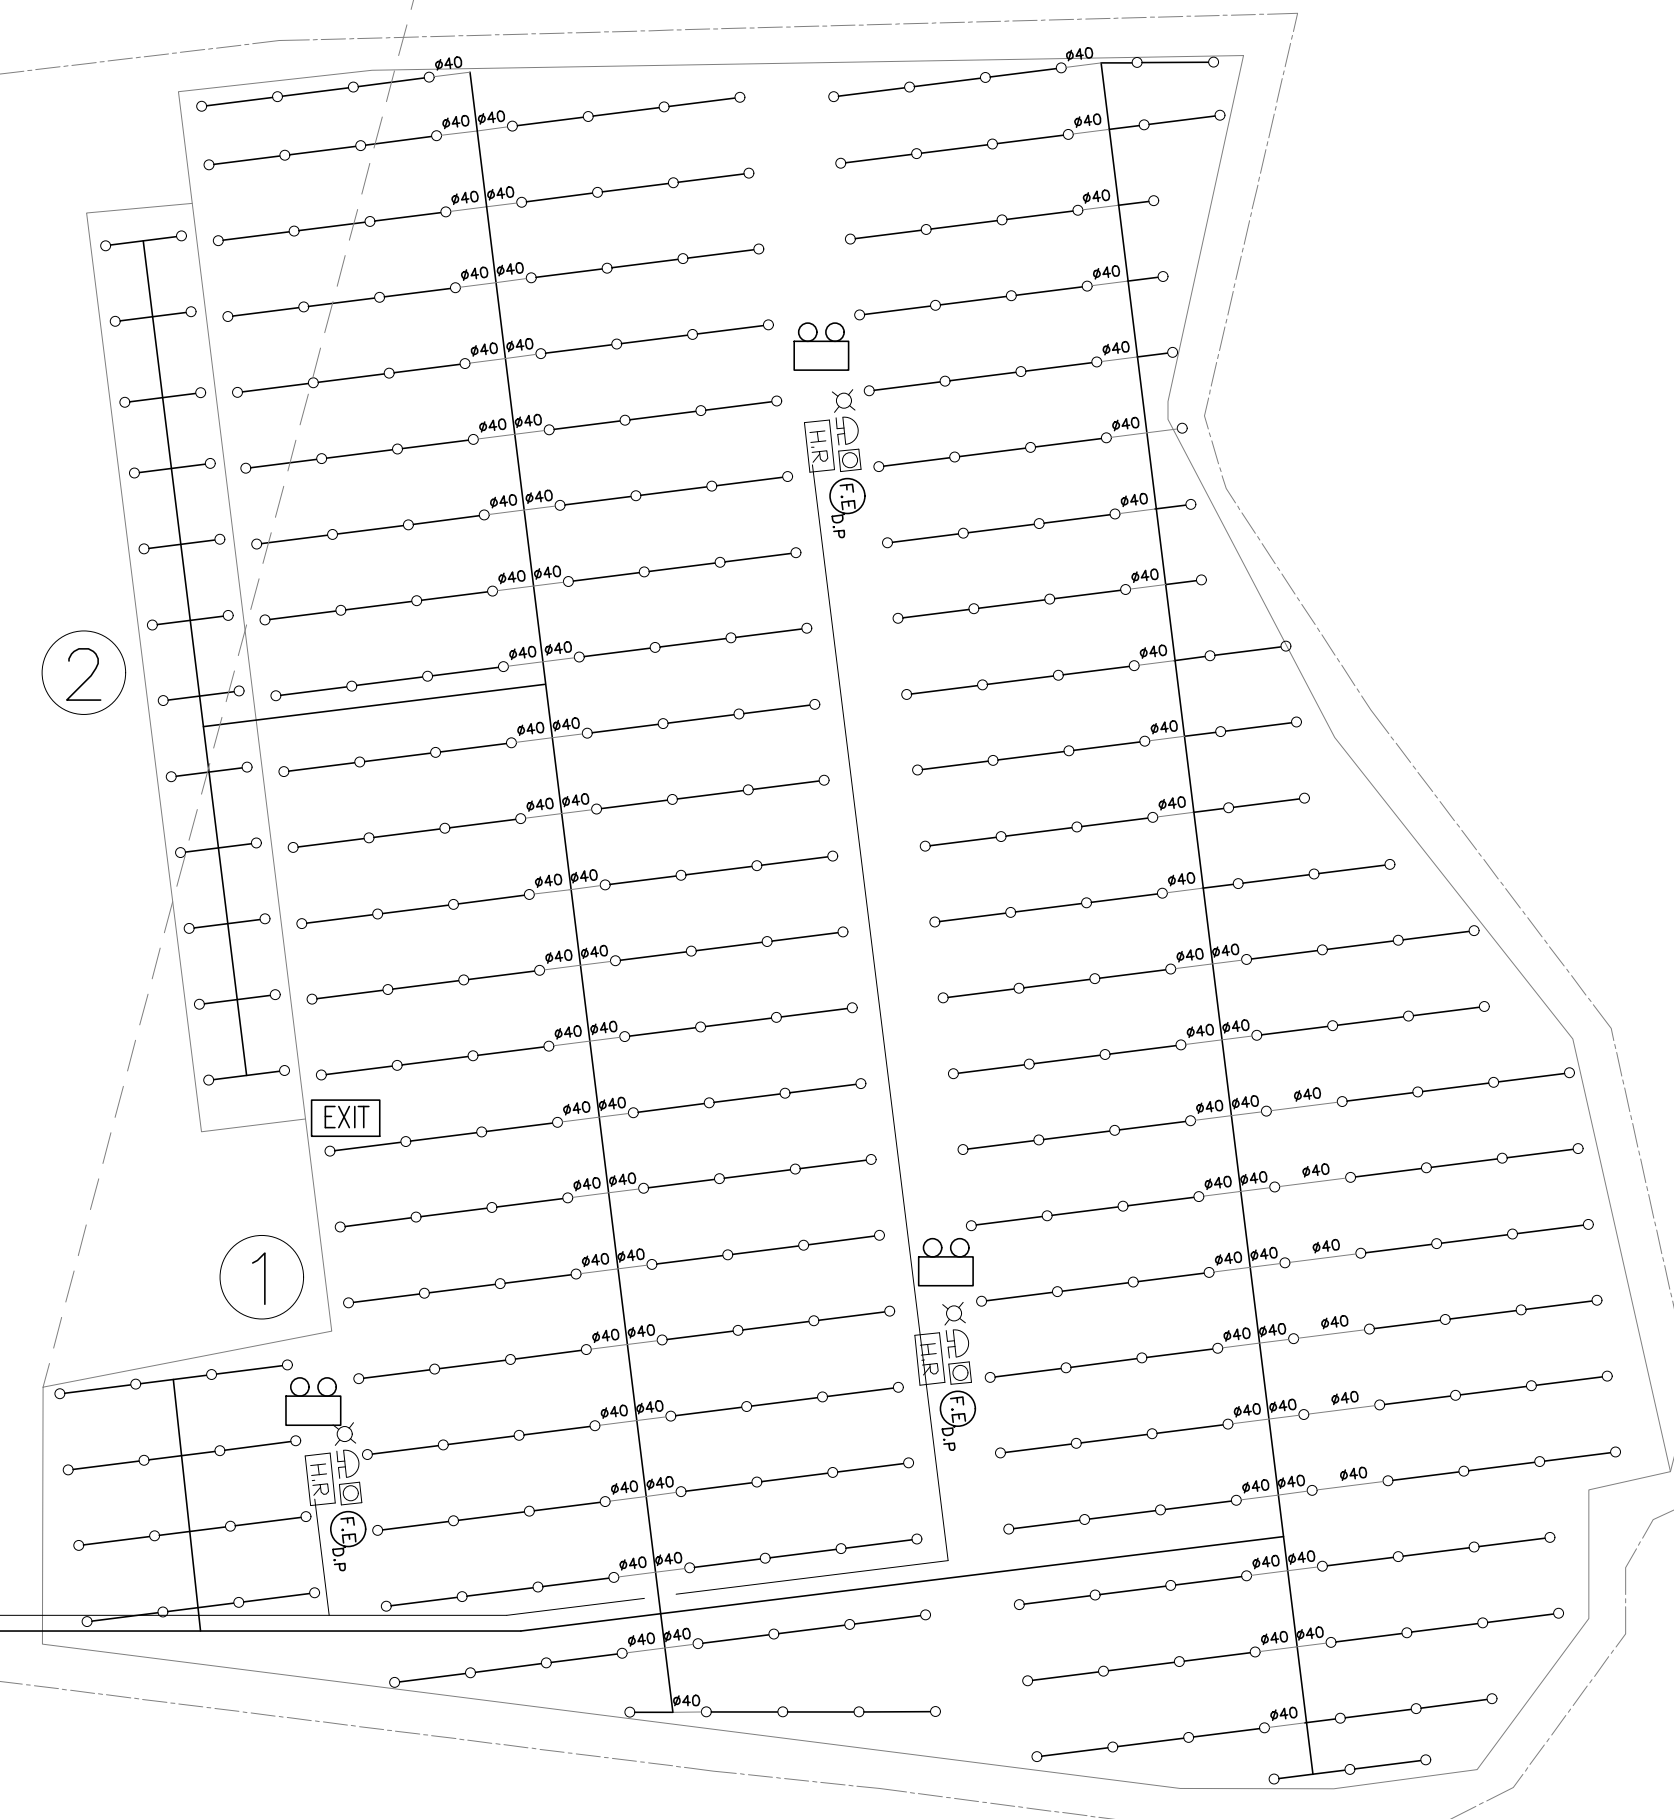
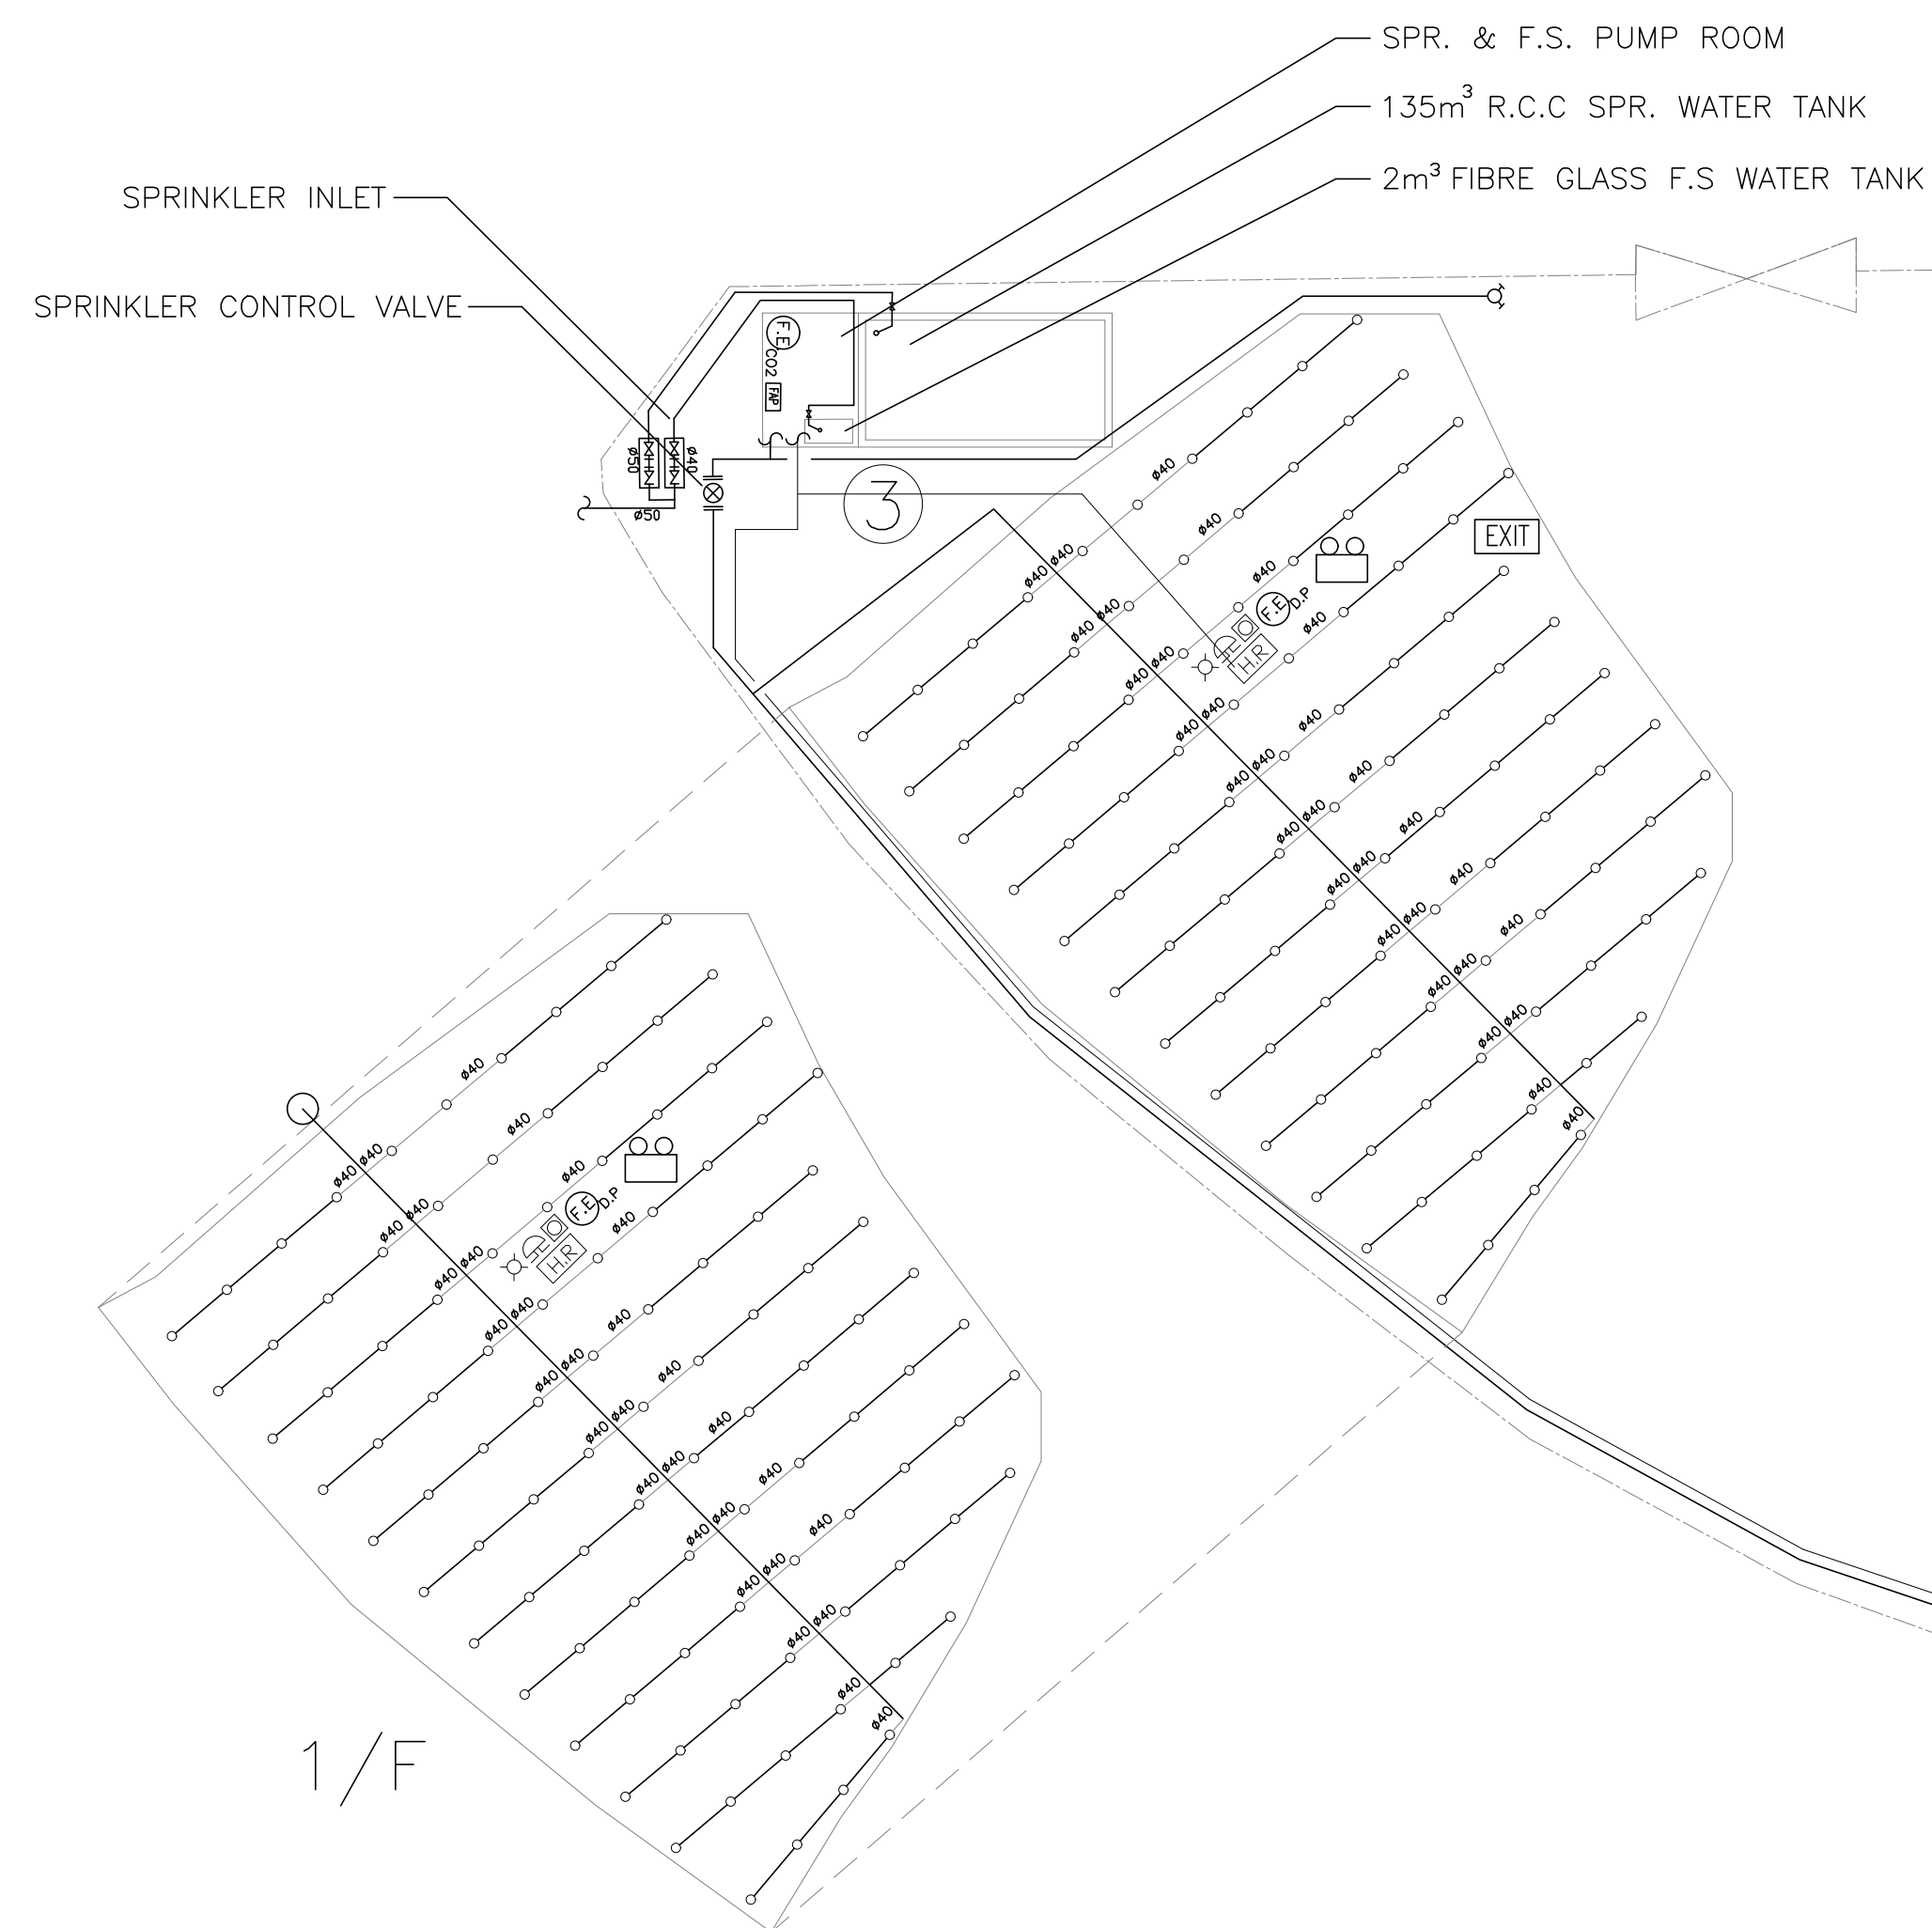
H.R.	HOSE REEL
F.S.	FIRE SERVICES
SPR.	SPRINKLER
U/G	UNDERGROUND
T/A	TO ABOVE
T/B	TO BELOW
F/A	FROM ABOVE
F/B	FROM BELOW
H/L	HIGH LEVEL
M/L	MIDDLE LEVEL
L/L	LOW LEVEL
W/	WITH
FFL	FINISHED FLOOR LEVEL
FE	FIRE EXTINGUISHER
DP	DESIGN POINT

COLOUR CODE

PIPE SIZES	COLOUR
ø25mm	LIGHT GREEN
ø32mm	RED
ø40mm	PURPLE
ø50mm	YELLOW
ø65mm	BLUE
ø80mm	GREEN
ø100mm	LIGHT BROWN
ø150mm	DEEP BROWN

A	FSD SUBMISSION	21-12-2025	WC
REV	DESCRIPTION	DATE	BY
FSI CONTRACTOR			
East Power Engineering Limited			
 Flat A, 7/F., Hop Shing Commercial Building, 41 Chi Kiang Street, Tseukwan, Kowloon Fax. : 2394-3772 Tel. : 2397-3236			
PROJECT FIRE SERVICES INSTALLATION WORK AT 東區中心			
DRAWING TITLE F.S. NOTES., BLOCK PLAN, LEGEND, ABBREVIATION, DRAWING LIST, PIPE MATERIAL SCHEDULE, PUMP SCHEDULE, VERTICAL LINE DIAGRAM,			
	INITIAL	DESIGNATION	DATE
DRAWN BY	WC	A. ENG	04-03-2025
DESIGN BY	CM	PM	04-03-2025
CHECK BY	CM	PM	04-03-2025
APPROVED BY	-	-	-
PROJECT NO.	■■■■■■■		
PAPER SIZE	A1	PLOT SCALE	1 : 1
DRAWING NO. EP-10247-FS01			
SCALE	N.T.S	REVISION	A

Structure No.	Uses	No. of Storey	Floor Area (m²)	Height (m)
1	Temporary Structure for Storage of XXX	2	3,103 x 2 = 6,206	13.0
2	Rain Shelter	1	182	9.0
3	Temporary Structure for Storage of XXX	2	936 x 2 = 1,872	13.0
4	Ancillary Office	2	53 x 2 = 106	5.0
5	Washroom	1	22	2.5
6	Meter Room	1	6	2.5



A	FSD SUBMISSION	21-12-2025	WC
REV	DESCRIPTION	DATE	BY
FSI CONTRACTOR			
East Power Engineering Limited Flat A, 7/F., Hop Shing Commercial Building, 41 Chi Kiang Street, Tsimshatsui, Kowloon Fax : 2394-3772 Tel : 2397-3238			
PROJECT FIRE SERVICES INSTALLATION WORK AT 港九九二街			
DRAWING TITLE			
FIRE SERVICES INSTALLATION LAYOUT PLAN			
	INITIAL	DESIGNATION	DATE
DRAWN BY	WC	A. ENG	04-03-2025
DESIGN BY	CM	PM	04-03-2025
CHECK BY	CM	PM	04-03-2025
APPROVED BY	-	-	-
PROJECT NO. 港九九二街			
PAPER SIZE	A1	PLOT SCALE	1 : 1
DRAWING NO.			
EP-10247-FS02			
SCALE	1 : 300 (A1)	REVISION	A