


**Structure 1,**  
tools storage units  
GFA: about 15 sqm  
Height: about 2.6m  
No. of storey: 1

**Structure 2,**  
Toilets units and portable drinking  
water point  
GFA: about 15 sqm (total)  
Height: about 2.6m  
No. of storey: 1

**Private Car Parking Spaces**

26 parking spaces of 5m x 2.5m  
for private car  
4 parking spaces of 7.5m x 3.5m  
for Van  
2 parking spaces of 5m x 3.8m  
for disabled

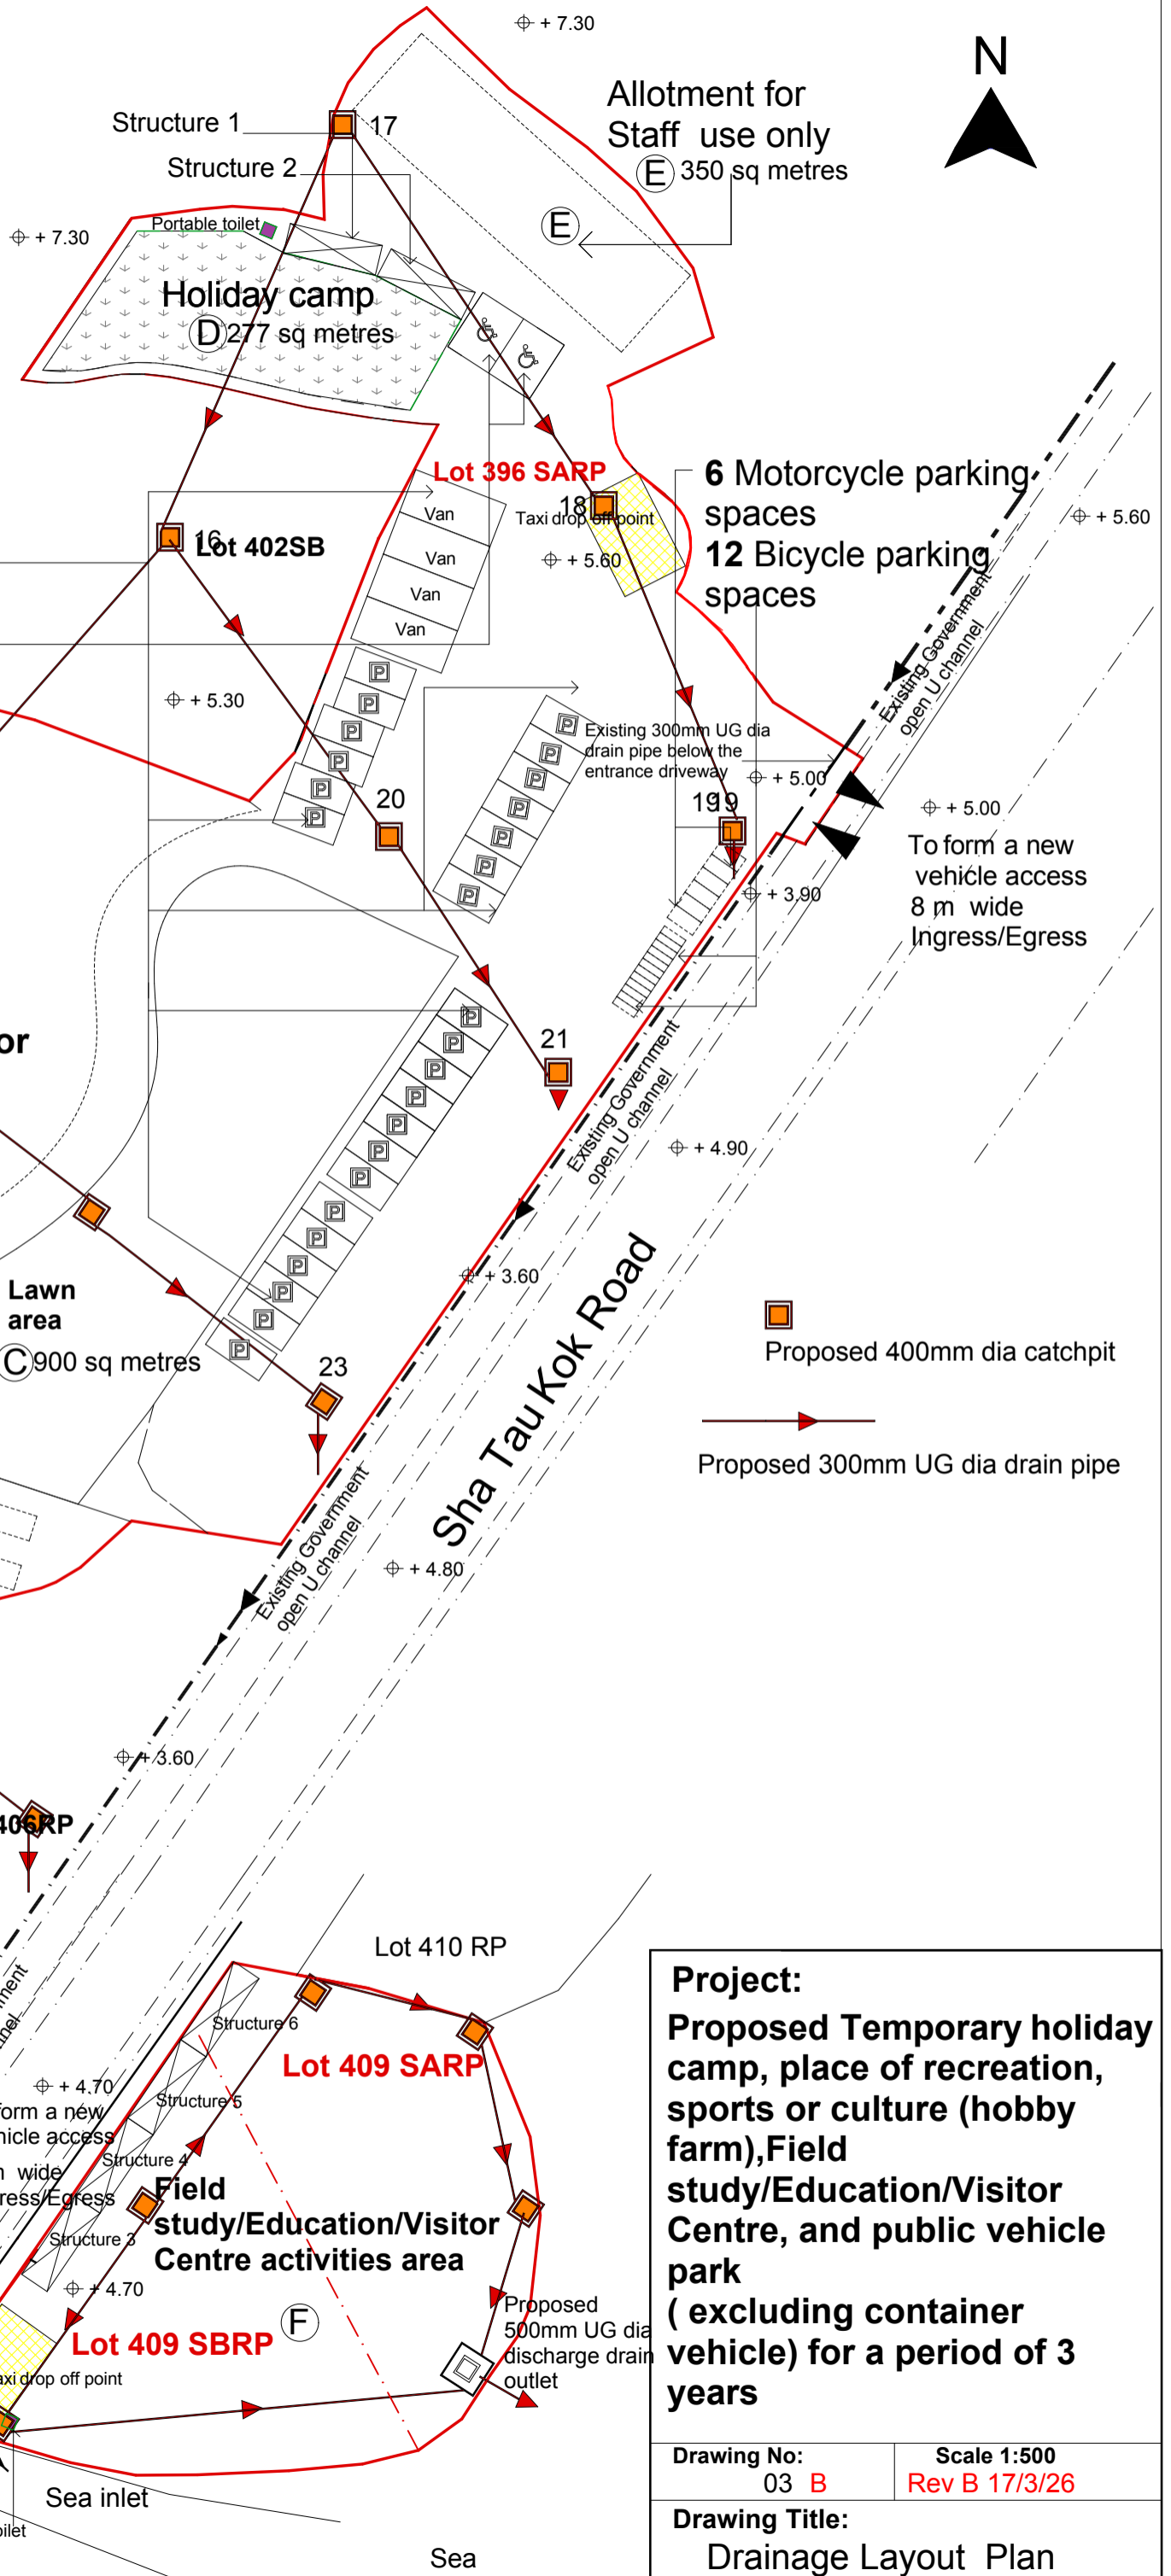

**Project:**  
Proposed Temporary holiday  
camp, place of recreation,  
sports or culture (hobby  
farm), Field  
study/Education/Visitor  
Centre, and public vehicle  
park  
(excluding container  
vehicle) for a period of 3  
years

Drawing No: 03 B	Scale 1:500 Rev B 17/3/26
Drawing Title: Drainage Layout Plan	