


B.D. Reference	地形圖參考
M.W. Reference	小型工程參考
L.D. Reference	地政署參考
F.S.D. Reference	消防處參考

Notes
Copyright Reserved nothing may be reprinted or utilized in any form or by any means without written permission from the M&D.

REV	DESCRIPTION	DATE
-----	-------------	------

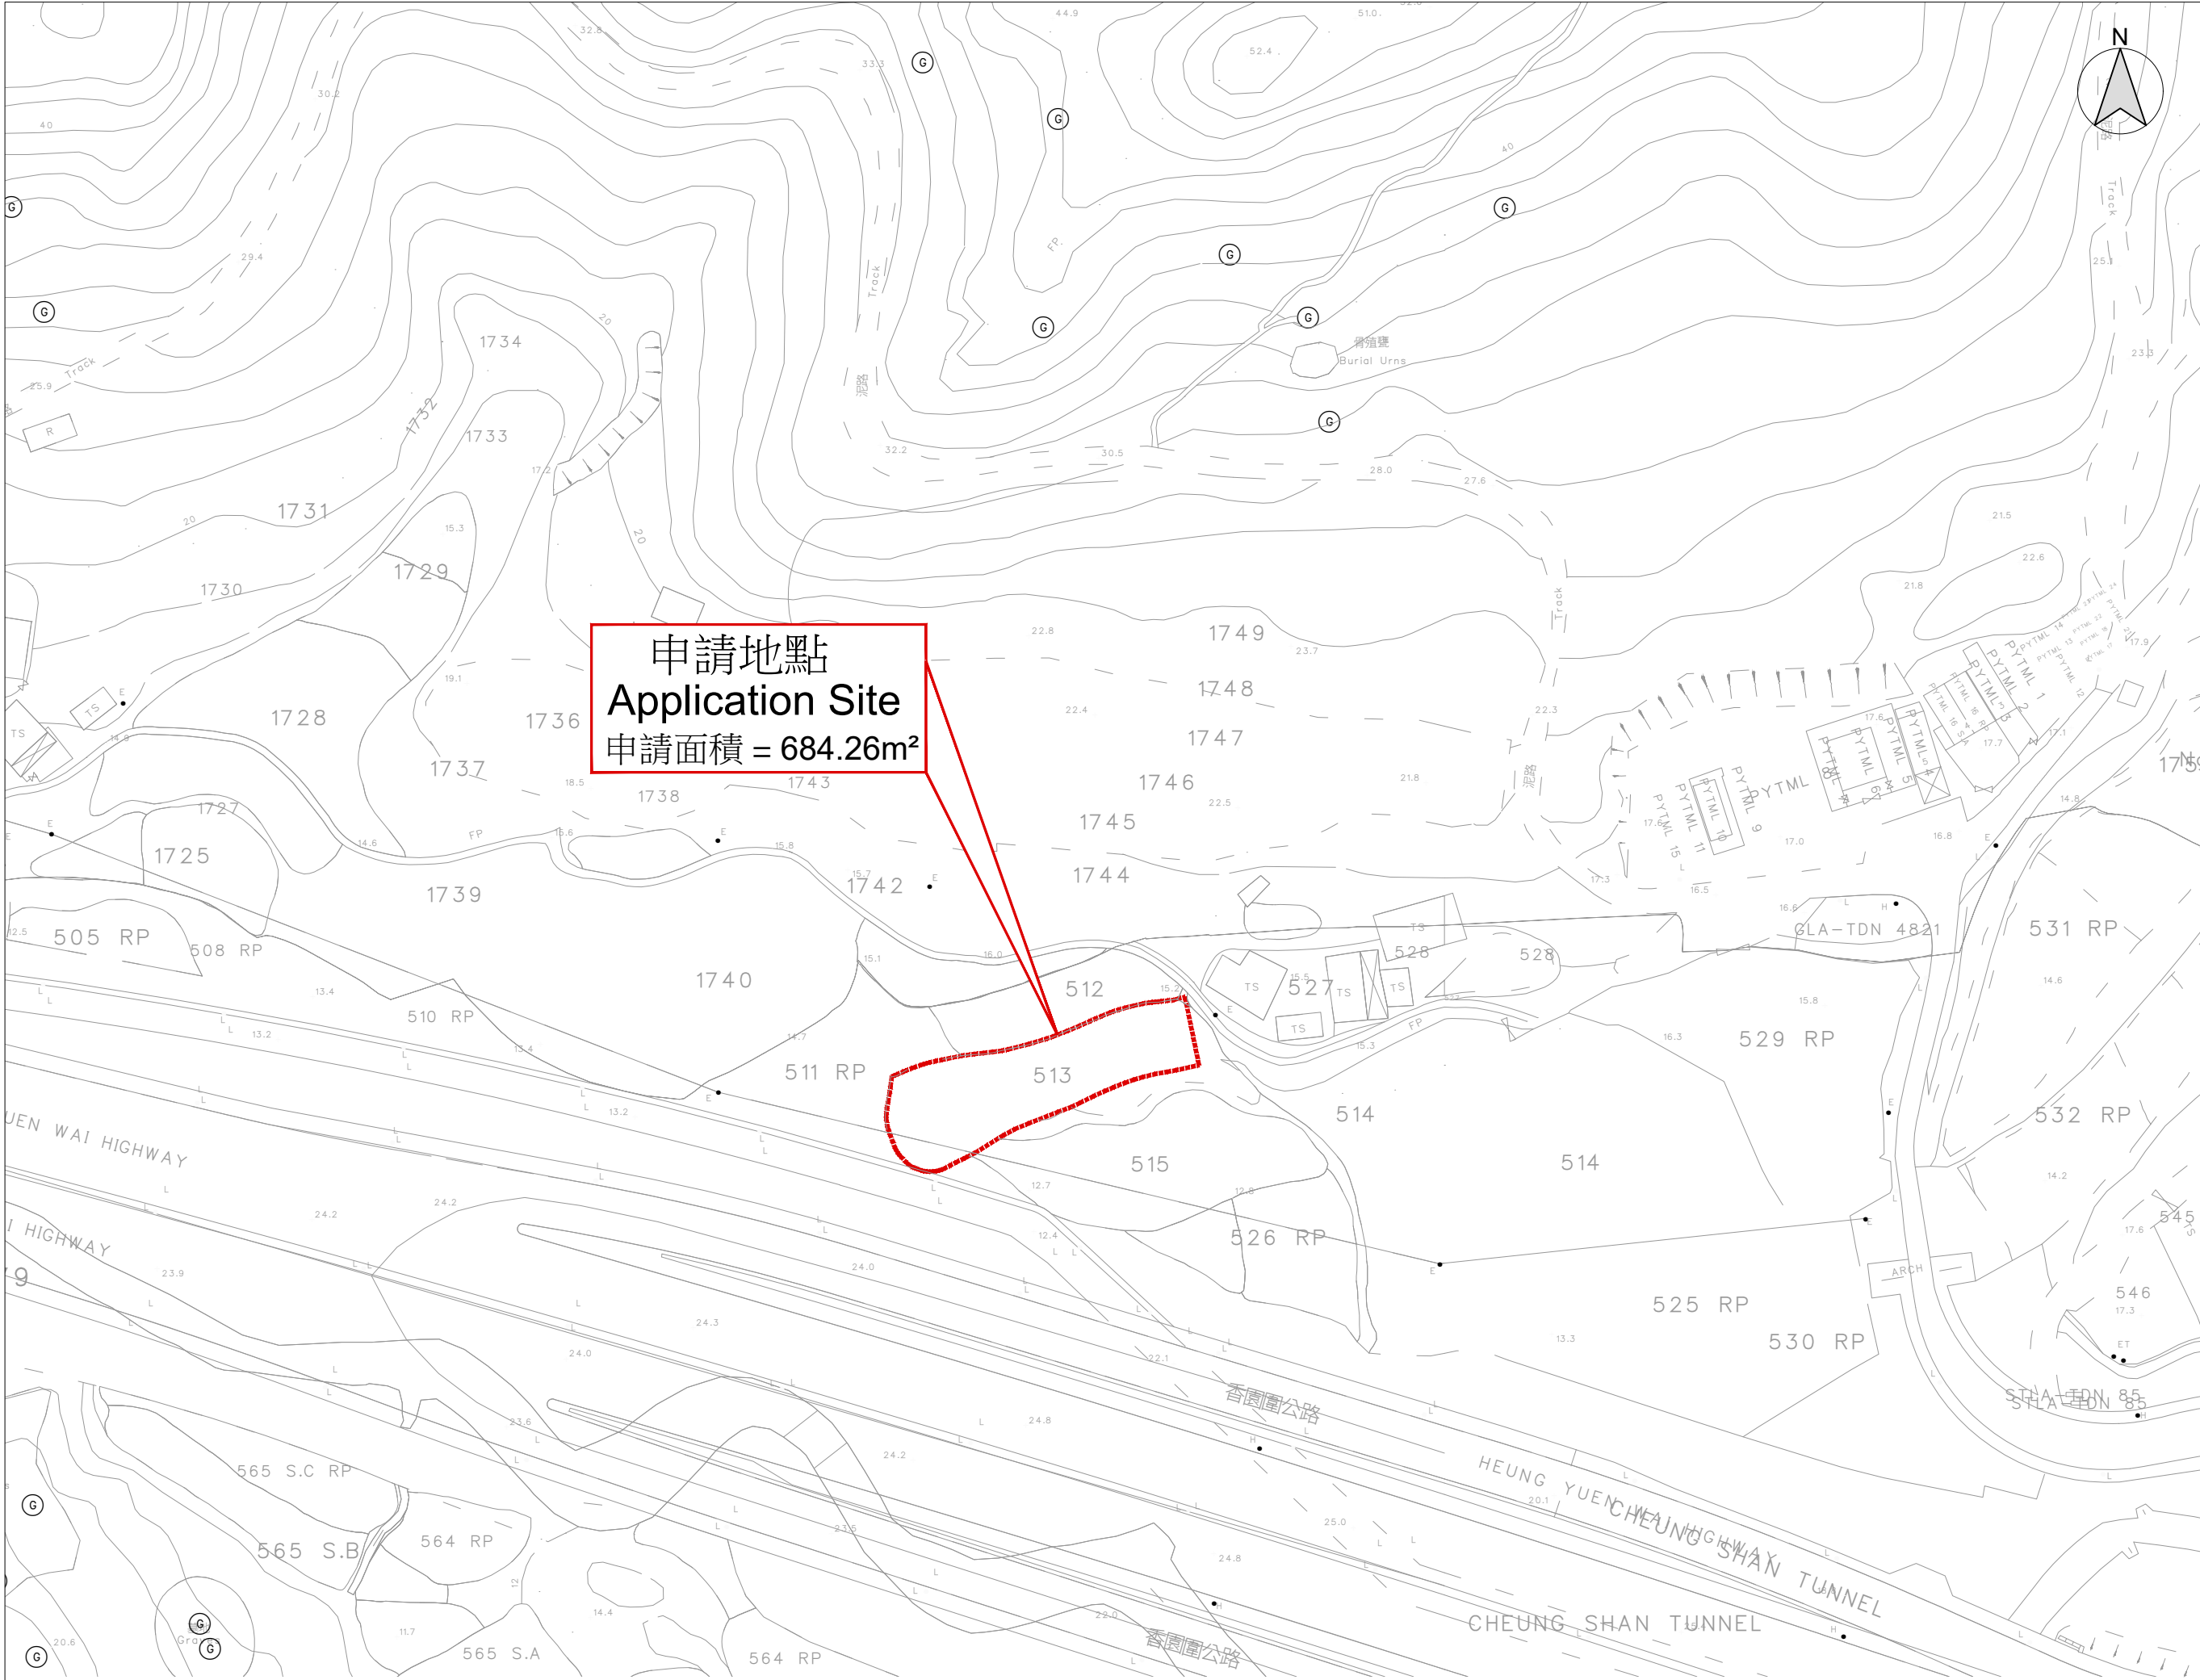

Project 項目

LOT 513(PART) IN D.D.79,
TA KWU LING,
NEW TERRITORIES

Application 申請

PROPOSED TEMPORARY PUBLIC
UTILITY INSTALLATION
(SOLAR ENERGY SYSTEM)
USE FOR A PERIOD OF 3 YEARS

Drawing Title 標題

LOCATION PLAN

Scale 比例 Revisions 修定

1:1000 (A3) —

Designed by 設計者 Drawn by 制圖人

LW Arthur

Checked by 檢查 Date 日期

LW 21-AUG-2025

Job No. 工程項目 Drawing No. 圖號

— LP-01