

Urgent Return receipt Expand Group Restricted Prevent Copy Confidential

Charlotte Tsz Wing WUN/PLAND

寄件者: [REDACTED]
寄件日期: 2026年06月08日星期一 19:22
收件者: tpbpd/PLAND
副本: Charlotte Tsz Wing WUN/PLAND
主旨: s16 No. A/NE-TK/859 : 補充文件
附件: A_NE-TK_859_FS Plan.pdf
類別: Internet Email


城規會/規劃處：

有關規劃許可：A/NE-TK/859 的申請，現附上消防圖。

如有什麼問題，請隨時聯絡我。

謝謝。

Ms Chong
[REDACTED]

 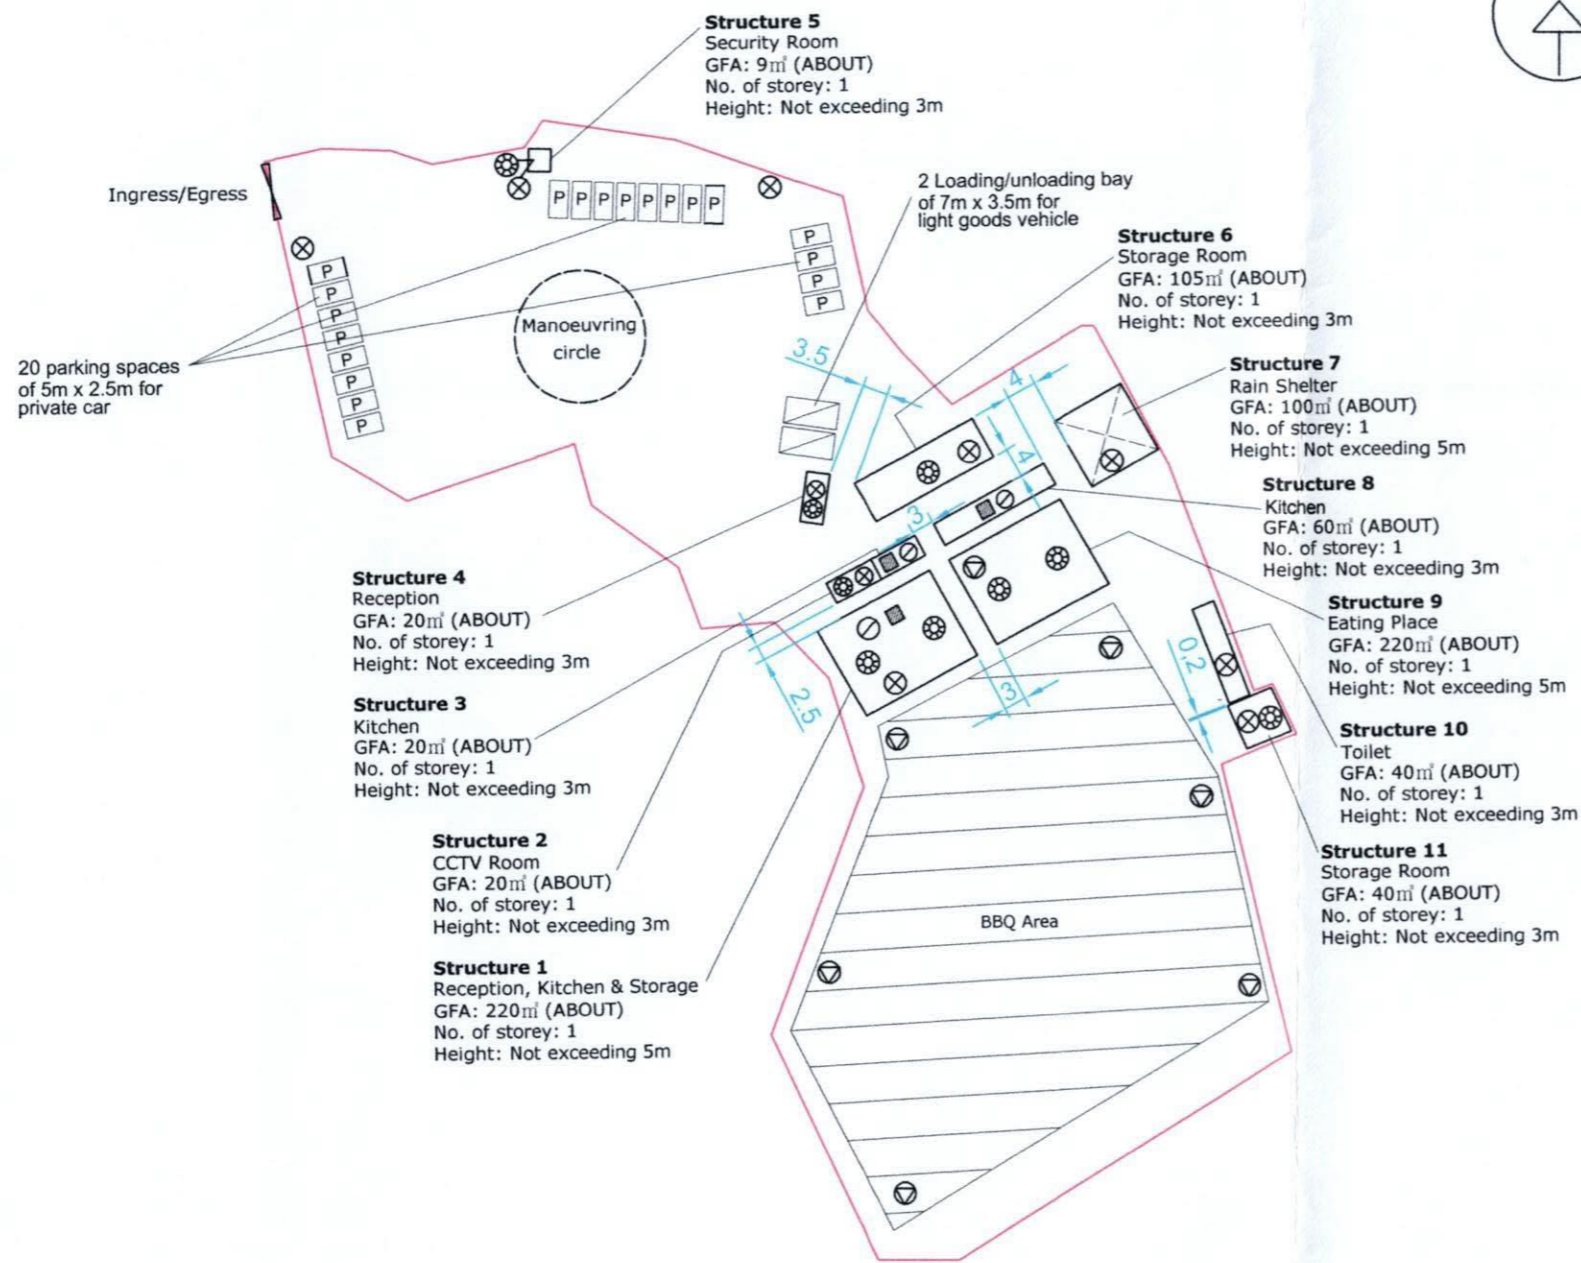


Legend:

- ⊗ 4kg dry powder type fire extinguisher
- ⊙ 5kg co2 gas type fire extinguisher
- ▨ fire blanket
- ⊖ 9 litre water/co2 type fire extinguisher
- ⊕ Stand-alone Fire Detector
- Lot Boundary

Fire Notes:

1. Sufficient portable hand-operated approved appliance shall be provided as required by occupancy and as marked on plans.
2. Stand-alone fire detector shall be provided for each structure as marked on plans. where two or more stand-alone fire detectors are installed in an enclosed structure, all detectors shall be interconnected (either wired or wirelessly), such that when one of the detectors is triggered, all connected detectors shall sound an alarm simultaneously.
3. The Stand-alone fire detector shall be provided in accordance with the "Stand-alone Fire Detector General Guidelines on Purchase, installation & Maintenance [Sep 2021]".

<p>INTERCEPT FIRE & SECURITY TECHNICIANS LIMITED</p> 	<p>Project:</p> <p>Proposed Temporary Eating Place and Barbecue Site with Ancillary Facilities and car park for a Period of 3 Years at Various Lots in D.D. 17 and Adjoining Government Land, Ting Kok, Tai Po, N, T</p>	<p>Title:</p> <p>Proposed Fire Service Installation Layout Plan</p>	<p>Drawn by:</p> <p>W.C.WONG</p>
			<p>Date:</p> <p>2026-05-20</p>
			<p>Scale:</p> <p>1:1000 @ A3</p>
			<p>Ref No:</p> <p>TPB/A/NE-TK/859</p>
			<p>Drawing No:</p> <p>2026/FS/32</p>