

 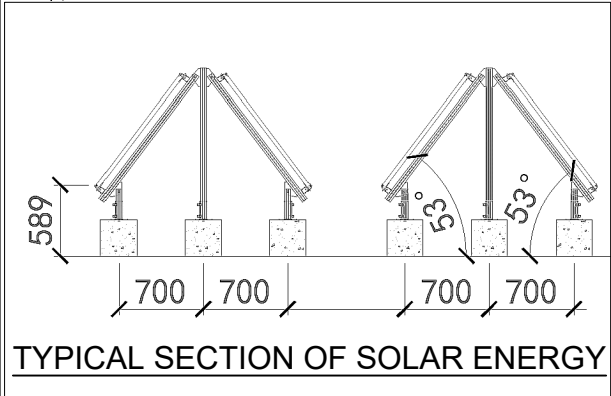


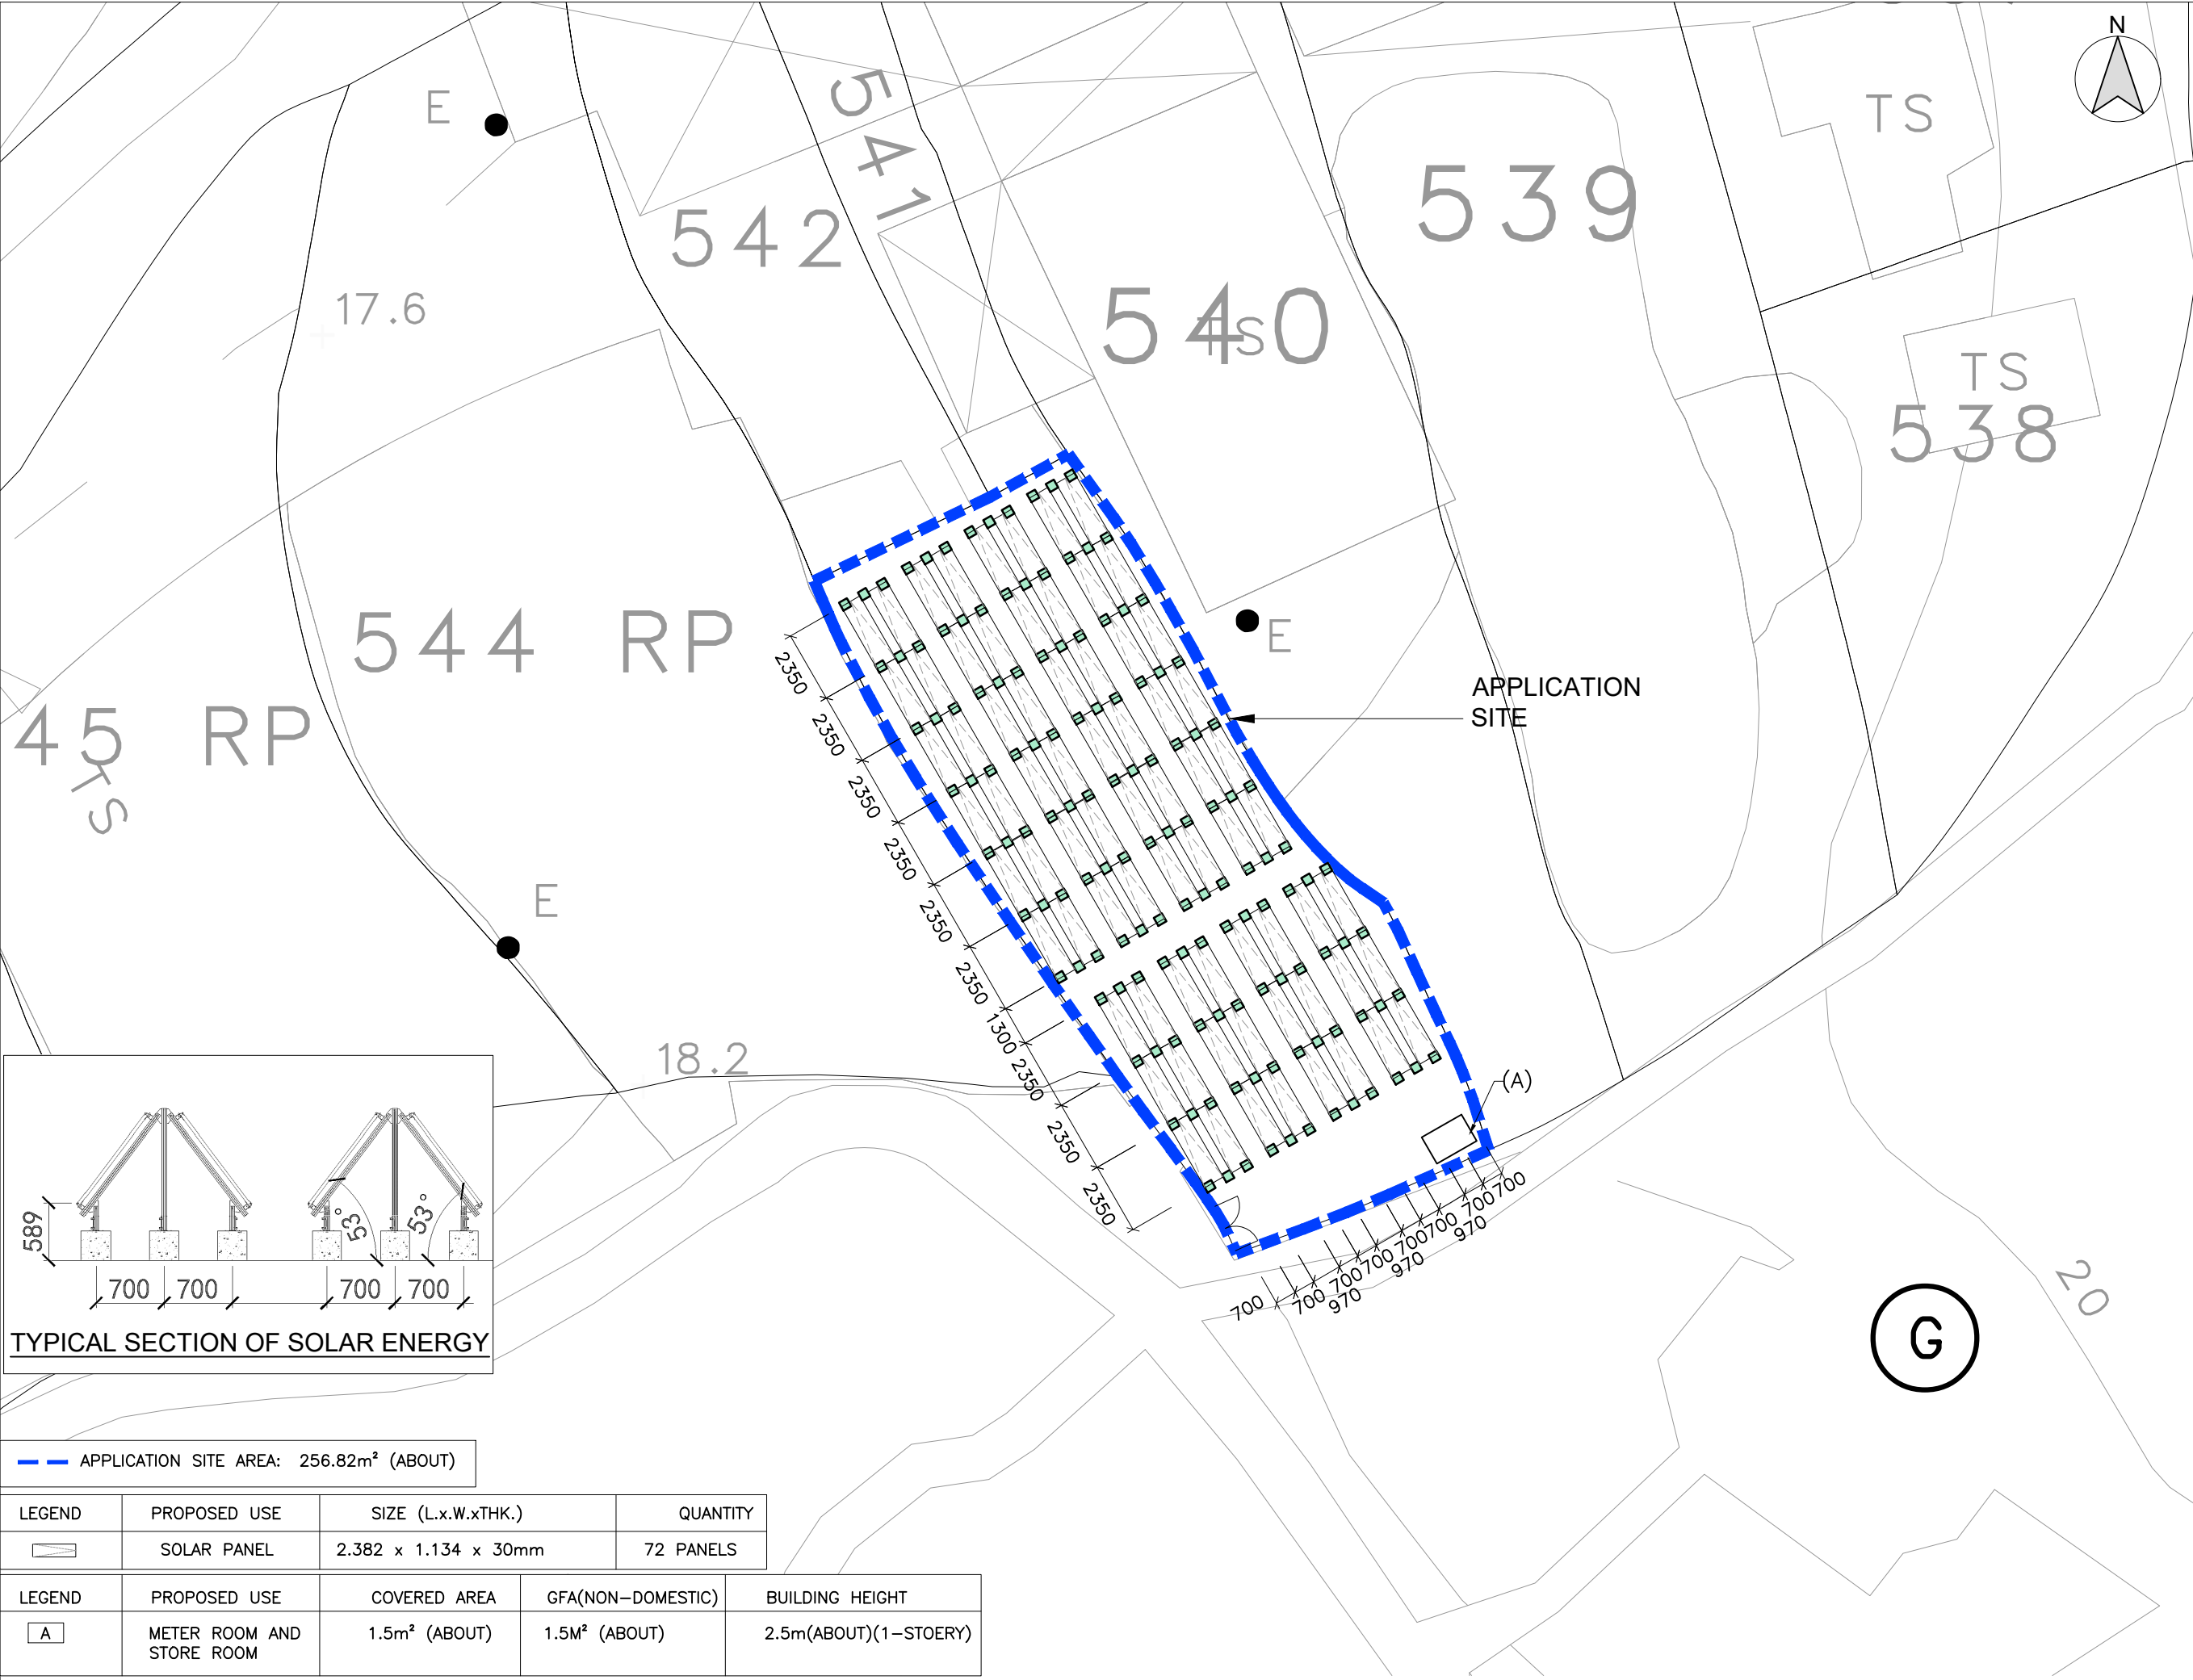

APPLICATION SITE AREA: 256.82m² (ABOUT)

LEGEND	PROPOSED USE	SIZE (L.x.W.xTHK.)	QUANTITY
	SOLAR PANEL	2.382 x 1.134 x 30mm	72 PANELS

LEGEND	PROPOSED USE	COVERED AREA	GFA(NON-DOMESTIC)	BUILDING HEIGHT
	METER ROOM AND STORE ROOM	1.5m ² (ABOUT)	1.5M ² (ABOUT)	2.5m(ABOUT)(1-STOERY)



B.D. Reference	電子圖檔案
M.W. Reference	小型工程檔案
L.D. Reference	地政署檔案
F.S.D. Reference	消防處檔案

Notes
Copyright Reserved nothing may be reprinted or utilized in any form or by any means without written permission from the M&D.

REV	DESCRIPTION	DATE
-----	-------------	------

M&D
Planning and
Construction
Consultant Ltd.

Tel: 2191 4088
Fax: 3105 0810
Email: sales@moderneng.com.hk

Project
DD79 LOT 543

Application
PROPOSED TEMPORARY PUBLIC
UTILITY INSTALLATION
(SOLAR ENERGY SYSTEM)
USE FOR A PERIOD OF 3 YEARS

Drawing Title
PROPOSED LAYOUT PLAN

Scale	比例	Revisions	修定
1:200 (A3)		—	
Designed by LW	設計者	Drawn by Arthur	制圖人
Checked by LW	校核	Date 27-MAY-2025	日期
Job No. —	工程項目	Drawing No. LP-01	圖號