
 


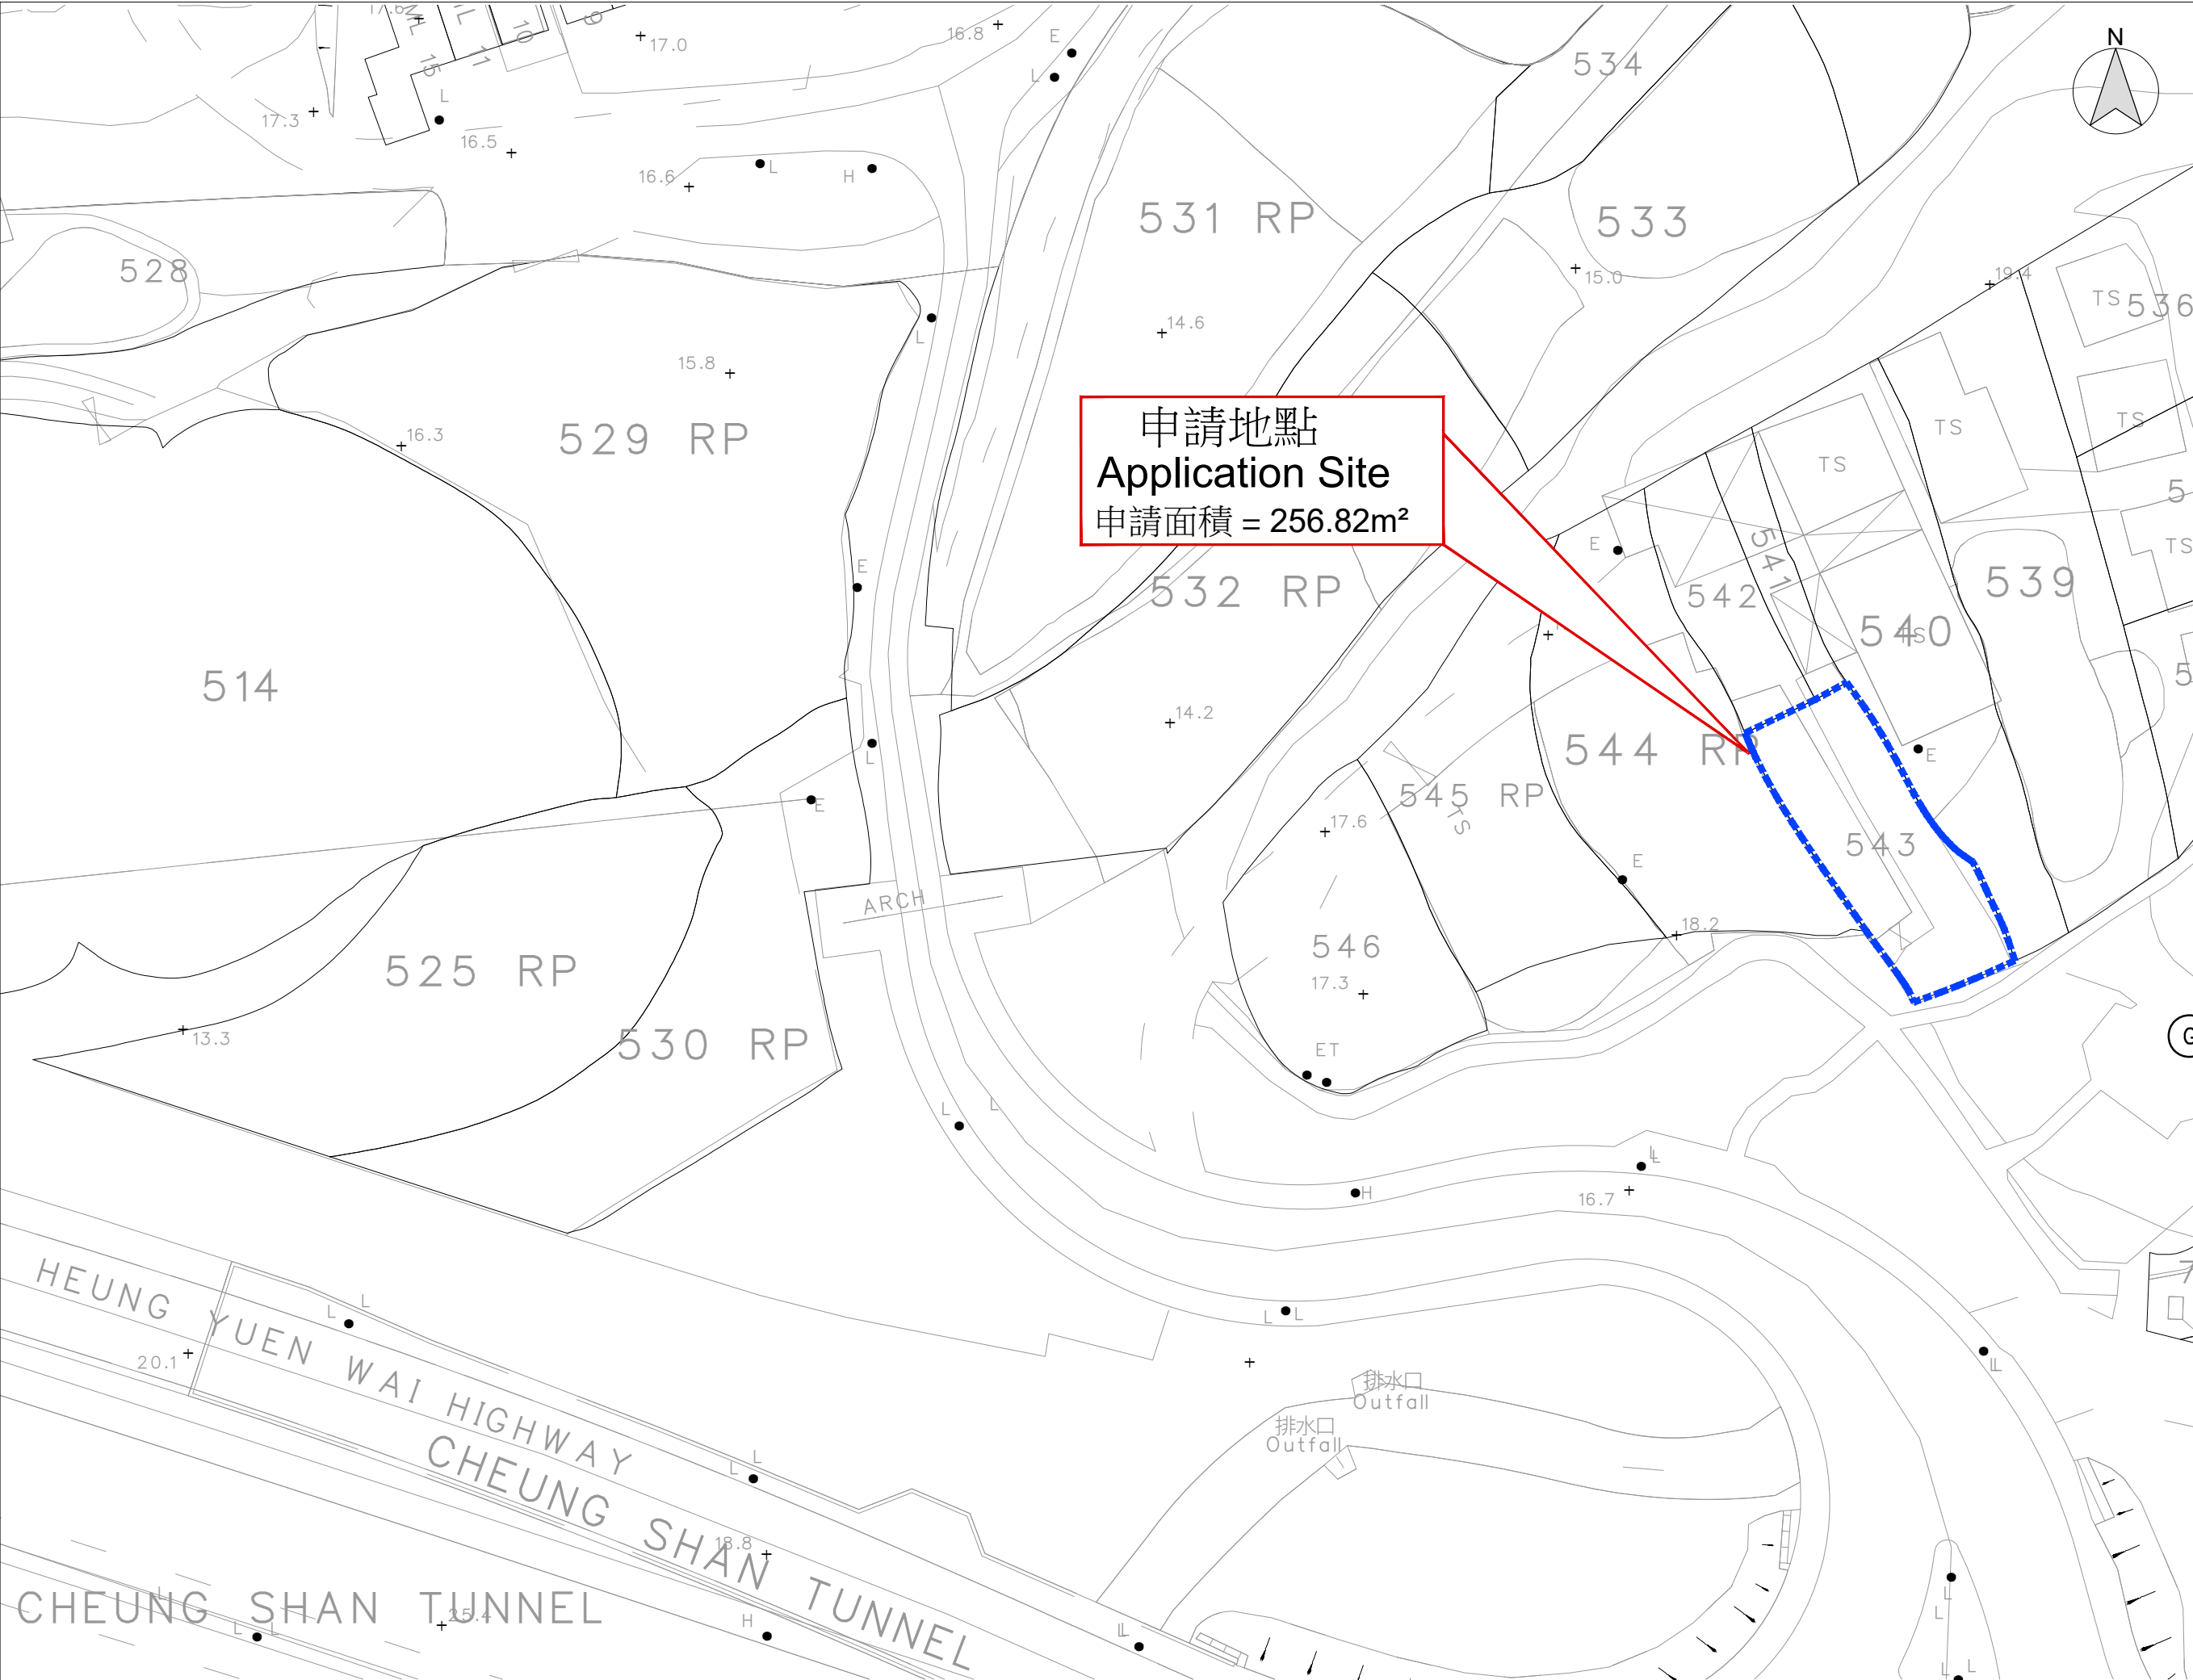

申請地點
Application Site
申請面積 = 256.82m²



B.D. Reference	基本圖則
M.W. Reference	小型工程圖則
L.D. Reference	地政署圖則
F.S.D. Reference	消防處圖則

Notes
Copyright Reserved nothing may be reprinted or utilized in any form or by any means without written permission from the M&D.

REV	DESCRIPTION	DATE

M&D
Planning and Construction Consultant Ltd.

Tel: 2191 4088
Fax: 3105 0810
Email: sales@moderneng.com.hk

Project
DD79 LOT 543

Application
PROPOSED TEMPORARY PUBLIC UTILITY INSTALLATION (SOLAR ENERGY SYSTEM) USE FOR A PERIOD OF 3 YEARS

Drawing Title LOCATION PLAN	
Scale 1:1000 (A3)	Revisions —
Designed by LW	Drawn by Arthur
Checked by LW	Date 25-APR-2025
Job No. —	Drawing No. LP-01