


AU PUI WAN STREET

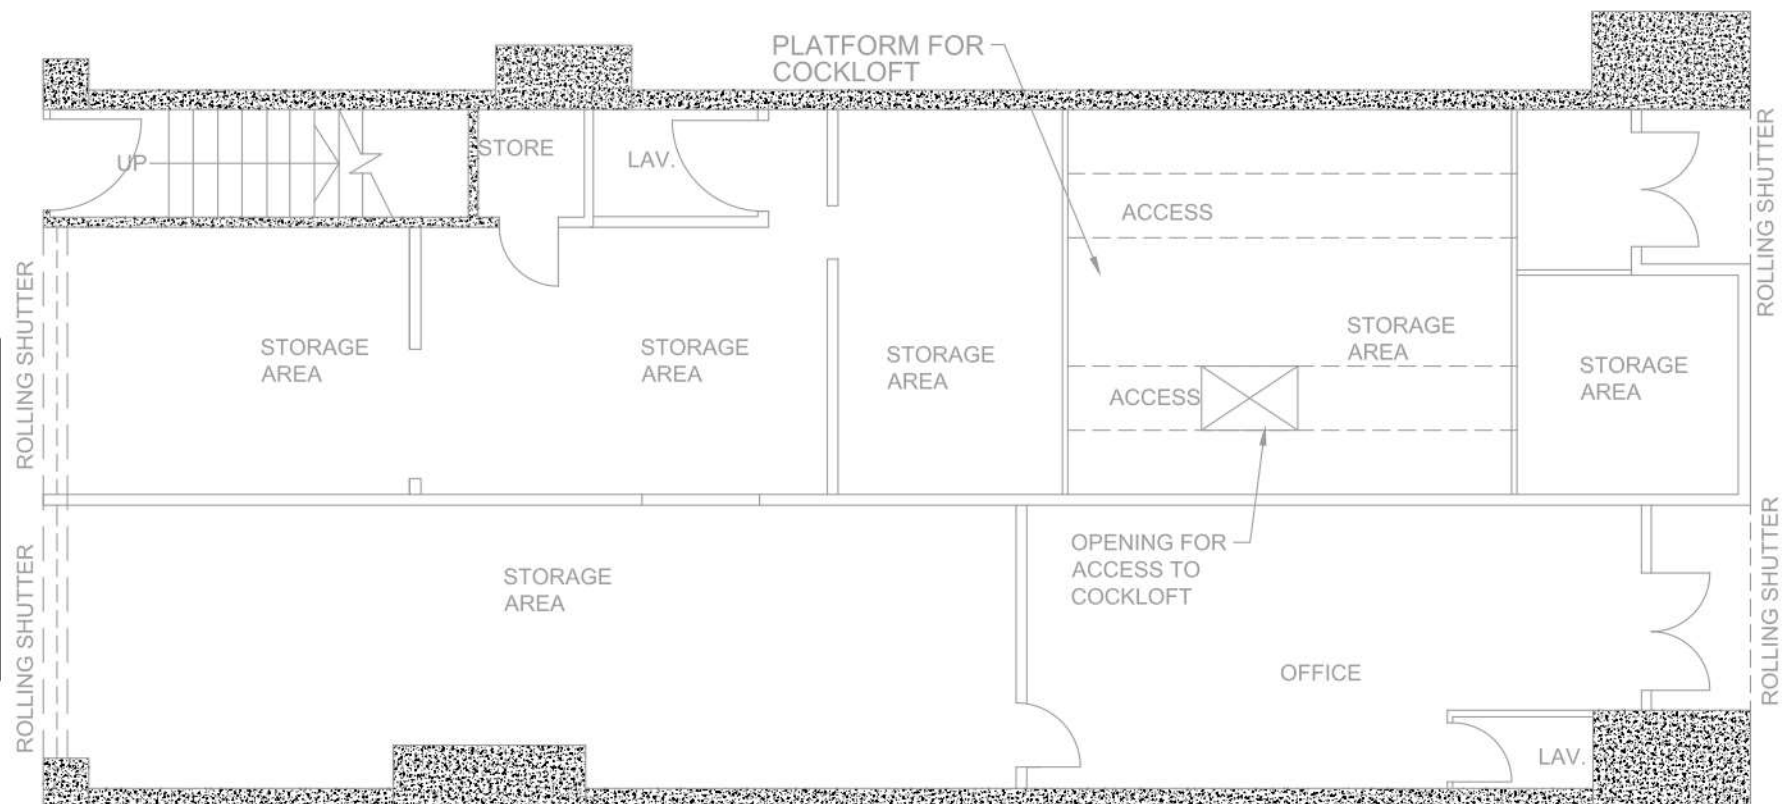

GROUND FLOOR PLAN

NOTES:

REV.	DATE	DESCRIPTION	BY
B	26.7.16	GENERAL REVISION	C.K.L.
A	27.2.14	GENERAL REVISION	C.K.L.

FS CONTRACTOR :
MARVEL FIRE ENGINEERING CO., LTD
威達消防工程有限公司
2/F., Tai Nam Commercial Building,
169 Tai Nam Street, Kowloon
TEL : 2393 1037 FAX : 2399 7863

PROJECT
UNIT 5A, G/F, VERISTRONG
INDUSTRIAL CENTRE
34-36 AU PUI WAN STREET,
FO TAN.

DRAWING TITLE
ALTERATION & ADDITIONAL
WORKS FOR FIRE SERVICES
INSTALLATION AT UNIT 5A
ON G/F

DRAWING NO
PJ-VIC-L-001

FILE NAME
FS-01.DWG

DATE	SCALE	REV.
04/2013	1:100	B
DESIGN	DRAWN	APPROVAL
C.K.LAM	C.K.LAM	IVAN
CHECKED IVAN		