


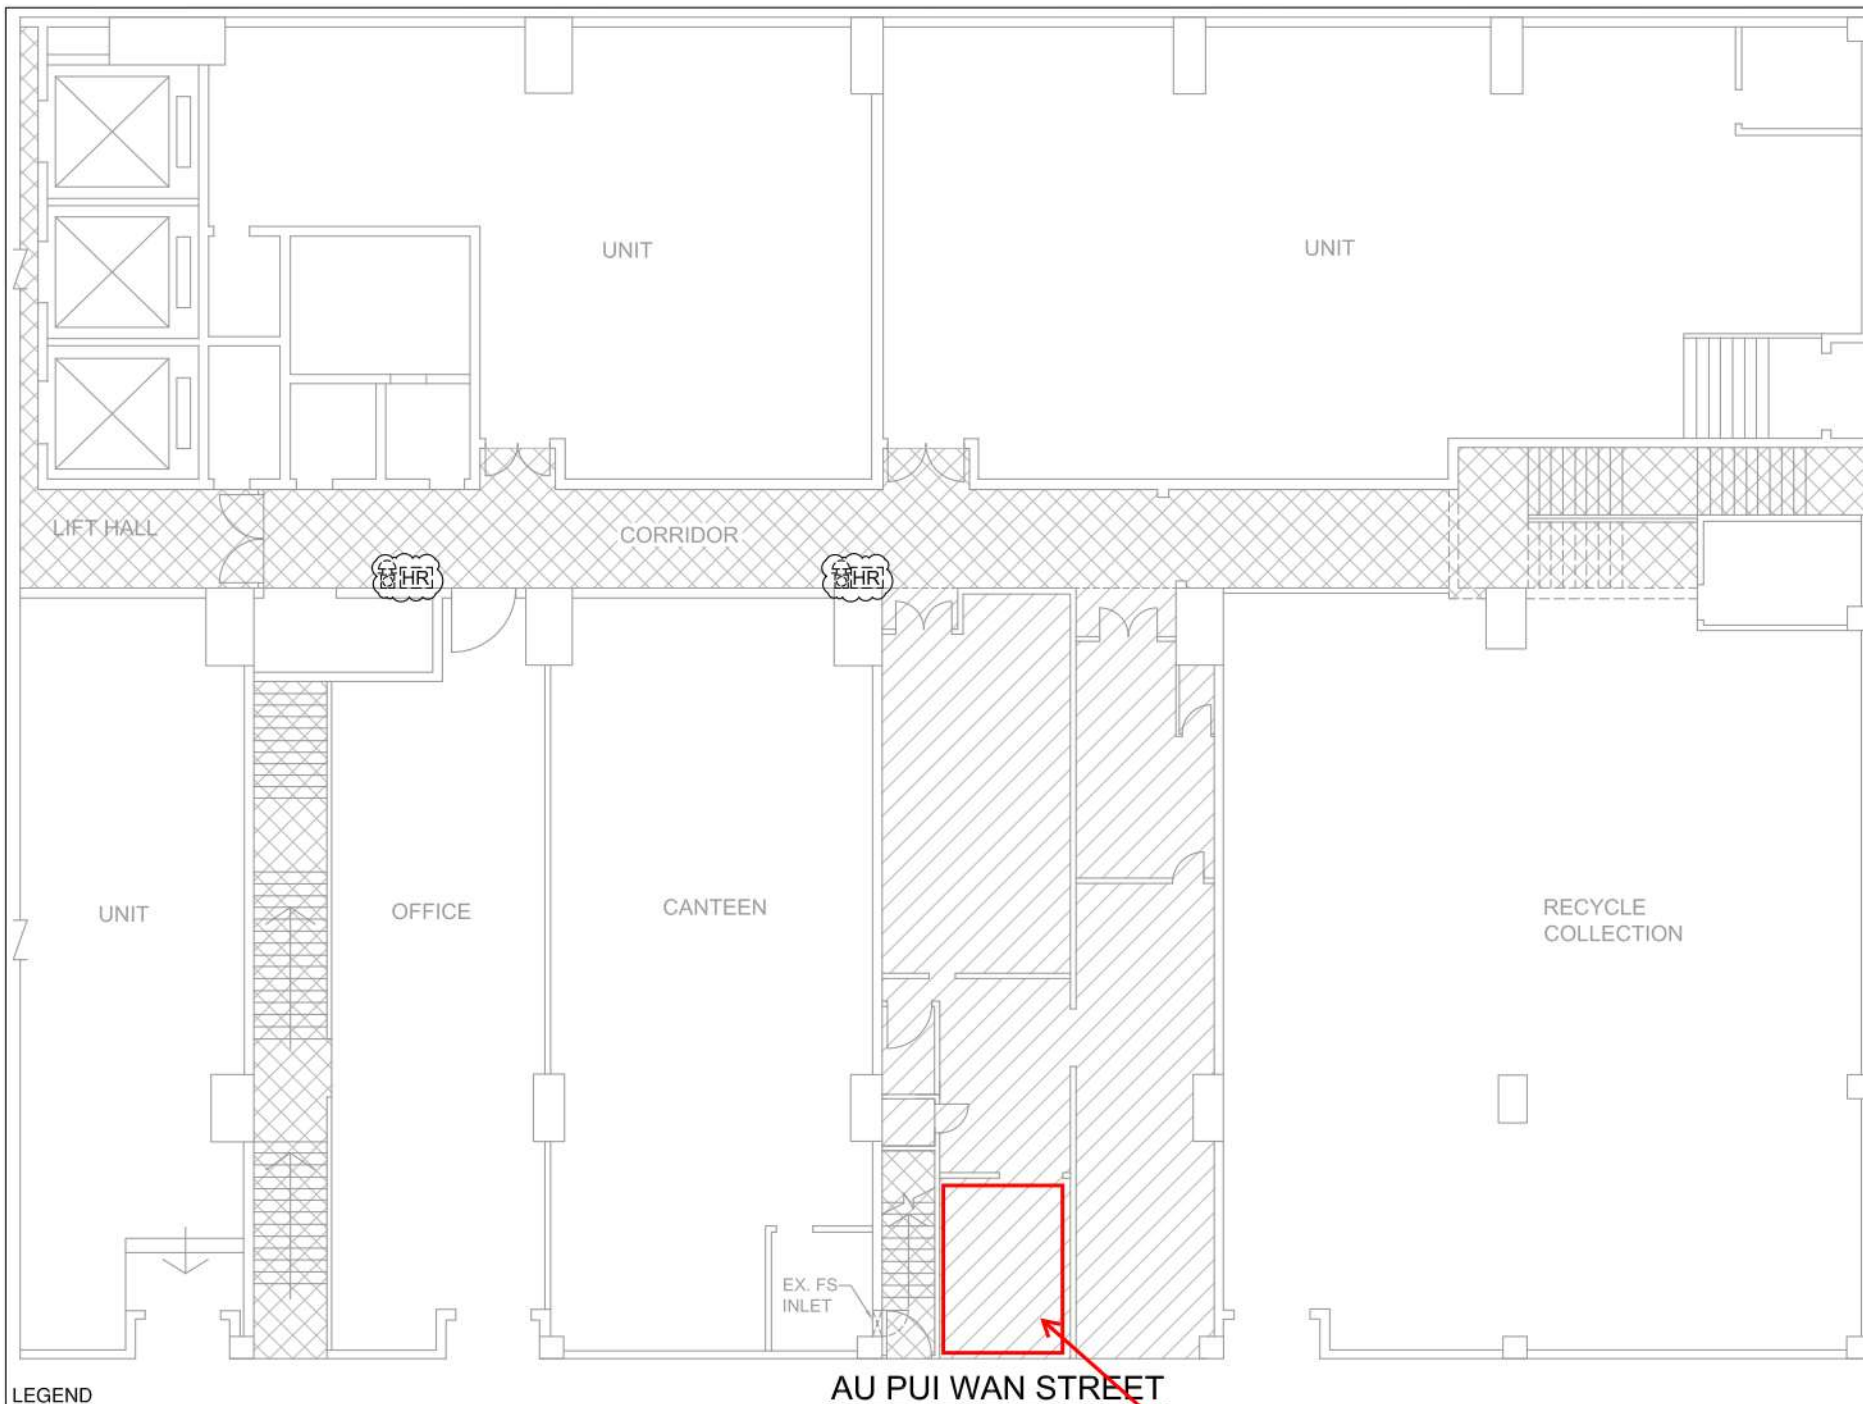

LEGEND

- EXISTING HOSEREEL SET
- EXISTING FIRE ALARM BELL
- EXISTING MANUAL CALL POINT
- SHADED PREMISE AREA IS AT G/F, UNIT 5A TO APPLY FOR COMMERCIAL USE
- SHADED PUBLIC AREA TO BE PROTECTED BY THE EXISTING SPRINKLER SYSTEM

NOTES:

1 05/2013/PSD COMMENTED ON 20/5/13/CKL

REV. DATE DESCRIPTION BY
 PS CONTRACTOR :
 MARVEL FIRE ENGINEERING CO., LTD
 威達消防工程有限公司
 2/F, Tai Nam Commercial Building,
 140 Tai Nam Street, Kowloon,
 TEL : 2303 0157 FAX : 2300 7883

PROJECT
 UNIT 5A/B/G/F, VERISTRONG
 INDUSTRIAL CENTRE
 34-36 AU PUI WAN STREET,
 FO TAN.

DRAWING TITLE
 ALTERATION & ADDITIONAL
 WORKS FOR FIRE SERVICES
 INSTALLATION AT UNIT 5A/B
 ON G/F

DRAWING NO
 PJ-VIC-L-002

FILE NAME
 FS-01.DWG

DATE 04/2013 SCALE 1:100 REV. 0

DESIGN C.K.LAM DRAWN C.K.LAM

CHECKED IVAN APPROVAL IVAN

申請地點豐盛工業中心地下5A 舖(部份)