


Appendix I

Fire Service Installations Proposal

DEVELOPMENT PARAMETERS

APPLICATION SITE AREA : 3,595 m² (ABOUT)
COVERED AREA : NOT APPLICABLE
UNCOVERED AREA : 3,595 m² (ABOUT)

NO STRUCTURE IS PROPOSED AT THE APPLICATION SITE.

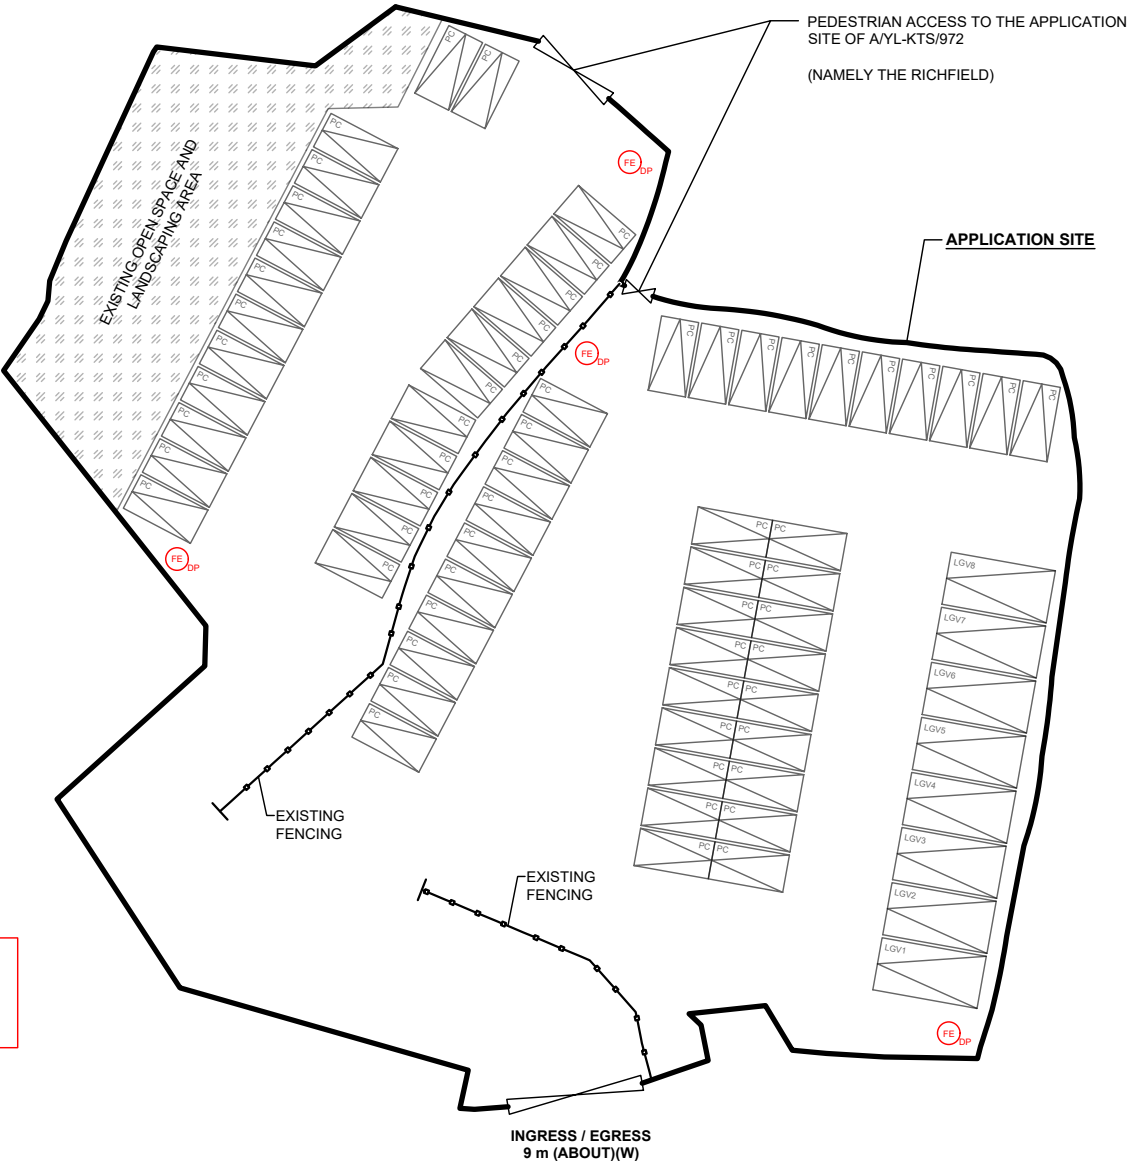

FIRE SERVICE INSTALLATIONS

FE DP 4 KG DRY POWER TYPE FIRE EXTINGUISHER


PARKING PROVISIONS

NO. OF PRIVATE CAR PARKING SPACE : 62
DIMENSIONS OF PARKING SPACE : 5 m (L) X 2.5 m (W)

NO. OF LIGHT GOODS VEHICLE PARKING SPACE : 8
DIMENSIONS OF PARKING SPACE : 7 m (L) X 3.5 m (W)

LEGEND

- APPLICATION SITE
- PARKING SPACE (PRIVATE CAR)
- PARKING SPACE (LIGHT GOODS VEHICLE)
- INGRESS / EGRESS

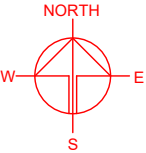

PLANNING CONSULTANT



PROJECT

PROPOSED TEMPORARY
PUBLIC VEHICLE PARK
(EXCLUDING CONTAINER
VEHICLE) FOR A PERIOD OF 5
YEARS

SITE LOCATION

VARIOUS LOTS IN D.D. 109, KAM
TIN, YUEN LONG, NEW
TERRITORIES

SCALE

1 : 500 @ A4

DRAWN BY

MN

CHECKED BY

DATE

APPROVED BY

DATE

DWG. TITLE

FSIs PROPOSAL

DWG NO.

APPENDIX I

VER.

001

Appendix II
Drainage Plan

PROPOSED DRAINAGE LAYOUT PLAN FOR
PUBLIC VEHICLE PARK IN VARIOUS LOTS IN
D.D. 109, KAM TIN, YUEN LONG, N.T.

NOTES:

PLAN DRAWN TO SCALE 1:500

CATCHPIT (CP9) WITH DESILTING FACILITY
SHALL FOLLOW CEDD STANDARD DRAWING
NO.: c2406I.

CATCHPIT AND UC FOLLOWS TYPICAL DETAILS
OF GEOTECHNICAL MANULA FOR SLOPE FIG.
8.10 AND FIG. 8.11 RESPECTIVELY

20/3/2025

