



Attachment 1

Revised Fire Service Installations Proposal

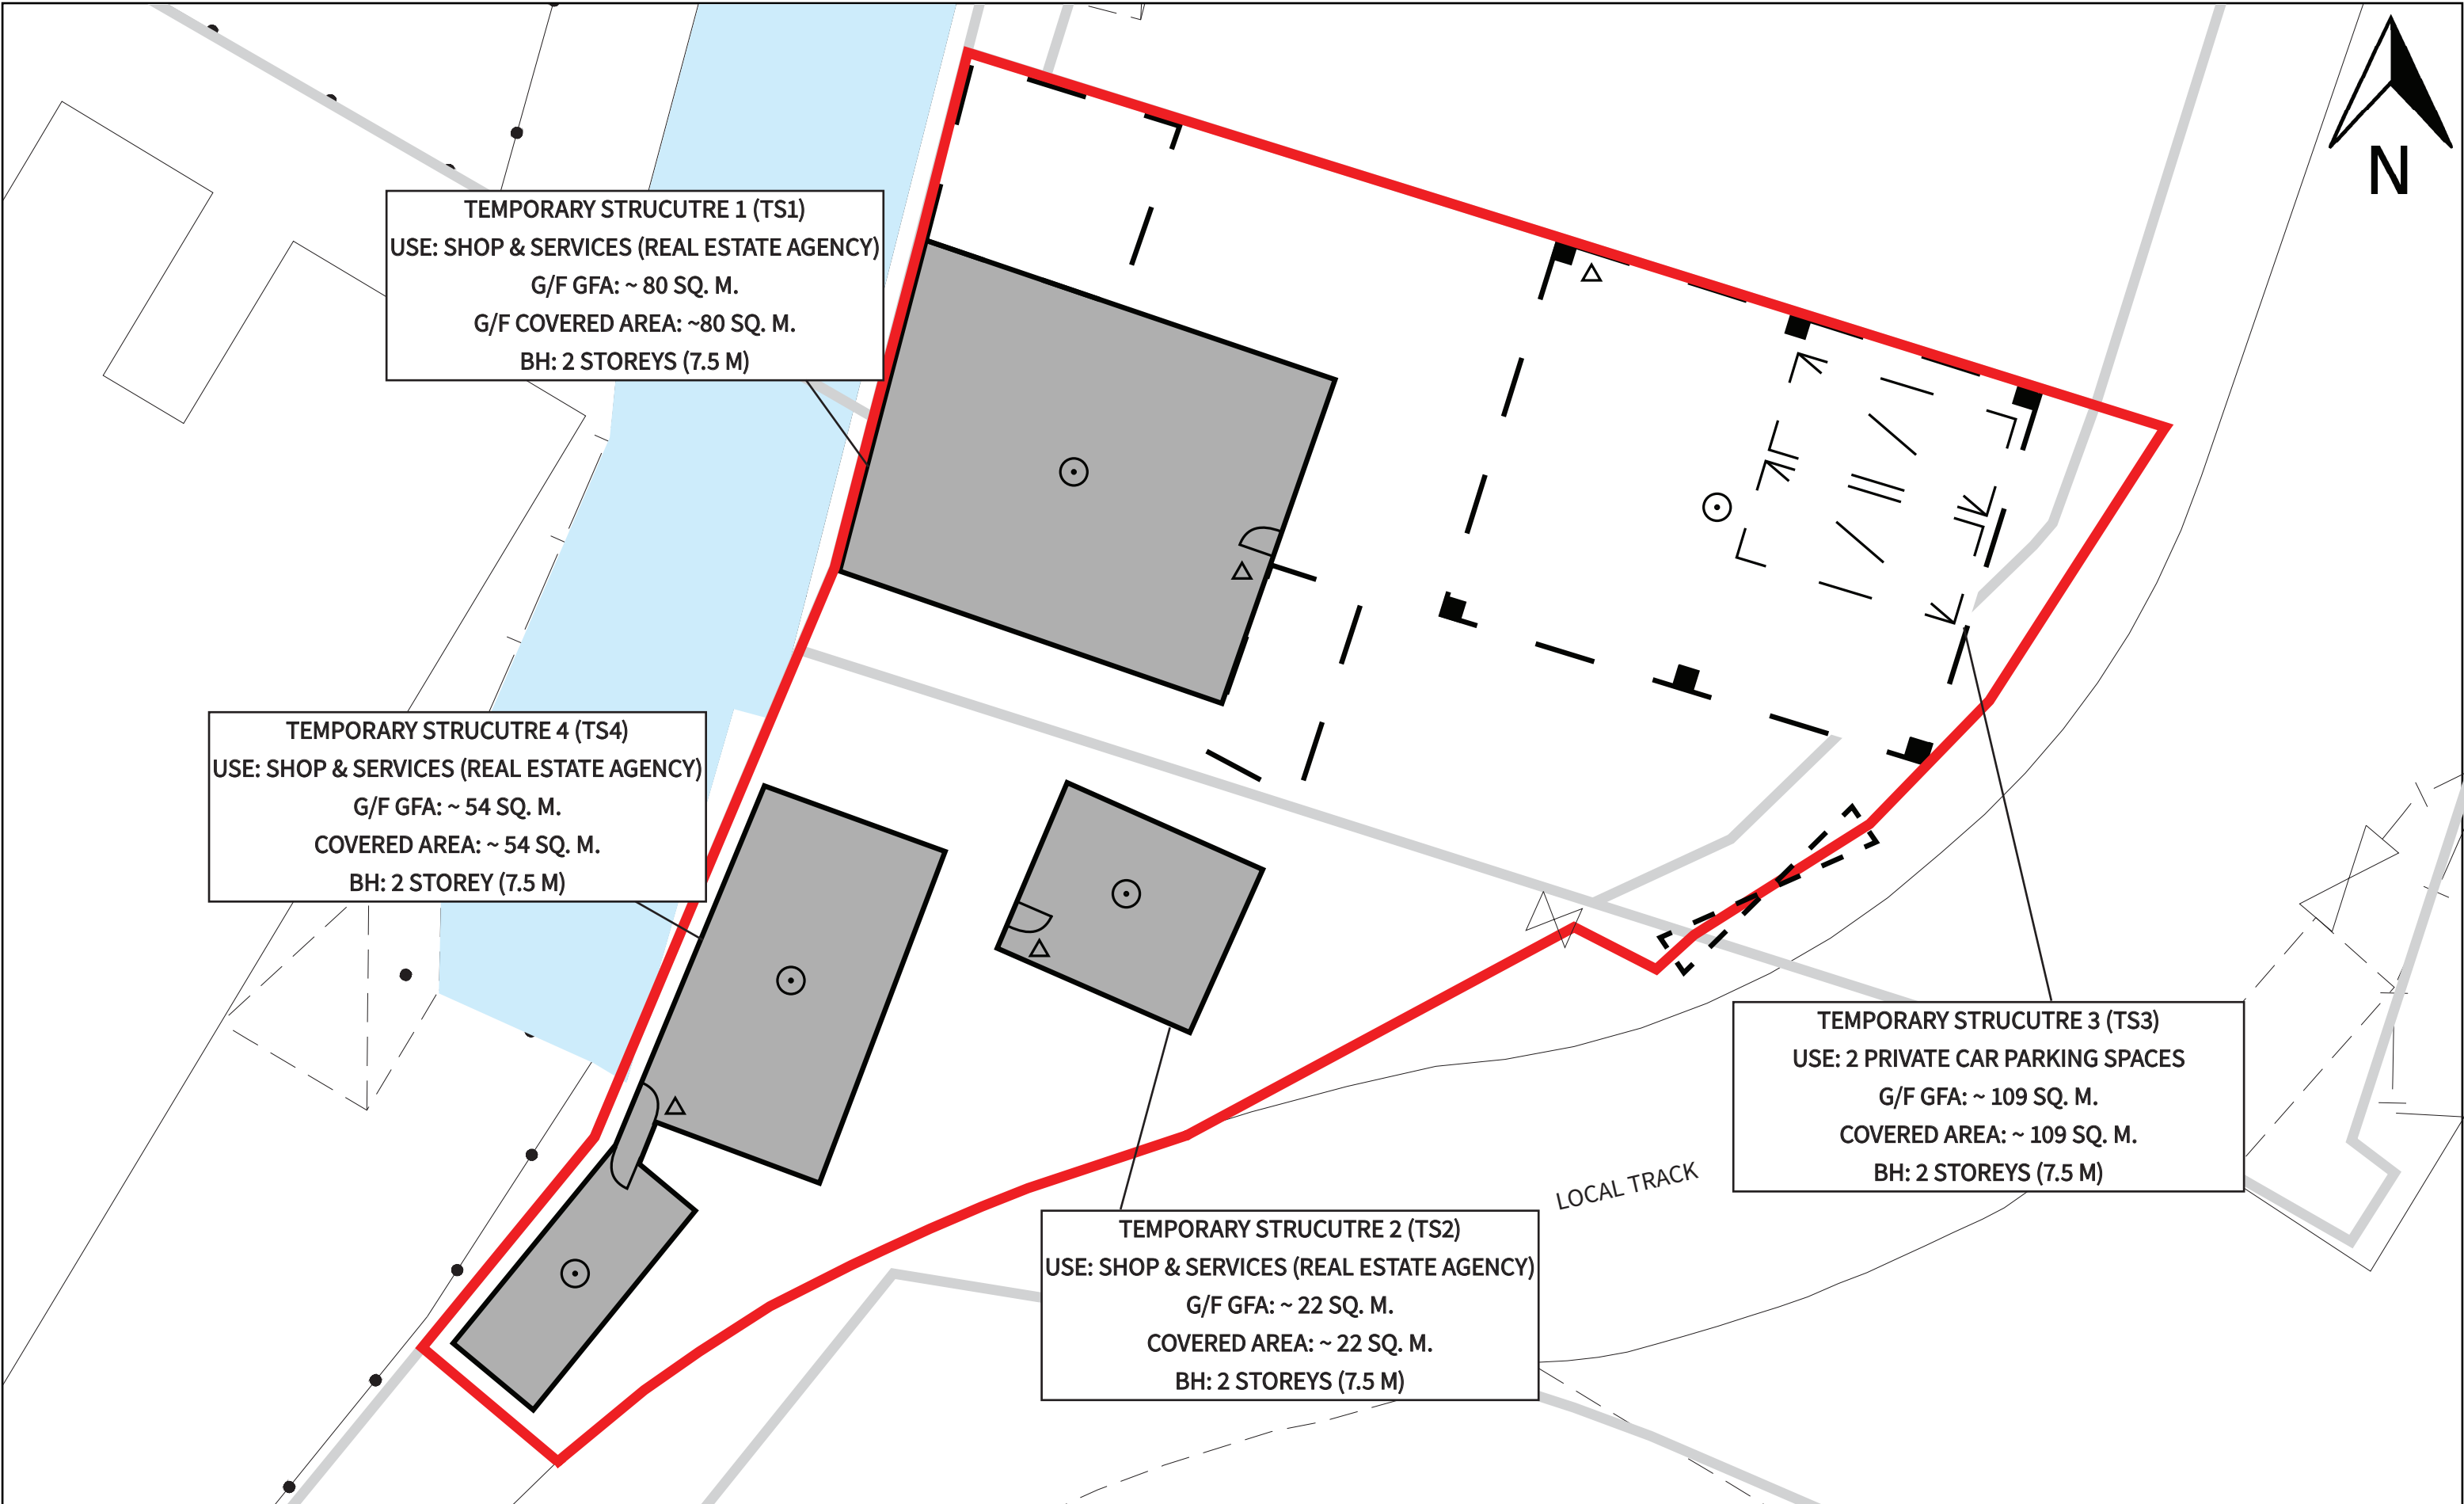

DRAWING TITLE: GROUND FLOOR PLAN	LEGEND: [Red Outline] APPLICATION BOUNDARY [Grey Fill] ENCLOSED STRUCTURE [Dashed Outline] STRUCTURE ABOVE [Triangle] PORTABLE FIRE EXTINGUISHER [Circle with Dot] STANDALONE FIRE DETECTOR	SCALE: NOT TO SCALE	PREPARED BY:  DeSPACE (International) Limited
DRAWING NO.: FIGURE 1		DATE: SEPTEMBER 2026	

- FS NOTES:**
- 1. THE WHOLE OF THE FIRE SERVICE INSTALLATIONS SHALL COMPLY WITH THE CODES OF PRACTICE (2022 EDITION) ISSUED BY THE HONG KONG FIRE SERVICES DEPARTMENT.
 - 2. THE INSTALLATIONS PROPOSED ARE IN ACCORDANCE TO FIRE SAFETY REQUIREMENTS FOR “TEMPORARY STORAGE AND STRUCTURES UNDER PLANNING APPLICATION, SHORT TERM TENANCY & SHORT TERM WAIVER (06/2025).”
 - 3. THE STANDALONE FIRE DETECTOR PROVISION IS IN ACCORDANCE TO “STANDALONE FIRE DETECTOR GENERAL GUIDELINES ON PURCHASE, INSTALLATION & MAINTENANCE (SEP 2021).”
 - 4. ALL DETECTORS WITHIN THE APPLICATION SITE SHALL BE INTERCONNECTED (EITHER WIRED OR WIRELESSLY) SUCH THAT WHEN ONE OF THE DETECTORS IS TRIGGERED, ALL CONNECTED DETECTORS SHALL SOUND AN ALARM SIMULTANEOUSLY.
 - 5. STAND-ALONE FIRE DETECTORS SHALL BE PROVIDED IN EVERY ROOM/COMPARTMENT EXCEPT IN KITCHEN AND WASHROOM.

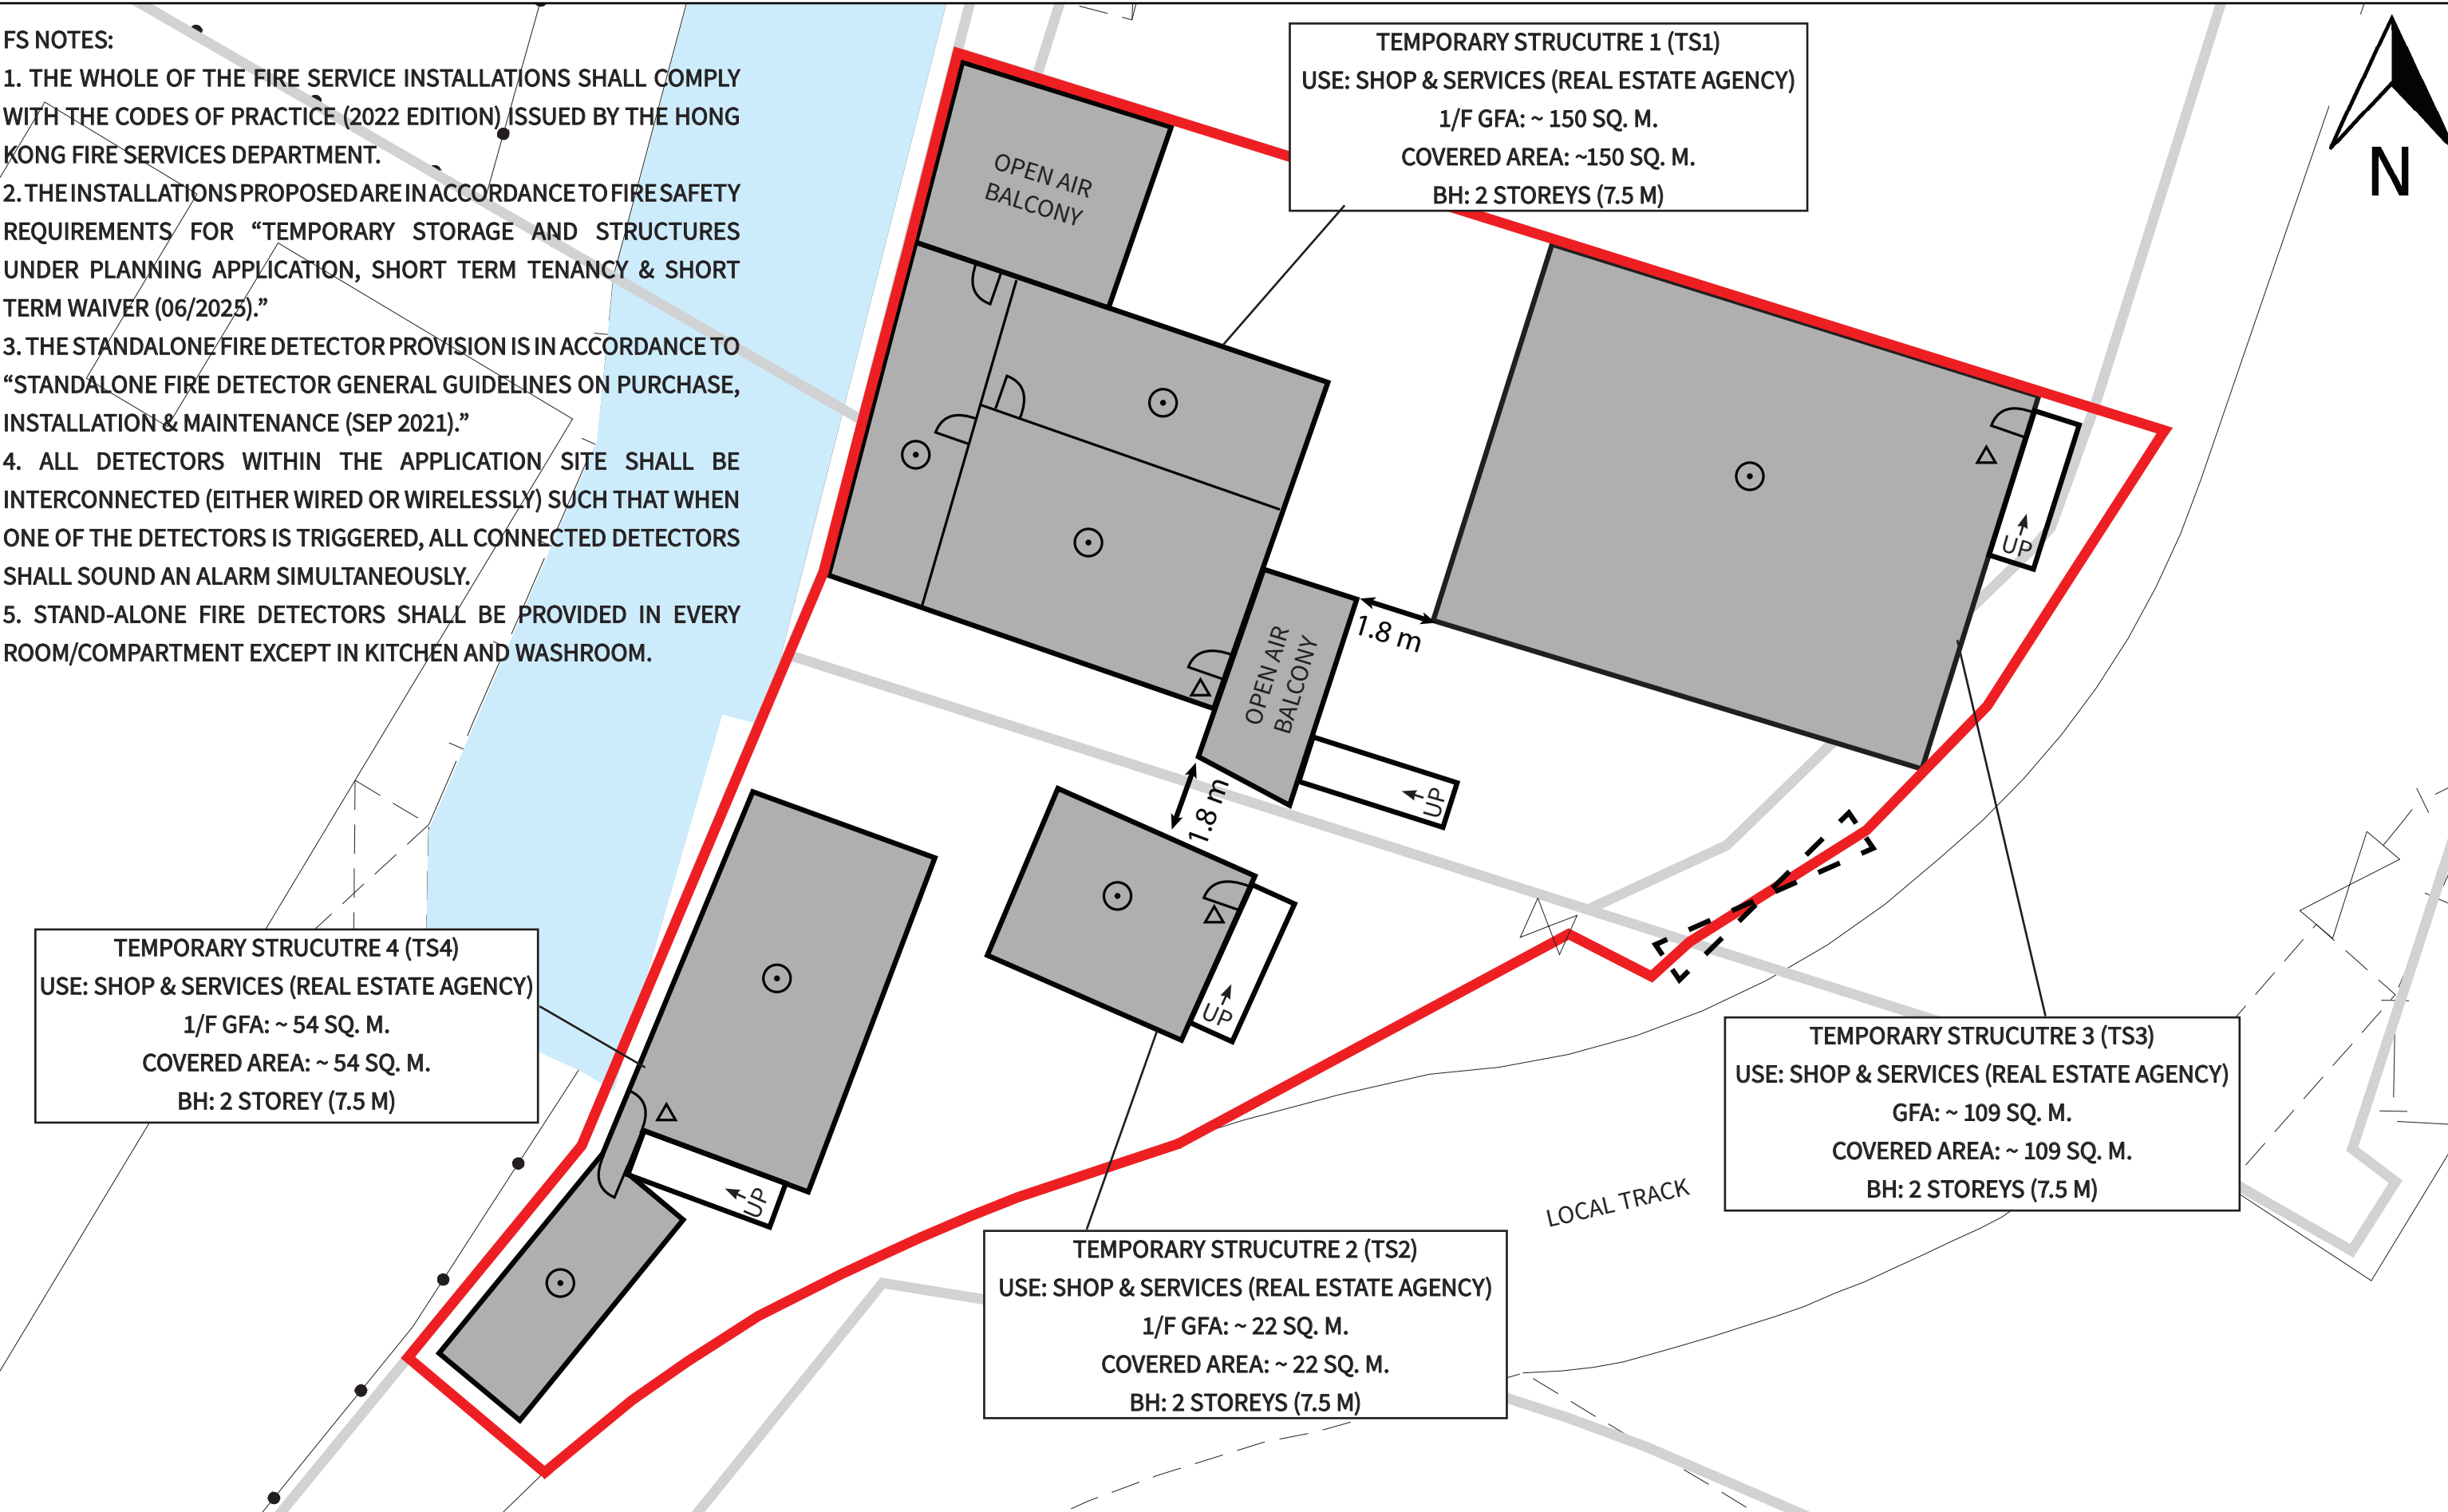

DRAWING TITLE: FIRST FLOOR PLAN	LEGEND: APPLICATION BOUNDARY ENCLOSED STRUCTURE PORTABLE FIRE EXTINGUISHER STANDALONE FIRE DETECTOR	SCALE: NOT TO SCALE	PREPARED BY:  DeSPACE (International) Limited
DRAWING NO.: FIGURE 2		DATE: SEPTEMBER 2026	