
 


申請地點位置圖

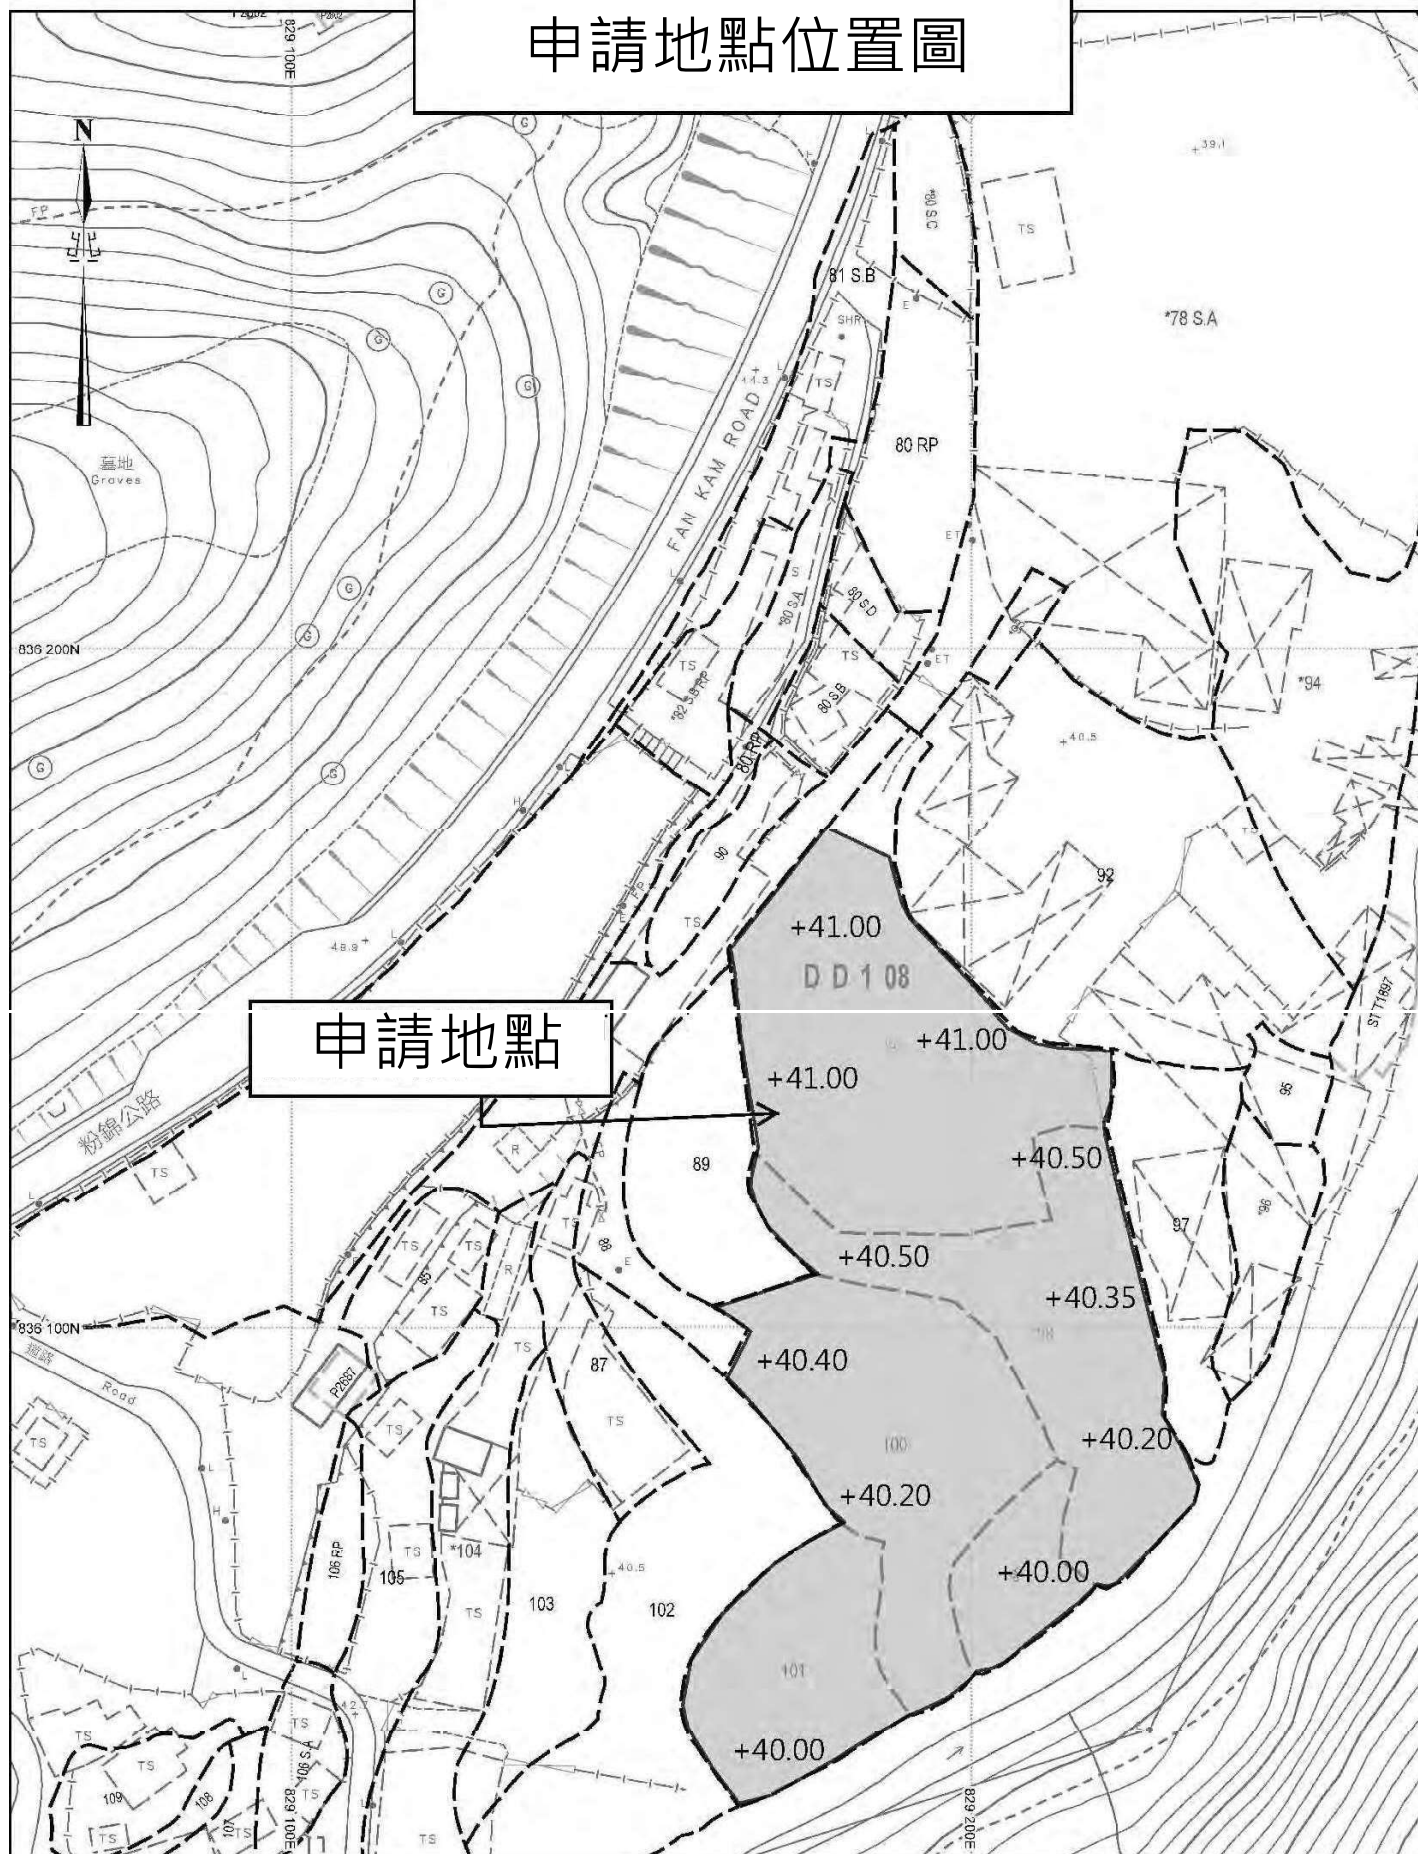

申請填土範圍



Note:

1. Catchpit (CP1-CP9) with desilting facility shall follow CEDD's standard drawing No. 2406/1, 2406/2A
2. Catchpit and UC follows Typical Details of Geotechnical Manual for Slope Fig.8.10 and Fig.8.11 respectively.
3. The inverted level of the connection point shall be verified on site prior the commencement of work
4. Grating Concrete Cover follows CEDD's standard drawing No. C2412E: U-CHANNELS WITH PRECAST CONCRETE SLABS

Site Catchment Area = 6380 m^2


= 0.06380 km^2

Peak runoff in m^3/s = Peak runoff in m^3/s = $0.278 \times 0.95 \times 240 \text{ mm/hr} \times 0.06380 \text{ km}^2$

= $4.04389 \text{ m}^3/\text{s}$

= 25275 liter/min


雨水排放建議圖

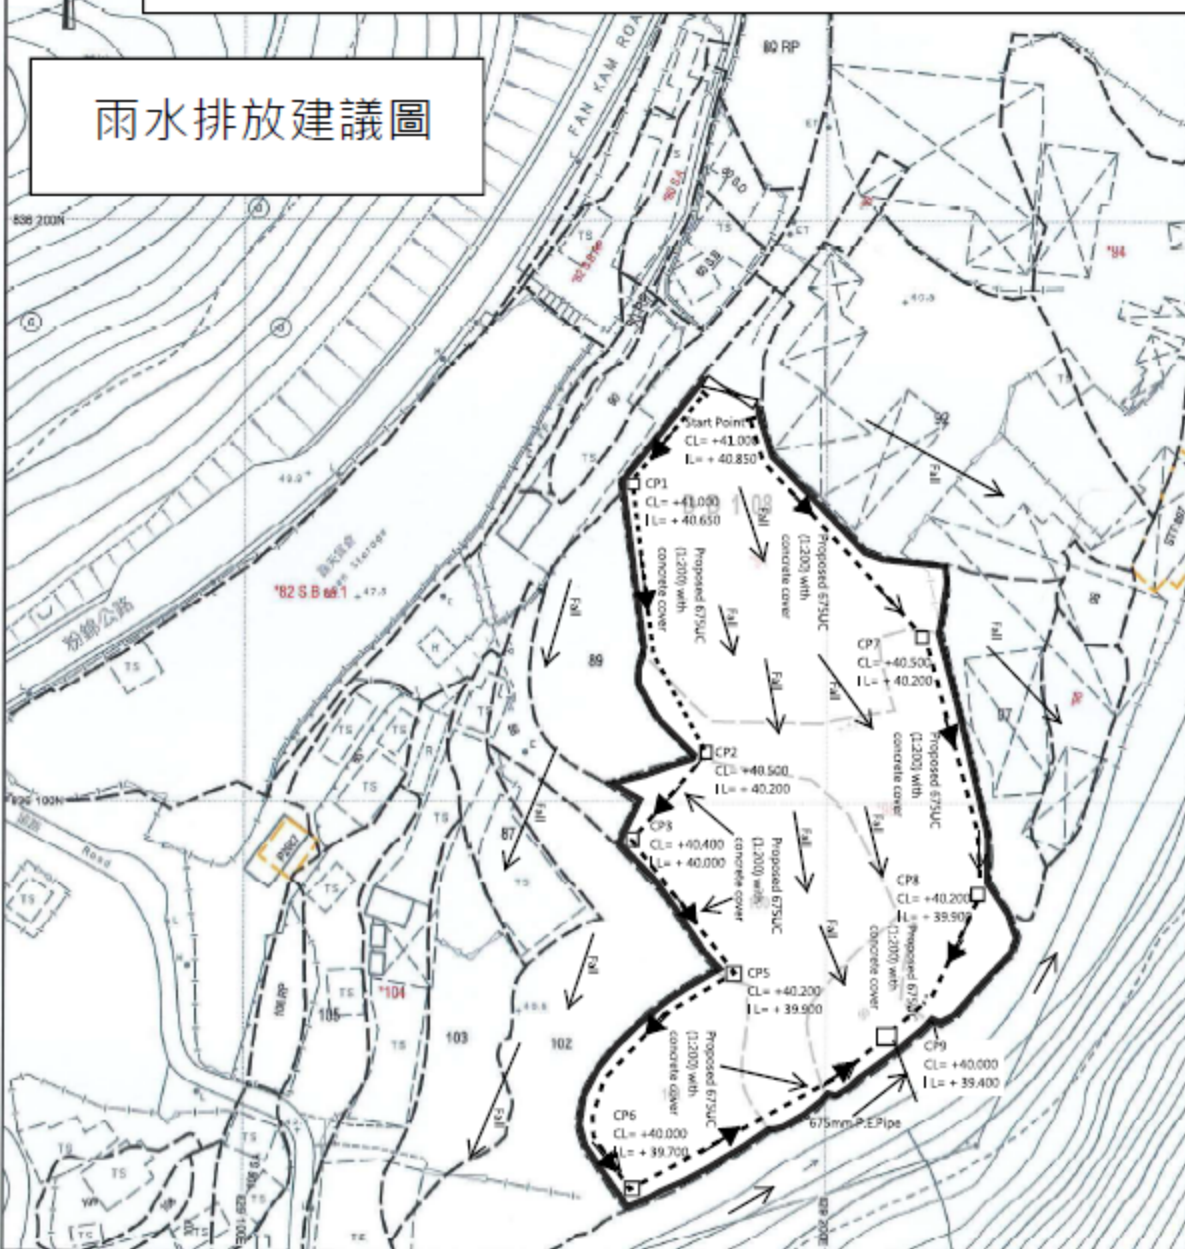

☐Urgent ☐Return receipt ☐Expand Group ☐Restricted ☐Prevent Copy

From: sun wo wong [REDACTED]
Sent: 2025-10-15 星期三 09:35:08
To: [REDACTED]
Subject: Fwd: A/YL-PH/1090
Attachment: P8.pdf; 消防裝置建議圖(15-10-2025).pdf

街景圖可否後補給妳
因今早要離港，請幫忙 謝謝

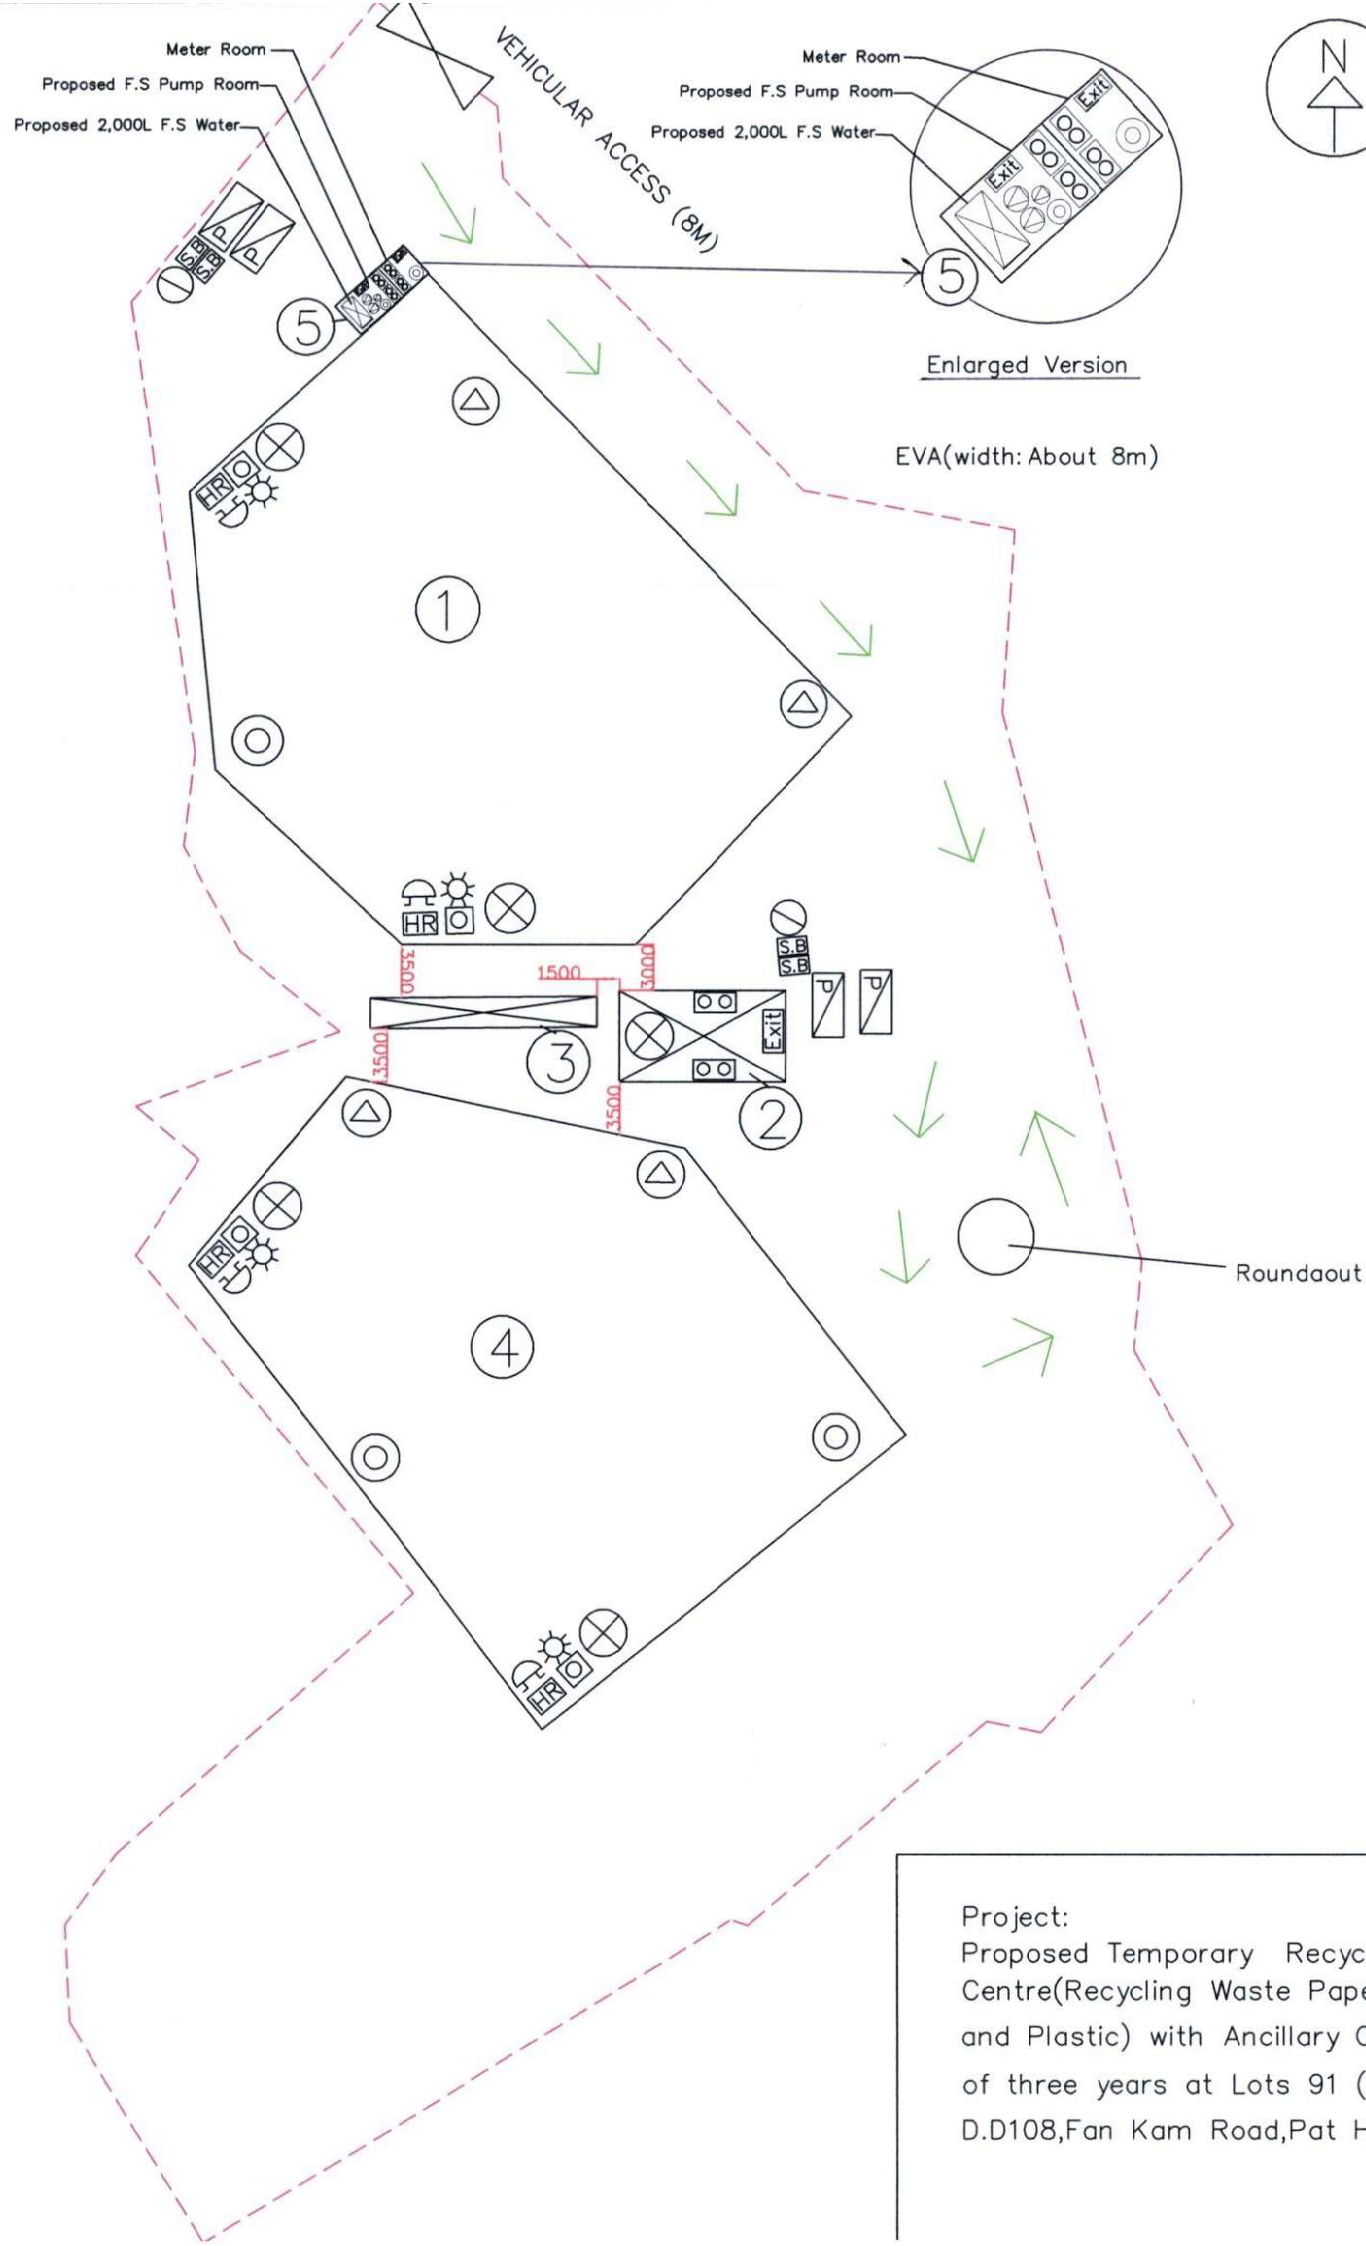

Legend:

- ⊗ 4kg dry powder type fire extinguisher
- ⊙ 5kg co2 type fire extinguisher
- ⊕ 9 Litre Water type fire extinguisher
- ⊖ 9 Litre Foam type fire extinguisher
- S.B SAND BUCKET
- HR Hore Reel Set
- 🔔 150mm Fire Alarm Bell
- 🔑 Break Glass Call Point
- ☀ Visual Alarm Device
- ⊕ F.S Pump

- ⬡ Emergency Lighting
- Exit Exit Sign
- Lot Boundary
- New installations
- P Parking Spaces
- EVA (Emergency Vehicular Access)

Fire Notes:

1. Sufficient emergency lighting shall be provided throughout the entire building in accordance with BS5266-1:2016 and BS EN 1838:2013 and the FSD Circular Letter no.4/2021.
2. Sufficient directional and exit sign shall be provided in accordance with BS 5266-1:2016 and FSD Circular letter No 5/2008.
3. Sufficient portable hand-operated approved appliance shall be provided as required by occupancy and as marked on plans.
4. A hose reel system should be supplied by a 2.0m³ F.S Water tank. There shall be sufficient hose reel to ensure that every part of each building can be reached by a length of not more than 30m of hose reel tubing. The F.S water tank, F.S pump room and hose reel shall be clearly marked on plans.
5. Fire alarm system shall be provided throughout the entire building in accordance with BS 5839-1:2017 and the FSD Circular Letter 6/2021. One actuation point and one audio warning device to be located at each hose reel point. The actuation point should include facilities for fire pump start and audio/Visual warning device initiation.
6. Hose Reel pump (HR-P1, HR-P2 & HR-JP) and 1 no 5kg co2 type fire extinguisher shall be provided at F.S pump Room.
7. Source of secondary power supply for FSI shall be provided.

NATURE OF OCCUPANCY:

- ① 1-Storey shed (all side open) for Recycling Centre
Floor Area: 1192 sq.m. Height: 12m
- ② 1-Storey container for Ancillary office
Floor Area: 66 sq.m, Height: 4.5m
- ③ 1-Storey portable toilet
Floor Area: 30 sq.m, Height: 3.5m.
- ④ 1-Storey shed (all side open) for Recycling Centre
Floor Area: 1123 sq.m. Height: 12m
- ⑤ 1-Storey container for Meter Room & F.S Pump Room
Floor Area: 15 sq.m. Height: 3m

INTERCEPT FIRE & SECURITY TECHNICIANS LIMITED

Registered Address:

Shop 25 & 84, G/F, Man Fung Building, YTL329 Fung Kwan Street, Yuen Long, N.T.

Tel: 92637766, Fax: 24285932

Business Address:

8/F, Block L, Phase 2, Wah Fung Industrial Centre, 33-39 Kwai Fung Street Kwai Chung, N.T.

Tel: 24255404, Fax: 24285932

Project:
Proposed Temporary Recyclable Materials Centre (Recycling Waste Paper, Waste Metalware and Plastic) with Ancillary Office for A Period of three years at Lots 91 (Part) and 98 in D.D108, Fan Kam Road, Pat Heung, Yuen Long.

Title:
Proposed Fire Service
Installation Layout Plan

Drawn by: W.C. WONG

Date: 2025-10-13

Scale: 1:500 @ A3

Ref No:

Drawing No: 2025/FS/005