

Your Ref.: A/YL-TT/796

Our Ref.: P11003/TL26238

25 June 2026

The Secretary
Town Planning Board
15/F., North Point Government Offices
333 Java Road, North Point, Hong Kong

By E-mail
tpbpd@pland.gov.hk

Dear Sir,

Submission of Supplementary Information

**Renewal of Planning Approval for Temporary Canteen for a Period of 3 Years
in "Village Type Development" Zone, Lots 1187 S.O (Part), 1187 S.Q (Part) and
1187 S.R (Part) in D. D. 117 and adjoining Government Land,
Shap Pat Heung, Yuen Long, New Territories
(Application No. A/YL-TT/796)**

We write to submit a FSI proposal which was accepted by the Director of Fire Services under previous renewal application. The applied use, layout and development parameters under the current renewal application remain unchanged compared with the previous renewal application.

Yours faithfully,
For and on behalf of
Goldrich Planners & Surveyors Ltd.




Francis Lau

Encl.

C.C.
DPO/TMYLW, PlanD (Attn.: Mr. Kevin LAM)


FS NOTES:

- (i) Sufficient emergency lighting shall be provided throughout the entire building in accordance with BS 5266: Part 1 and BS EN 1838.
- (ii) Sufficient directional and exit sign shall be provided in accordance with BS 5266: Part 1 and FSD Circular Letter 5/2008.
- (iii) Fire alarm system shall be provided throughout the entire building in accordance with BS 5839-1:2002 + A2:2008 and FSD Circular Letter 1/2009. One actuating point and one audio warning device to be located at each hose reel point. This actuation point should include facilities for fire pump start and audio/visual warning device initiation.
- (iv) A new hose reel system supplied by 2m3 FS water tank shall be provided. There shall be sufficient hose reels to ensure that every part of each building can be reached by a length of not more than 30m of hosereel tubing.
- (v) Portable hand-operated approved appliances shall be provided as required by occupancy.

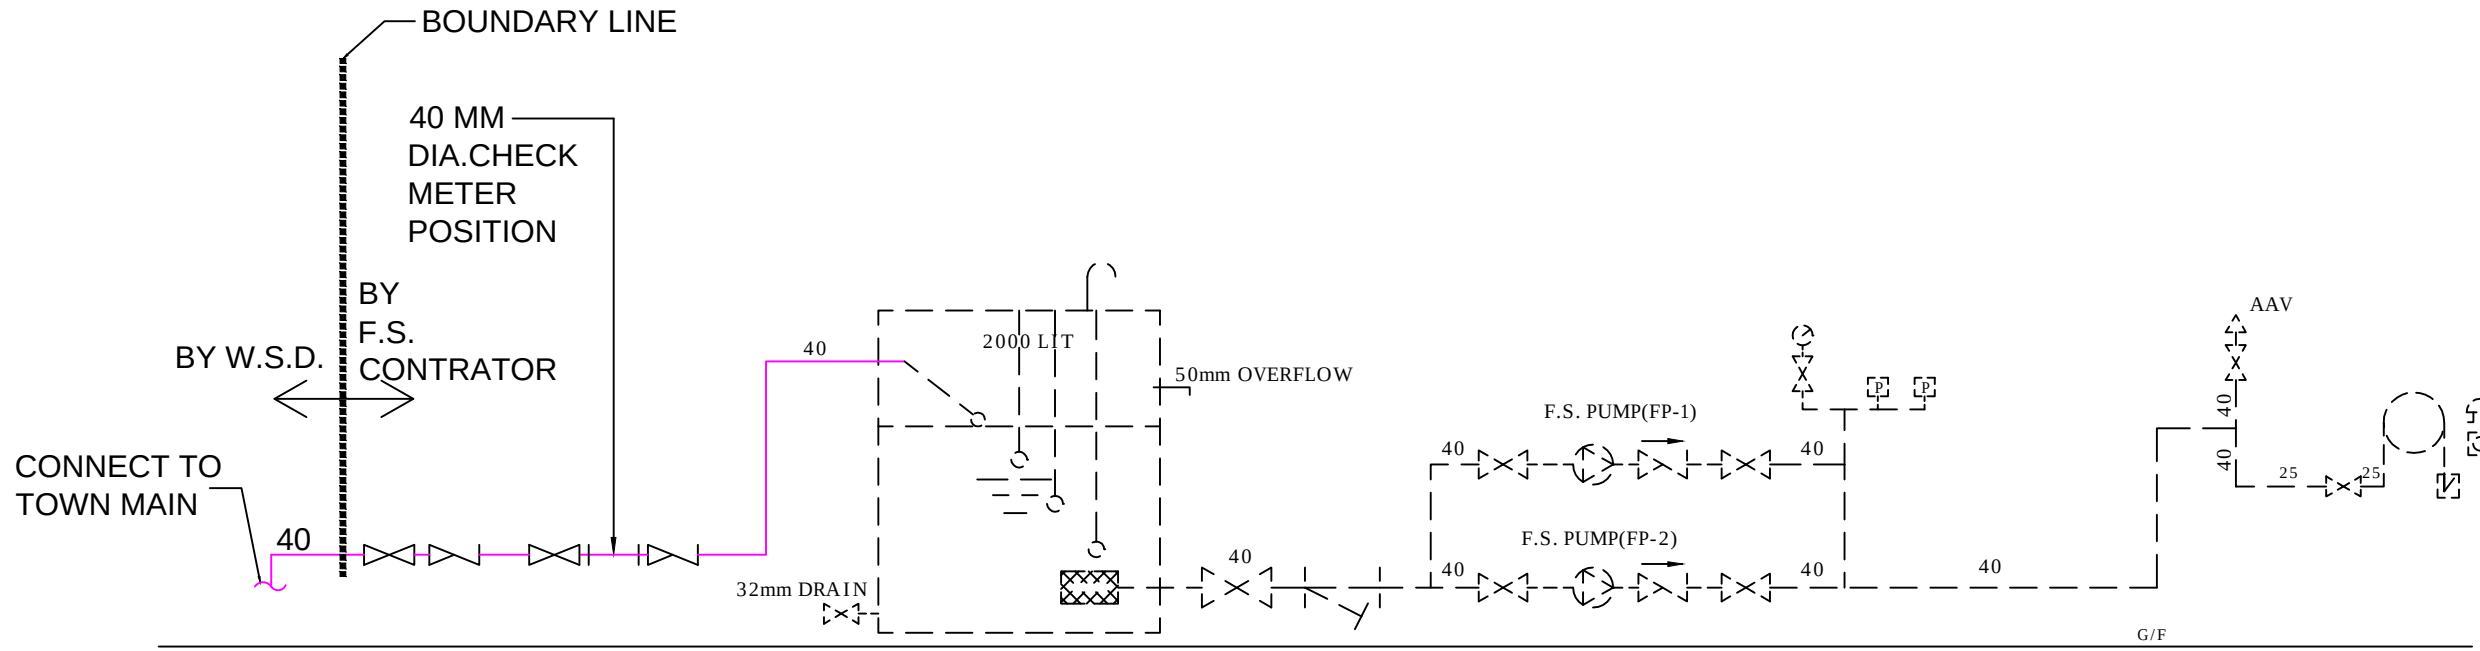


SCHEMATIC DIAGRAM OF FH/HR SYSTEM


PUMP SCHEDULE				
DESCRIPTION	FLOW	PRESSURE	RPM	POWER
F.S.PUMP (FP-1 & FP-2)	0.4 L/S	1.5BAR	2900	2.2 kw

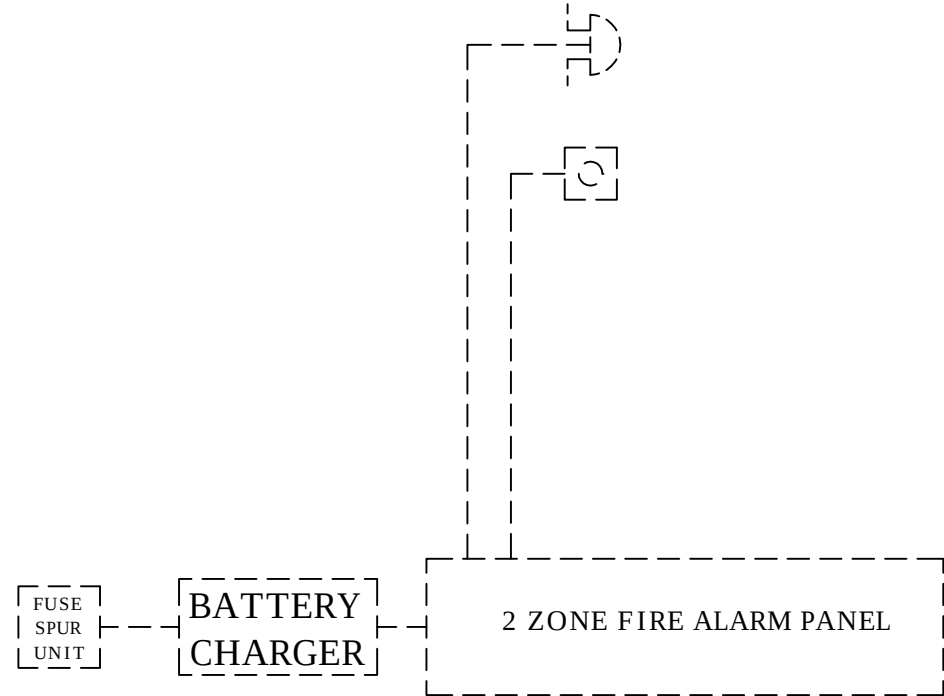

SCHEMATIC DIAGRAM OF FIRE ALARM SYSTEM

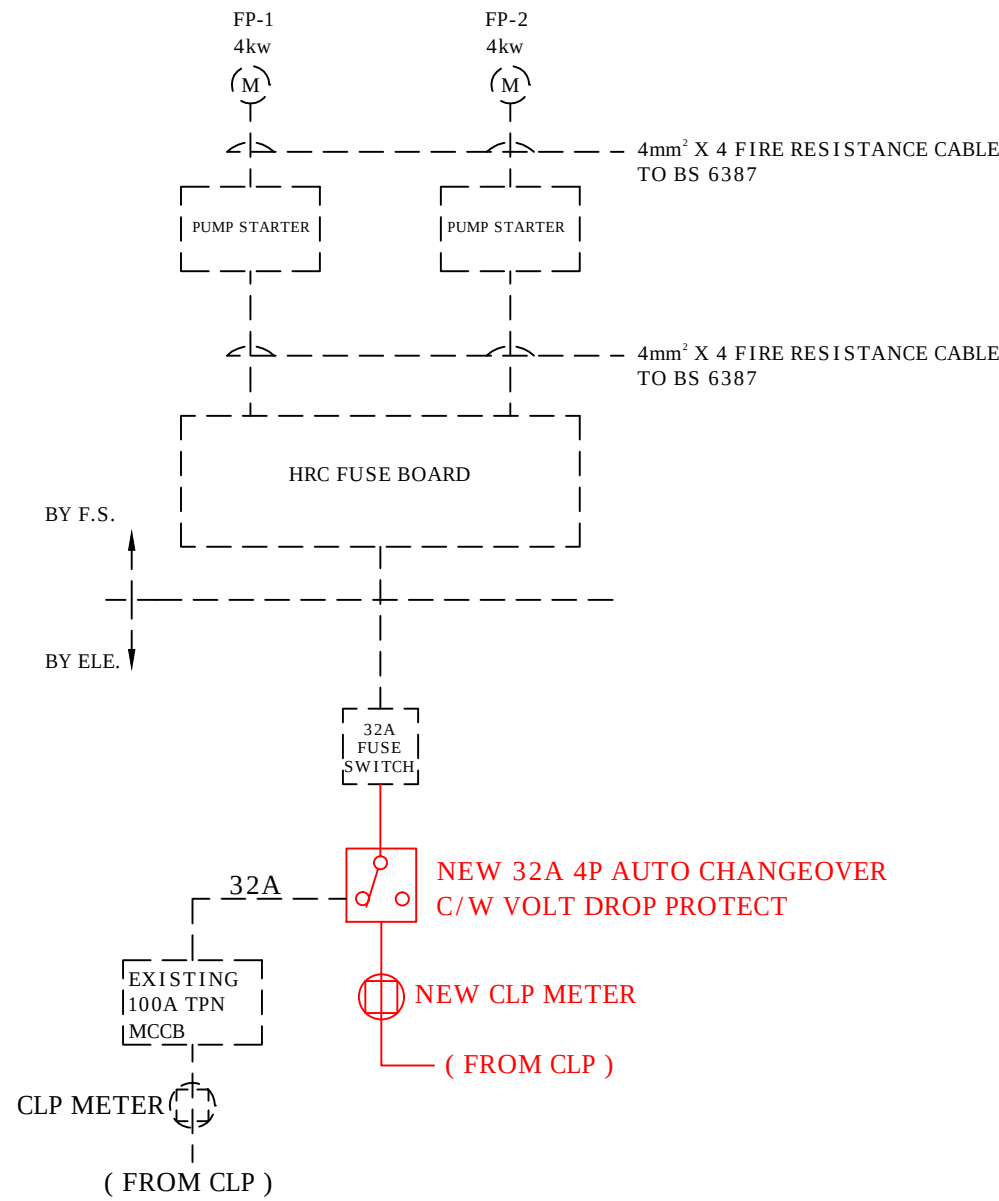

FIRE SERVICE POWER SUPPLY SCHEMATIC DIAGRAM

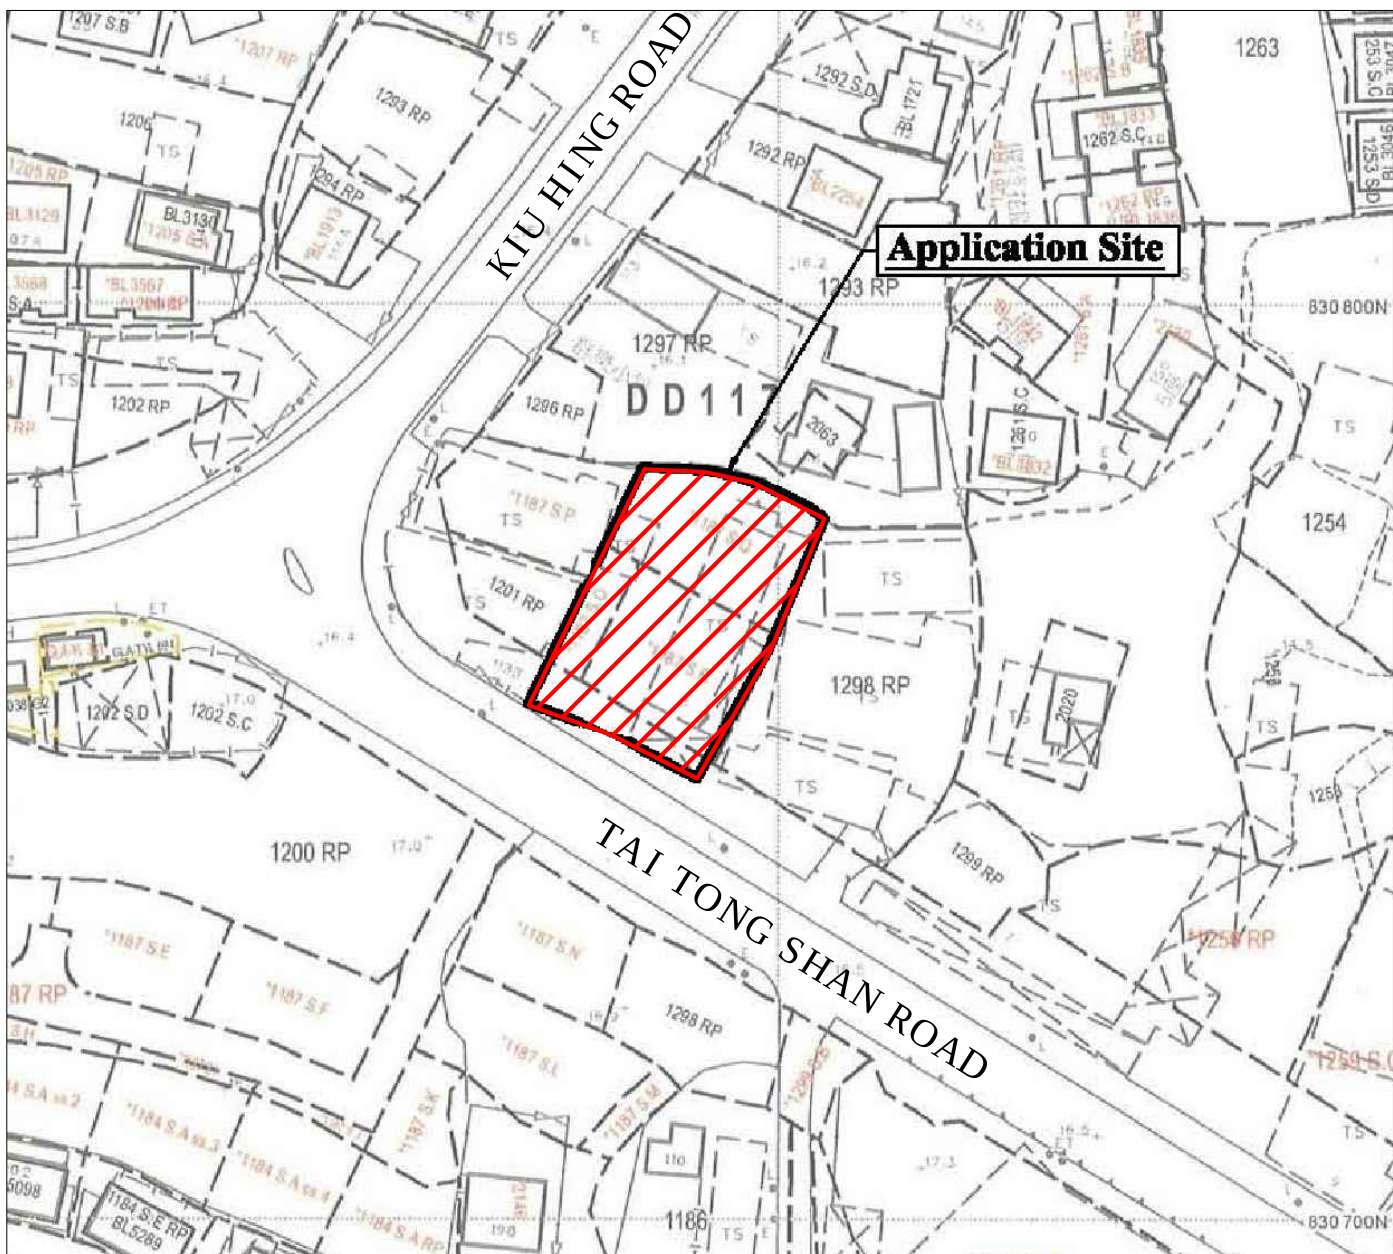

BLOCK PLAN SCALE:N.T.S.

FSD REF: -----

FEHD REF: -----

V. D. REF:FP 33/

WWO. REF: -----

LEGEND :

- DIA-20MM PIPE (ORANGE)

DIA-40MM PIPE (PURPLE)
- PRESSURE SWITCH
- BREAKGLASS UNIT
- ALARM BELL
- PUMP SET
- GATE VALVE
- CHECK VALVE
- STRAINER
- PRESSURE GAUGE
- PUMP MOTOR
- Y- STRAINER
- HOSE REEL C/W NOZZLE BOX
- AUTOMATIC EMERGENCY LIGHT
- EXIT SIGN
- 9 LITRE WATER/CO2 TYPE FIRE EXTINGUISHER
- Hose Reel Pump
- FS Water Tank
- Hosereel
- 5.0kg CO2 Gas type Fire Extinguisher
- Sand Bucket
- Manual Fire Alarm Call Point
- F.S. PUMP PANEL
- CLP METER
- AUTO CHANGEOVER

5	04/03/20	FSD SUBMISSION-(4)	FSD	Y.S.
4	07/01/20	FSD SUBMISSION-(3)	FSD	C.N.
3	10/12/18	FSD SUBMISSION-(2)	FSD	C.N.
2	04/09/18	FSD SUBMISSION-(1)	FSD	C.N.
1	08/01/13	FSD SUBMISSION-(0)	FSD	C.L.
0	28/12/12	FSD SUBMISSION-(0)	FSD	C.N.
REV.	DATE	DESCRIPTION	TO	BY

ESTABLISH DATE: 21/12/2012

CLIENT :

偉記食堂

CONTRACTOR :

新邦消防工程有限公司
FIRST FIRE ENGINEERING CO., LTD.

(註冊通風系統承辦商 SC (V)/4/2003)

TITLE :

PROPOSE HOSE REEL SYSTEM PLAN

JOB LOCATION:
LOTS 1187 S.O (PART), 1187 S.Q (PART)
AND 1187 S.R (PART) IN D.D. 117 AND
ADJOINING GOVERNMENT LAND, SHAP
PAT HEUNG, YUEN LONG, N.T.

DRAWN BY : C.N. KWOK

CHECKED BY: BARRY CHIU

APPROVED BY : O.T. LI

SCALE : 1:100

PAGE NO.: 1 OF 1

QUOTATION NO.: -Nil-

CONTRACT NO.: -Nil-

DWG. NO.: N3219/1212/FF/FS