


S16 Planning Application
Proposed “Flat”, “Shop and Services”/ “Eating Place” and “Social Welfare Facility”
with Minor Relaxation of Plot Ratio and Building Height Restrictions
at 21-35 Wang Yip Street East, Yuen Long

Appendix I

Schematic Architectural Drawings

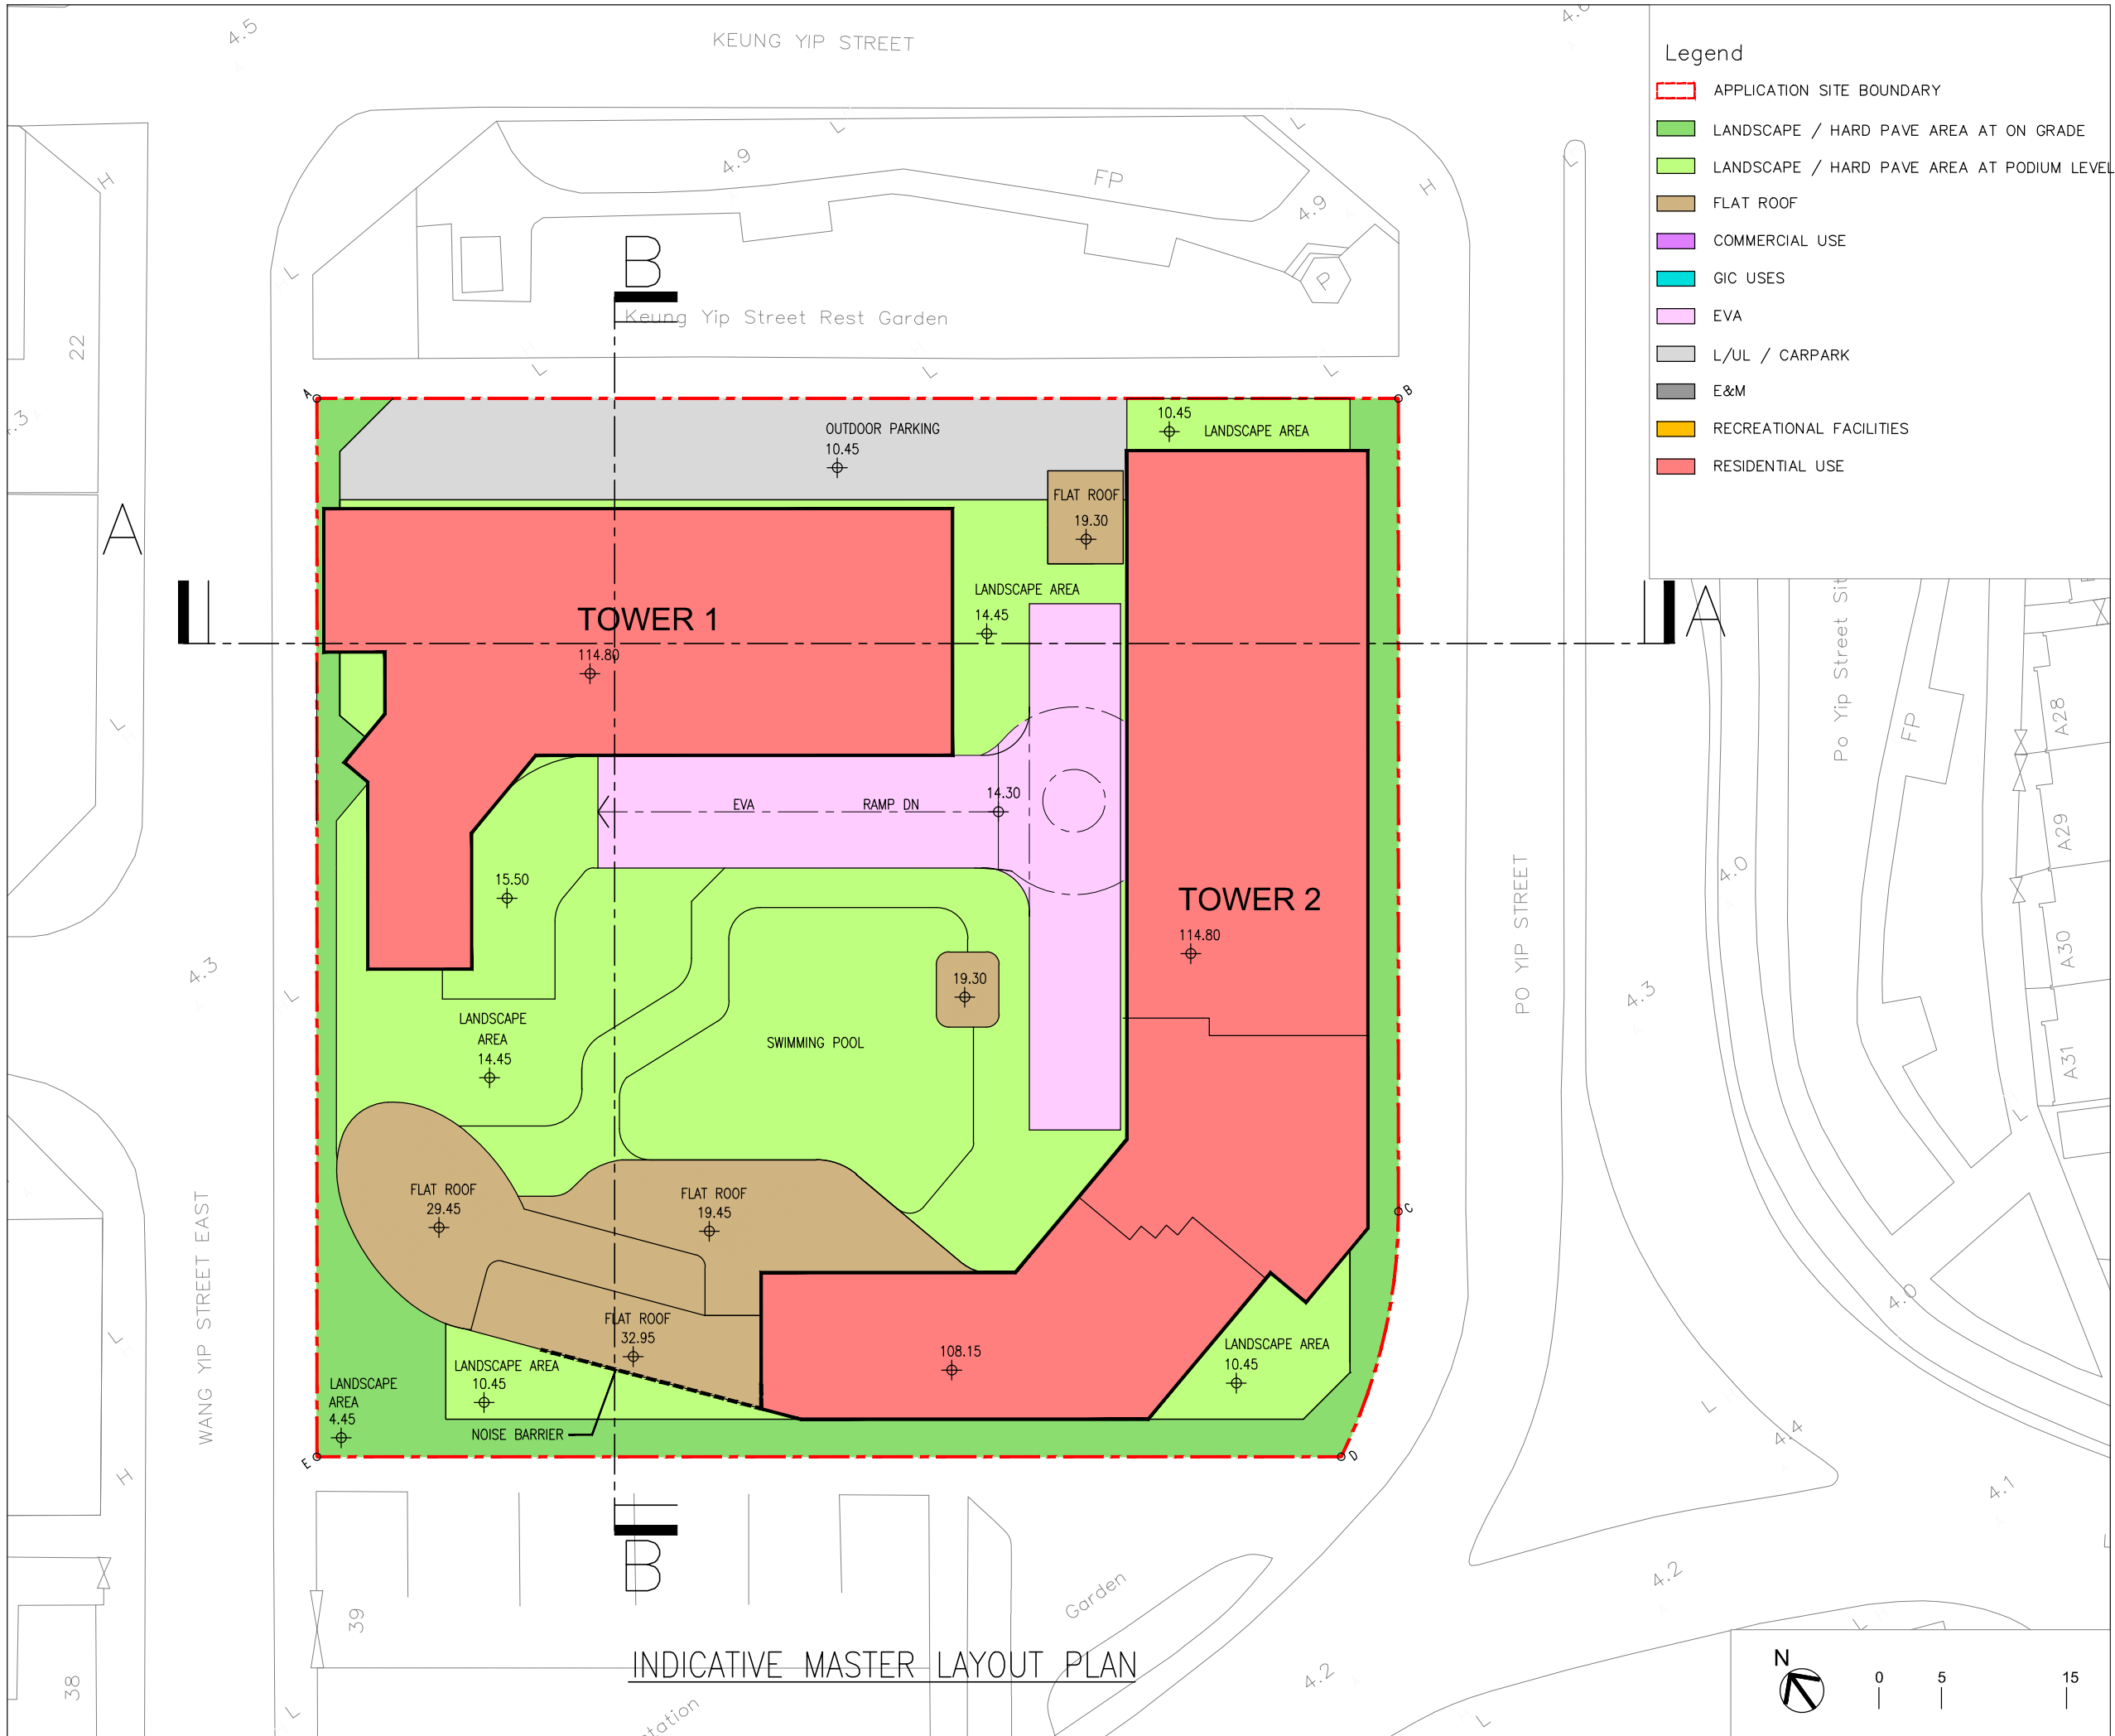

- Legend**
- APPLICATION SITE BOUNDARY
 - LANDSCAPE / HARD PAVE AREA AT ON GRADE
 - LANDSCAPE / HARD PAVE AREA AT PODIUM LEVEL
 - FLAT ROOF
 - COMMERCIAL USE
 - GIC USES
 - EVA
 - L/UL / CARPARK
 - E&M
 - RECREATIONAL FACILITIES
 - RESIDENTIAL USE

B.D. REFERENCE	屋宇署檔案
F.S.D. REFERENCE	消防處檔案
W.W.O. REFERENCE	水務署檔案
CAD FILE NAME	檔案編號

NOTES				注釋
NO.	REVISIONS	DATE	BY	
修定號	修定內容	日期	經手人	

DLN

DLN Architects Limited 46-47 Floor, Tower One, Times Square
 Matheson Street, Causeway Bay, Hong Kong
 劉榮廣伍振民建築師有限公司
 香港銅鑼灣勿地臣街
 時代廣場一座46至47樓
 T + 852 2895 6888 F + 852 2576 4074 email: general@dln.com.hk www.dln.com.hk

2ND DRAFT

ALL MEASUREMENTS MUST BE CHECKED AT THE WORK BY THE CONTRACTOR
 所有尺寸應由承建商於工地核實
 DO NOT SCALE FROM DRAWINGS. 尺寸不應由圖紙直接量度
 ALL PRINTS, SPECIFICATIONS AND THEIR COPYRIGHT ARE THE PROPERTY OF THE ARCHITECT AND SHALL BE RETURNED AT THE COMPLETION OF THE WORK
 所有印刷、規格說明及所有的版權屬於建築師及應在工程完結後歸還建築師


PROJECT	項目名稱
21-25 WANG YIP STREET EAST, YUEN LONG, NEW TERRITORIES, HONG KONG	


TITLE	標題
INDICATIVE MASTER LAYOUT PLAN	

SCALE	比例	DATE	日期
1:500(A3)		MAR 2026	

DRAWN BY	製作人	CHECKED BY	檢查
-		-	

JOB NO.	工程項目	DRAWING NO.	圖號
N3147-H		-	

 

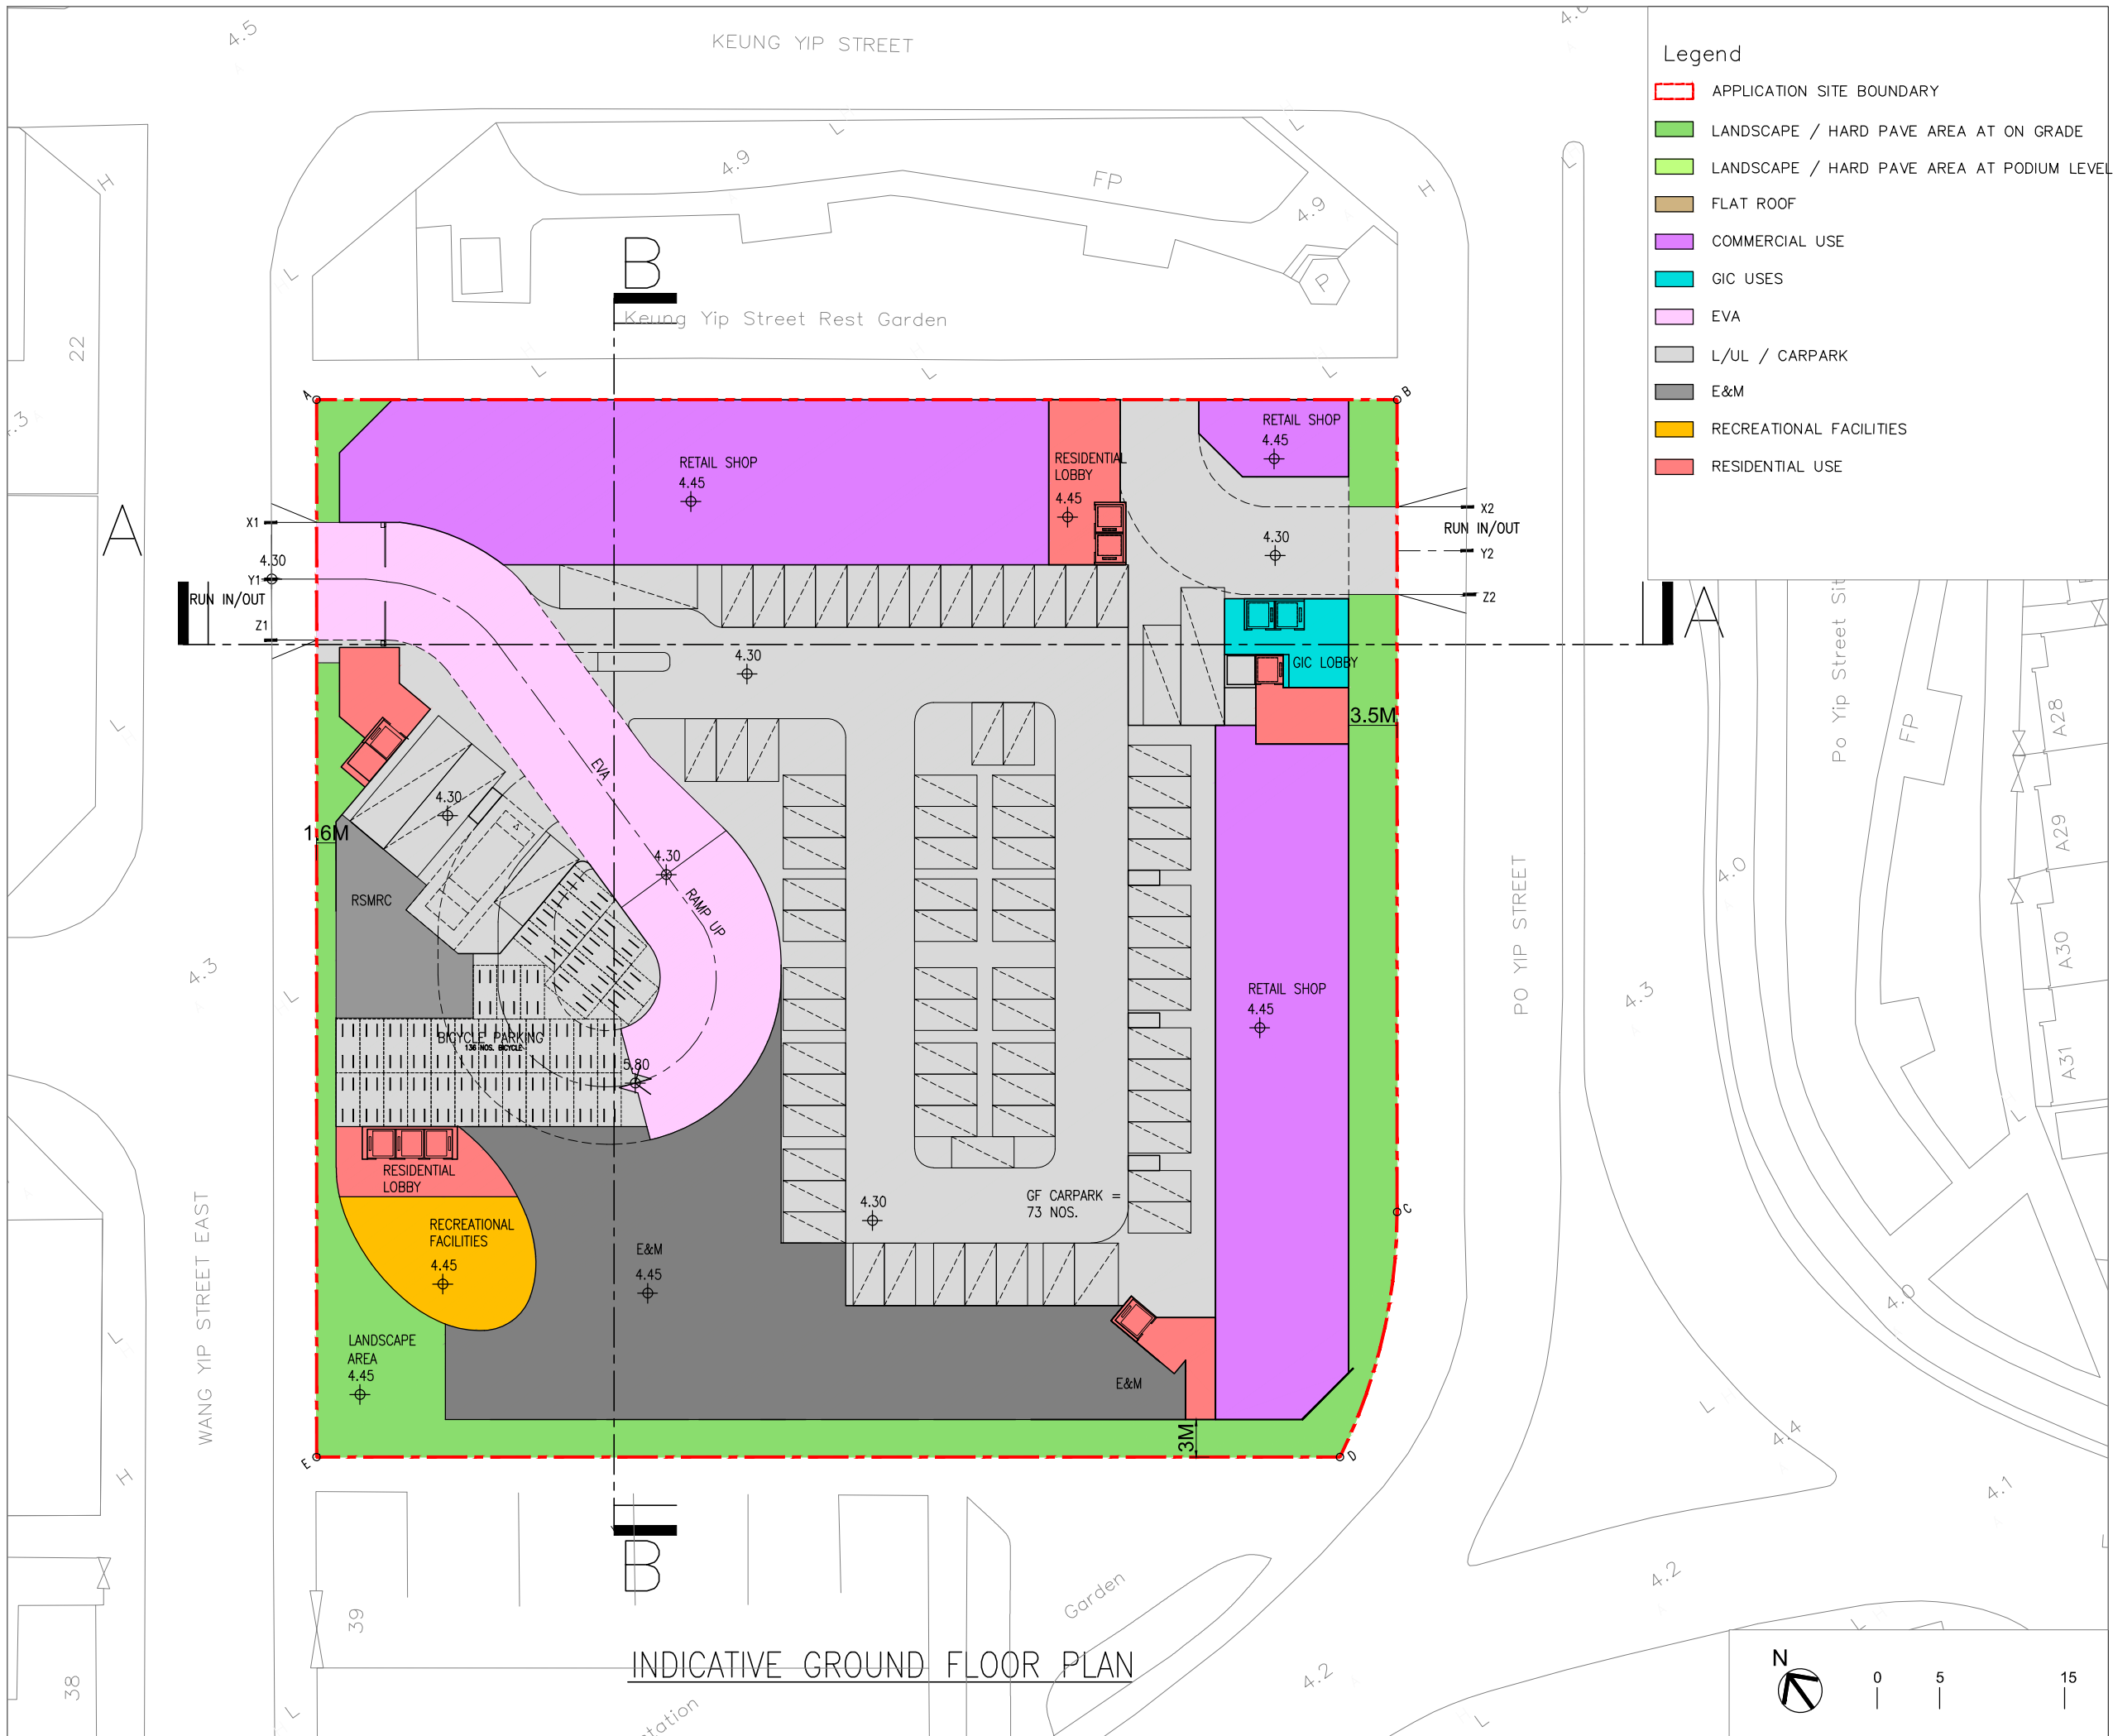

- Legend**
- APPLICATION SITE BOUNDARY
 - LANDSCAPE / HARD PAVE AREA AT ON GRADE
 - LANDSCAPE / HARD PAVE AREA AT PODIUM LEVEL
 - FLAT ROOF
 - COMMERCIAL USE
 - GIC USES
 - EVA
 - L/UL / CARPARK
 - E&M
 - RECREATIONAL FACILITIES
 - RESIDENTIAL USE

B.D. REFERENCE	屋宇署檔案
F.S.D. REFERENCE	消防處檔案
W.W.O. REFERENCE	水務署檔案
CAD FILE NAME	檔案編號

NOTES 注釋

NO. 修定號	REVISIONS 修定內容	DATE 日期	BY 經手人



DLN Architects Limited 46-47 Floor, Tower One, Times Square
 Matheson Street, Causeway Bay, Hong Kong
 香港銅鑼灣勿地臣街
 時代廣場一座46至47樓
 T +852 2895 6888 F +852 2576 4074 email: general@dln.com.hk www.dln.com.hk

2ND DRAFT

ALL MEASUREMENTS MUST BE CHECKED AT THE WORK BY THE CONTRACTOR
 所有尺寸應由承建商於工地核實
 DO NOT SCALE FROM DRAWINGS. 尺寸不應由圖紙直接量度
 ALL PRINTS, SPECIFICATIONS AND THEIR COPYRIGHT ARE THE PROPERTY OF THE ARCHITECT AND SHALL BE RETURNED AT THE COMPLETION OF THE WORK
 所有印刷、規格說明及所有的版權屬於建築師及應在工程完結後歸還建築師


PROJECT 項目名稱	21-25 WANG YIP STREET EAST, YUEN LONG, NEW TERRITORIES, HONG KONG
--------------	---

TITLE 標題	INDICATIVE GROUND FLOOR PLAN
----------	------------------------------


SCALE 比例	1:500(A3)	DATE 日期	APRIL 2026
----------	-----------	---------	------------

DRAWN BY 製作者	-	CHECKED BY 檢查	-
--------------	---	---------------	---

JOB NO. 工程項目	N3147-H	DRAWING NO. 圖號	-
--------------	---------	----------------	---

 

INDICATIVE GROUND FLOOR PLAN

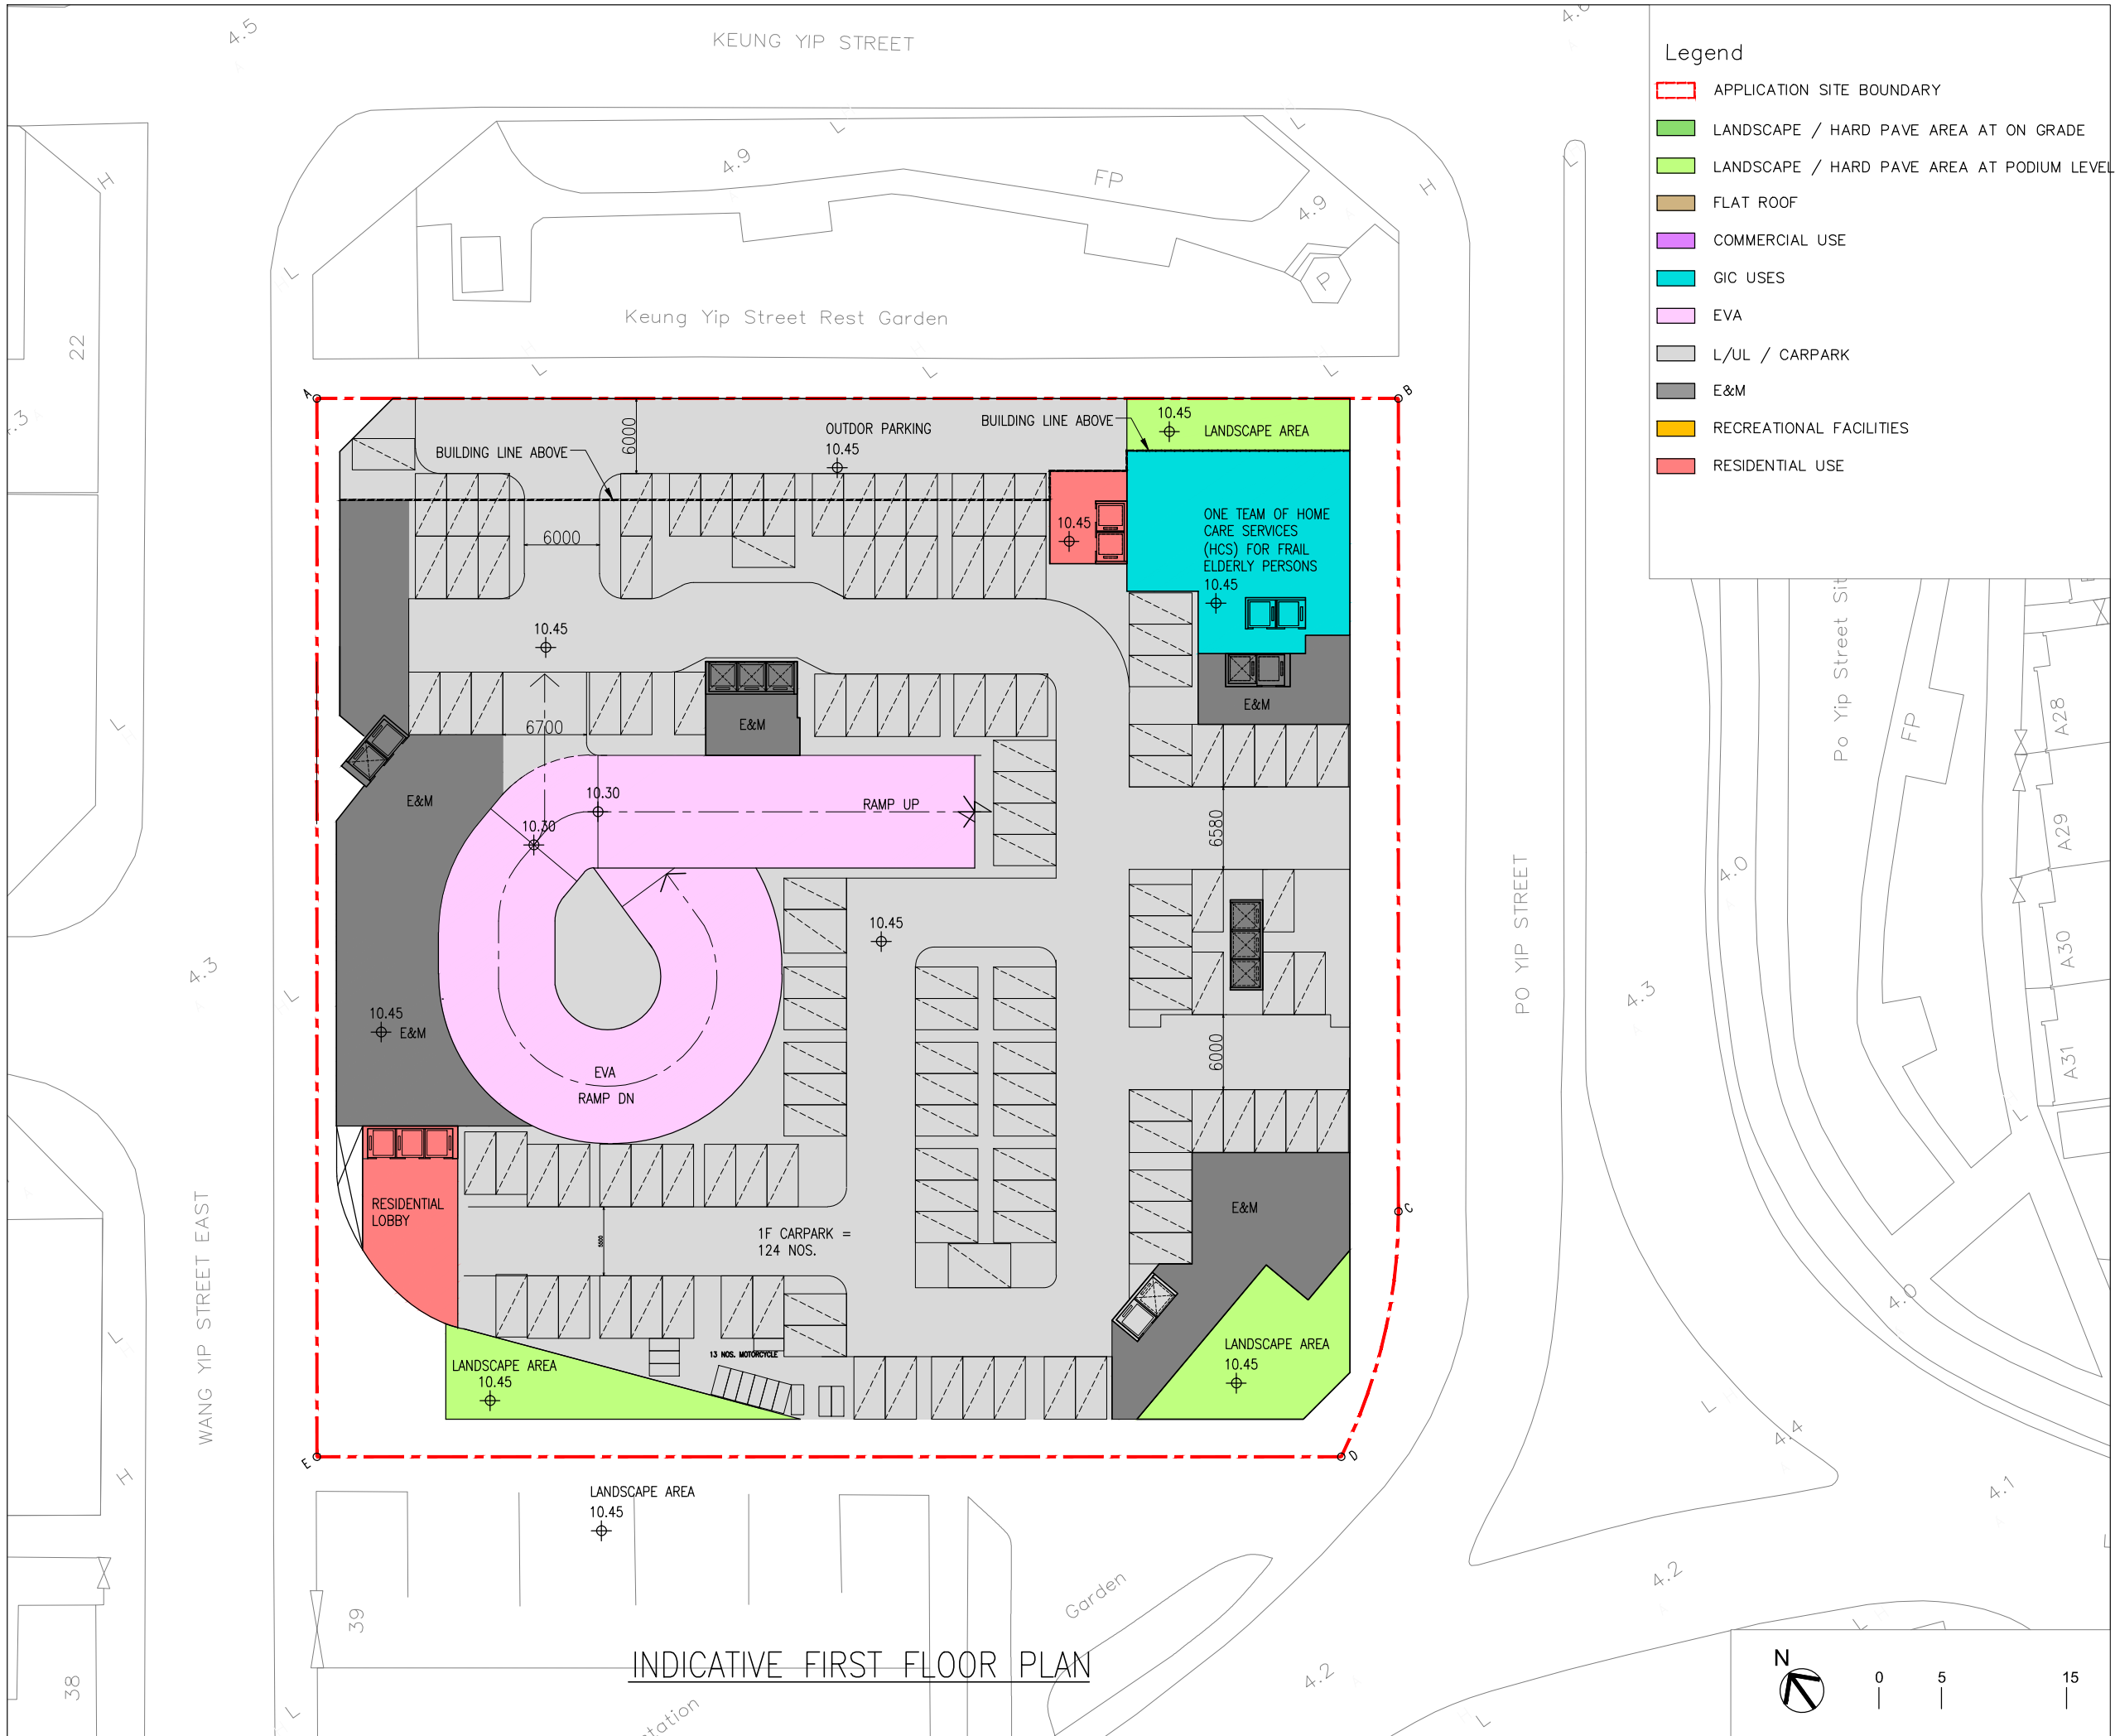

- Legend**
- APPLICATION SITE BOUNDARY
 - LANDSCAPE / HARD PAVE AREA AT ON GRADE
 - LANDSCAPE / HARD PAVE AREA AT PODIUM LEVEL
 - FLAT ROOF
 - COMMERCIAL USE
 - GIC USES
 - EVA
 - L/UL / CARPARK
 - E&M
 - RECREATIONAL FACILITIES
 - RESIDENTIAL USE

B.D. REFERENCE	屋宇署檔案
F.S.D. REFERENCE	消防處檔案
W.W.O. REFERENCE	水務署檔案
CAD FILE NAME	檔案編號

NOTES				注釋
NO. 修定號	REVISIONS 修定內容	DATE 日期	BY 經手人	

DLN

DLN Architects Limited 46-47 Floor, Tower One, Times Square
 劉榮廣伍振民建築師有限公司 Matheson Street, Causeway Bay, Hong Kong
 香港銅鑼灣勿地臣街 時代廣場一座46至47樓
 T +852 2895 6888 F +852 2576 4074 email general@dln.com.hk www.dln.com.hk


2ND DRAFT

ALL MEASUREMENTS MUST BE CHECKED AT THE WORK BY THE CONTRACTOR
 所有尺寸應由承建商於工地核實
 DO NOT SCALE FROM DRAWINGS. 尺寸不應由圖紙直接量度
 ALL PRINTS, SPECIFICATIONS AND THEIR COPYRIGHT ARE THE PROPERTY OF THE ARCHITECT AND SHALL BE RETURNED AT THE COMPLETION OF THE WORK
 所有印刷、規格說明及所有的版權屬於建築師及應在工程完結後歸還建築師


PROJECT	項目名稱
21-25 WANG YIP STREET EAST, YUEN LONG, NEW TERRITORIES, HONG KONG	

TITLE	標題
INDICATIVE FIRST FLOOR PLAN	

SCALE	比例	DATE	日期
1:500(A3)		APRIL 2026	
DRAWN BY	製作人	CHECKED BY	檢查
-		-	
JOB NO.	工程項目	DRAWING NO.	圖號
N3147-H		-	

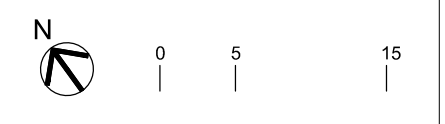

INDICATIVE FIRST FLOOR PLAN

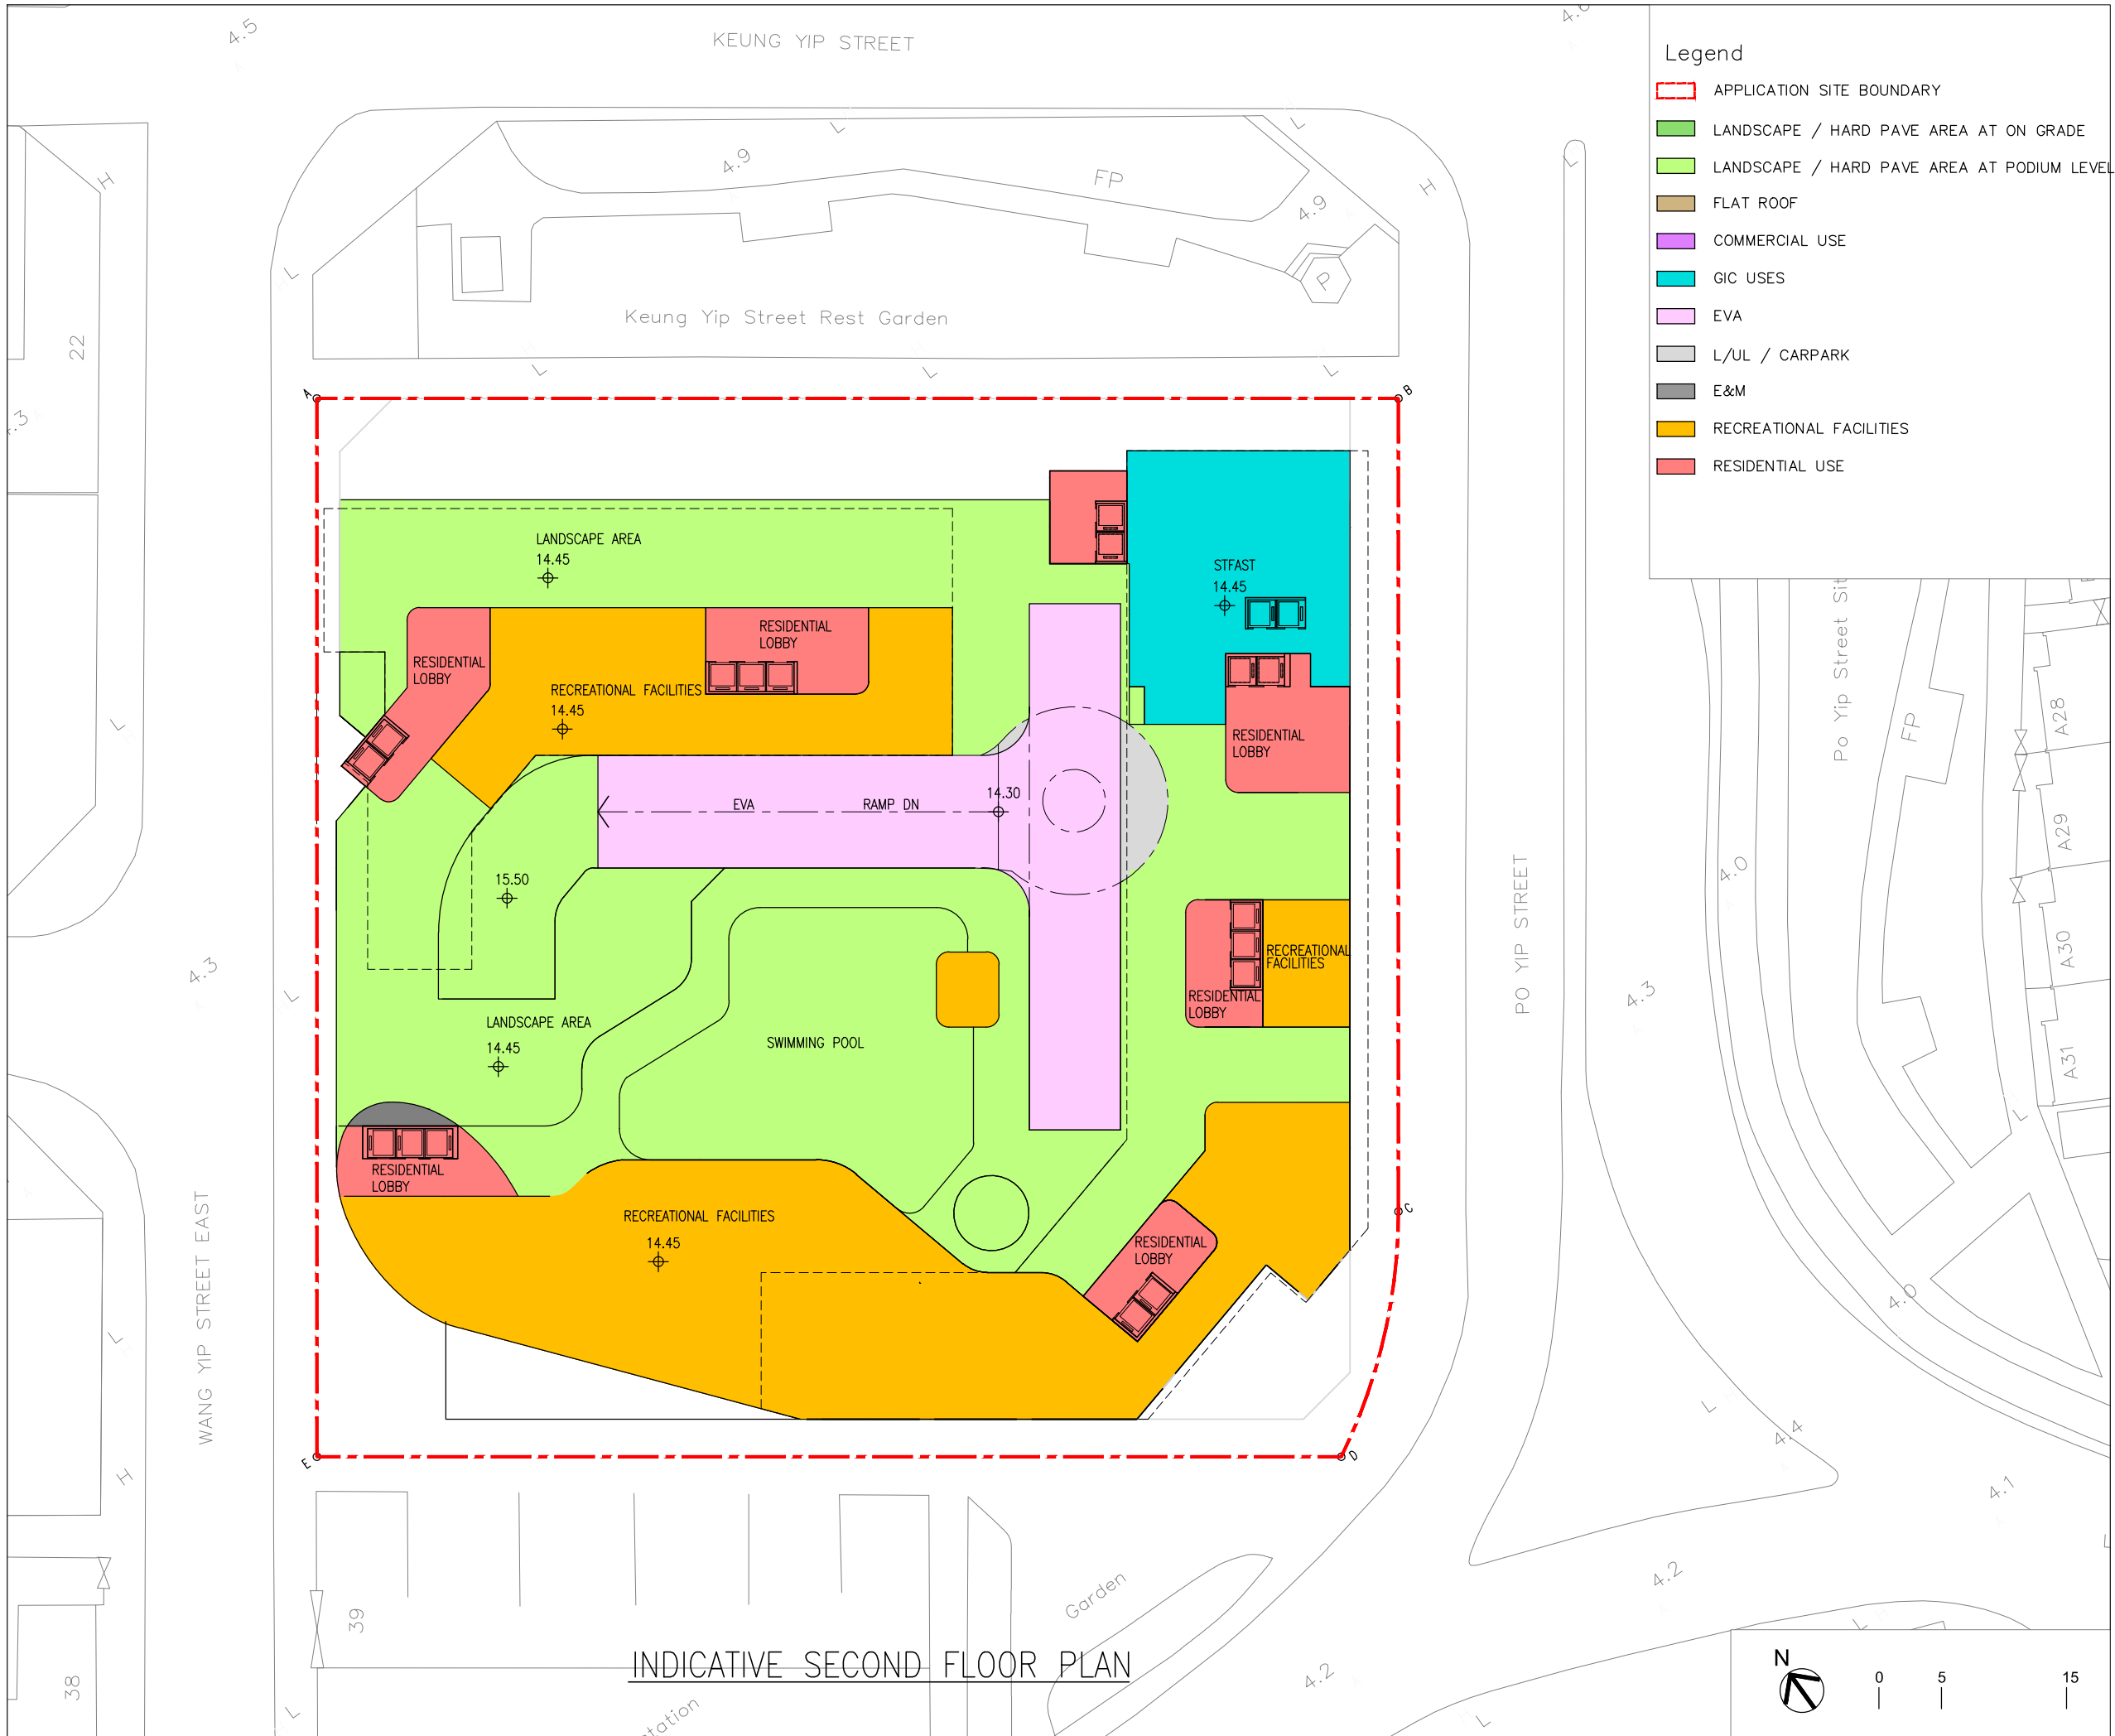

Legend

- APPLICATION SITE BOUNDARY
- LANDSCAPE / HARD PAVE AREA AT ON GRADE
- LANDSCAPE / HARD PAVE AREA AT PODIUM LEVEL
- FLAT ROOF
- COMMERCIAL USE
- GIC USES
- EVA
- L/UL / CARPARK
- E&M
- RECREATIONAL FACILITIES
- RESIDENTIAL USE

B.D. REFERENCE	屋宇署檔案
F.S.D. REFERENCE	消防處檔案
W.W.O. REFERENCE	水務署檔案
CAD FILE NAME	檔案編號

NOTES				注釋
NO. 修定號	REVISIONS 修定內容	DATE 日期	BY 經手人	

DLN

DLN Architects Limited 46-47 Floor, Tower One, Times Square
 劉榮廣伍振民建築師有限公司 Matheson Street, Causeway Bay, Hong Kong
 香港銅鑼灣勿地臣街 時代廣場一座46至47樓
 T +852 2895 6888 F +852 2576 4074 email general@dln.com.hk www.dln.com.hk


2ND DRAFT

ALL MEASUREMENTS MUST BE CHECKED AT THE WORK BY THE CONTRACTOR
 所有尺寸應由承建商於工地核實
 DO NOT SCALE FROM DRAWINGS. 尺寸不應由圖紙直接量度
 ALL PRINTS, SPECIFICATIONS AND THEIR COPYRIGHT ARE THE PROPERTY OF THE ARCHITECT AND SHALL BE RETURNED AT THE COMPLETION OF THE WORK
 所有印刷、規格說明及所有的版權屬於建築師及應在工程完結後歸還建築師

PROJECT	項目名稱
21-25 WANG YIP STREET EAST, YUEN LONG, NEW TERRITORIES, HONG KONG	

TITLE	標題
INDICATIVE SECOND FLOOR PLAN	

SCALE	比例	DATE	日期
1:500(A3)		APRIL 2026	
DRAWN BY	製作人	CHECKED BY	檢查
-		-	
JOB NO.	工程項目	DRAWING NO.	圖號
N3147-H		-	

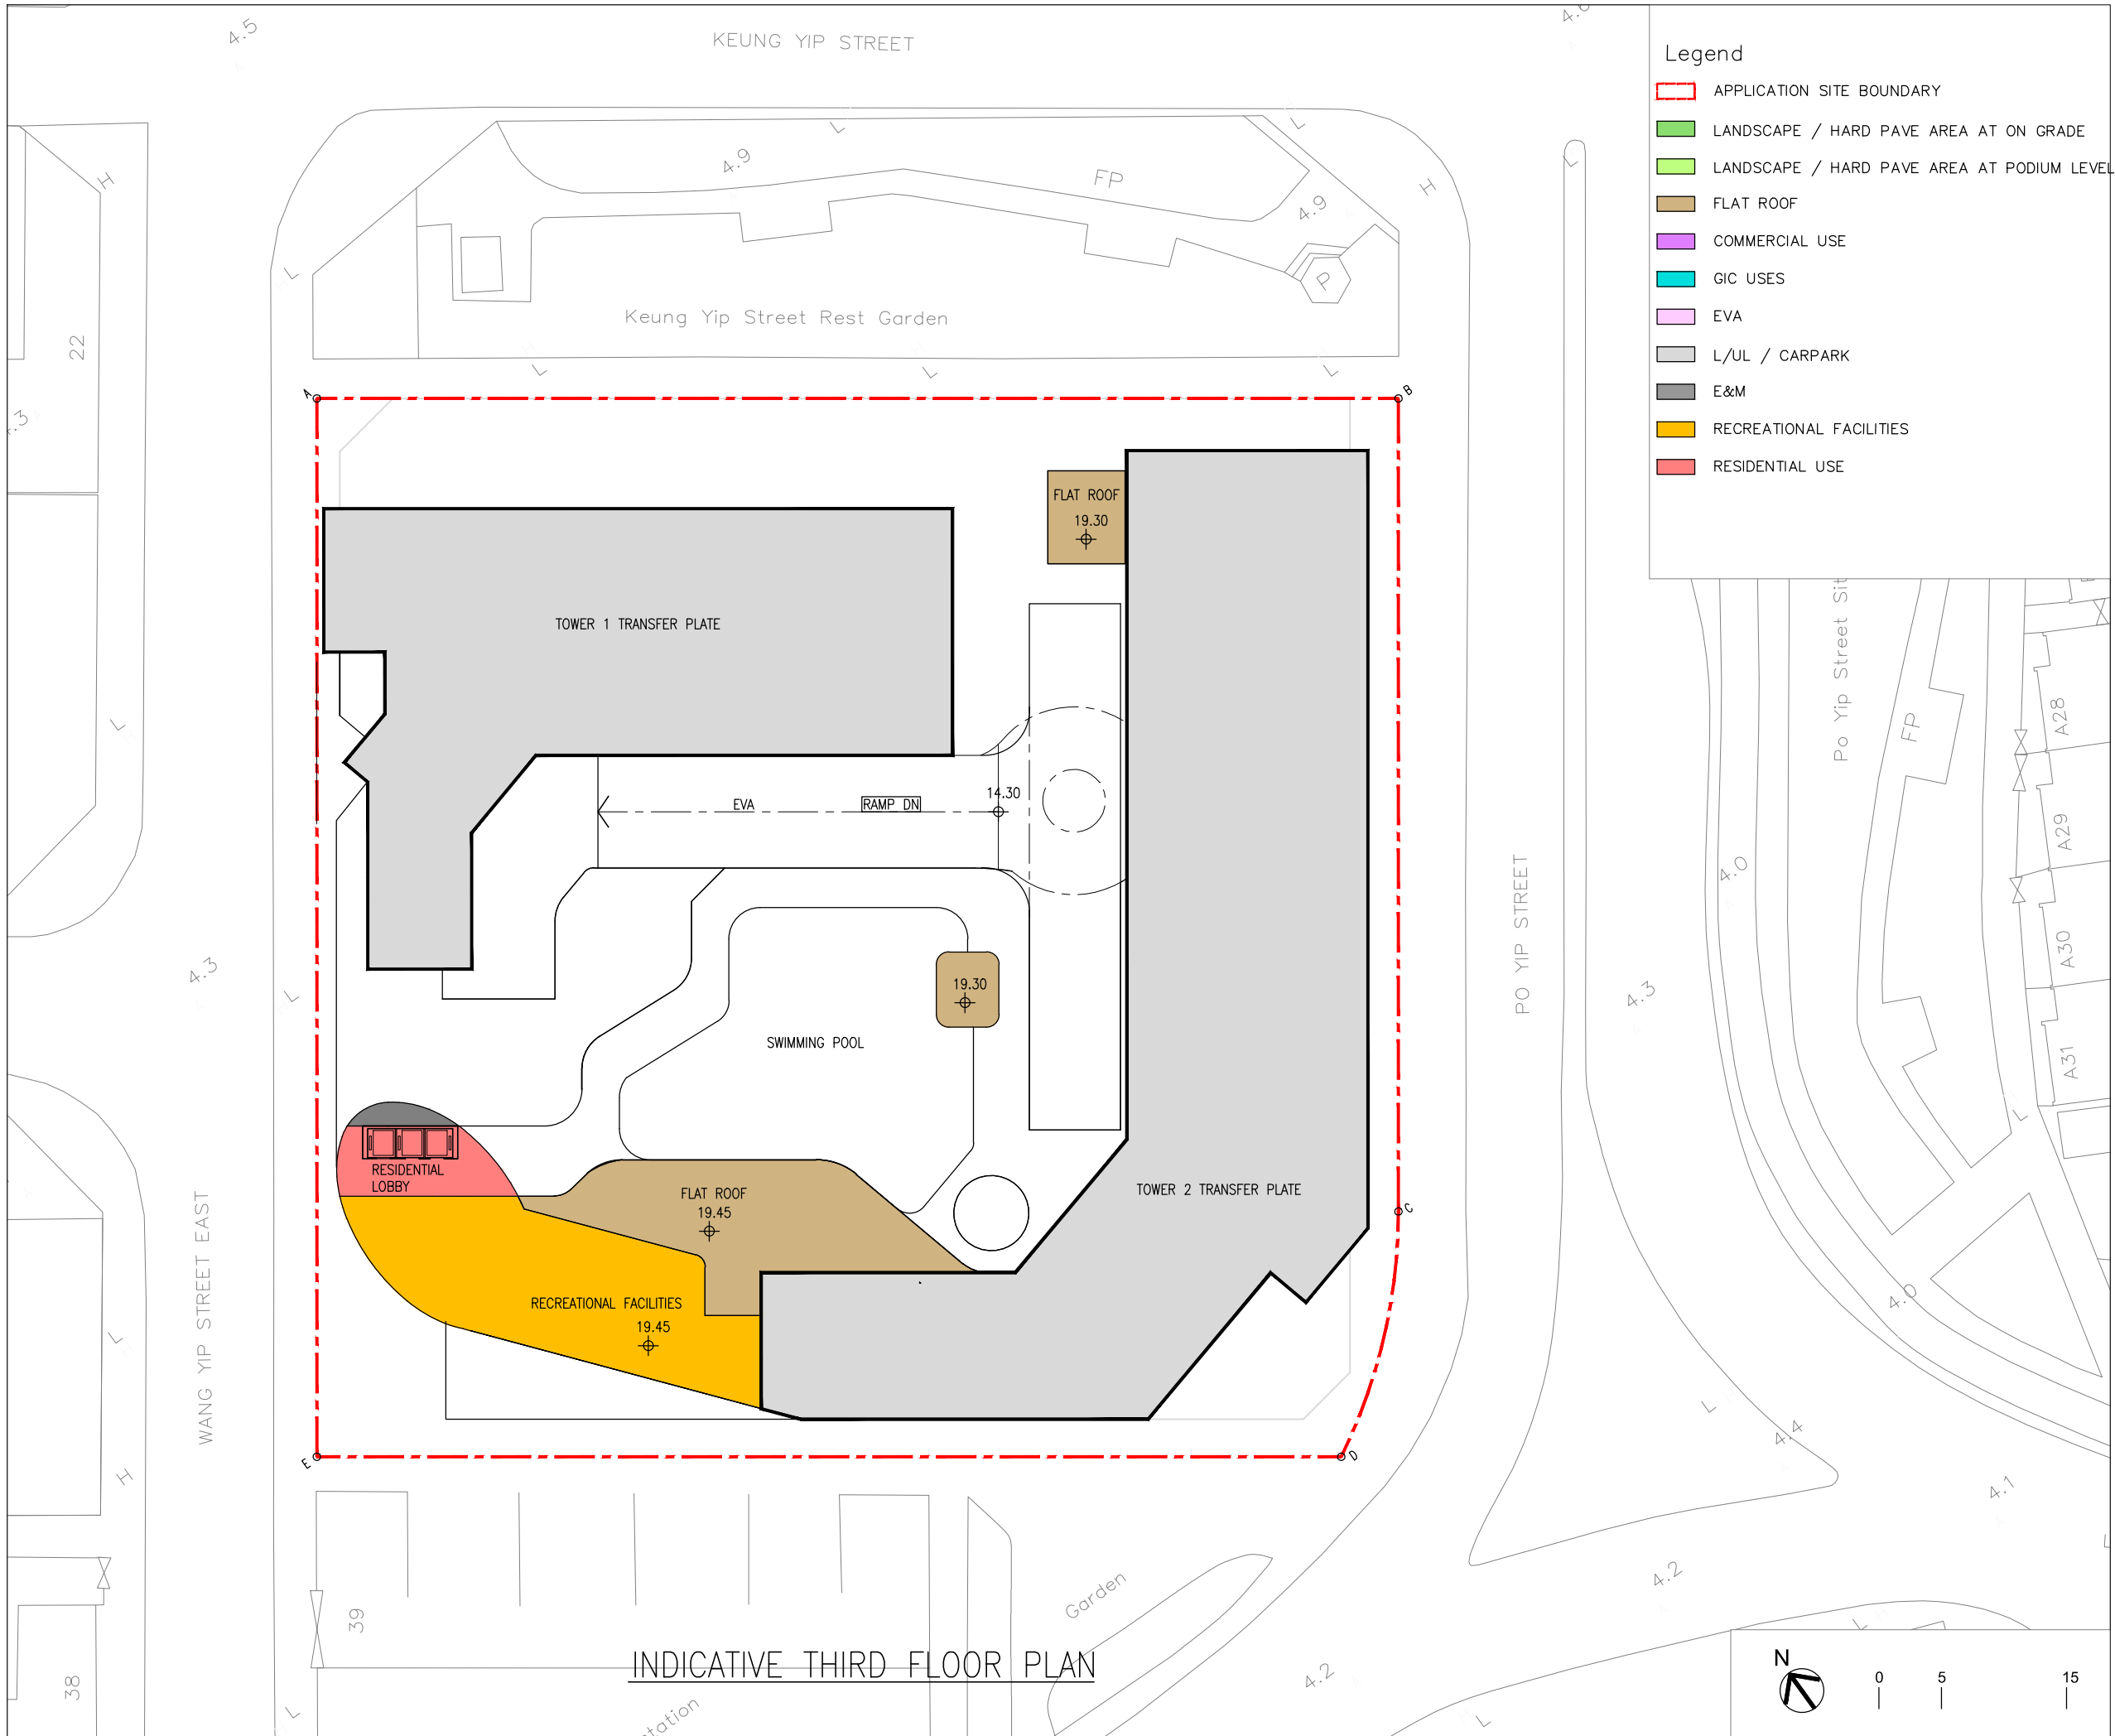

- Legend**
- APPLICATION SITE BOUNDARY
 - LANDSCAPE / HARD PAVE AREA AT ON GRADE
 - LANDSCAPE / HARD PAVE AREA AT PODIUM LEVEL
 - FLAT ROOF
 - COMMERCIAL USE
 - GIC USES
 - EVA
 - L/UL / CARPARK
 - E&M
 - RECREATIONAL FACILITIES
 - RESIDENTIAL USE

B.D. REFERENCE	屋宇署檔案
F.S.D. REFERENCE	消防處檔案
W.W.O. REFERENCE	水務署檔案
CAD FILE NAME	檔案編號

NOTES				注釋
NO. 修定號	REVISIONS 修定內容	DATE 日期	BY 經手人	

DLN

DLN Architects Limited 46-47 Floor, Tower One, Times Square
 Matheson Street, Causeway Bay, Hong Kong
 香港銅鑼灣勿地臣街
 時代廣場一座46至47樓
 T +852 2895 6888 F +852 2576 4074 email general@dln.com.hk www.dln.com.hk


2ND DRAFT

ALL MEASUREMENTS MUST BE CHECKED AT THE WORK BY THE CONTRACTOR
 所有尺寸應由承建商於工地核實
 DO NOT SCALE FROM DRAWINGS. 尺寸不應由圖紙直接量度
 ALL PRINTS, SPECIFICATIONS AND THEIR COPYRIGHT ARE THE PROPERTY OF
 THE ARCHITECT AND SHALL BE RETURNED AT THE COMPLETION OF THE WORK
 所有印刷、規格說明及所有的版權屬於建築師及應在工程完結後歸還建築師


PROJECT	項目名稱
21-25 WANG YIP STREET EAST, YUEN LONG, NEW TERRITORIES, HONG KONG	

TITLE	標題
INDICATIVE SECOND FLOOR PLAN	

SCALE	比例	DATE	日期
1:500(A3)		APRIL 2026	
DRAWN BY	製作人	CHECKED BY	檢查
-		-	
JOB NO.	工程項目	DRAWING NO.	圖號
N3147-H		-	

 

INDICATIVE THIRD FLOOR PLAN

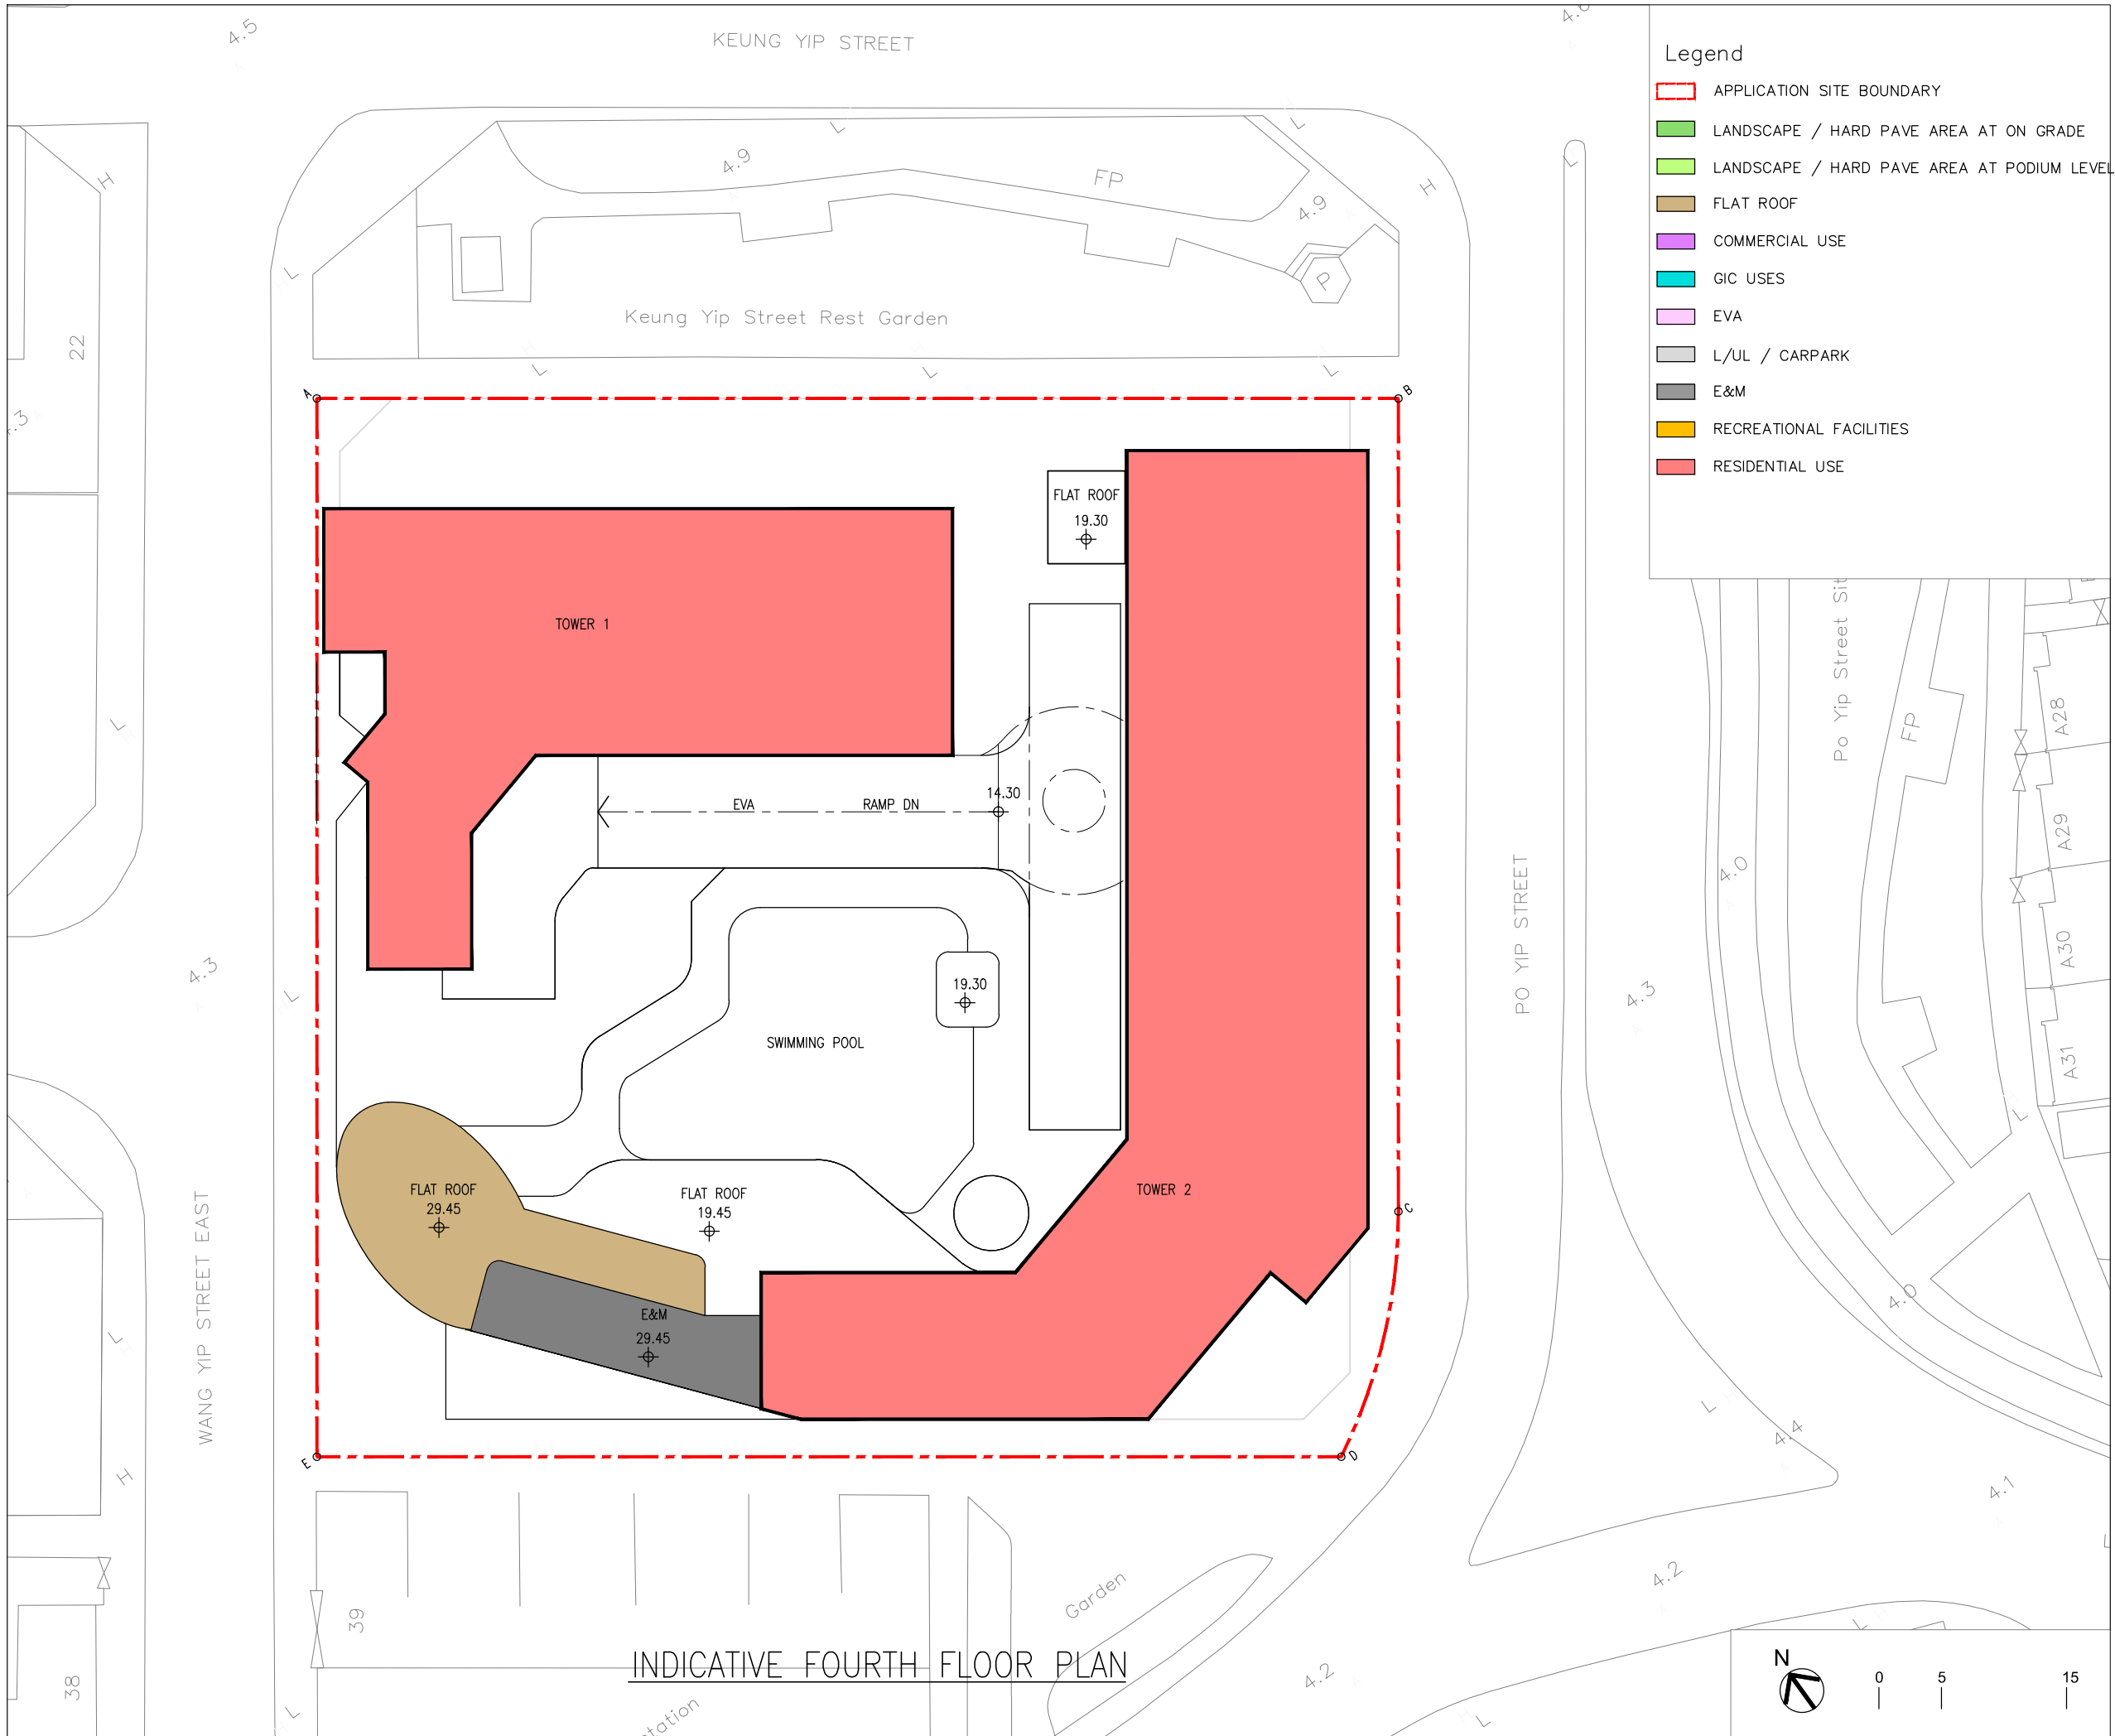

B.D. REFERENCE	屋宇署檔案
F.S.D. REFERENCE	消防處檔案
W.W.O. REFERENCE	水務署檔案
CAD FILE NAME	檔案編號

NOTES 注釋

NO. 修定號	REVISIONS 修定內容	DATE 日期	BY 經手人

DLN

DLN Architects Limited 46-47 Floor, Tower One, Times Square
 劉榮廣伍振民建築師有限公司 Matheson Street, Causeway Bay, Hong Kong
 香港銅鑼灣勿地臣街 時代廣場一座46至47樓
 T + 852 2895 6888 F + 852 2576 4074 email: general@dln.com.hk www.dln.com.hk


2ND DRAFT


ALL MEASUREMENTS MUST BE CHECKED AT THE WORK BY THE CONTRACTOR
 所有尺寸應由承建商於工地核實
 DO NOT SCALE FROM DRAWINGS. 尺寸不應由圖紙直接量度
 ALL PRINTS, SPECIFICATIONS AND THEIR COPYRIGHT ARE THE PROPERTY OF THE ARCHITECT AND SHALL BE RETURNED AT THE COMPLETION OF THE WORK
 所有印刷、規格說明及所有的版權屬於建築師及應在工程完結後歸還建築師

PROJECT	項目名稱
21-25 WANG YIP STREET EAST, YUEN LONG, NEW TERRITORIES, HONG KONG	



TITLE	標題
INDICATIVE SECOND FLOOR PLAN	

SCALE	比例	DATE	日期
1:500(A3)		APRIL 2026	
DRAWN BY	製作人	CHECKED BY	檢查
-		-	
JOB NO.	工程項目	DRAWING NO.	圖號
N3147-H		-	

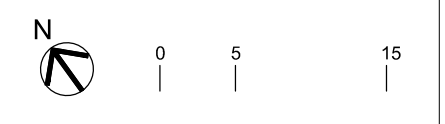

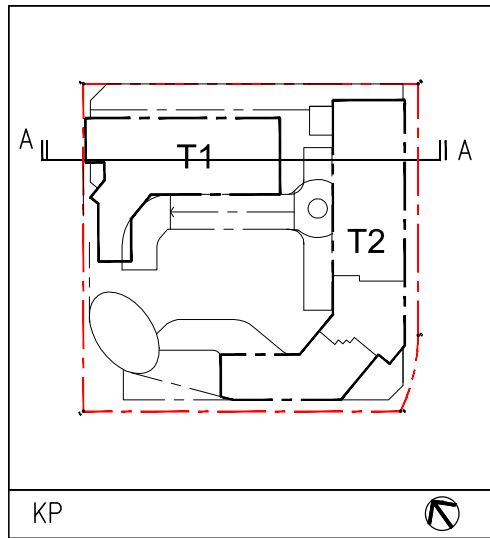

- Legend
- APPLICATION SITE BOUNDARY
 - COMMERCIAL USE
 - GIC USES
 - EVA
 - L/UL / CARPARK
 - E&M
 - RECREATIONAL FACILITIES
 - RESIDENTIAL USE

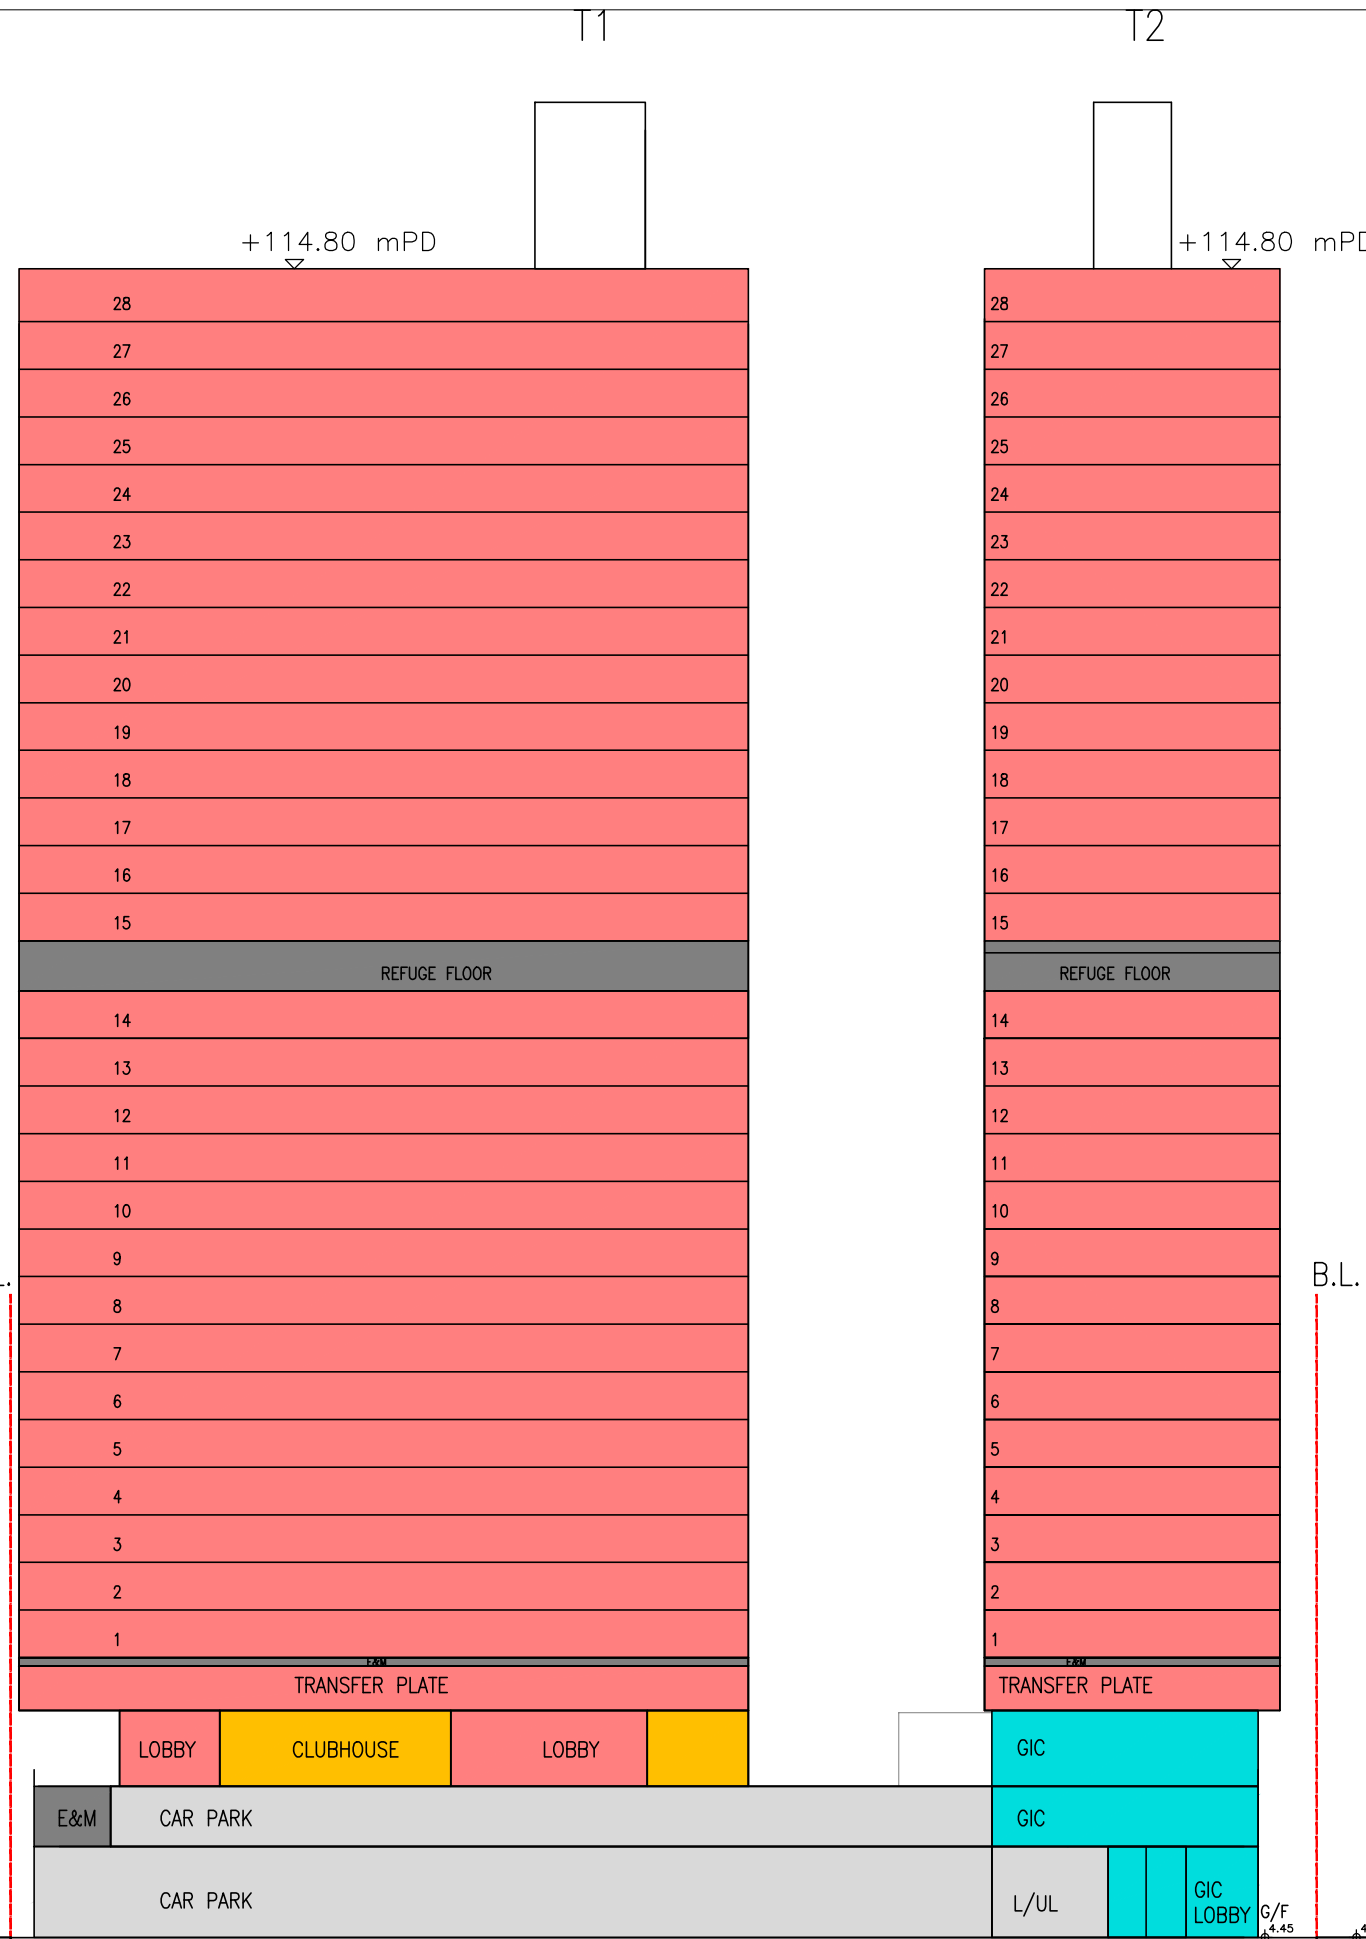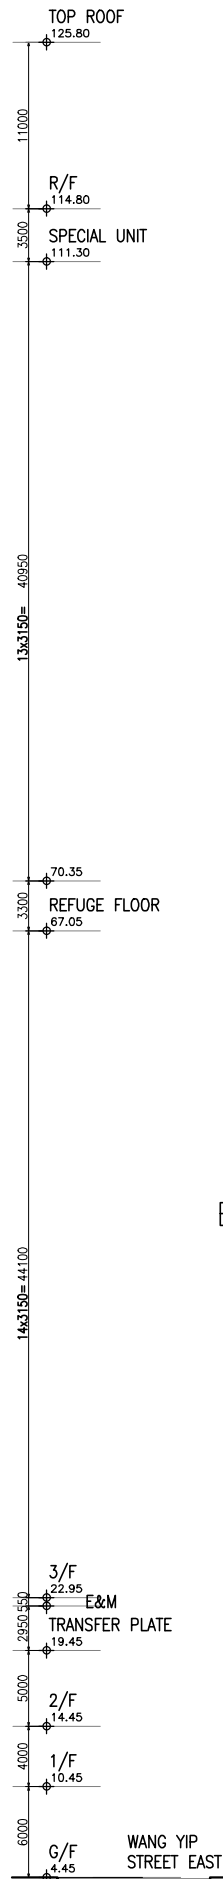

SECTION A-A

B.D. REFERENCE	屋宇署檔案
F.S.D. REFERENCE	消防處檔案
W.W.O. REFERENCE	水務署檔案
CAD FILE NAME	檔案編號

NOTES 注釋

NO. 修定號	REVISIONS 修定內容	DATE 日期	BY 經手人

DLN Architects Limited 46-47 Floor, Tower One, Times Square
 Matheson Street, Causeway Bay, Hong Kong
 劉榮廣伍振民建築師有限公司
 香港銅鑼灣勿地臣街
 時代廣場一座46至47樓
 T + 852 2895 6888 F + 852 2576 4074 email: general@dln.com.hk www.dln.com.hk


2ND DRAFT

ALL MEASUREMENTS MUST BE CHECKED AT THE WORK BY THE CONTRACTOR
 所有尺寸應由承建商於工地核實
 DO NOT SCALE FROM DRAWINGS. 尺寸不應由圖紙直接量度
 ALL PRINTS, SPECIFICATIONS AND THEIR COPYRIGHT ARE THE PROPERTY OF
 THE ARCHITECT AND SHALL BE RETURNED AT THE COMPLETION OF THE WORK
 所有印刷、規格說明及所有的版權屬於建築師及應在工程完結後歸還建築師


PROJECT 項目名稱	21-25 WANG YIP STREET EAST, YUEN LONG, NEW TERRITORIES, HONG KONG
--------------	--

TITLE 標題	INDICATIVE SECTION PLAN
----------	-------------------------

SCALE 比例	1:500(A3)	DATE 日期	MAR 2026
DRAWN BY 製作人	-	CHECKED BY 檢查	-
JOB NO. 工程項目	N3147-H	DRAWING NO. 圖號	-

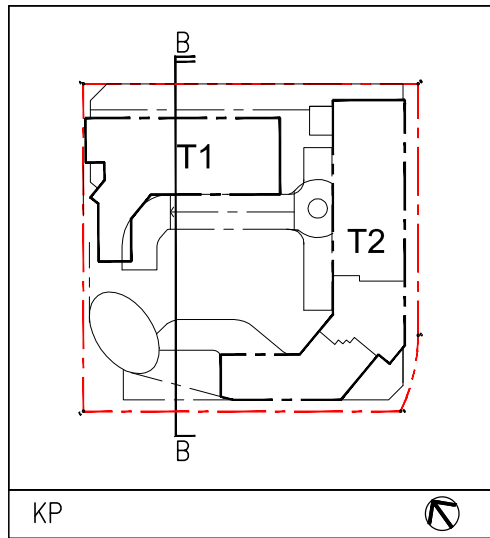

- Legend
- APPLICATION SITE BOUNDARY
 - COMMERCIAL USE
 - GIC USES
 - EVA
 - L/UL / CARPARK
 - E&M
 - RECREATIONAL FACILITIES
 - RESIDENTIAL USE

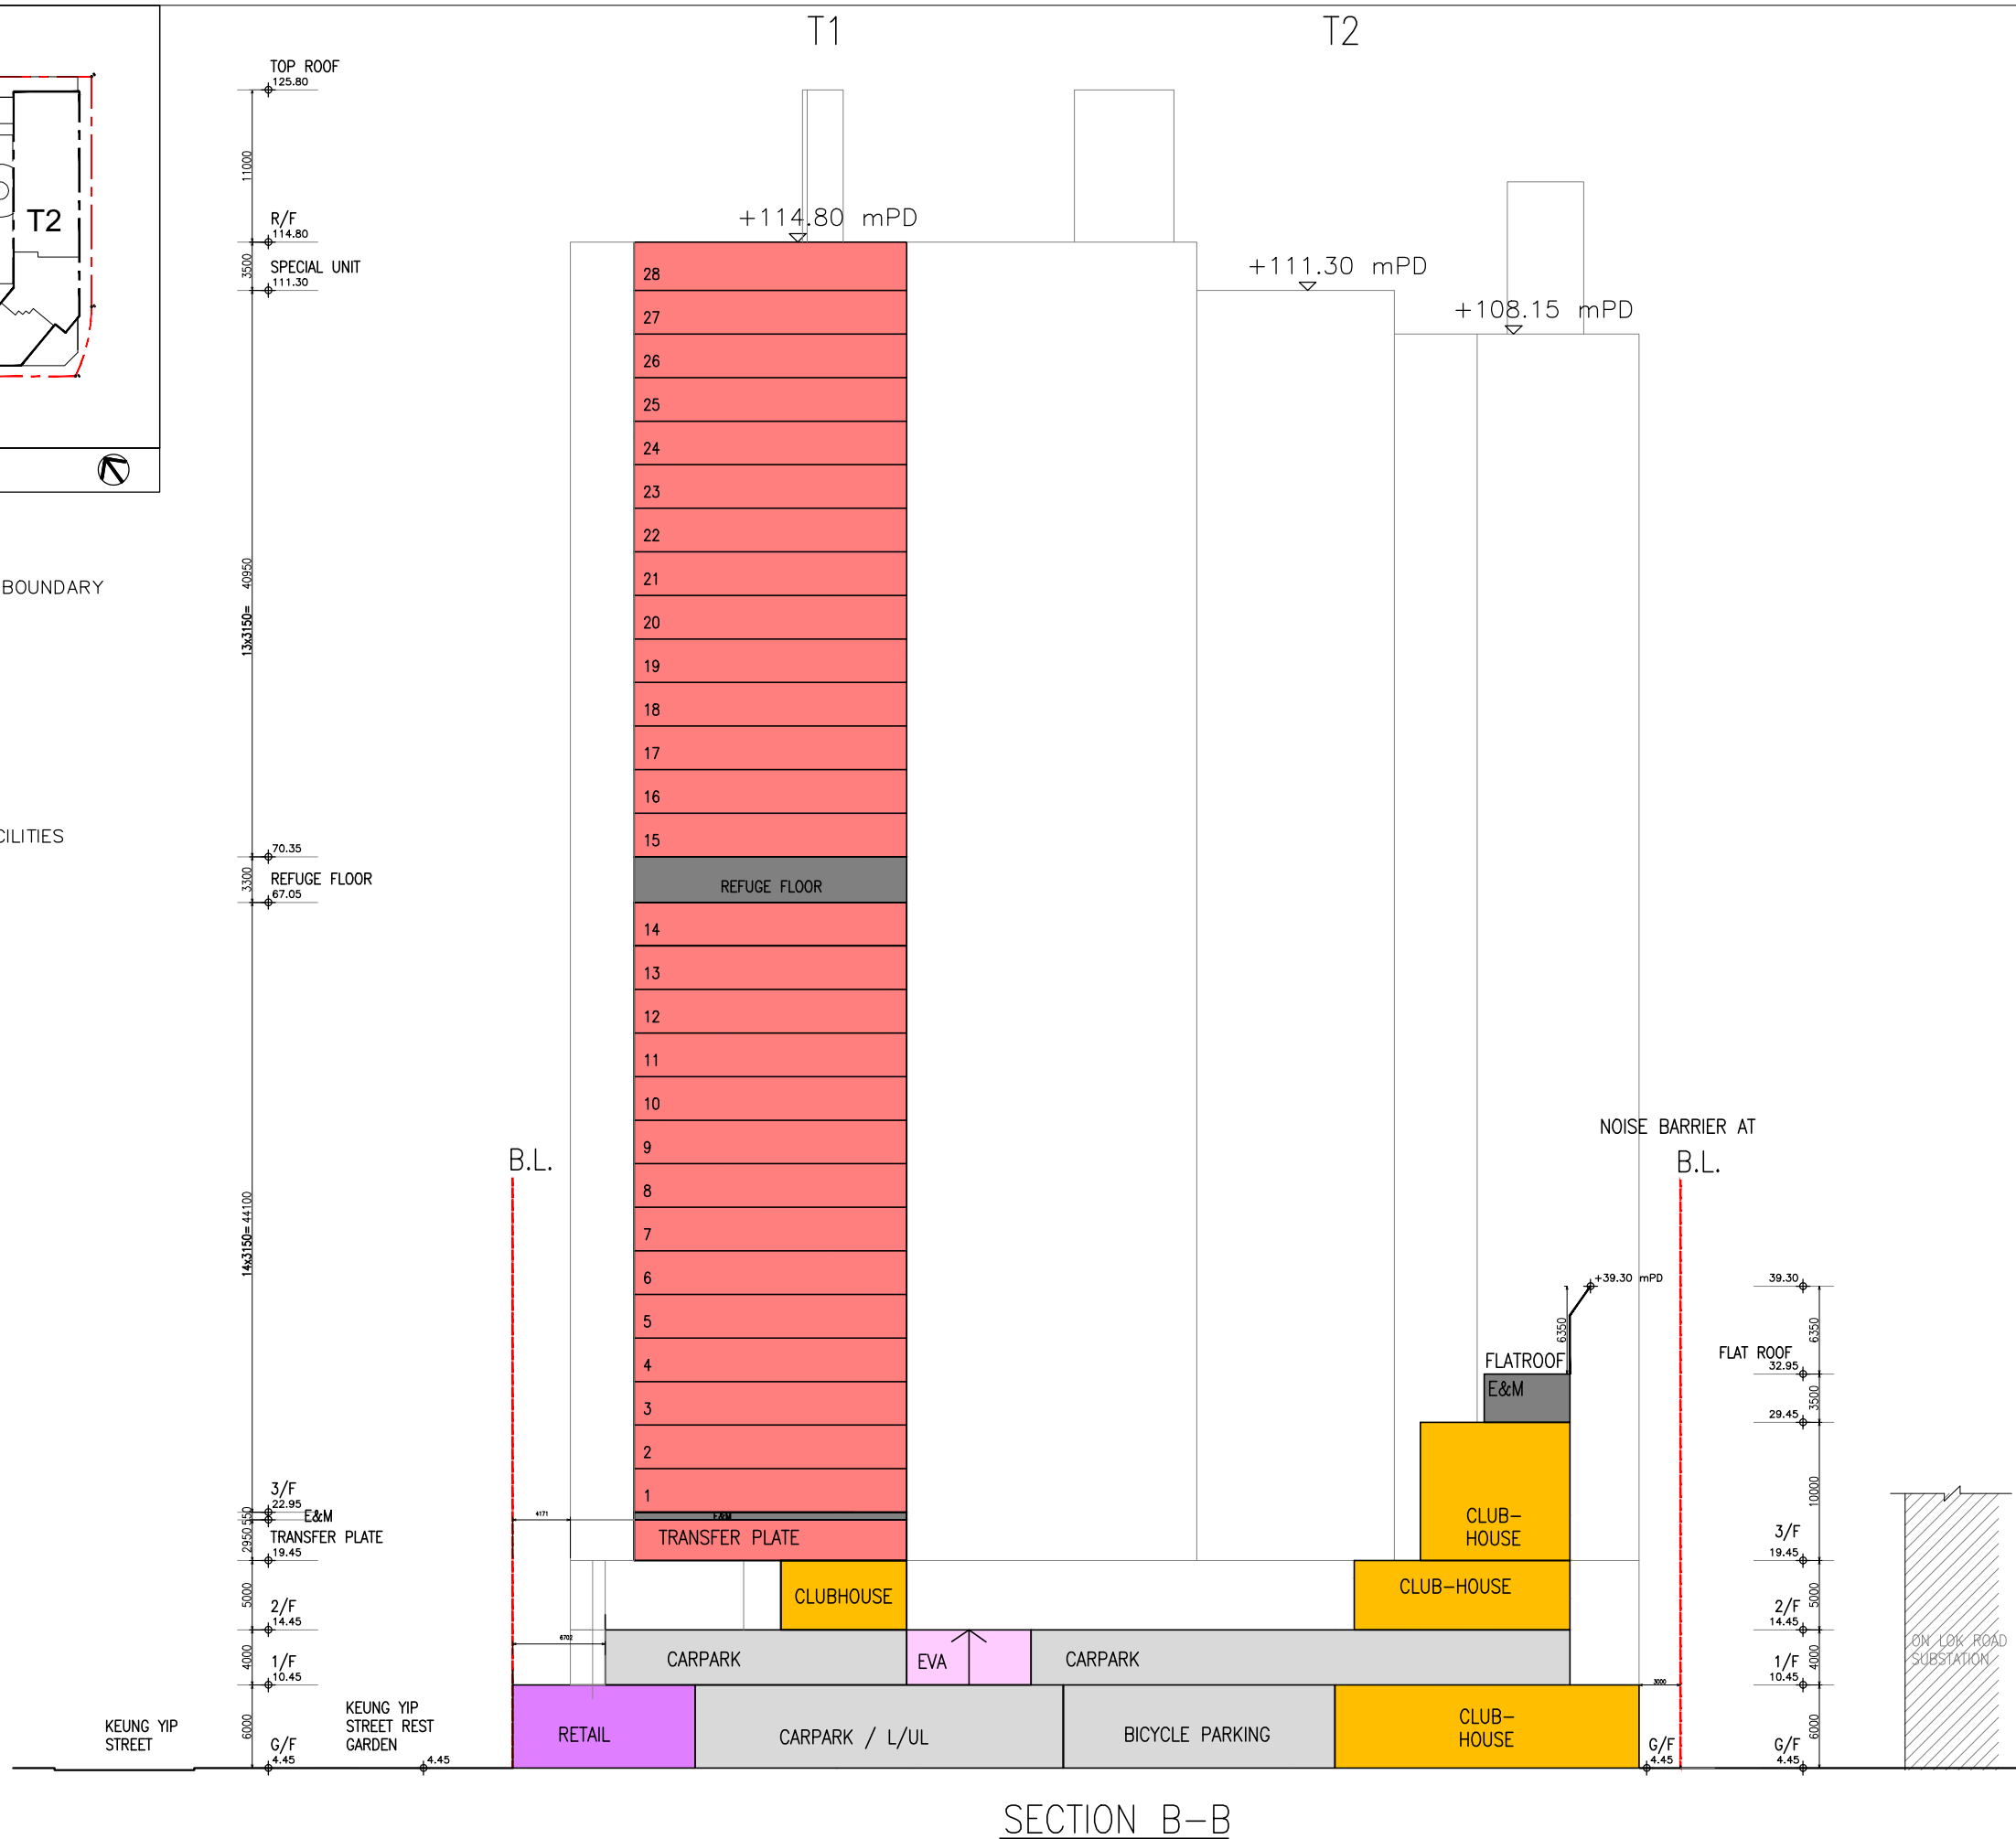

SECTION B-B

B.D. REFERENCE	屋宇署檔案
F.S.D. REFERENCE	消防處檔案
W.W.O. REFERENCE	水務署檔案
CAD FILE NAME	檔案編號

NOTES 注釋

NO. 修定號	REVISIONS 修定內容	DATE 日期	BY 經手人

DLN

DLN Architects Limited 46-47 Floor, Tower One, Times Square
 劉榮廣伍振民建築師有限公司 Matheson Street, Causeway Bay, Hong Kong
 香港銅鑼灣勿地臣街 時代廣場一座46至47樓
 T + 852 2895 6888 F + 852 2576 4074 email: general@dln.com.hk www.dln.com.hk

2ND DRAFT

ALL MEASUREMENTS MUST BE CHECKED AT THE WORK BY THE CONTRACTOR
 所有尺寸應由承建商於工地核實
 DO NOT SCALE FROM DRAWINGS 尺寸不應由圖紙直接量度
 ALL PRINTS, SPECIFICATIONS AND THEIR COPYRIGHT ARE THE PROPERTY OF THE ARCHITECT AND SHALL BE RETURNED AT THE COMPLETION OF THE WORK
 所有印刷、規格說明及所有的版權屬於建築師及應在工程完結後歸還建築師

PROJECT	項目名稱
21-25 WANG YIP STREET EAST, YUEN LONG, NEW TERRITORIES, HONG KONG	

TITLE	標題
INDICATIVE SECTION PLAN	

SCALE 比例	DATE 日期
1:500(A3)	APRIL 2026
DRAWN BY 製作人	CHECKED BY 檢查
-	-
JOB NO. 工程項目	DRAWING NO. 圖號
N3147-H	-