

Total: 3 pages

Date: 11 May 2026

TPB Ref.: A/YL-PS/779

By Email

Town Planning Board  
15/F, North Point Government Offices  
333, Java Road  
North Point  
Hong Kong  
(Attn: The Secretary)

Dear Sir,

**Proposed Temporary Shop & Services for a Period of 3 Years at Lot 455 S.A RP in D.D.122 & Adjoining Government Land, Ping Shan, Yuen Long, N.T.**

We write to confirm that the layout and the use of the proposed development at the captioned site is the same as the layout and use of the last planning permission No. A/YL-PS/682.

We are glad to submit the FSI plan and the FS251 certificate herewith for the consideration of the Director of Fire Services (D of FS).


Should you have any enquiries, please feel free to contact our Mr. Patrick Tsui at [REDACTED] [REDACTED] at your convenience.

Yours faithfully,



Patrick Tsui

c.c. Tuen Mun and Yuen Long West District Planning Office (Attn: Ms. Emily WONG) – By Email

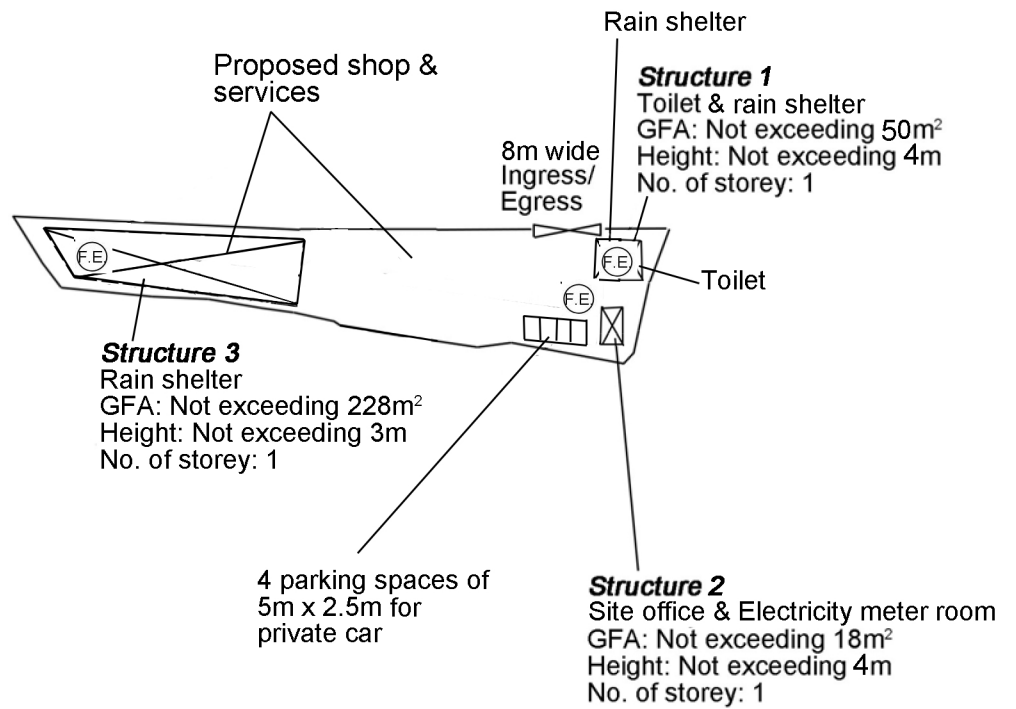

Project 項目名稱: Proposed Temporary Shop & Services for a Period of 3 Years at Lot 455 S.A RP in D.D. 122 and Adjoining Government Land, Ping Shan, Yuen Long, N.T.	Drawing Title 圖目: Proposed Fire Service Installations Proposal	Remarks 備註: (F.E) 9 litre water type fire extinguisher
	Drawing No. 圖號: Figure 1	Scale 比例: 1:1000

消防處檔號: \_\_\_\_\_  
FSD Ref.

消防(裝置及設備)規例(第九條(1)款)消防裝置及設備證書  
FIRE SERVICE (INSTALLATIONS AND EQUIPMENT) REGULATIONS  
(REGULATION 9(1))  
CERTIFICATE OF FIRE SERVICE INSTALLATION AND EQUIPMENT

序號 Serial Number  
00000000439 400070

顧客姓名  
Name of Client

樓宇地址  
Address of Building

座  
Block

樓宇名稱  
Name of Building

屋邨/鄉村名稱  
Name of Estate/Village

門牌號數及街道/地段  
Number and Name of Street/Lot

地區  
District

香港  
HK  九龍  
K  新界  
NT

- 持牌/註冊處所類型 (如適用)  
Type of Licensed/Registered Premises (If applicable)
- 請在合適空格內填上「✓」號  
Please tick the appropriate "box"
- 簡樸房 Basic Housing Unit
  - 危險品倉 Dangerous Goods Store
  - 食物業處所 Food Premises
  - 校舍 School Premises
  - 幼兒中心 Child Care Centre
  - 酒店 Hotel
  - 會社 Club
  - 木料倉 Timber Store
  - 電器廢物處置 E-waste Disposal
  - 改建校舍 Non-designed School
  - 私營骨灰安置所 Private Columbaria
  - 賓館 Guesthouse
  - 床位寓所 Bedspace Apartment
  - 危險品車輛 Dangerous Good Vehicle
  - 公眾娛樂場所 Place of Public Entertainment
  - 安老院舍 Residential Care Home for the Elderly
  - 殘疾院舍 Residential Care Home for Persons with Disabilities
  - 卡拉 OK 場所 Karaoke Establishment

**第一部 只適用於年檢事項**  
**Part 1 Annual Inspection ONLY**

根據《消防(裝置及設備)規例》第八條(1)(b)款，擁有裝置在任何處所內的任何消防裝置或設備的人，須每12個月由一名註冊承辦商檢查該等消防裝置或設備至少一次。  
In accordance with Regulation 8(1)(b) of Fire Service (Installations and Equipment) Regulations, the owner of any fire service installation or equipment which is installed in any premises shall have such fire service installation or equipment inspected by a registered contractor at least once in every 12 months.

編碼 Code (1-35)	裝置類型 Type of FSI	位置 Location(s)	狀況評述 Comment on Condition	完成日期 Completion Date (DD/MM/YYYY)	到期日 Due Date (DD/MM/YYYY)
24	3 x Water 9 litres type F.E.	As above	Conforms with FSD requirements	06/05/2026	05/05/2027

**第二部 Part 2 裝置/保養/修理/檢查工作 Installation/Maintenance/Repair/Inspection work**

編碼 Code (1-35)	裝置類型 Type of FSI	位置 Location(s)	完成之工作內容 Nature of Work Carried out	狀況評述 Comment on Condition	完成日期 Completion Date (DD/MM/YYYY)	消防裝置關閉/嚴重損壞/恢復通知書 FSD serial number of Notification of FSI Shutdown/Major Defect/Resumption

**第三部 Part 3 欠妥事項 Defects**

編碼 Code (1-35)	裝置類型 Type of FSI	位置 Location(s)	欠妥事項 Defects (請以「*」註明主要系統嚴重損壞 Please indicate major defects in major system with a "*" sign)	欠妥事項評述 Comment on Defects	消防裝置關閉/嚴重損壞/恢復通知書 FSD serial number of Notification of FSI Shutdown/Major Defect/Resumption

本人/我們特此聲明，上述之消防裝置/設備經測試及/或檢查，其運作狀況符合消防處處長訂明適用於該建築物/處所的《最低限度之消防裝置及設備守則》中的規格/要求，以及最新的《裝置及設備之檢查、測試及保養守則》中的要求，以證明其性能良好，除在第三部分中詳列的裝置/設備欠妥事項（如有）。

I/We hereby declare that the above installations/equipment has/have been tested and/or inspected, with its/their working conditions certified in conformance with the specifications/requirements in the Code of Practice for Minimum Fire Service Installations and Equipment applicable to the building/premises and the requirements in the latest Code of Practice for Inspection, Testing and Maintenance of Installations and Equipment prescribed by the Director of Fire Services to be in efficient working order except defect(s) of the installations/equipment, if any, detailed in Part 3.

請將此證書張貼於大廈或處所當眼處以供消防處人員查核  
Please display this certificate at a conspicuous place in the building or premises for FSD's inspection.

註冊編號  
Registration No. RC3/0439

註冊消防裝置承辦商名稱  
Name of Registered Fire Service Installation Contractor  
Chim Chung Yam

聯絡電話  
Telephone

電郵地址  
Email address

日期  
Date 06/05/2026

備註  
Remark

