

參考編號  
REFERENCE No.

A/NE-MKT/19


繪圖

DRAWING A-1

( 來源 : 附件 1h )  
( Source : Appendix 1h )

Plot Date: 1/21/2022 5:08:30 PM

File Name: Y:\Daily Work\03 BIM model\Project\DS\382813\03-Model\382813-AR.rvt

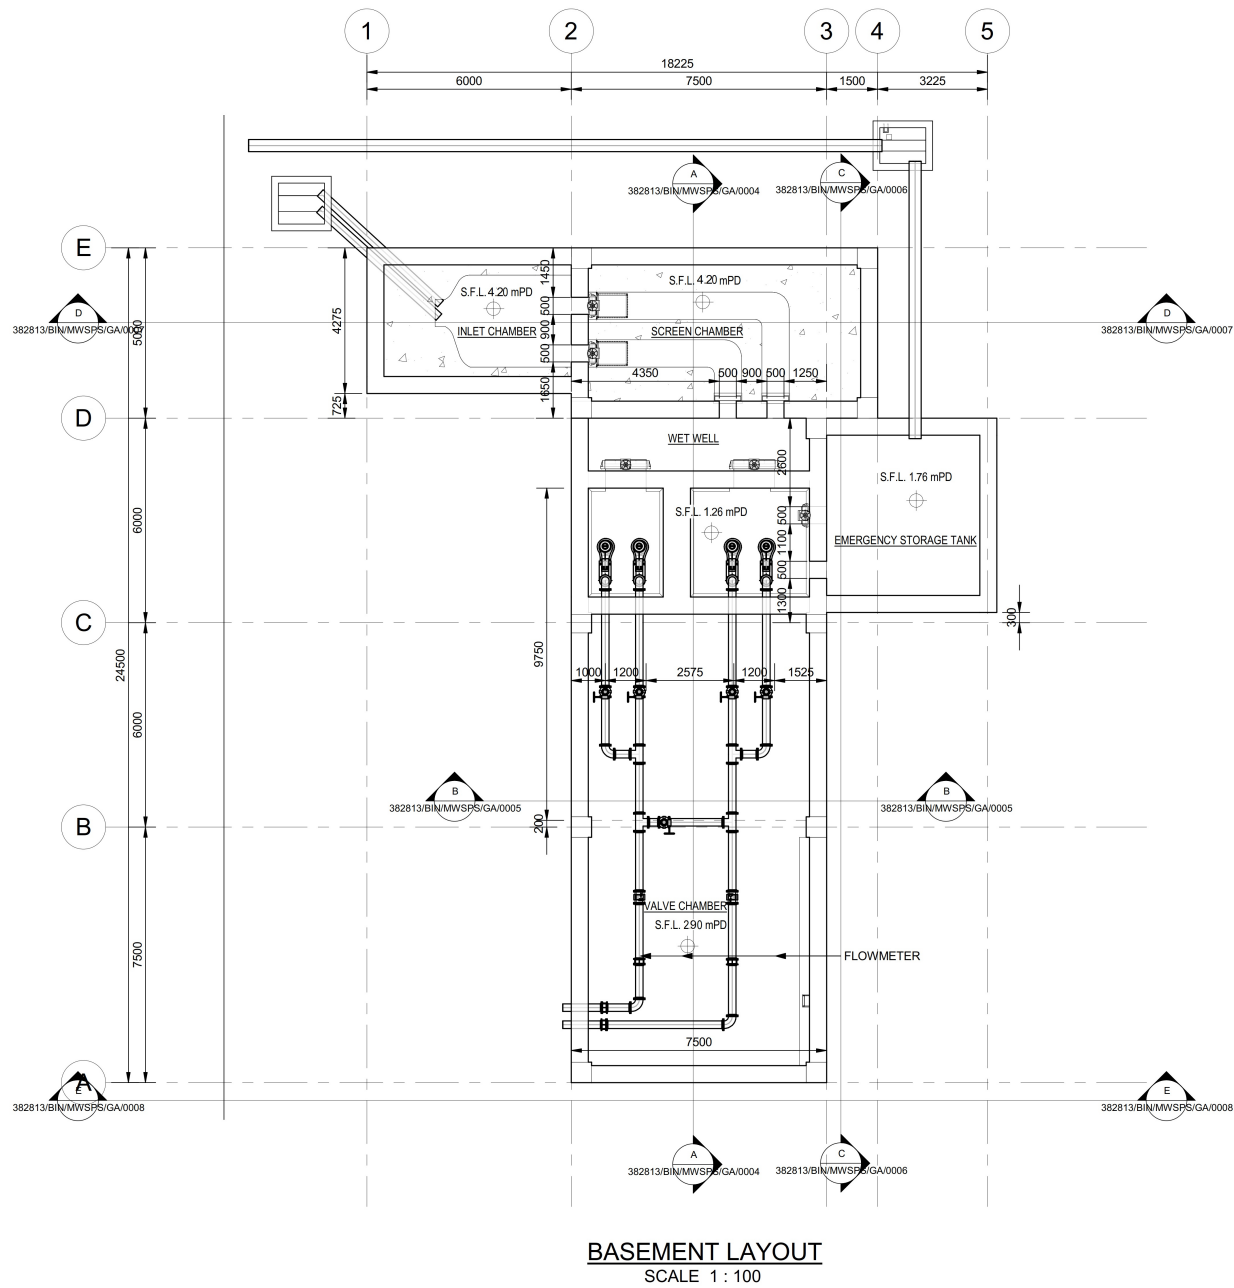

© Copyright by Binnies Hong Kong Limited

NOTE:

1. ALL DIMENSIONS ARE IN MILLIMETERS UNLESS OETHERWISR STATED.  
2. ALL LEVEL ARE IN METERS ABOVE PRINCIPAL DATUM.

0	-	-	-
Revision	Date	Description	Initial
	Designed	Checked	Drawn
Initial			SZ
Date			

Approved

Contract No. CE 50/2007 (DS)

Contract Title  
NORTH DISTICT SEWERAGE STAGE 2 (REMINDER) AND SEWERAGE TO CHUEN LUNG, KAU WA KEUNG OLD VILLAGE AND LO WAI

Drawing Title  
MUK WU SEWAGE PUMPING STATION - BASEMENT LAYOUT PLAN

Drawing No. FIGURE 7	Revision 0
----------------------	------------

Scale 1:100

香港特別行政區政府渠務署  
THE GOVERNMENT OF THE HONG KONG  
SPECIAL ADMINISTRATIVE REGION  
DRAINAGE SERVICES DEPARTMENT

**binnies**  
BINNIES HONG KONG LIMITED  
賓尼斯工程顧問有限公司

參考編號  
REFERENCE No.

A/NE-MKT/19


繪圖 DRAWING A-2

( 來源 : 附件 1h )  
( Source : Appendix 1h )



Plot Date: 1/21/2022 5:08:30 PM

File Name: Y:\Daily Work\03 BIM model\Project\DS\382813\03-Model\382813-AR.rvt

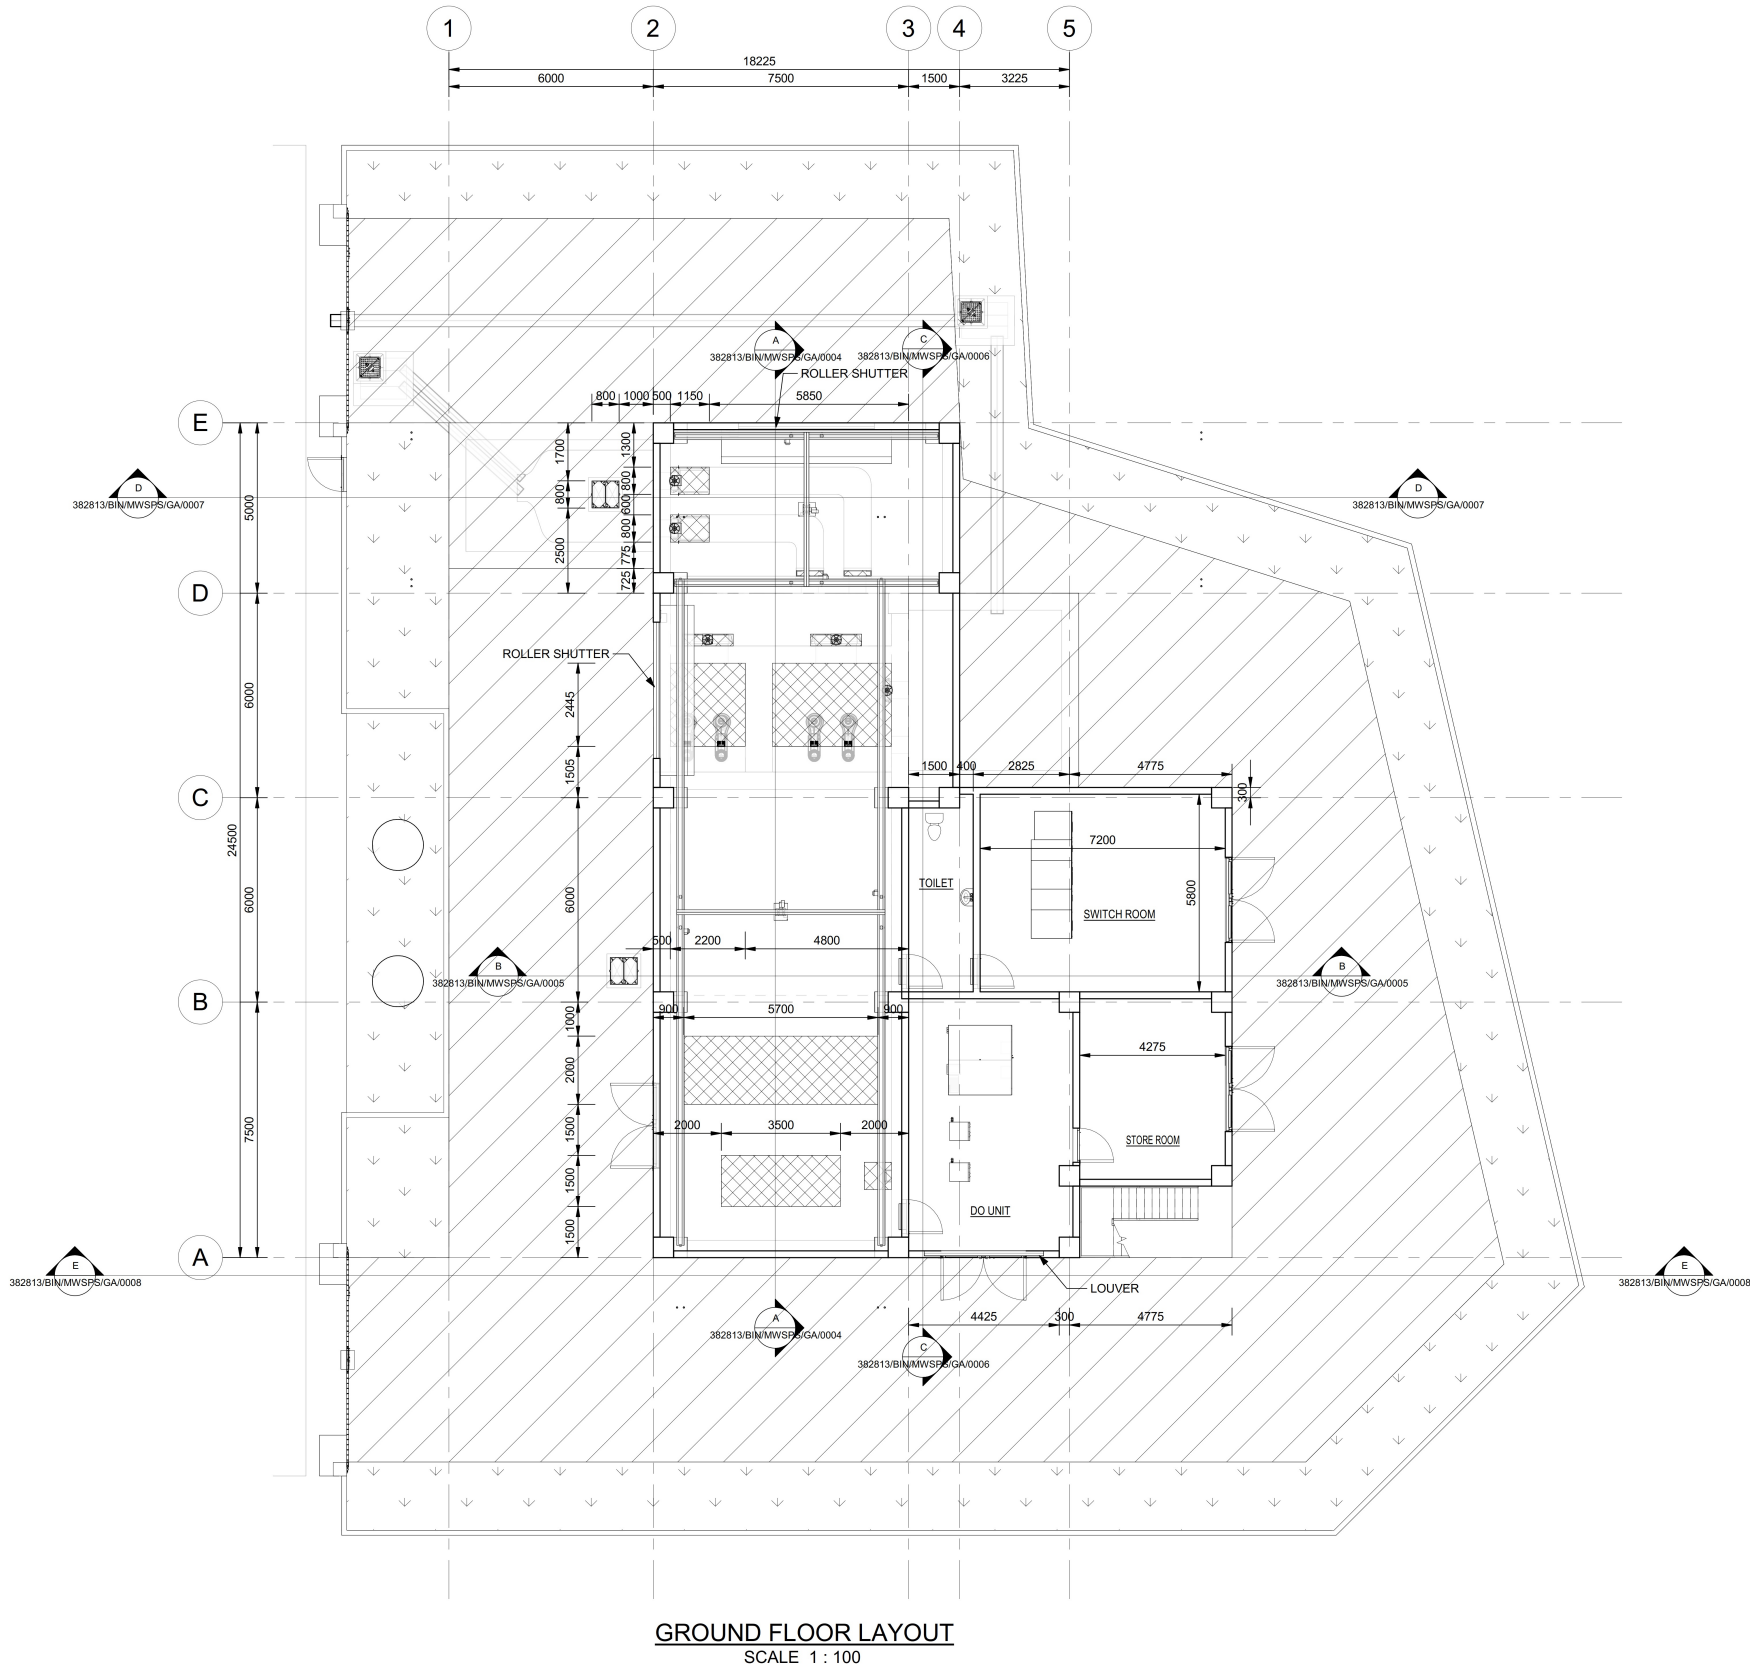

GROUND FLOOR LAYOUT  
SCALE 1 : 100

© Copyright by Binnies Hong Kong Limited

NOTE:

1. ALL DIMENSIONS ARE IN MILLIMETERS UNLESS OTHERWISE STATED.
2. ALL LEVEL ARE IN METERS ABOVE PRINCIPAL DATUM.

LEGEND:

- ACCESS ROAD
- LANDSCAPE AREA
- CLP TRANSFORMER POLES

0	-	-	-
Revision	Date	Description	Initial
	Designed	Checked	Drawn
Initial			SZ
Date			

Approved

Contract No. CE 50/2007 (DS)

Contract Title  
NORTH DISTRICT SEWERAGE STAGE 2 (REMINDER) AND SEWERAGE TO CHUEN LUNG, KAU WA KEUNG OLD VILLAGE AND LO WAI

Drawing Title  
MUK WU SEWAGE PUMPING STATION - GROUND FLOOR PLAN

Drawing No.	Revision
FIGURE 8	0

Scale 1:100

香港特別行政區政府渠務署  
THE GOVERNMENT OF THE HONG KONG  
SPECIAL ADMINISTRATIVE REGION  
DRAINAGE SERVICES DEPARTMENT

**binnies**  
BINNIES HONG KONG LIMITED  
賓尼斯工程顧問有限公司

參考編號  
REFERENCE No.


A/NE-MKT/19

繪圖 DRAWING A-3

( 來源 : 附件 1h )  
( Source : Appendix 1h )

Plot Date: 1/21/2022 5:08:26 PM

File Name: Y:\Daily Work\03 BIM model\Project\DS\382813\03-Model\382813-AR.rvt

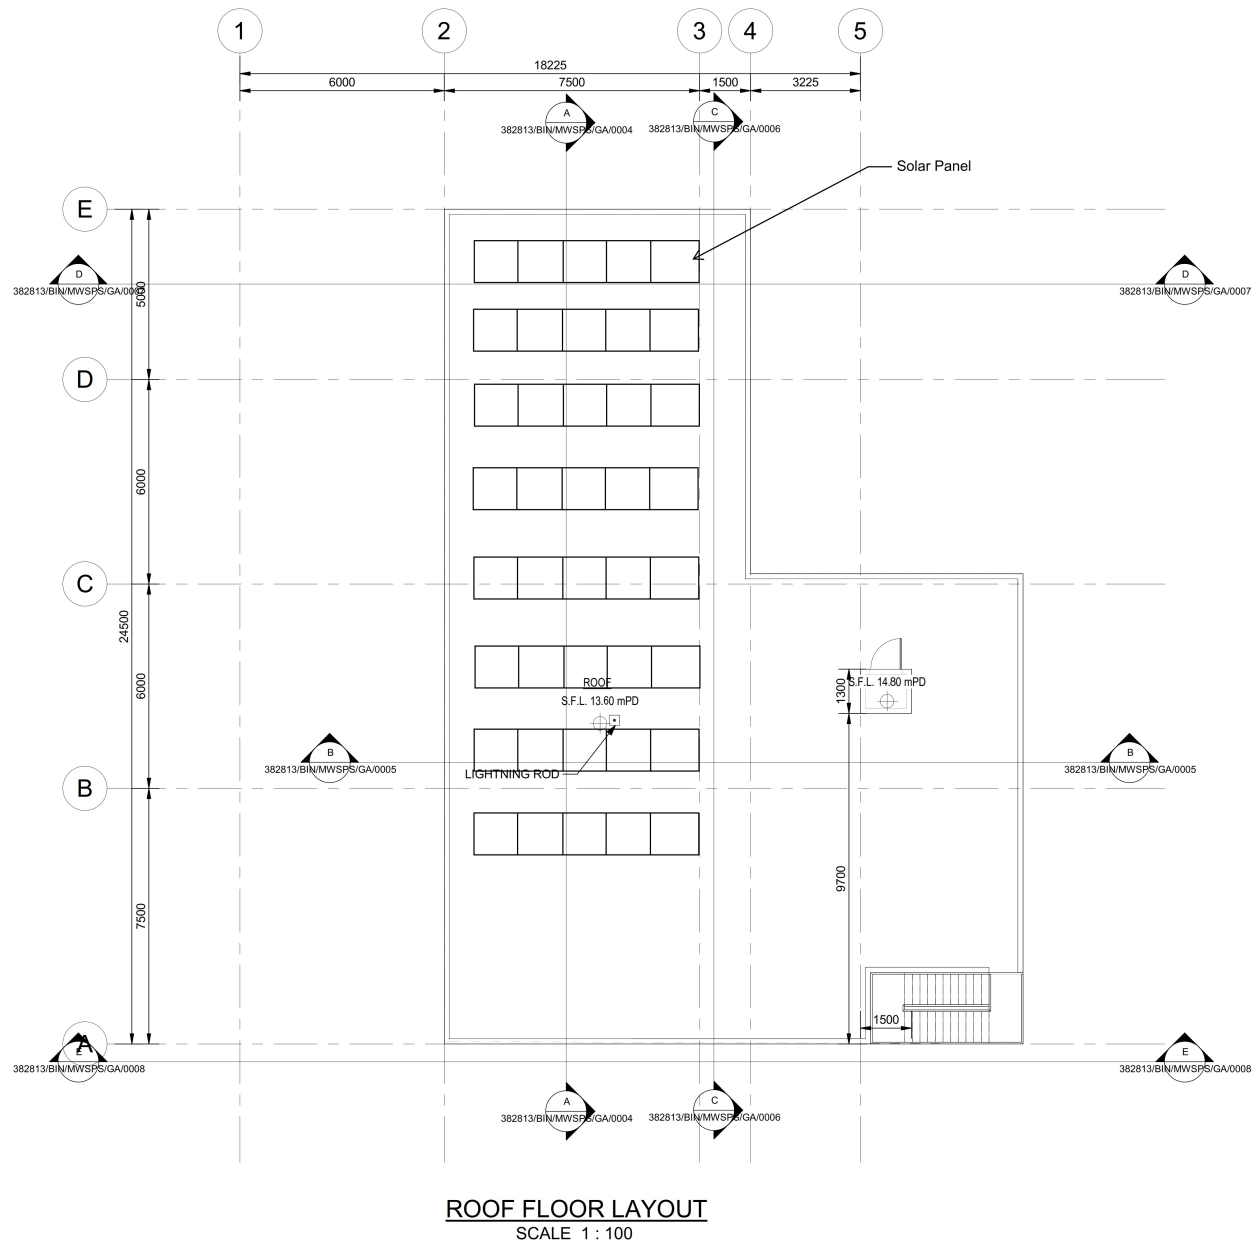

© Copyright by Binnies Hong Kong Limited

NOTE:

1. ALL DIMENSIONS ARE IN MILLIMETERS UNLESS OTHERWISE STATED.
2. ALL LEVEL ARE IN METERS ABOVE PRINCIPAL DATUM.

0	-	-	-
Revision	Date	Description	Initial
	Designed	Checked	Drawn
Initial			SZ
Date			

Approved

Contract No. CE 50/2007 (DS)

Contract Title  
NORTH DISTRICT SEWERAGE STAGE 2 (REMINDER) AND SEWERAGE TO CHUEN LUNG, KAU WA KEUNG OLD VILLAGE AND LO WAI

Drawing Title  
MUK WU SEWAGE PUMPING STATION - ROOF FLOOR PLAN

Drawing No.	Revision
FIGURE 9	0

Scale 1:100


香港特別行政區政府渠務署  
THE GOVERNMENT OF THE HONG KONG  
SPECIAL ADMINISTRATIVE REGION  
DRAINAGE SERVICES DEPARTMENT

**binnies**  
BINNIES HONG KONG LIMITED  
賓尼斯工程顧問有限公司

參考編號 REFERENCE No.	A/NE-MKT/19	繪圖 DRAWING A-4
( 來源 : 附件 1h ) ( Source : Appendix 1h )		

Plot Date: 1/21/2022 5:08:51 PM

File Name: Y:\Daily Work\03 BIM model\Project\DS\382813\03-Model\382813-AR.rvt

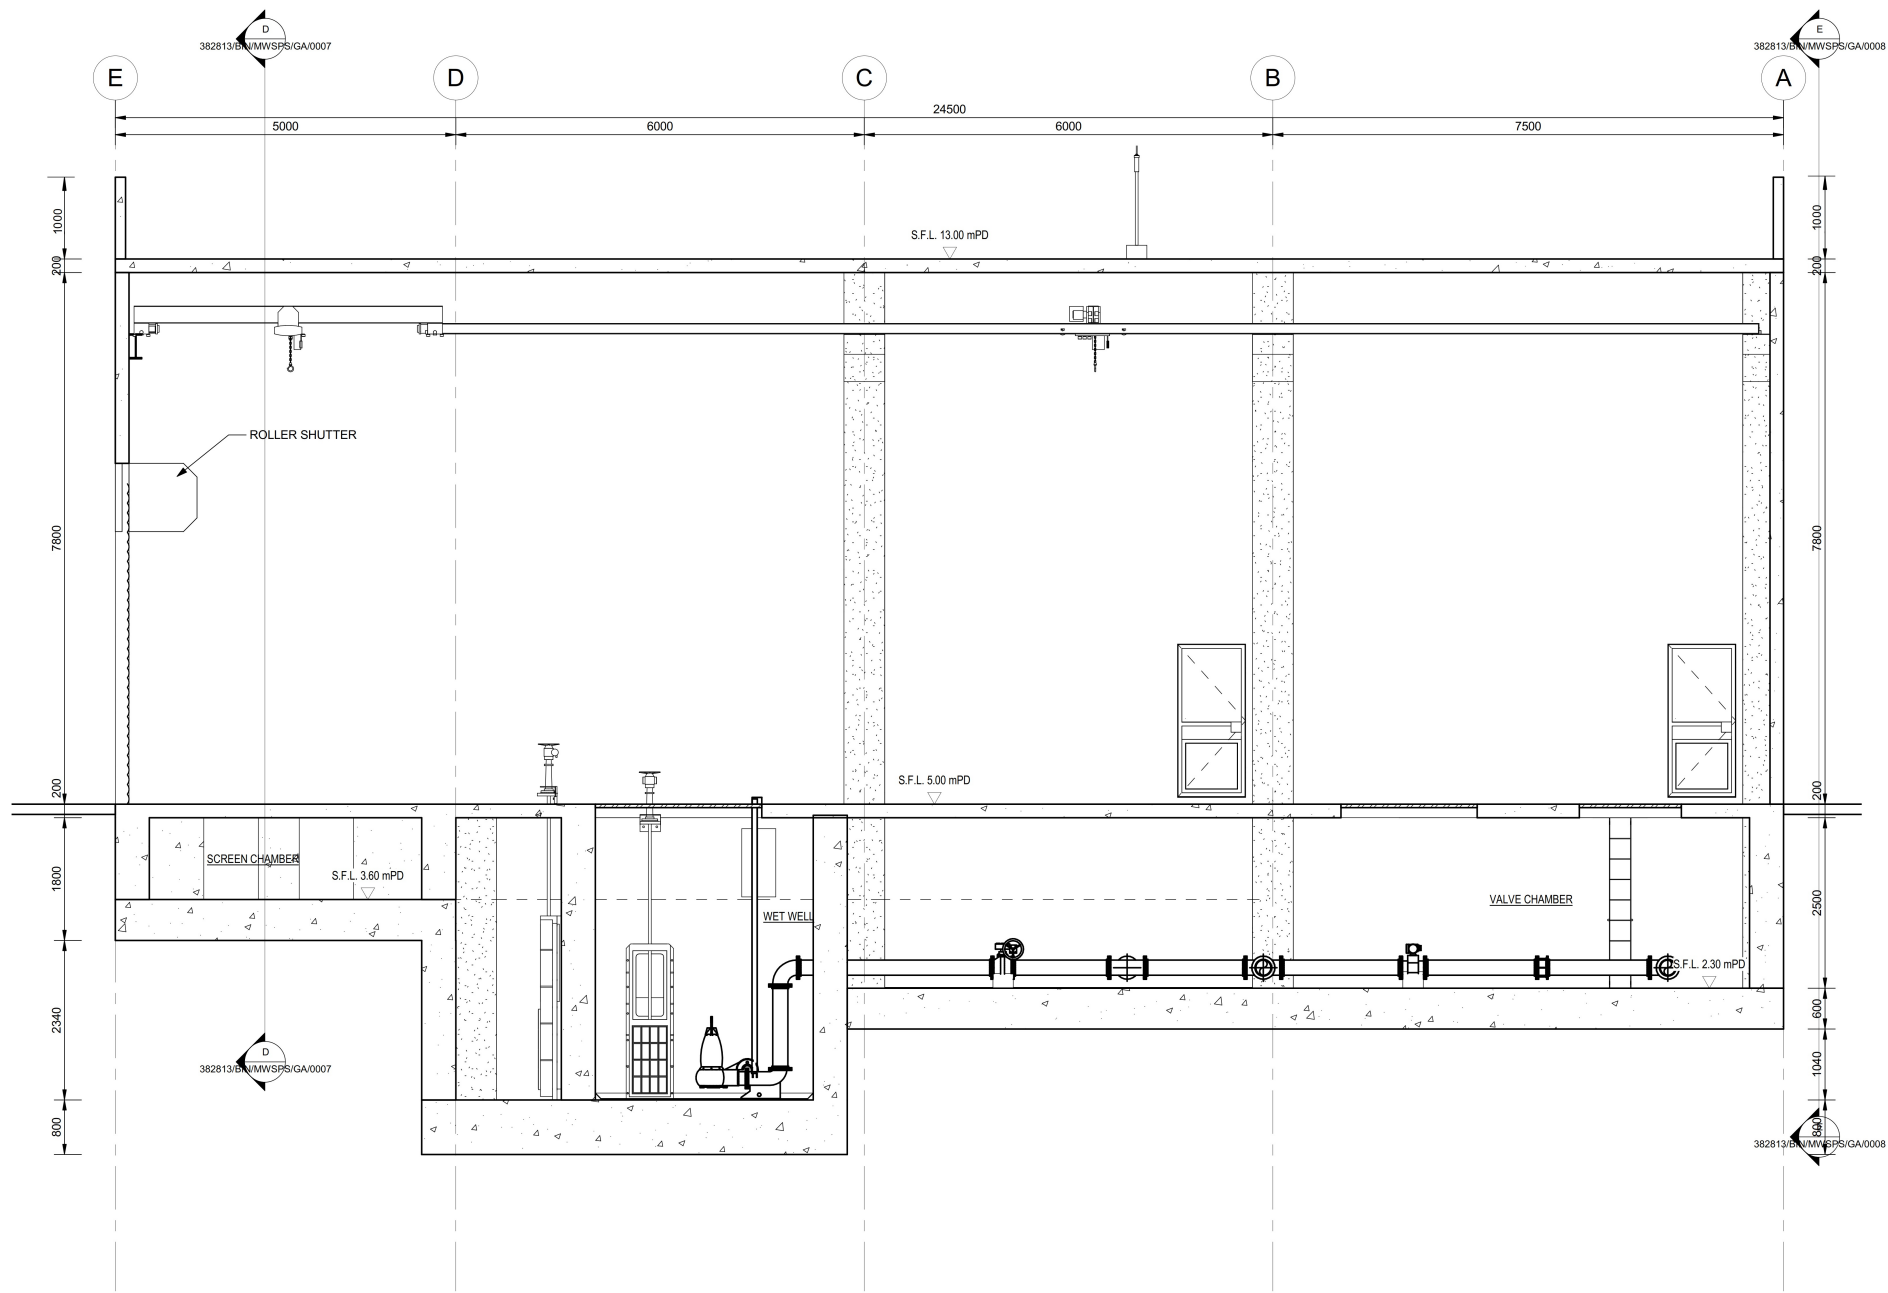

SECTION A-A  
SCALE 1 : 50

© Copyright by Binnies Hong Kong Limited

NOTE:

1. ALL DIMENSIONS ARE IN MILLIMETERS UNLESS OTHERWISE STATED.
2. ALL LEVEL ARE IN METERS ABOVE PRINCIPAL DATUM.

0	-	-	-
Revision	Date	Description	Initial
	Designed	Checked	Drawn
Initial			SZ
Date			

Approved

Contract No. CE 50/2007 (DS)

Contract Title  
NORTH DISTRICT SEWERAGE STAGE 2 (REMINDER) AND SEWERAGE TO CHUEN LUNG, KAU WA KEUNG OLD VILLAGE AND LO WAI

Drawing Title  
MUK WU SEWAGE PUMPING STATION - SECTION A-A

Drawing No.	Revision
FIGURE 10	0

Scale A/A as indicated

 香港特別行政區政府渠務署  
THE GOVERNMENT OF THE HONG KONG  
SPECIAL ADMINISTRATIVE REGION  
DRAINAGE SERVICES DEPARTMENT

 **binnies**  
BINNIES HONG KONG LIMITED  
賓尼斯工程顧問有限公司

參考編號  
REFERENCE No.

A/NE-MKT/19

繪圖 DRAWING A-5

( 來源 : 附件 1h )  
( Source : Appendix 1h )


COMPENSATED TREE PLANTING SCHEDULE (TREE)				
CODE	SCIENTIFIC NAME	HT. x SPD. (mm)	REMARKS	QUANTITY (NO.)
TC	TABEBUIA CHRYSANTHE	3500 x 2000	HEAVY STANDARD	7
LF	LIQUIDAMBAR FARMOSANA	3500 x 2000	HEAVY STANDARD	7
PR	PLUMERIA RUBRA	3500 x 2000	HEAVY STANDARD	7

PLANTING SCHEDULE (SHRUBS)		
CODE	SCIENTIFIC NAME	HT. x SPD. (mm)
REX	RHAPIS EXCELSA	400 x 400
LSI	LIGUSTRUM SINENSE	400 x 400

PLANTING SCHEDULE (GROUND COVER)	
CODE	SCIENTIFIC NAME
ADU	ARACHIS DURANENSIS
IKO	IMPERATA KOENIGII

© Copyright by Binnies Hong Kong Limited

- NOTES :
- PLEASE REFER TO DRAWING NO. 382813/BIN/AR/000 FOR NOTES, LEGENDS AND ABBREVIATIONS.
  - USE THIS DRAWING IN CONJUNCTION WITH ARCHITECTURAL DRAWINGS AND OTHER RELEVANT DOCUMENTS. IT IS CONTRACTOR'S DUTY TO VERIFY ALL DIMENSIONS BEFORE PROCEEDING. DO NOT SCALE DRAWINGS.
  - THIS IS A DESIGN INTENT DRAWINGS SET ILLUSTRATING THE APPEARANCE OF THE FINISHED WORK, SHOP DRAWINGS AND STRUCTURAL ELEMENTS ARE TO BE DESIGNED BY CONTRACTORS FOR OUR APPROVAL.
  - BUILDING REGULATIONS AND ORDINANCES, AND FIRE SERVICES REQUIREMENTS ARE TO BE COMPLIED WITH.
  - COLOR AND FINISH TEXTURE, AND ASSOCIATED MATERIAL QUALITY ARE TO BE SUBMITTED AS SAMPLES FOR DESIGNER'S APPROVAL.
  - DRAWING IS NOT VALID FOR CONSTRUCTION UNLESS EXPRESSLY CERTIFIED.

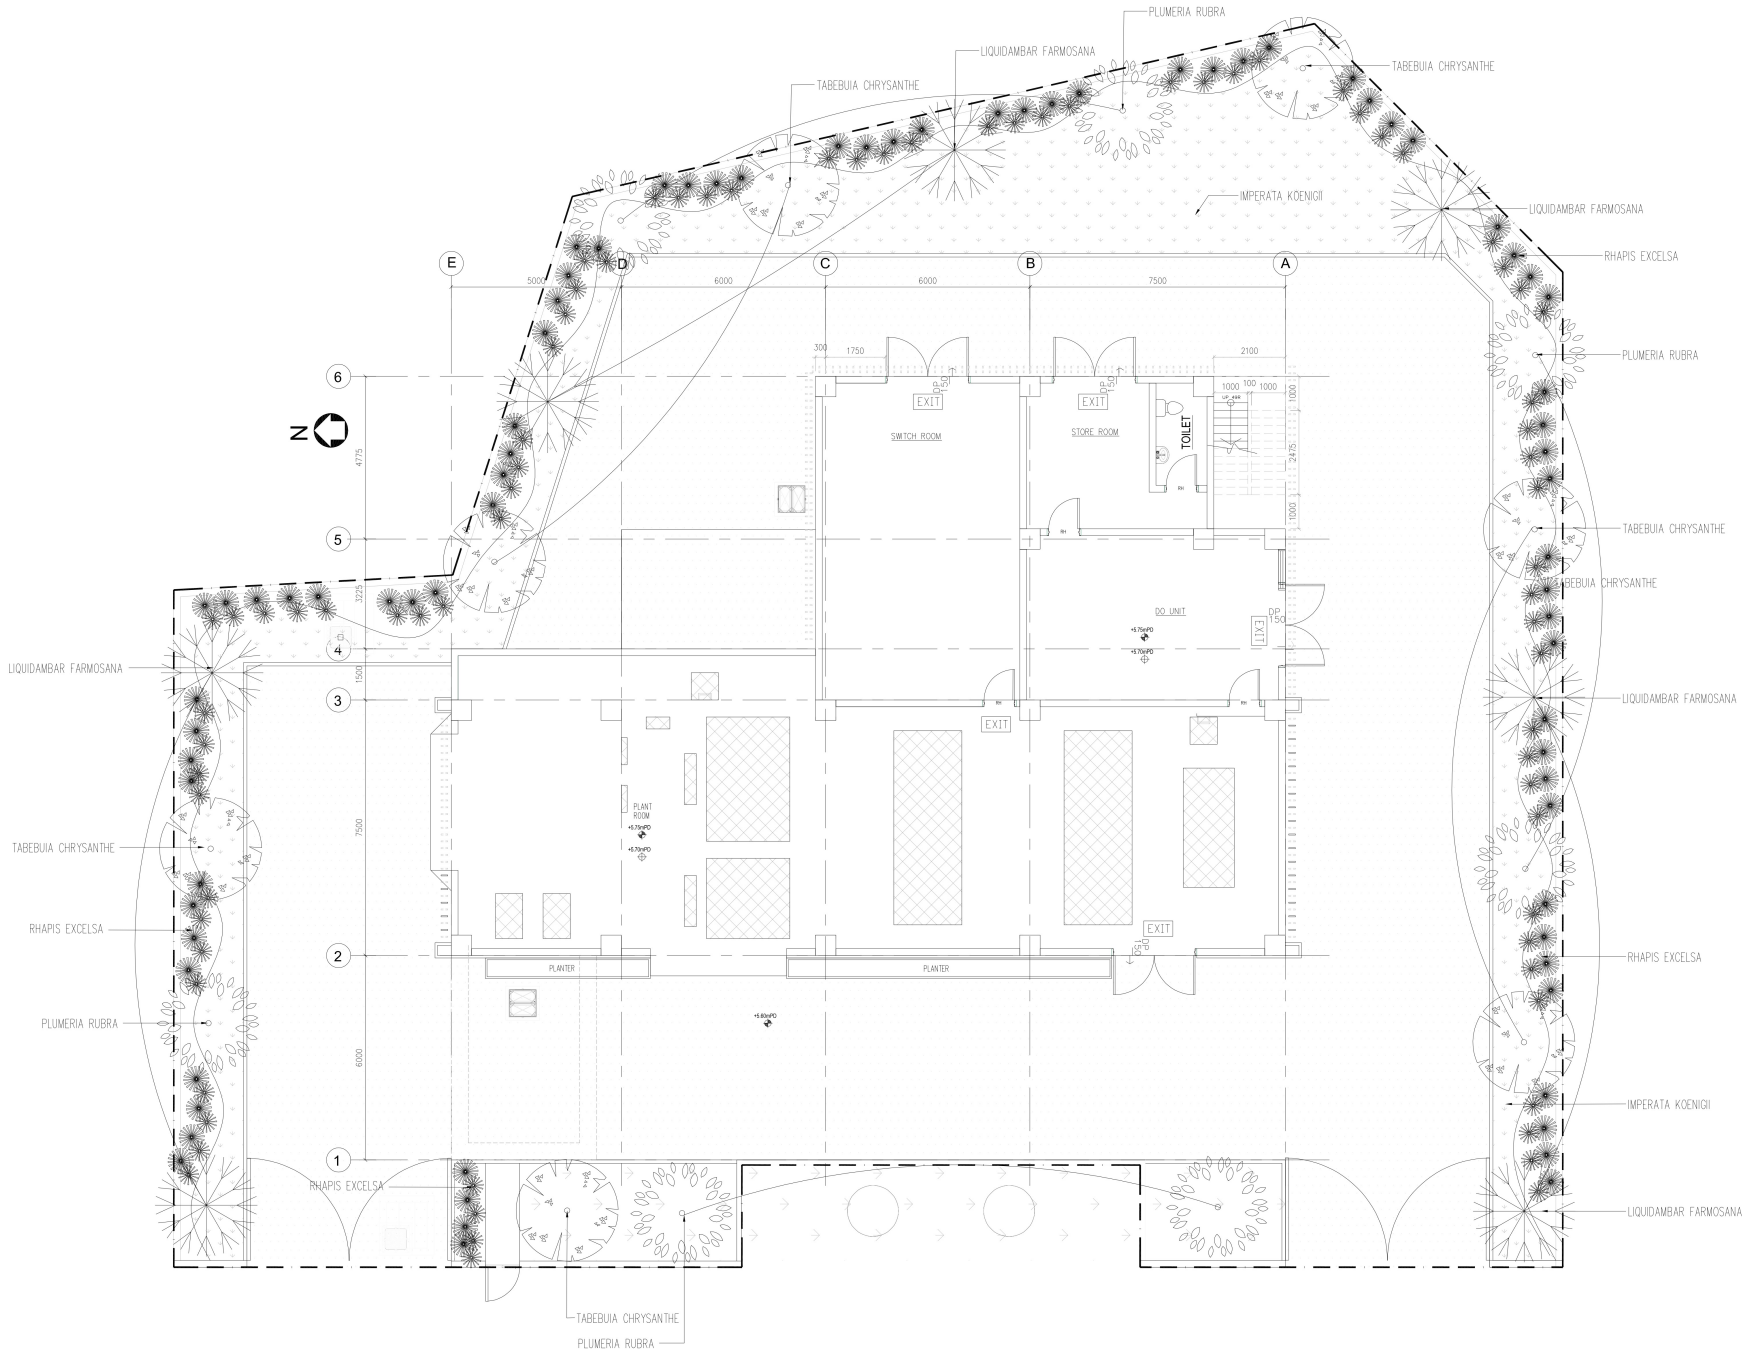

1 SITE LAYOUT PLAN  
scale 1:100 @ A1 1:200 @ A3

Revision	Date	Description	Initial
	Designed	Checked	Drawn
Initial			
Date			

Approved

Contract No. CE 50/2007 (DS)

Contract Title  
NORTH DISTICT SEWERAGE STAGE 2 (REMINDER) AND SEWERAGE TO CHUEN LUNG, KAU WA KEUNG OLD VILLAGE AND LO WAI

Drawing Title  
LADNSCAPE LAYOUT PLAN

Drawing No. FIGURE 13  
Revision —

Scale

香港特別行政區政府渠務署  
THE GOVERNMENT OF THE HONG KONG  
SPECIAL ADMINISTRATIVE REGION  
DRAINAGE SERVICES DEPARTMENT

binnies  
BINNIES HONG KONG LIMITED  
賓尼斯工程顧問有限公司

參考編號  
REFERENCE No.

A/NE-MKT/19

繪圖  
DRAWING A-6

( 來源 : 附件 1h )  
( Source : Appendix 1h )





1 NORTH WEST PERSPECTIVE VIEW  
N.T.S.



2 SOUTH WEST PERSPECTIVE VIEW  
N.T.S.

© Copyright by Binnies Hong Kong Limited

NOTES :

- PLEASE REFER TO DRAWING NO. 382813/BIN/MWASP/AR/000 FOR NOTES, LEGENDS AND ABBREVIATIONS.
- USE THIS DRAWING IN CONJUNCTION WITH ARCHITECTURAL DRAWINGS AND OTHER RELEVANT DOCUMENTS. IT IS CONTRACTOR'S DUTY TO VERIFY ALL DIMENSIONS BEFORE PROCEEDING. DRAWING NOT IN SCALE.
- THIS IS A DESIGN INTENT DRAWINGS SET ILLUSTRATING THE APPEARANCE OF THE FINISHED WORK. SHOP DRAWINGS AND STRUCTURAL ELEMENTS ARE TO BE DESIGNED BY CONTRACTORS FOR OUR APPROVAL.
- BUILDING REGULATIONS AND ORDINANCES, AND FIRE SERVICES REQUIREMENTS ARE TO BE COMPLIED WITH.
- COLOR AND FINISH TEXTURE, AND ASSOCIATED MATERIAL QUALITY ARE TO BE SUBMITTED AS SAMPLES FOR PROJECT MANAGER'S APPROVAL.
- DRAWING IS NOT VALID FOR CONSTRUCTION UNLESS EXPRESSLY CERTIFIED.

Revision	Date	Description			Initial
	Designed	Checked	Drawn	Checked	
Initial	KB	CC	KB	CC	
Date	04/22	04/22	04/22	04/22	

Approved

Contract no.

DC/2022/06

Contract title

VILLAGE SEWERAGE IN MUK WU, LO WAI, CHUEN LUNG AND KAU WA KENG OLD VILLAGE

Drawing title

MUK WU SEWAGE PUMPING STATION PERSPECTIVES 1

Drawing no.

FIGURE 14

Revision

-

Scale

A1 N.T.S.

香港特別行政區政府渠務署  
THE GOVERNMENT OF THE HONG KONG  
SPECIAL ADMINISTRATIVE REGION  
DRAINAGE SERVICES DEPARTMENT

BINNIES HONG KONG LIMITED  
賓尼斯工程顧問有限公司



- NOTES :
1. PLEASE REFER TO DRAWING NO. 382813/BIN/MWSP/AR/000 FOR NOTES, LEGENDS AND ABBREVIATIONS.
  2. USE THIS DRAWING IN CONJUNCTION WITH ARCHITECTURAL DRAWINGS AND OTHER RELEVANT DOCUMENTS. IT IS CONTRACTOR'S DUTY TO VERIFY ALL DIMENSIONS BEFORE PROCEEDING. DRAWING NOT IN SCALE.
  3. THIS IS A DESIGN INTENT DRAWINGS SET ILLUSTRATING THE APPEARANCE OF THE FINISHED WORK. SHOP DRAWINGS AND STRUCTURAL ELEMENTS ARE TO BE DESIGNED BY CONTRACTORS FOR OUR APPROVAL.
  4. BUILDING REGULATIONS AND ORDINANCES, AND FIRE SERVICES REQUIREMENTS ARE TO BE COMPLIED WITH.
  5. COLOR AND FINISH TEXTURE, AND ASSOCIATED MATERIAL QUALITY ARE TO BE SUBMITTED AS SAMPLES FOR PROJECT MANAGER'S APPROVAL.
  6. DRAWING IS NOT VALID FOR CONSTRUCTION UNLESS EXPRESSLY CERTIFIED.

Revision	Date	Description			Initial
	Designed	Checked	Drawn	Checked	
Initial	KB	CC	KB	CC	
Date	04/22	04/22	04/22	04/22	

Approved

*CC*

Contract no.

DC/2022/06

Contract title

VILLAGE SEWERAGE IN MUK WU, LO WAI, CHUEN LUNG AND KAU WA KENG OLD VILLAGE

Drawing title

MUK WU SEWAGE PUMPING STATION PERSPECTIVES 2

Drawing no.

FIGURE 15

Revision

-

Scale


A1 N.T.S.

 香港特別行政區政府渠務署  
THE GOVERNMENT OF THE HONG KONG  
SPECIAL ADMINISTRATIVE REGION  
DRAINAGE SERVICES DEPARTMENT

 **binnies**  
BINNIES HONG KONG LIMITED  
賓尼斯工程顧問有限公司



1 SOUTH EAST PERSPECTIVE VIEW  
N.T.S.

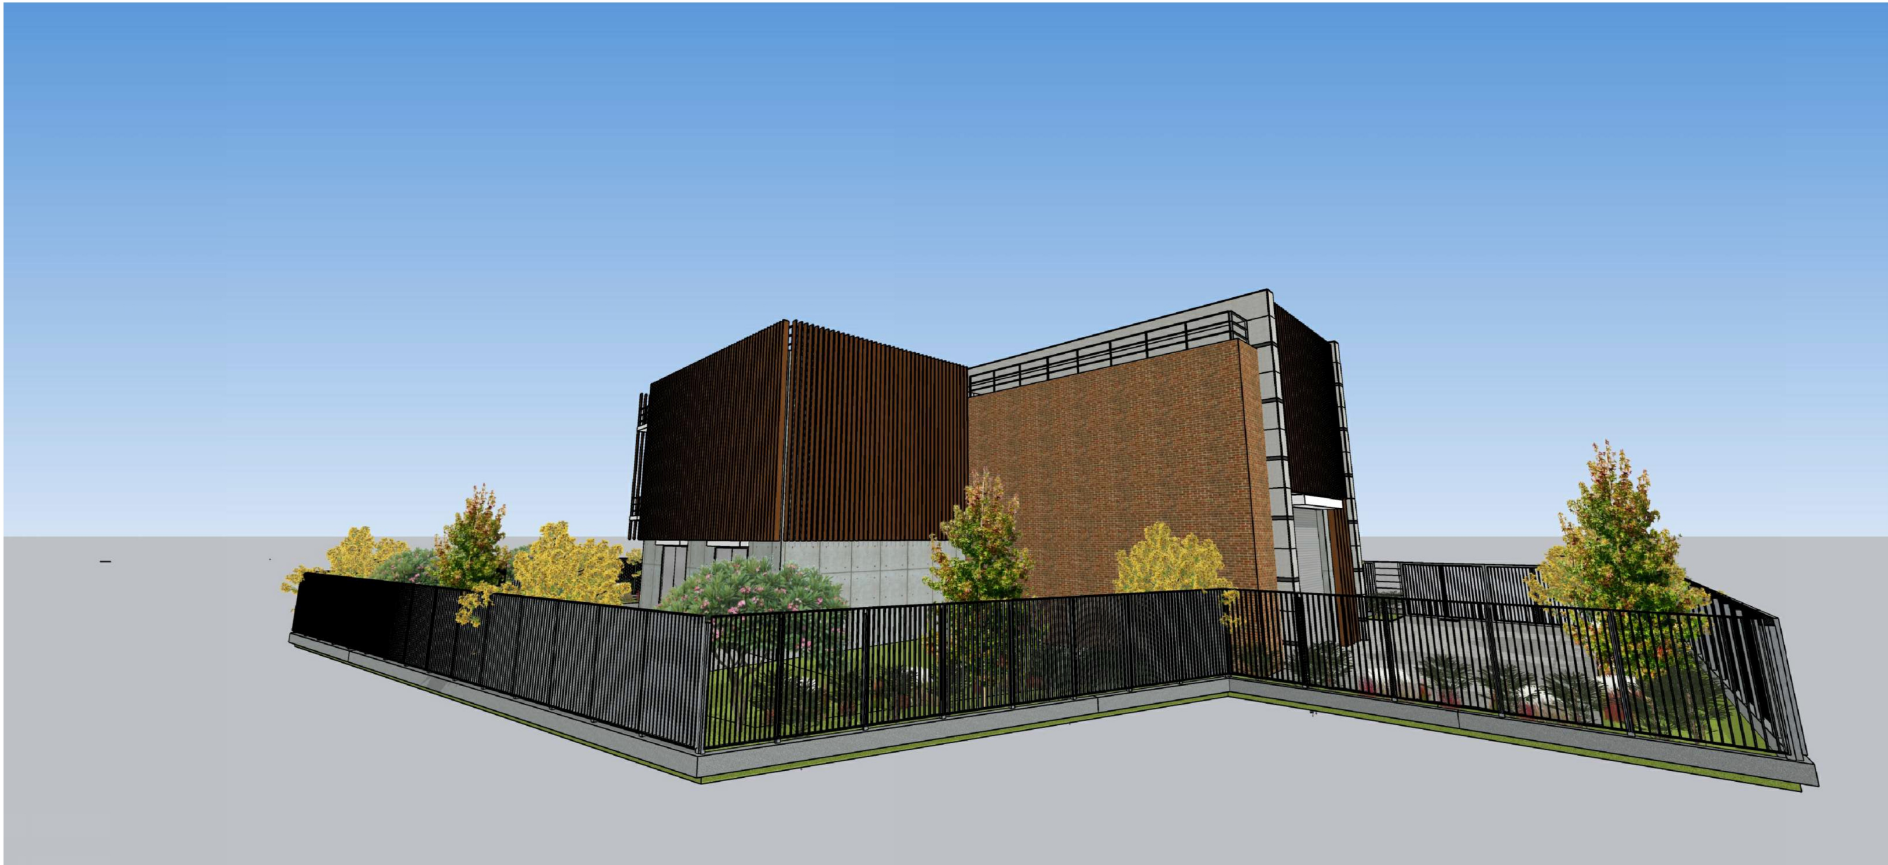

2 NORTH EAST PERSPECTIVE VIEW  
N.T.S.

參考編號  
REFERENCE No.

A/NE-MKT/19

繪圖 DRAWING A-8

( 來源 : 附件 1h )  
( Source : Appendix 1h )



- NOTES :
- PLEASE REFER TO DRAWING NO. 382813/BIN/MWASP/AR/000 FOR NOTES, LEGENDS AND ABBREVIATIONS.
  - USE THIS DRAWING IN CONJUNCTION WITH ARCHITECTURAL DRAWINGS AND OTHER RELEVANT DOCUMENTS. IT IS CONTRACTOR'S DUTY TO VERIFY ALL DIMENSIONS BEFORE PROCEEDING. DRAWING NOT IN SCALE.
  - THIS IS A DESIGN INTENT DRAWINGS SET ILLUSTRATING THE APPEARANCE OF THE FINISHED WORK. SHOP DRAWINGS AND STRUCTURAL ELEMENTS ARE TO BE DESIGNED BY CONTRACTORS FOR OUR APPROVAL.
  - BUILDING REGULATIONS AND ORDINANCES, AND FIRE SERVICES REQUIREMENTS ARE TO BE COMPLIED WITH.
  - COLOR AND FINISH TEXTURE, AND ASSOCIATED MATERIAL QUALITY ARE TO BE SUBMITTED AS SAMPLES FOR PROJECT MANAGER'S APPROVAL.
  - DRAWING IS NOT VALID FOR CONSTRUCTION UNLESS EXPRESSLY CERTIFIED.

Revision	Date		Description			Initial
	Designed	Checked	Drawn	Checked		
Initial	KB	CC	KB	CC		
Date	04/22	04/22	04/22	04/22		

Approved



Contract no. DC/2022/06

Contract title

VILLAGE SEWERAGE IN MUK WU, LO WAI, CHUEN LUNG AND KAU WA KENG OLD VILLAGE

Drawing title

MUK WU SEWAGE PUMPING STATION PERSPECTIVES 3

Drawing no.	Revision
FIGURE 16	-


Scale A1 N.T.S.

 香港特別行政區政府渠務署  
THE GOVERNMENT OF THE HONG KONG  
SPECIAL ADMINISTRATIVE REGION  
DRAINAGE SERVICES DEPARTMENT

 binnies  
BINNIES HONG KONG LIMITED  
賓尼斯工程顧問有限公司



1 NORTH WEST AERIAL VIEW  
N.T.S.

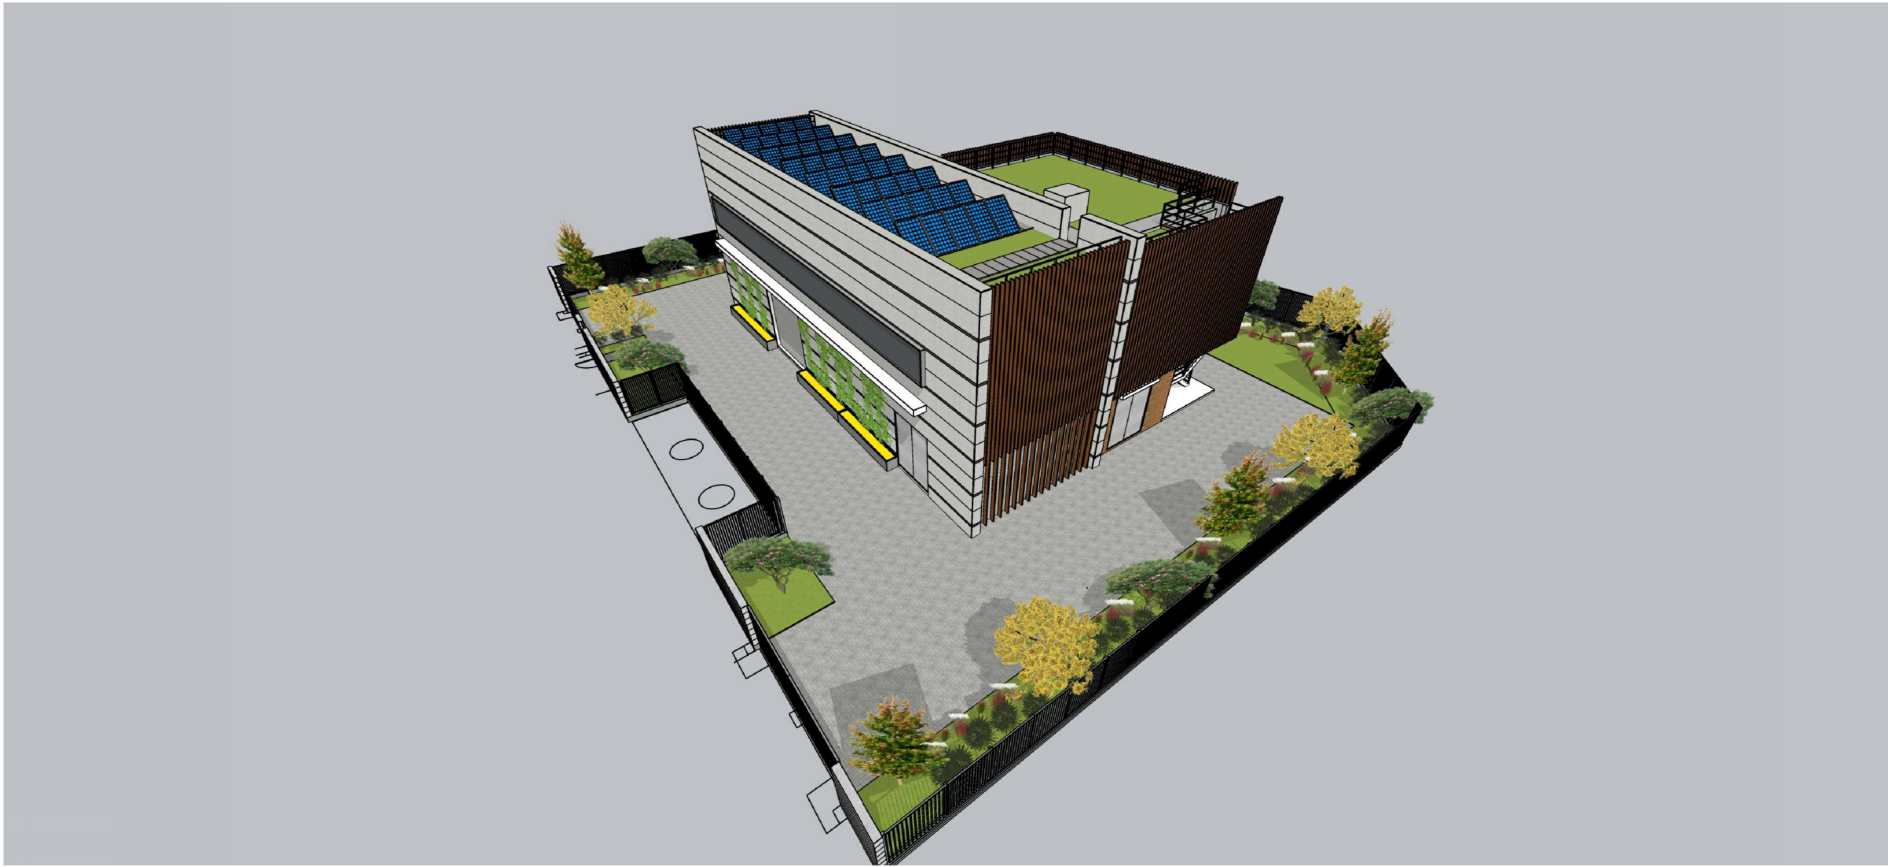

2 SOUTH WEST AERIAL VIEW  
N.T.S.



- NOTES :
1. PLEASE REFER TO DRAWING NO. 382813/BIN/MWSP/AR/000 FOR NOTES, LEGENDS AND ABBREVIATIONS.
  2. USE THIS DRAWING IN CONJUNCTION WITH ARCHITECTURAL DRAWINGS AND OTHER RELEVANT DOCUMENTS. IT IS CONTRACTOR'S DUTY TO VERIFY ALL DIMENSIONS BEFORE PROCEEDING. DRAWING NOT IN SCALE.
  3. THIS IS A DESIGN INTENT DRAWINGS SET ILLUSTRATING THE APPEARANCE OF THE FINISHED WORK. SHOP DRAWINGS AND STRUCTURAL ELEMENTS ARE TO BE DESIGNED BY CONTRACTORS FOR OUR APPROVAL.
  4. BUILDING REGULATIONS AND ORDINANCES, AND FIRE SERVICES REQUIREMENTS ARE TO BE COMPLIED WITH.
  5. COLOR AND FINISH TEXTURE, AND ASSOCIATED MATERIAL QUALITY ARE TO BE SUBMITTED AS SAMPLES FOR PROJECT MANAGER'S APPROVAL.
  6. DRAWING IS NOT VALID FOR CONSTRUCTION UNLESS EXPRESSLY CERTIFIED.

Revision	Date	Description			Initial
	Designed	Checked	Drawn	Checked	
Initial	KB	CC	KB	CC	
Date	04/22	04/22	04/22	04/22	

Approved

*Cu Cu*

Contract no.

DC/2022/06

Contract title

VILLAGE SEWERAGE IN MUK WU, LO WAI, CHUEN LUNG AND KAU WA KENG OLD VILLAGE

Drawing title

MUK WU SEWAGE PUMPING STATION PERSPECTIVES 4


Drawing no.	Revision
FIGURE 17	-

Scale

A1 N.T.S.


 香港特別行政區政府渠務署  
THE GOVERNMENT OF THE HONG KONG  
SPECIAL ADMINISTRATIVE REGION  
DRAINAGE SERVICES DEPARTMENT

 binnies  
BINNIES HONG KONG LIMITED  
賓尼斯工程顧問有限公司

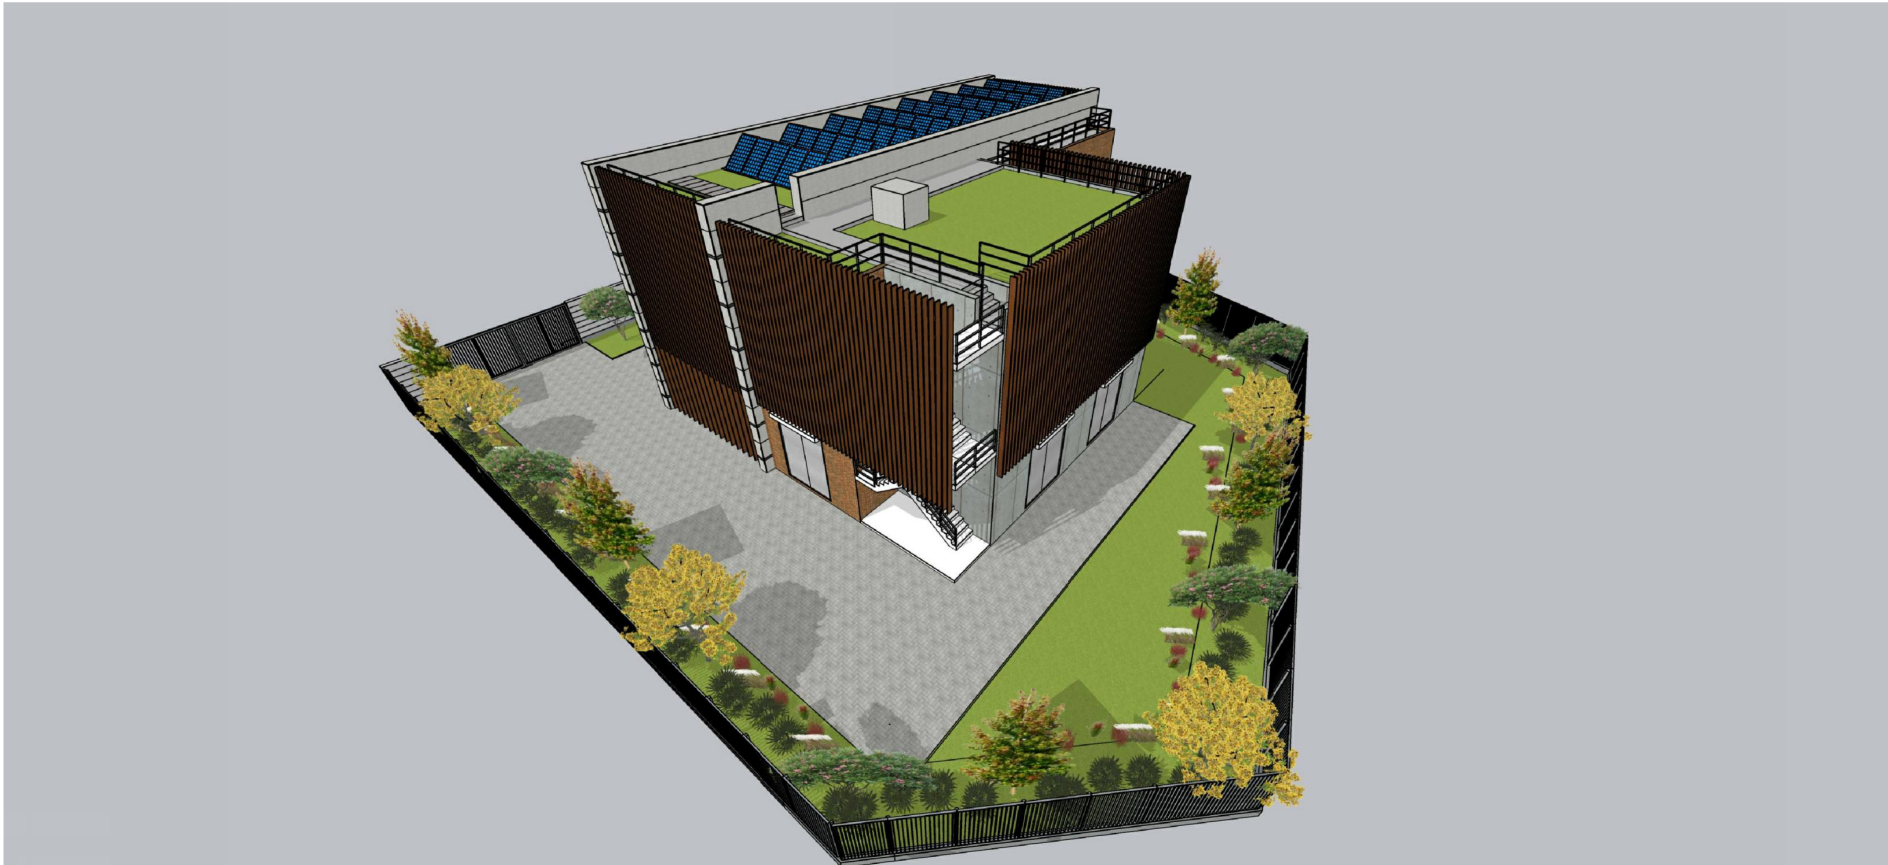

1 SOUT EAST AERIAL VIEW

N.T.S.

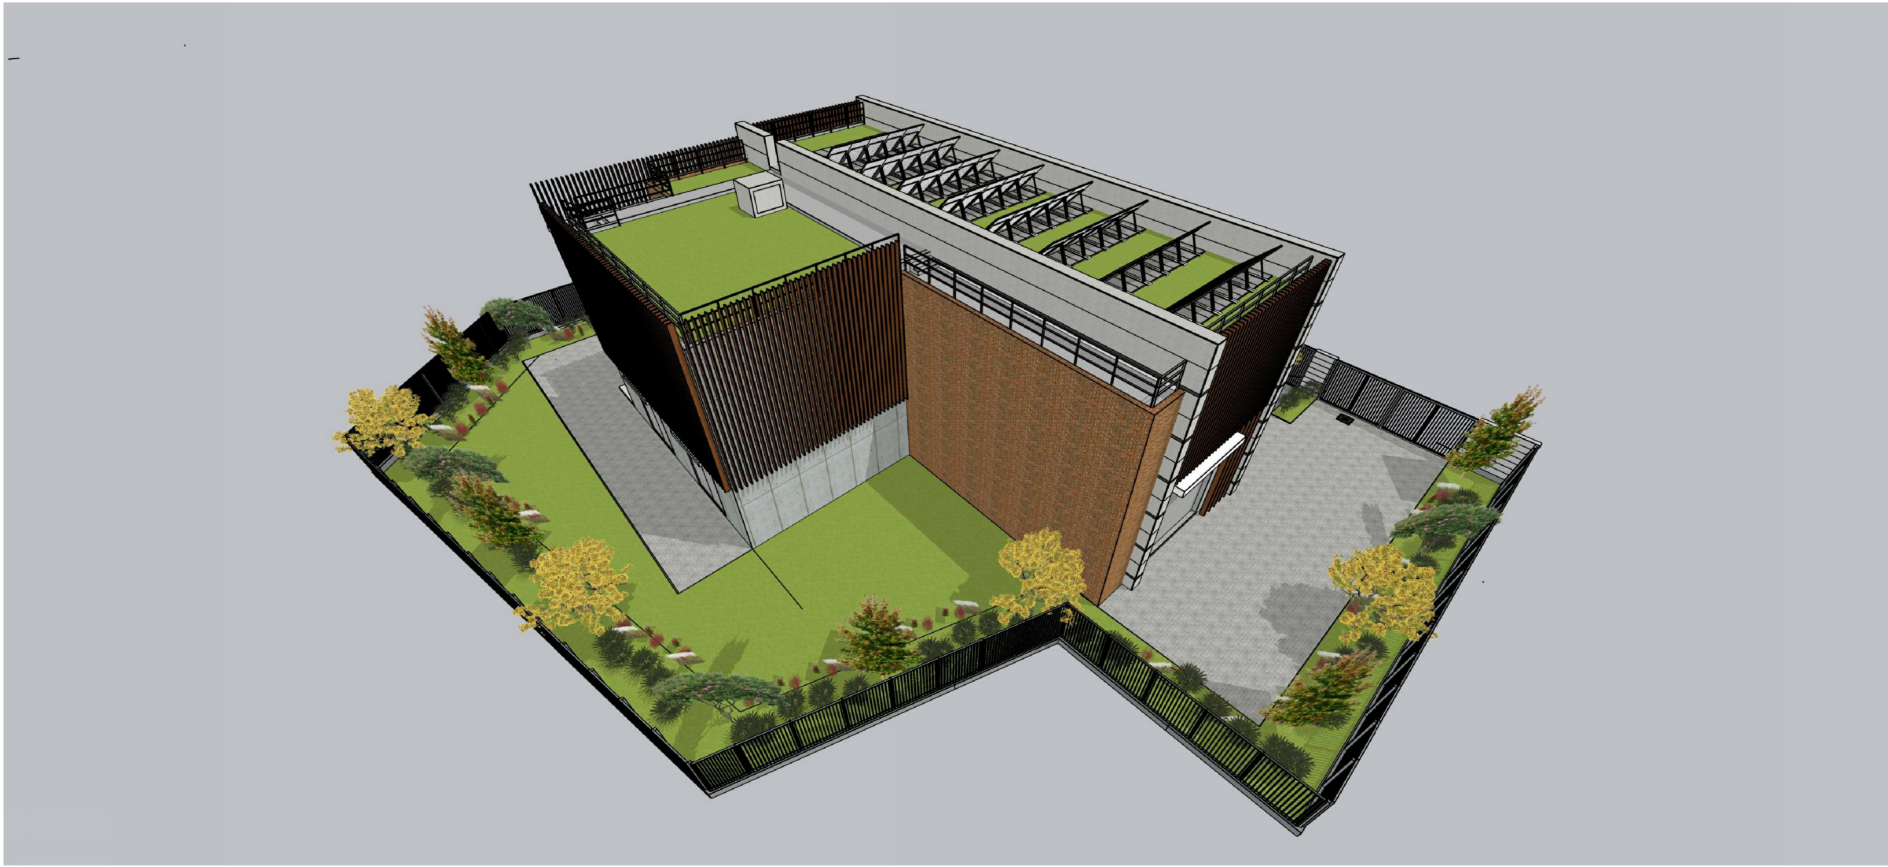


2 NORTH EAST AERIAL VIEW

N.T.S.



### 要覽圖 KEY PLAN

SCALE 1:50,000 比例尺

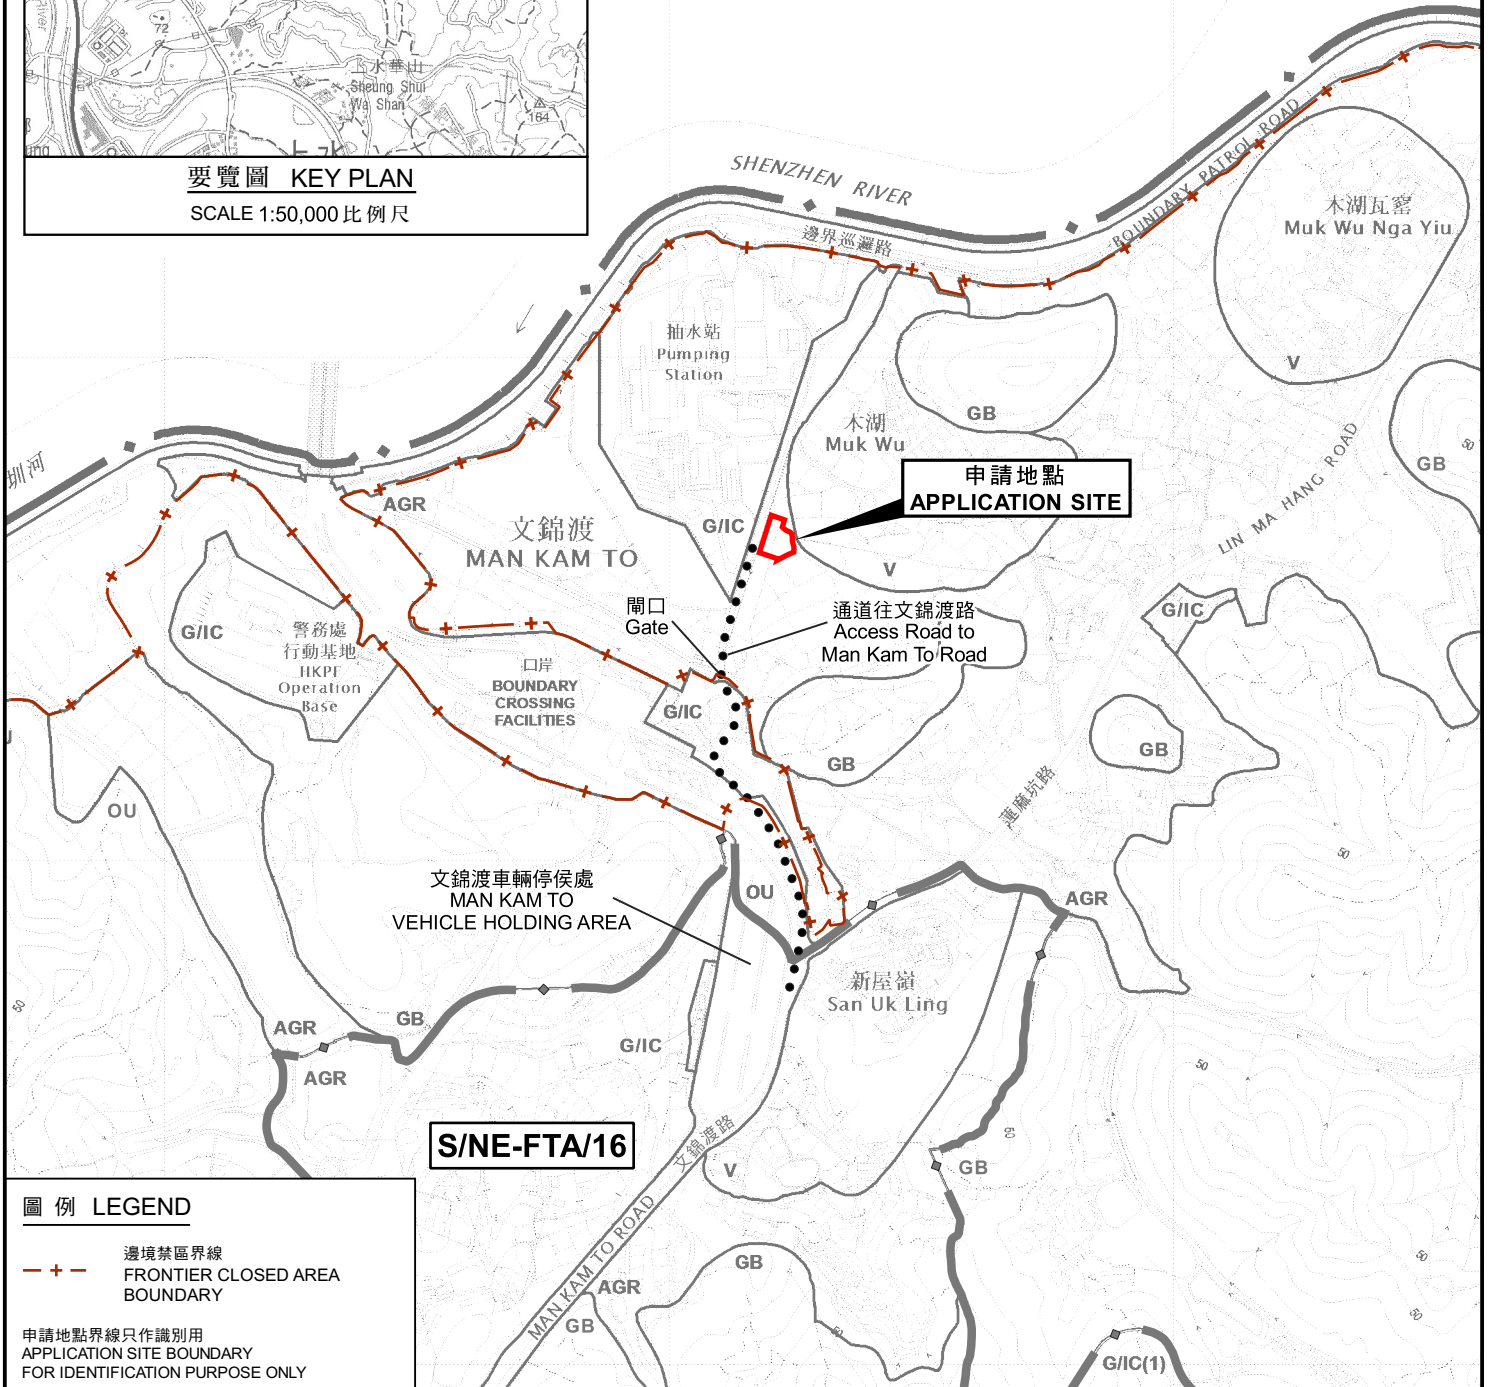

### 圖例 LEGEND

— + — 邊境禁區界線  
FRONTIER CLOSED AREA  
BOUNDARY

申請地點界線只作識別用  
APPLICATION SITE BOUNDARY  
FOR IDENTIFICATION PURPOSE ONLY

### 位置圖 LOCATION PLAN

擬議公用事業設施裝置 (污水泵房)  
PROPOSED PUBLIC UTILITY INSTALLATION  
(SEWAGE PUMPING STATION)  
新界文錦渡丈量約份第90約政府土地及毗連地段第79號餘段  
GOVERNMENT LAND AND ADJOINING LOT 79 RP IN D.D. 90,  
MAN KAM TO, N.T.  
SCALE 1:7 500 比例尺

米 100 0 100 200 300 米  
METRES

規劃署  
PLANNING  
DEPARTMENT




參考編號  
REFERENCE No.  
A/NE-MKT/19

圖 PLAN  
A-1

本摘要圖於2022年6月2日擬備，  
所根據的資料為：  
於2017年12月5日核准的  
分區計劃大綱圖編號S/NE-FTA/16及  
於2017年12月5日核准的  
分區計劃大綱圖編號S/NE-MKT/4  
EXTRACT PLAN PREPARED ON 2.6.2022  
BASED ON OUTLINE ZONING PLANS No.  
S/NE-FTA/16 APPROVED ON 5.12.2017 AND  
S/NE-MKT/4 APPROVED ON 5.12.2017



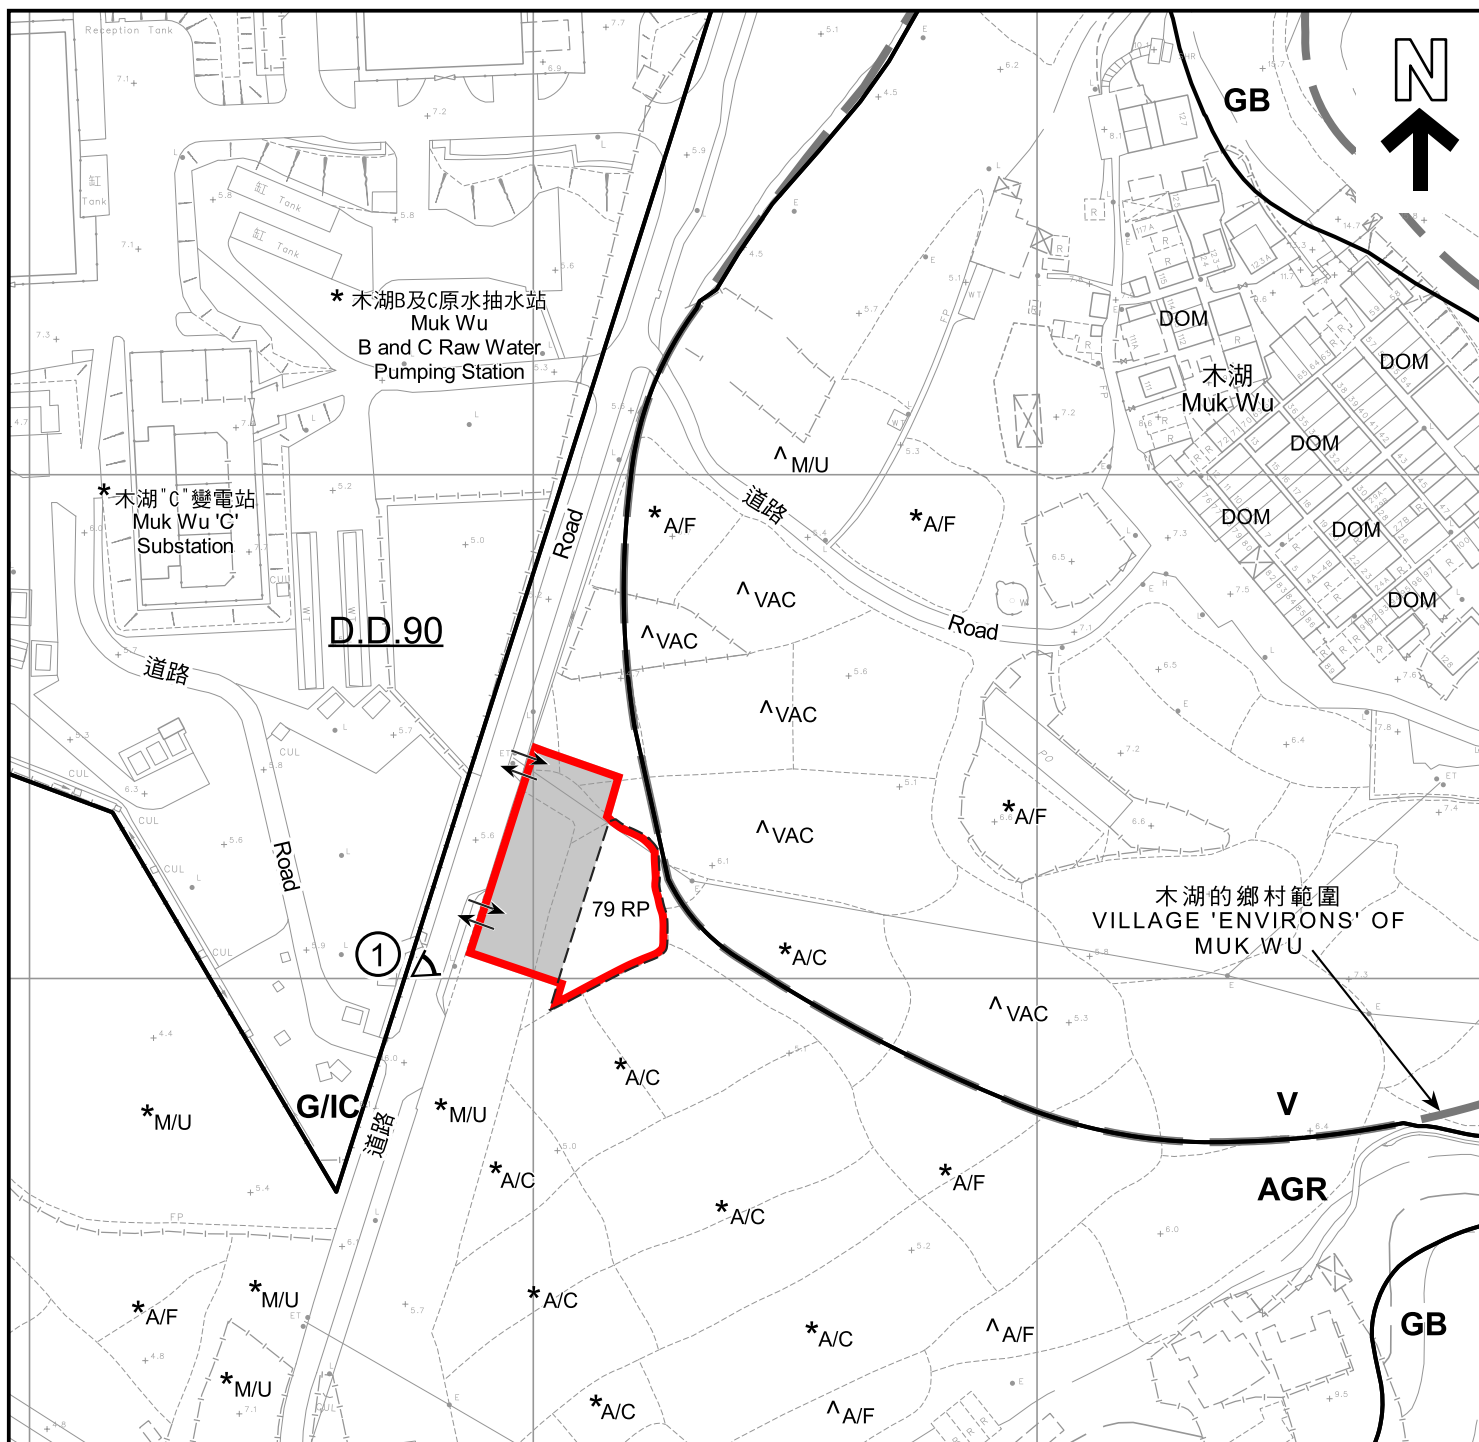

#### 圖例 LEGEND

- 申請地點 (界線只作識別用)  
APPLICATION SITE (BOUNDARY FOR IDENTIFICATION PURPOSE ONLY)
- 政府土地  
GOVERNMENT LAND
- AGR** 農業  
AGRICULTURE
- GB** 綠化地帶  
GREEN BELT
- G/IC** 政府、機構或社區  
GOVERNMENT, INSTITUTION OR COMMUNITY
- V** 鄉村式發展  
VILLAGE TYPE DEVELOPMENT

- A/C** 常耕農地  
CULTIVATED AGRICULTURAL LAND
- A/F** 休耕農地  
FALLOW AGRICULTURAL LAND
- DOM** 住用構築物  
DOMESTIC STRUCTURE
- M/U** 荒地  
UNUSED LAND
- VAC** 空置  
VACANT
- $\Rightarrow$  入口/出口  
INGRESS / EGRESS
- ①**  $\triangleleft$  實地照片的觀景點  
VIEWING POINT OF SITE PHOTO

#### 註釋 Notes:

- 2022年4月22日勘測的土地用途  
Land uses shown on this plan are in accordance with the land use survey conducted by the Planning Department on 22.4.2022
- \* 土地用途跟2010年7月30日及8月1日勘測的土地用途一致  
Indicates that the use is the same as that revealed by the land use survey conducted by the Planning Department on 30.7.2010 & 1.8.2010
- ^ 土地用途跟2010年7月30日及8月1日勘測的土地用途有別  
Indicates that the use is different from that revealed by the land use survey conducted by the Planning Department on 30.7.2010 & 1.8.2010

#### 平面圖 SITE PLAN

擬議公用事業設施裝置 (污水泵房)  
PROPOSED PUBLIC UTILITY INSTALLATION  
(SEWAGE PUMPING STATION)  
GOVERNMENT LAND AND ADJOINING LOT 79 RP IN D.D. 90,  
MAN KAM TO, N.T.

SCALE 1:1 500 比例尺  
米 METRES 25 0 25 50 米 METRES

規劃署  
PLANNING  
DEPARTMENT



參考編號  
REFERENCE No.  
A/NE-MKT/19

圖 PLAN  
A-2

本摘要圖於2022年6月1日擬備，  
所根據的資料為測量圖編號  
3-NW-11D、12C、16B及17A  
EXTRACT PLAN PREPARED ON 1.6.2022  
BASED ON SURVEY SHEETS No.  
3-NW-11D, 12C, 16B & 17A





木湖B及C原水抽水站  
Muk Wu  
B and C Raw Water  
Pumping Station

道路 Road

道路 Road

道路 Road

道路 Road

道路 Road

道路 Road

道路 Road

木湖  
Muk Wu

#### 圖例 LEGEND

 申請地點（界線只作識別用）  
APPLICATION SITE (BOUNDARY FOR  
IDENTIFICATION PURPOSE ONLY)

本摘要圖於2022年6月1日擬備，  
所根據的資料為地政總署於2021年11月26日  
拍得的航攝照片編號E141298C\_R  
EXTRACT PLAN PREPARED ON 1.6.2022  
BASED ON AERIAL PHOTO No. E141298C\_R  
TAKEN ON 26.11.2021

#### 航攝照片 AERIAL PHOTO

擬議公用事業設施裝置（污水泵房）  
新界文錦渡丈量約份第90約政府土地及毗連地段第79號餘段  
PROPOSED PUBLIC UTILITY INSTALLATION  
(SEWAGE PUMPING STATION)  
GOVERNMENT LAND AND ADJOINING LOT 79 RP IN D.D. 90,  
MAN KAM TO, N.T.

規劃署  
PLANNING  
DEPARTMENT



參考編號  
REFERENCE No.  
A/NE-MKT/19

圖 PLAN  
A-3





<p>本圖於2022年6月1日擬備， 所根據的資料為攝於2022年4月22日 的實地照片 PLAN PREPARED ON 1.6.2022 BASED ON SITE PHOTO TAKEN ON 22.4.2022</p>	<p><b>實地照片 SITE PHOTO</b> 擬議公用事業設施裝置（污水泵房） 新界文錦渡丈量約份第90約政府土地及毗連地段第79號餘段 PROPOSED PUBLIC UTILITY INSTALLATION (SEWAGE PUMPING STATION) GOVERNMENT LAND AND ADJOINING LOT 79 RP IN D.D. 90, MAN KAM TO, N.T.</p>	<p><b>規劃署 PLANNING DEPARTMENT</b></p> <p>參考編號 REFERENCE No. <b>A/NE-MKT/19</b></p>	<p> <b>圖 PLAN A-4</b></p>
---	--	--	--