

List of Approval Conditions

Application No. A/K9/260

- Application Site : Kowloon Inland Lot No. 11205, Junction of Hung Luen Road and Wa Shun Street, Hung Hom, Kowloon
- Subject of Application : Proposed Hotel with Eating Place/Shop and Services, and Public Transport Interchange in "Comprehensive Development Area (1)" Zone ("CDA(1)")
- Date of Approval : 13.12.2013
- Approval Conditions :
- (a) the submission and implementation of a revised Master Layout Plan (MLP), taking into account the approval conditions (f) to (j) below to the satisfaction of the Director of Planning or of the Town Planning Board ;
 - (b) the gross floor area for eating place and shop and services should be not less than 5,708m² as proposed by the applicant;
 - (c) the proposed development is subject to the maximum building heights as proposed in the building height profile in the MLP;
 - (d) the podium decks at 11.75mPD, 12.3mPD and 16.5mPD should be open to the public, as proposed by the applicant, at reasonable hours;
 - (e) the submission of a revised Air Ventilation Assessment to the satisfaction of the Director of Planning or of the Town Planning Board;
 - (f) the submission and implementation of a revised Landscape Master Plan to the satisfaction of the Director of Planning or of the Town Planning Board;
 - (g) the submission and implementation of the design of the 24-hour pedestrian walkway between the public promenade and the proposed development as well as the pedestrian connection between the adjoining "CDA(2)" site and the proposed development to the satisfaction of the Director of Planning or of the Town Planning Board;
 - (h) the submission and implementation of the design of the pedestrian connection between the public promenade and the proposed development to the satisfaction of the Director of Leisure and Cultural Services or of the Town Planning Board;
 - (i) the submission and implementation of the design of the public transport interchange as well as vehicular access, parking facilities, loading/unloading spaces and lay-bys for the proposed development to the satisfaction of the Commissioner for Transport or of the Town Planning Board; and

**DEVELOPMENT PARAMETER BASED ON APPROVED SCHEME UNDER
S16 APPLICATION NO. A/K9/260**

LOCATION & LOT NO.: KIL11205, Junction of Hung Luen Road & Wa Shun Street,
Kowloon

Development Parameter

Site Area:	15,623sq.m.
Total Plot Ratio (PR):	4
Site Coverage:	80% max.
Total GFA:	62,492sq.m. max.
- PTI GFA	10,750sq.m. min.
- Hotel	51,742sq.m. max.
	(excl. 2,587.1sq.m. for Back of House area)
	(incl. 5,708sq.m. min. for Hotel-related Eating Place / Shop and Services and 46,034sq.m. max. remaining Hotel area)
No. of Blocks:	1
No. of Storeys:	18 (incl. 1 basement level)
Building Height:	
- Main Roof	75mPD
- Various deck levels	Ranging from 11.75mPD to 75mPD
Height of Roof-top Structures:	7m
Greenery Coverage:	20% min.
No. of Hotel Rooms:	599 max.
Car Parking and L/UL Facilities:	
- Private car parking space	69
- Motorcycle parking space	7
- L/UL bays	14
- Taxi Lay-bys	3
- Coach Lay-bys	3
PTI Facilities:	
- Franchised Bus Bay	10
- Green Mini Bus (GMB) Bay	1
- Taxi Lay-bys	1
- General Lay-bys	1
Anticipated Completion Time:	2018

THE MLP WILL BE SUBJECT TO CHANGE TO INCORPORATE THE REQUIREMENTS OF THE APPROVAL CONDITIONS

ADJACENT LOT
K.I.L. 11111

30M
NON-BUILDING
AREA

PROPOSED VEHICULAR
INGRESS & EGRESS

HUNG

LUEN

ROAD

PROPOSED PTI
INGRESS & EGRESS

LANDSCAPE DECK
(3 STOREYS)
+22.00

LANDSCAPE DECK
(16 STOREYS)
+81.70

LANDSCAPE DECK
(16 STOREYS)
+71.00

DECK
+11.75

LANDSCAPE DECK
(4 STOREYS)
+28.50

DECK
+81.70

HOTEL ABOVE PTI

FLAT ROOF
(17 STOREYS)
+75.00

LANDSCAPE DECK
(3 STOREYS)
+22.00

SITE
KOWLOON INLAND
LOT NO. 11205

LANDSCAPE DECK
(7 STOREYS)
+40.00

LANDSCAPE DECK
(4 STOREYS)
+28.50

DECK
+27.00

POOL

LANDSCAPE DECK
(1 STOREY)
+11.75

LANDSCAPE DECK
(2 STOREYS)
+16.50

DECK +26.00

LANDSCAPE NON-BUILDING AREA

EXISTING WATERFRONT PROMENADE

EXISTING
GOVERNMENT
PUMP HOUSE
(UNDERGROUND)
SEE NOTE *1

HUNG HOM BAY

VICTORIA

HARBOUR

FERRY
PIER

FERRY PIER

EXISTING
BUS
TERMINAL

B.D. Ref. No. 屋宇署建築編號			
F.S.D. Ref. No. 消防處建築編號			
Revision/Submission 修改版/編號			
No. 編號	Description 說明	Date 日期	Approved 審批
A	S16 SUBMISSION	19.04.2013	FH
B	S16 SUBMISSION	25.04.2013	FH
C	S16 SUBMISSION	22.05.2013	FH
D	S16 SUBMISSION	31.05.2013	FH
E	S16 SUBMISSION	06.09.2013	FH
F	S16 SUBMISSION	30.10.2013	FH

LEGEND:

- INDICATIVE PEDESTRIAN ROUTE/CONNECTION BETWEEN 24HR PUBLICLY ACCESSIBLE PEDESTRIAN WALKWAY & ADJACENT LOT K.I.L. 11111 WATERFRONT PROMENADE/GOVERNMENT ACCOMMODATION
- ADDITIONAL PEDESTRIAN ACCESS CONNECTION
- EMERGENCY VEHICULAR ACCESS
- INDICATIVE PIPE & CABLE ROUTING (UNDERGROUND)

- NOTE: *1 EXISTING GOVERNMENT PUMP-HOUSE FACILITIES TO BE CONNECTED TO AND USED BY THE PROPOSED DEVELOPMENT. UNDERGROUND PIPES/CABLES IN CONNECTION TO BE BY APPLICANT.
- *2 ALL LEVELS TO BE THE STRUCTURAL FLOOR LEVEL OF MAIN ROOF OF THE ROOFS. CERTAIN ROOF TOP ELEMENTS WILL PROJECT ABOVE THESE STRUCTURAL FLOOR LEVELS SUCH AS ROOF FINISHES, PLANTERS, PARAPET WALLS, STEPS AND RAMPS CONNECTING WITH INDOOR AREA, LIGHTING PROVISION, BUILDING MAINTENANCE SYSTEM, LIGHTING PROTECTION AND TELE-COMMUNICATION PROVISION, LIFT SHAFT & OVERLAP, DOORHOUSES, ETC. DETAILED OUTLINING ARE SUBJECT TO FURTHER DETAIL DESIGN AND APPROVAL OF THE BUILDING AUTHORITY.

This drawing and the contents herein are the copyright of Rocco Design Architects Limited. 本圖紙及其內容的版權屬許李顯建築師事務所有限公司所有。

No part of the drawing and the design contained herein may be reproduced without the prior written consent of a director of Rocco Design Architects Limited. 未經本公司董事書面同意，不得複製此圖紙內任何內容或設計。

Do not take measurements directly from this drawing. 切勿直接從圖紙上量度尺寸。

Check and verify all dimensions on site. 所有尺寸必須在工地現場量度及審核。

Read this drawing in conjunction with the specifications and all other related drawings. 此圖紙必須與規格說明書及其它有關圖紙一併閱讀。

Notify the Architect immediately of any discrepancy found herein. 如發現內容有任何錯誤之處，應立即通知建築師。

Client 業主
SHANGRI-LA HOTEL (KOWLOON) LTD.

Project 項目
HOTEL DEVELOPMENT AT K.I.L. 11205, JUNCTION OF HUNG LUEN ROAD & WA SHUN STREET, HUNG HOM, KOWLOON

Drawing Title 圖名

MASTER LAYOUT PLAN

Scale 比例 1:1000	Drawn 製圖 TL	Checked 校對 AC
Job No. 項目編號 1983	Drawing No. 圖號 B576	Revision 修改版 F

茲證明城市規劃委員會已根據城市規劃條例第4A(3)條的規定而於二零一三年十二月十三日批准本總綱發展藍圖。

I hereby certify, as required under S.4A(3) of the Town Planning Ordinance, that this Master Layout Plan was approved by the Town Planning Board on 13. 12. 2013.

signed Thomas CHOW 周達明
Chairman, Town Planning Board 城市規劃委員會主席 簽署

ROCCO
許李顯

B.D. Ref No. 屋宇審裁處編號				
F.S.D. Ref No. 消防處樓宇編號				
Revision/Submission 修改版/轉提				
No. 編號	Description 說明	Date 日期	Approved 審批	
A	NO SUBMISSION	21.12.2012	FM	
B	S16 SUBMISSION	14.01.2013	FM	
C	S16 SUBMISSION	19.04.2013	FM	
D	S16 SUBMISSION	21.06.2013	FM	
E	S16 SUBMISSION	04.09.2013	FM	
F	S16 SUBMISSION	30.10.2013	FM	

LEGEND:

	Pile Area
	HOTEL (HOTEL-RELATED EXISTING PLACE/SHOP & SERVICES)
	HOTEL (PLANT ROOMS/CORE)

NOTE:

ALL LEVELS TO BE THE STRUCTURAL FLOOR LEVEL OF MAIN ROOF OF THE ROOFS/ROCKS. CERTAIN ROOF TOP ELEMENTS WILL PROJECT ABOVE THESE STRUCTURAL FLOOR LEVELS SUCH AS ROOF FINISHES, PLANTERS, PARAPET WALLS, STEPS AND RAMP CONNECTING WITH PILE AREA, LIFTWAYS, PROVISION, BUILDING MAINTENANCE SYSTEM, LIGHTING PROTECTION AND TELE-COMMUNICATION PROVISION, LIFT SHAFT & OVERHEAD COCKHOUSE, ETC. DETAILED SPECIFICATIONS ARE SUBJECT TO FURTHER DETAIL DESIGN AND APPROVAL OF THE BUILDING AUTHORITY.

This drawing and the contents herein are the copyright of Rocco Design Architects Limited. 本圖紙及其內容的版權屬於羅傑建築師事務所有限公司所有。

No part of the drawing and the design contained herein may be reproduced without the prior written consent of a director of Rocco Design Architects Limited. 未經本公司董事書面同意，不得複製此圖紙內任何內容或設計。

Do not take measurements directly from this drawing. 切勿直接從圖紙上量度尺寸。

Check and verify all dimensions on site. 所有尺寸必須在工地現場核實及覆核。

Read this drawing in conjunction with the specifications and all other related drawings. 此圖紙必須與規格說明書及其它有關圖紙一併閱讀。

Notify the Architect immediately of any discrepancy found herein. 如發現內容有任何錯誤之處，應立即通知建築師。

Client 業主

SHANGRI-LA HOTEL (KOWLOON) LTD.

Project 項目


HOTEL DEVELOPMENT AT K. I. L. 11205, JUNCTION OF HUNG LUEN ROAD & WA SHUN STREET, HUNG HOM, KOWLOON

Drawing Title 圖名

BASEMENT PLAN

Scale 比例	Drawn 繪圖	Checked 校對
1:500	TL	AC
Job No. 項目編號	Drawing No. 圖號	Revision 修改版
1963	B662	F

ROCCO
許李

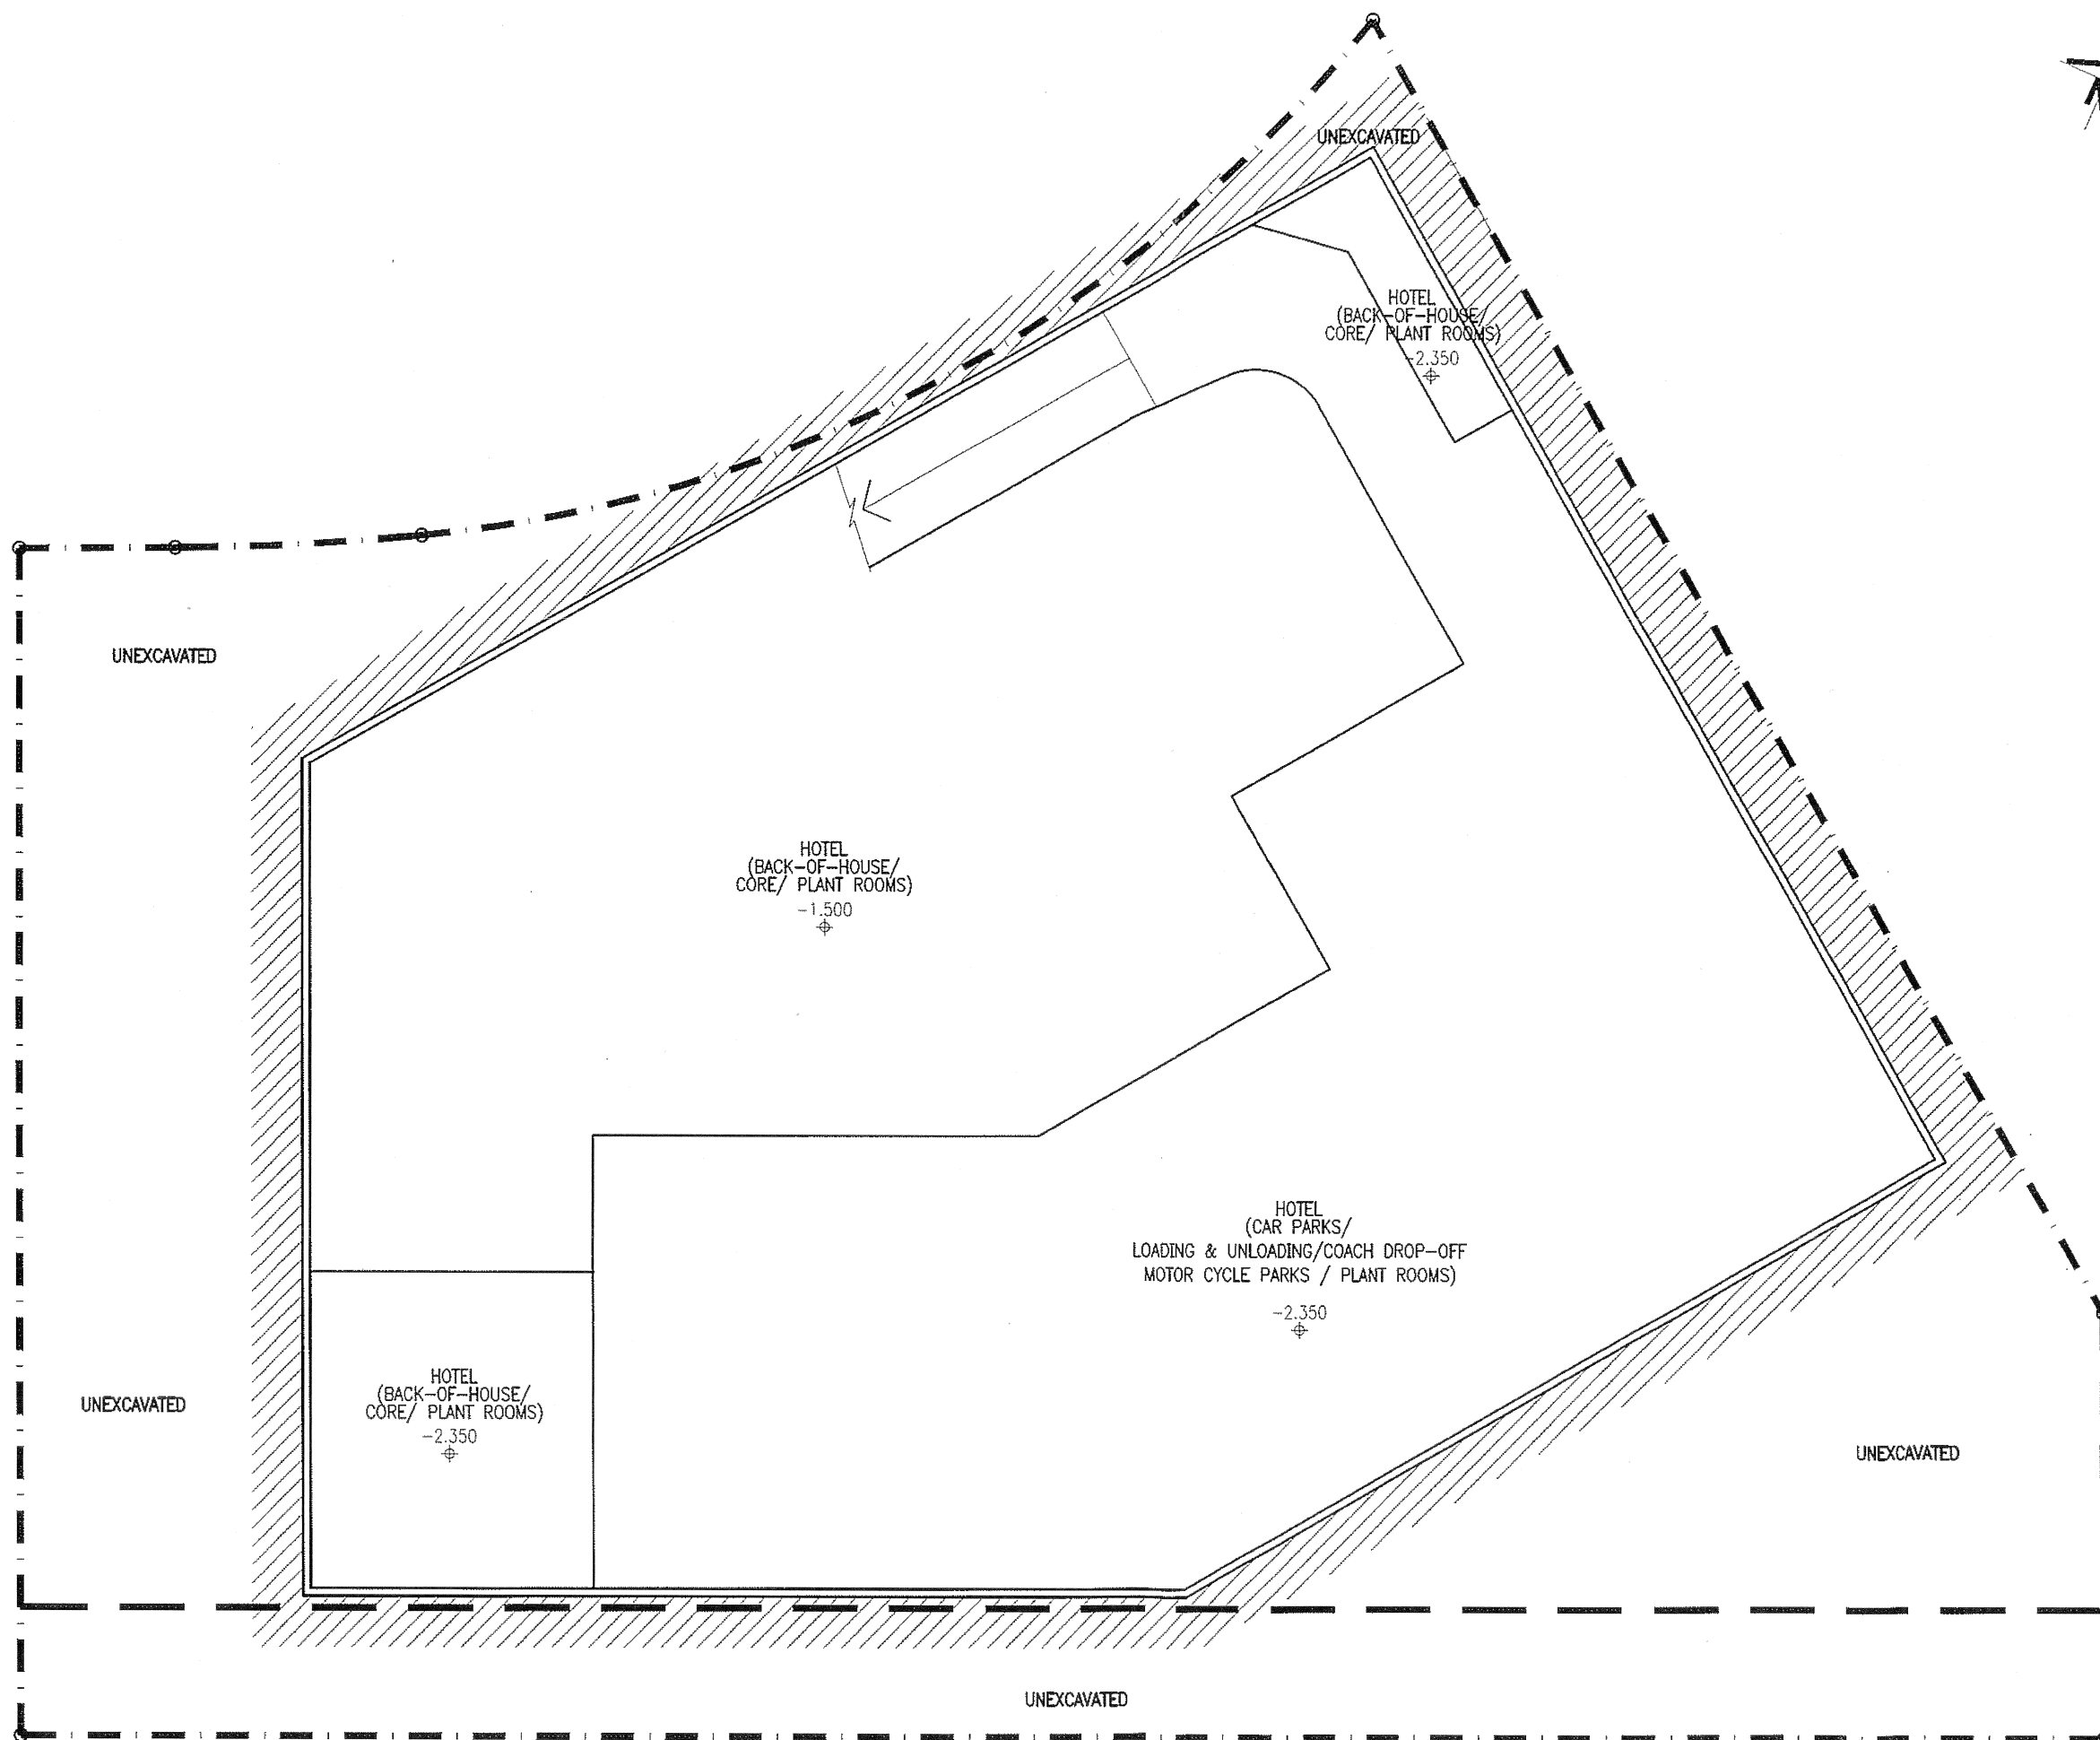

0 D Ref No. 屋宇署建築編號

FSD Ref No. 消防處建築編號

Revision/Submission 修改版/版數

No. 編號	Description 說明	Date 日期	Approved 審批
A	HC SUBMISSION	21.12.2012	PH
B	S16 SUBMISSION	19.04.2013	PH
C	S16 SUBMISSION	04.07.2013	PH
D	S16 SUBMISSION	20.10.2013	PH

LEGEND:

	PTH AREA
	HOTEL (HOTEL-RELATED EXISTING PLACE/SHOP & SERVICES)
	HOTEL (PLANT ROOMS/CORE)

NOTE:

ALL LEVELS TO BE THE STRUCTURAL FLOOR LEVEL OF EACH FLOOR OF THE BUILDING. CERTAIN ROOF TOPS/ROOFS WILL PROJECT ABOVE THESE STRUCTURAL FLOOR LEVELS SUCH AS ROOF FINISHES, PLANTERS, PARAPET WALLS, STEPS AND RAMPES CONNECTING WITH INDOOR AREA, LIGHTING PROTECTION, BUILDING MAINTENANCE SYSTEM, LIGHTING PROTECTION AND TELE-COMMUNICATION PROVISION, LIFT SHAFT & OVERHEAD, CORRIDORS, ETC. DETAILED SPECIFICATIONS ARE SUBJECT TO FURTHER DETAIL DESIGN AND APPROVAL OF THE BUILDING AUTHORITY.

- This drawing and the contents herein are the copyright of Rocco Design Architects Limited.
本圖紙及其內容的版權屬許李顯建築師事務所有限公司所有。

- No part of the drawing and the design contained herein may be reproduced without the prior written consent of a director of Rocco Design Architects Limited.
未經本公司董事書面同意，不得複製此圖紙內任何內容或設計。

- Do not take measurements directly from this drawing.
切勿直接從圖紙上量度尺寸。

- Check and verify all dimensions on site.
所有尺寸必須在工地現場量度及審核。

- Read this drawing in conjunction with the specifications and all other related drawings.
此圖紙必須與規格說明書及其它有關圖紙一併閱讀。

- Notify the Architect immediately of any discrepancy found herein.
如發現內有任何錯誤之處，應立即通知建築師。

Client 業主

SHANGRI-LA HOTEL
(KOWLOON) LTD.

Project 項目
HOTEL DEVELOPMENT AT
K. I. L., 11205, JUNCTION OF
HUNG LUEN ROAD &
WA SHUN STREET,
HUNG HOM, KOWLOON

Drawing Title 圖名

5TH & 6TH FLOOR PLAN

Scale 比例

1:500

Drawn 繪圖

TL

Checked 校對

AC

Job No. 項目編號

1963

Drawing No. 圖號

B666

Revision 修改版

D

ROCCO
許李顯

B.D. Ref No. 屋宇署核准編號			
F.S.D. Ref No. 消防處核准編號			
Revision/Revision 修改版/版次			
No. 編號	Description 說明	Date 日期	Approved 審定
A	NO SUBMISSION	21.12.2012	FM
B	S16 SUBMISSION	19.04.2013	FM
C	S16 SUBMISSION	20.05.2013	FM
D	S16 SUBMISSION	06.09.2013	FM
E	S16 SUBMISSION	30.10.2013	FM

LEGEND:

	PTE AREA
	HOTEL (HOTEL-RELATED EATING PLACE/SHOP & SERVICES)
	HOTEL (PLANT ROOMS/CORE)

NOTE:

ALL LEVELS TO BE THE STRUCTURAL FLOOR LEVEL OF MAIN ROOF OF THE ROOFS/DECKS. CERTAIN ROOF TOP ELEMENTS WILL PROJECT ABOVE THESE STRUCTURAL FLOOR LEVELS SUCH AS ROOF FINISHES, PLANTING, PARAPET WALLS, STEPS AND RAMPS CONNECTING WITH ROOFS AREA. LIGHTING PROVISION, BUILDING MAINTENANCE SYSTEM, LIGHTNING PROTECTION AND TELE-COMMUNICATION PROVISION, LIFT SHAFT & CISTERN, DOORHOUSES, ETC. DETAILED SPECIFICATIONS ARE SUBJECT TO FURTHER DETAIL DESIGN AND APPROVAL OF THE BUILDING AUTHORITY.

- This drawing and the contents herein are the copyright of Rocco Design Architects Limited. 本圖紙及其內容的版權屬許李鐵建築師事務所有限公司所有。
- No part of the drawing and the design contained herein may be reproduced without the prior written consent of a director of Rocco Design Architects Limited. 未經本公司董事書面同意，不得複製此圖紙內任何內容或設計。
- Do not take measurements directly from this drawing. 切勿直接從圖紙上量度尺寸。
- Check and verify all dimensions on site. 所有尺寸必須在工地現場量度及審核。
- Read this drawing in conjunction with the specifications and all other related drawings. 此圖紙必須與規格說明書及其它有關圖紙一併閱讀。如有任何內容有任何錯誤之處，應立即通知和確認。

Client 業主

SHANGRI-LA HOTEL (KOWLOON) LTD.

Project 項目

HOTEL DEVELOPMENT AT K. I. L. 11205, JUNCTION OF HUNG LUEN ROAD & WA SHUN STREET, HUNG HOM, KOWLOON

Drawing Title 圖名

7TH FLOOR PLAN

Scale 比例	Drawn 製圖	Checked 校對
1:500	TL	AC
Job No. 項目編號	Drawing No. 圖號	Revision 修改版
1963	6669	E

ROCCO
許李

S.D. Ref. No. 屋宇審議署編號			
F.S.D. Ref. No. 消防處核對編號			
Revision/Submission 修改版/報社			
No. 編號	Description 說明	Date 日期	Approved 核准
A	HC SUBMISSION	21.12.2012	FM
B	S16 SUBMISSION	19.04.2013	FM
C	S16 SUBMISSION	20.05.2013	FM
D	S16 SUBMISSION	06.09.2013	FM
E	S16 SUBMISSION	30.10.2013	FM

LEGEND:

	Pile Area
	HOTEL (HOTEL-RELATED EATING PLACE/SHOP & SERVICES)
	HOTEL (PLANT ROOMS/CORE)

NOTE:

ALL LEVELS TO BE THE STRUCTURAL FLOOR LEVEL OF MAIN ROOF OF THE ROOFS/DECKS. CERTAIN ROOF TOP ELEVATIONS WILL FORMER ABOVE THESE STRUCTURAL FLOOR LEVELS SUCH AS ROOF FRITCHES, PLANTERS, PARAPET WALLS, STEPS AND RAMPS CONNECTING WITH TUGOUT AND, LIGHTING PROVISION, BUILDING MAINTENANCE SYSTEM, LIGHTNING PROTECTION AND TELE-COMMUNICATION PROVISION, LIFT SHAFT & OVERHEAD, DOCKHOUSES, ETC. DETAILED SPECIFICATIONS ARE SUBJECT TO FURTHER DETAIL DESIGN AND APPROVAL OF THE BUILDING AUTHORITY.

- This drawing and the contents herein are the copyright of Rocco Design Architects Limited. 本圖紙及其內容的版權屬於李耀建設計事務所有限公司所有。
- No part of the drawing and the design contained herein may be reproduced without the prior written consent of a director of Rocco Design Architects Limited. 未經本公司董事書面同意，不得複製此圖紙內任何內容或設計。
- Do not take measurements directly from this drawing 切勿直接從圖紙上量取尺寸。
- Check and verify all dimensions on site. 所有尺寸必須在工地現場核實及審核。
- Read this drawing in conjunction with the specifications and all other related drawings. 此圖紙必須與規格說明書及其他有關圖紙一併閱讀。
- Notify the Architect immediately of any discrepancy found herein. 如發現內容有任何錯誤之處，應立即通知建築師。

Client 業主

SHANGRI-LA HOTEL (KOWLOON) LTD.

Project 項目
HOTEL DEVELOPMENT AT K. I. L. 11205, JUNCTION OF HUNG LUEN ROAD & WA SHUN STREET, HUNG HOM, KOWLOON

Drawing Title 圖名

8TH FLOOR PLAN

Scale 比例	Drawn 繪圖	Checked 校對
1:500	TL	AC
Job No. 項目編號	Drawing No. 圖號	Revision 修改版
1993	B670	E

ROCCO
許李

U.D. Ref No. 屋宇圖則編號

F.S.D. Ref No. 消防處樓宇編號

Revision/Submission 修改版/圖號

No. 編號	Description 說明	Date 日期	Approved 審定
A	HC SUBMISSION	21.12.2012	FH
B	S16 SUBMISSION	19.04.2013	FH
C	S16 SUBMISSION	04.09.2013	FH
D	S16 SUBMISSION	30.10.2013	FH

LEGEND:

	PIT AREA
	HOTEL (HOTEL-RELATED EXISTING PLACES/SHOP & SERVICES)
	HOTEL (PLANT ROOMS/CORE)

NOTE:

ALL LEVELS TO BE THE STRUCTURAL FLOOR LEVEL OF MAIN ROOF OF THE ROOFS/DECKS. CERTAIN ROOF TOP ELEMENTS WILL PROJECT ABOVE THESE STRUCTURAL FLOOR LEVELS SUCH AS ROOF FINISHES, PLANTERS, PARAPET WALLS, STAIRS AND RAMP, CONNECTING WITH ROOF AREA, LIGHTING FIXTURES, BUILDING MAINTENANCE SYSTEM, LIGHTNING PROTECTION AND TELE-COMMUNICATION PROVISION, LIFT SHAFT & OVERHEAD, BOONHOUSES, ETC. DETAILS SPECIFICATIONS ARE SUBJECT TO FURTHER DETAIL DESIGN AND APPROVAL OF THE BUILDING AUTHORITY.

- This drawing and the contents herein are the copyright of Rocco Design Architects Limited.
本圖紙及其內容的版權歸許李屋建築師事務所有限公司所有。

- No part of the drawing and the design contained herein may be reproduced without the prior written consent of a director of Rocco Design Architects Limited.
未經本公司董事書面同意，不得複製此圖紙內任何內容或設計。

- Do not take measurements directly from this drawing.
切勿直接從圖紙上量度尺寸。

- Check and verify all dimensions on site.
所有尺寸必須在工地現場量度及核實。

- Read this drawing in conjunction with the specifications and all other related drawings.
此圖紙必須與規格說明書及其他有關圖紙一併閱讀。

- Notify the Architect immediately of any discrepancy found herein.
如發現內容有任何錯誤之處，應立即通知建築師。

Client 業主

SHANGRI-LA HOTEL
(KOWLOON) LTD.

Project 項目
HOTEL DEVELOPMENT AT
K. I. L. 11205, JUNCTION OF
HUNG LUEN ROAD &
WA SHUN STREET,
HUNG HOM, KOWLOON

Drawing Title 圖名

9TH TO 15TH FLOOR PLAN

Scale 比例
1:500

Drawn 製圖
TL

Checked 校對
AC

Job No. 項目編號
1963

Drawing No. 圖號
B671

Revision 修改版
D

ROCCO
許李屋

0.0 Ref No: 屋宇審裁處編號

F.S.D. Ref No: 消防處樓宇編號

Revision/Submission: 修改版/報批

No.	編號	Description	說明	Date	日期	Approved	審定
A	HC	SUBMISSION		21.12.2012		FH	
B	S16	SUBMISSION		19.04.2013		FH	
C	S16	SUBMISSION		06.09.2013		FH	
D	S16	SUBMISSION		30.10.2013		FH	

LEGEND:

	PIT AREA
	HOTEL (HOTEL-RELATED) CARING PLACE/SHOP & SERVICES
	HOTEL (PLANT ROOMS/CORE)

NOTE:

ALL LEVELS TO BE THE STRUCTURAL FLOOR LEVEL OF MAIN ROOF OF THE ROOFS/ROCKS. CERTAIN ROOF TOP ELEMENTS WILL PROTRUDE ABOVE THESE STRUCTURAL FLOOR LEVELS SUCH AS ROOF FINISHES, PLANTERS, PARADEL WELLS, STEPS AND RAMPS CONNECTING WITH ROOFS AREA, LIGHTING FIXTURES, BUILDING MAINTENANCE SYSTEM, LIGHTING PROTECTION AND LIFE-SAFETY COMMUNICATION PROVISION, LIFT SHAFT & OVERHEAD DOCKHOUSES, ETC. DETAILED SPECIFICATIONS ARE SUBJECT TO FURTHER DETAIL DESIGN AND APPROVAL OF THE BUILDING AUTHORITY.

- This drawing and the contents herein are the copyright of Rocco Design Architects Limited. 本圖紙及其內容均版權為羅拔建築師事務所有限公司所有。

- No part of the drawing and the design contained herein may be reproduced without the prior written consent of a director of Rocco Design Architects Limited. 未經本公司董事書面同意，不得複製此圖紙內任何內容及設計。

- Do not take measurements directly from the drawing. 切勿直接從圖紙上量度尺寸。

- Check and verify all dimensions on site. 所有尺寸必須在工地現場量度及核實。

- Read this drawing in conjunction with the specifications and all other related drawings. 此圖紙必須與規格說明書及其他有關圖紙一併閱讀。

- Notify the Architect immediately of any discrepancy found herein. 如發現內有任何錯誤之處，應立即通知建築師。

Client: 業主

SHANGRI-LA HOTEL
(KOWLOON) LTD.

Project: 項目
HOTEL DEVELOPMENT AT
K. I. L. 11205, JUNCTION OF
HUNG LUEN ROAD &
WA SHUN STREET,
HUNG HOM, KOWLOON


Drawing Title: 圖名

16TH FLOOR PLAN

Scale: 比例	Drawn: 繪圖	Checked: 校對
1:500	TL	AC
Job No: 項目編號	Drawing No: 圖號	Revision: 修改版
1963	B673	D

ROCCO
許李

16th Floor Plan, Kowloon, Hong Kong, 16th Floor Plan, Kowloon, Hong Kong

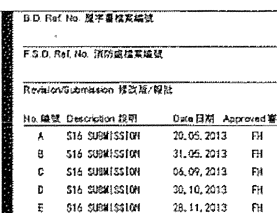

LEGEND:



NOTE:

NOTE: ALL LEVELS TO BE THE STRUCTURAL FLOOR LEVEL OF WAREHOUSE. THE ROOFS/DECKS, CERTAIN ROOF TOP ELEMENTS WILL PROJECT ABOVE THE STRUCTURAL FLOOR LEVELS SUCH AS ROOF FINISHES, PLANTERS, PARAPET WALLS, STEPS AND RAMPS CONNECTED WITH INDOOR AREA. LIGHTING PROVISION, BUILDING WARDING SYSTEM, LIGHTNING PROTECTION AND TELE-COMMUNICATION PROVISION, LIFE SCAFF & OVERRUNS, DOCKHOUSES, ETC. DETAILED SPECIFICATIONS ARE SUBJECT TO FURTHER DETAIL DESIGN AND APPROVAL OF THE ROYAL AUTHORITY.

- This drawing and the contents herein are the copyright of Rocco Design Architects Limited.
本圖紙及其內容的版權屬於李威建築師事務所有限公司

- No part of the drawing and the design contained herein may be reproduced without the prior written consent of a director of Rocco Design Architects Limited.
未經本公司董事書面同意，不得複製此圖紙內任何內容或設計。

- Do not take measurements directly from this drawing.
切勿直接從圖紙上量度尺寸。
- Check and verify all dimensions on site.
所有尺寸必須在工地現場檢查及實核。

- Read this drawing in conjunction with the specifications and information on the data plate.

此圖紙必須與規格說明書及其它有關圖紙一併閱讀。

- Notify the Architect immediately of any discrepancy found herein.

Client 業主

SHANGRI-LA HOTEL
(KOWLOON) LTD.


Project 項目
HOTEL DEVELOPMENT AT
K. I. L. 11205, JUNCTION OF
HUNG LUEN ROAD &
WA SHUN STREET,
HUNG HOM, KOWLOON

Drawing Title 圖名


SCHEMATIC SECTION A-A

Scale 比例 1:500	Drawn 製圖 TL	Checked 校核 AC
Job No. 項目編號 1963	Drawing No. 圖號 8881	Revision 修改 E

ROCCO
许奎

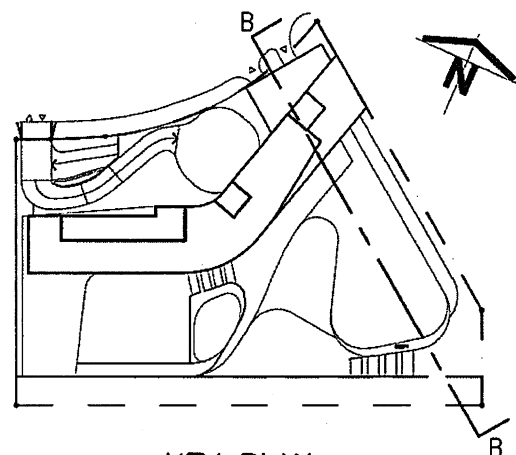


KEY PLAN

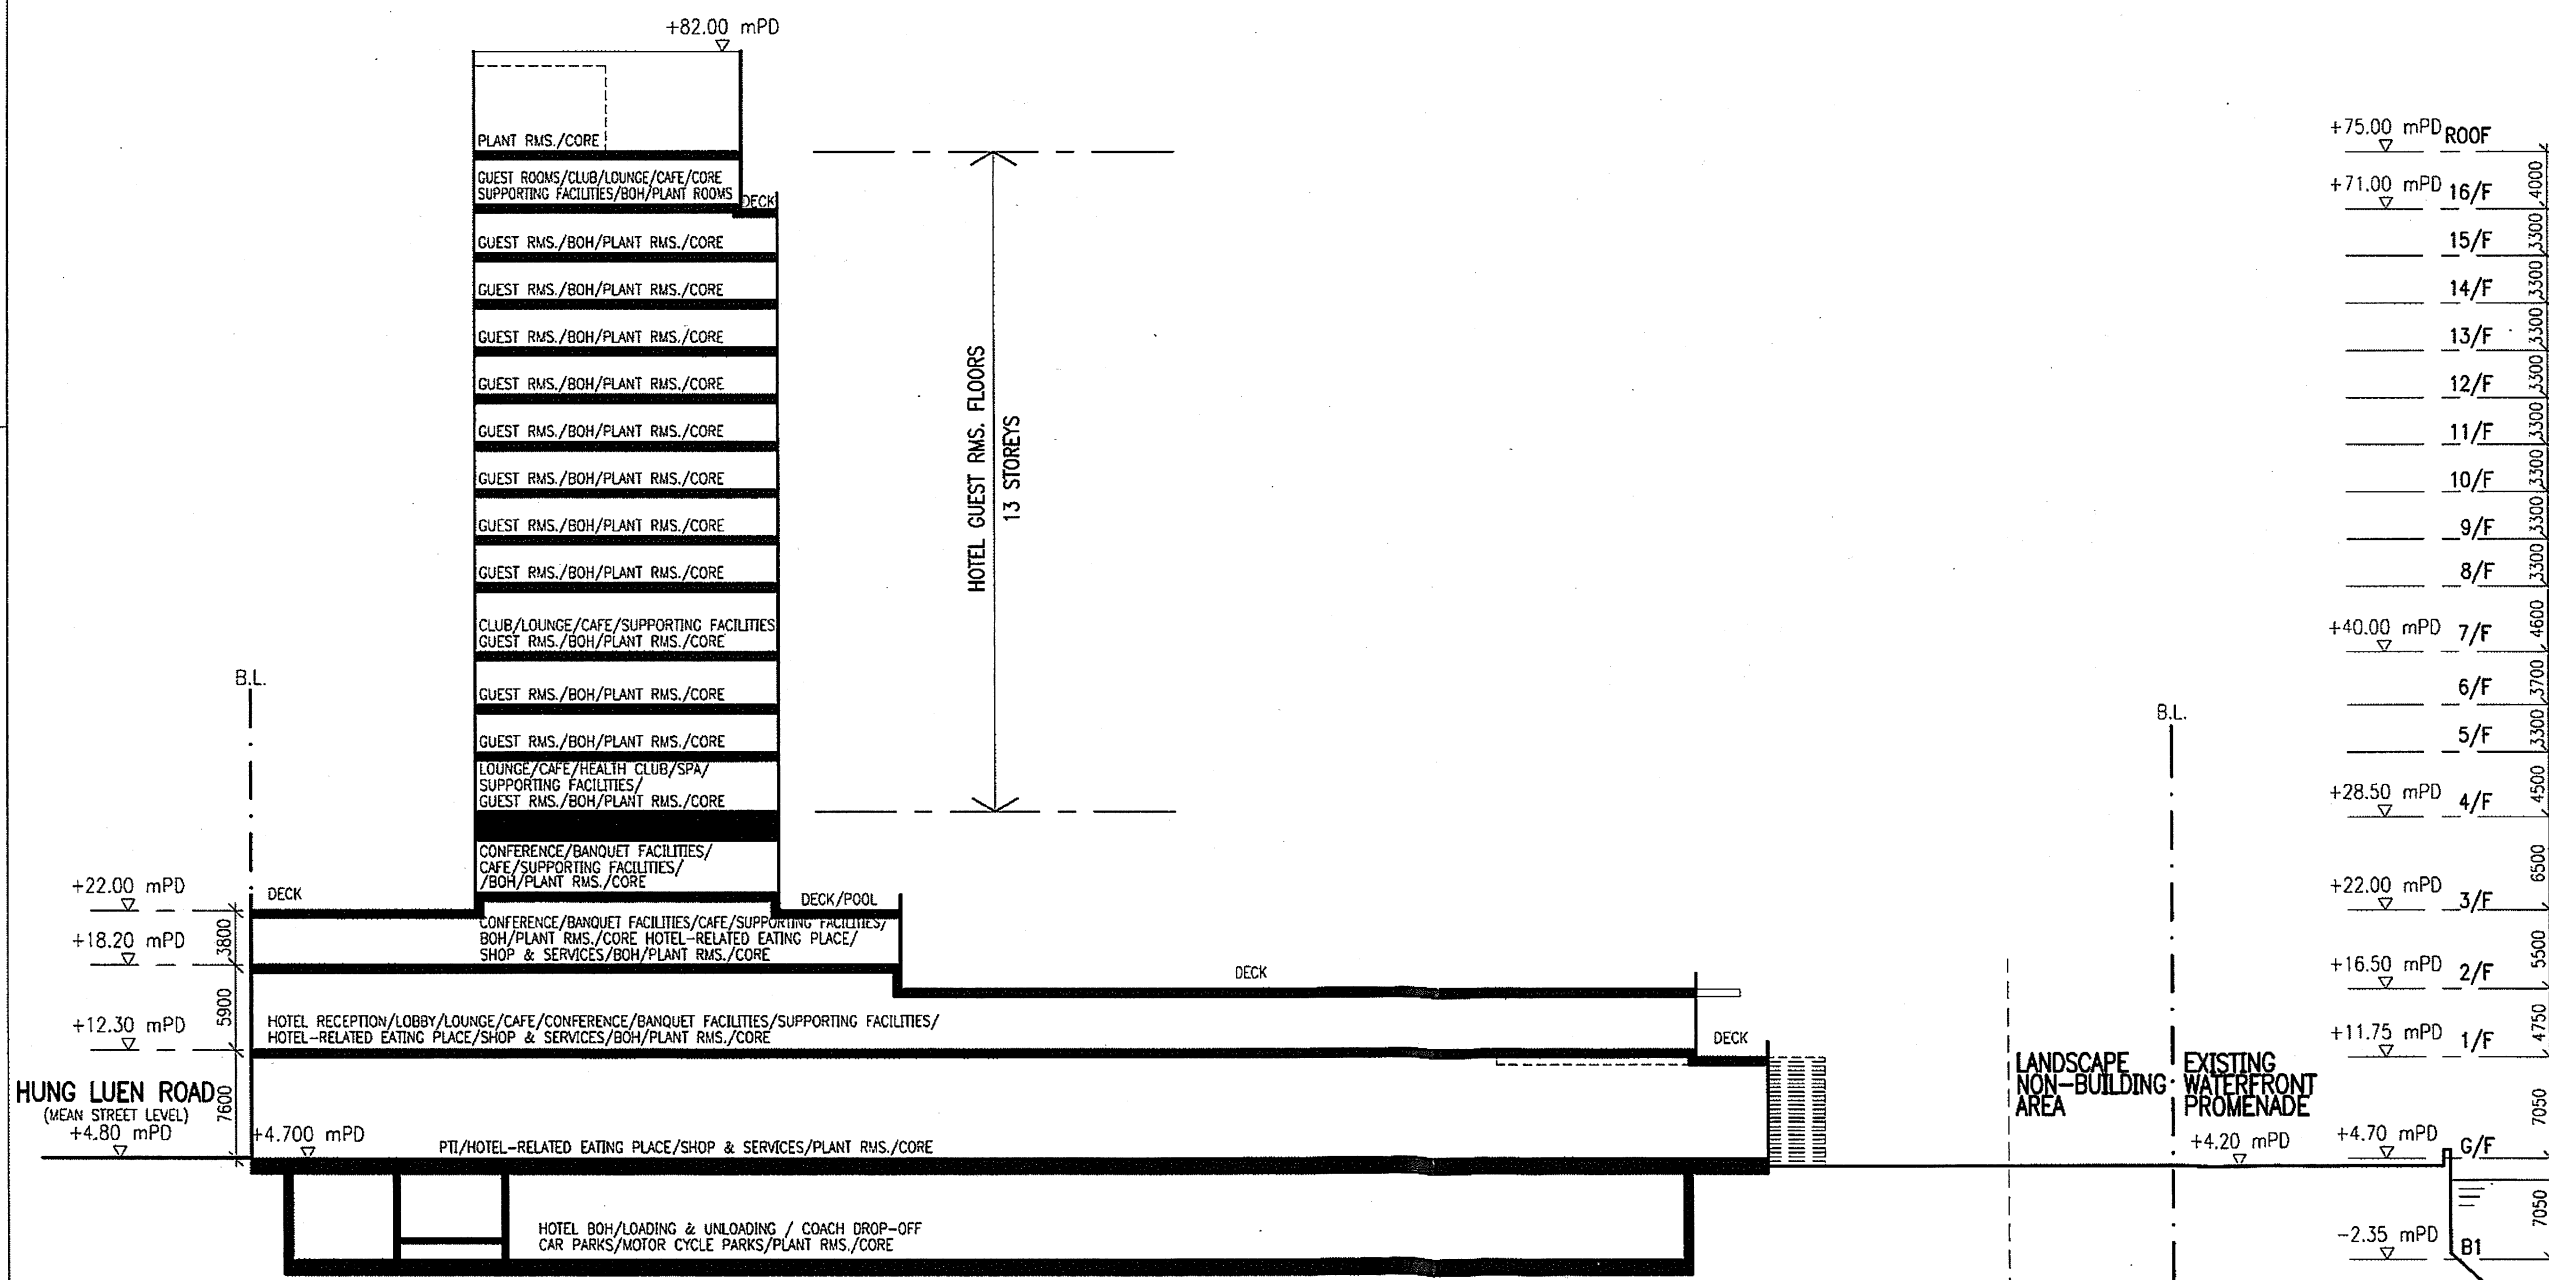

Revision/Submission 修改版/提交版			
No.	Description 说明	Date 日期	Approved 审批
A	NO SUBMISSION	21.12.2012	PH
B	S16 SUBMISSION	19.04.2013	PH
C	S16 SUBMISSION	31.05.2013	PH
D	S16 SUBMISSION	04.09.2013	PH
E	S16 SUBMISSION	30.10.2013	PH
F	S16 SUBMISSION	28.11.2013	PH

LEGEND:

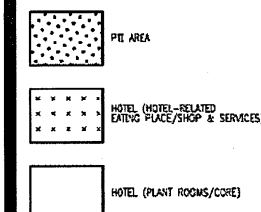

NOTE:

ALL LEVELS TO BE THE STRUCTURAL FLOOR LEVEL OF MAIN ROOF OF THE ROOFS/DECKS. CERTAIN ROOF TOP ELEVATIONS WILL PROTECT ABOVE THESE STRUCTURAL FLOOR LEVELS SUCH AS ROOF FINISHES, PLANTERS, PARAPET WALLS, STEPS AND RAMPS CONNECTING ROOF INDOOR AREA, LIGHTING PROVISION, BUILDING MAINTENANCE SYSTEM, LIGHTING PROTECTION AND TELL-COMMUNICATION PROVISION, LIFT SHAFT & OVERHEAD DOCKHOUSES, ETC. DETAILED SPECIFICATIONS ARE SUBJECT TO FURTHER DETAIL DESIGN AND APPROVAL OF THE BUILDING AUTHORITY.

This drawing and the contents herein are the copyright of Rocco Design Architects Limited. 本圖紙及其內容的版權屬於羅傑建築師有限公司所有。

No part of the drawing and the design contained herein may be reproduced without the prior written consent of a director of Rocco Design Architects Limited. 未經本公司董事書面同意，不得複製或重現任何內容或設計。

Do not take measurements directly from this drawing. 切勿直接從圖紙上量度尺寸。 Check and verify all dimensions on site. 所有尺寸必須在工地現場檢查及實核。

Read this drawing in conjunction with the specifications and all other related drawings. 此圖紙必須與規格說明書及其他有關圖紙一併閱讀。

Notify the Architect immediately of any discrepancy found herein. 如發現內容有任何錯誤之處，應立即通知建築師。

Client 業主

SHANGRI-LA HOTEL (KOWLOON) LTD.

Project 項目
HOTEL DEVELOPMENT AT K. I. L. 11205, JUNCTION OF HUNG LUEN ROAD & WA SHUN STREET, HUNG HOM, KOWLOON

Drawing Title 圖名

SCHEMATIC SECTION B-B

Scale 比例	Drawn 繪圖	Checked 校對
1:500 (A3)	TL	AC
Job No. 項目編號	Drawing No. 圖號	Revision 修改版
1963	B582	F

ROCCO
許李

MA TOU CHUNG
GOVERNMENT PRIMARY SCHOOL
(HUNG HOM BAY)

PROPOSED VEHICULAR INGRESS & EGRESS

HUNG LUEN ROAD
(+4.80 MEAN STREET LEVEL)

PROPOSED PTI
INGRESS & EGRESS

DECK
+22.00
⊕

DECK
+71.60
Φ

EXISTING BUS TERMINAL
(FUTURE PUBLIC OPEN SPACE
BY OTHERS)

HOTEL
(GUEST ROOMS/
CLUB/LOUNGE/CAFE
SUPPORTING FACILITIES/
BOH/PLANT ROOMS/CORE)

30M NON-BUILDING AREA
OF ADJACENT LOT K.I.L. 11111
BY OTHERS

(EVA)

DECK $\oplus$ +28.50

DECK
+22.00
⊕

DECK
+16.50

DEC
+11.7
⊕

DECK
+12.30
⊕

DECK
+40.00
⊕

DECK
+28.50

+27.00

POOL

DECK
+11.75
⊕

CANOPY

LANDSCAPE NON-BUILDING AREA

EXISTING PROMENADE +4.20

Notes

1. The copyright of this drawing belongs to Adrian L. Norman Limited.
2. Do not scale off this drawing.
3. All dimensions are in millimetres unless otherwise stated.
4. This drawings to be read in conjunction with all relevant architectural, civil/structural, and services engineer's drawings and specifications.
5. Should there be discrepancy between English and Chinese notes, the English note shall be taken as correct. This design and drawing are the exclusive property of ALN Limited. They cannot be used or reported without the written consent of ALN Limited.

LEVELS, DRAINAGE AND IRRIGATION LEGEND

CODE	DESCRIPTION
✓ FL	FINISH LEVEL
✓ TR	TOP OF RAILING
✓ TS	TOP OF SOIL LEVEL
✓ BOS	BOTTOM OF SOIL
✓ TW	TOP OF WALL LEVEL
✓ WL	WATER LEVEL
✓ BP	BOTTOM OF POOL
✓ TOS	TOP OF SEAT
✓ TK	TOP OF KERB
✓ HP	HIGH POINT

STRUCTURAL CODE LEGEND

CODE	DESCRIPTION
①	MASS CONCRETE FILL TO ENGINEER'S REQUIREMENTS
②	SAND SETTING BED, THICKNESS AS SPECIFIED
③	CONCRETE SLAB AND BASE, TO ENGINEER'S DETAIL DIMENSION AND SPECIFICATION (BY MAIN CONTRACTOR)
④	WATERPROOFING LAYER, TO ENGINEER'S DETAIL DIMENSION AND SPECIFICATION
⑤	MORTAR BASE, THICKNESS AS SPECIFIED
⑥a	LIGHT WEIGHT SOIL MIX (BY SOFT LANDSCAPE CONTRACTOR)
⑦	MINI DRAIN 1000 or APPROVED EQUAL, DRAINAGE OUTLETS TO ENGINEER'S DETAILS. (BY SOFT LANDSCAPE CONTRACTOR)
⑧	SUBSOIL DRAIN

Rev	Date	Description	Dwn	Chk	App
-	05SEP87	FIRST ISSUED	GK	LY	R

LANDSCAPE • MASTERPLANNING • URBAN DESIGN

qLn


Unit C, 6/F, Shaw House, Lot 220, Clear Water
Bay Road, Kowloon, Hong Kong
香港九龍清水灣道二二零地段邵氏大樓六樓C室
電話 T: 852 2358 2280 傳真 F: 852 2358 2281
電郵 E: adrian@aln.com.hk

Designed by	AN/RL/YK	
Drawn by	LY	
Checked by	RL	
Approved by	ALN	
Issued by		
Project Title		

Shangri La Hotel Development
KIL 11205, Hung Luen Road
Hung Hom Kowloon, Hong Kong
Drawing Title
Landscape Master Plan

Scale 1:500 (A3)

Job No. A408	Stage DD	Drawing No.	Rev.
Cad Ref.			Sheet Size A1

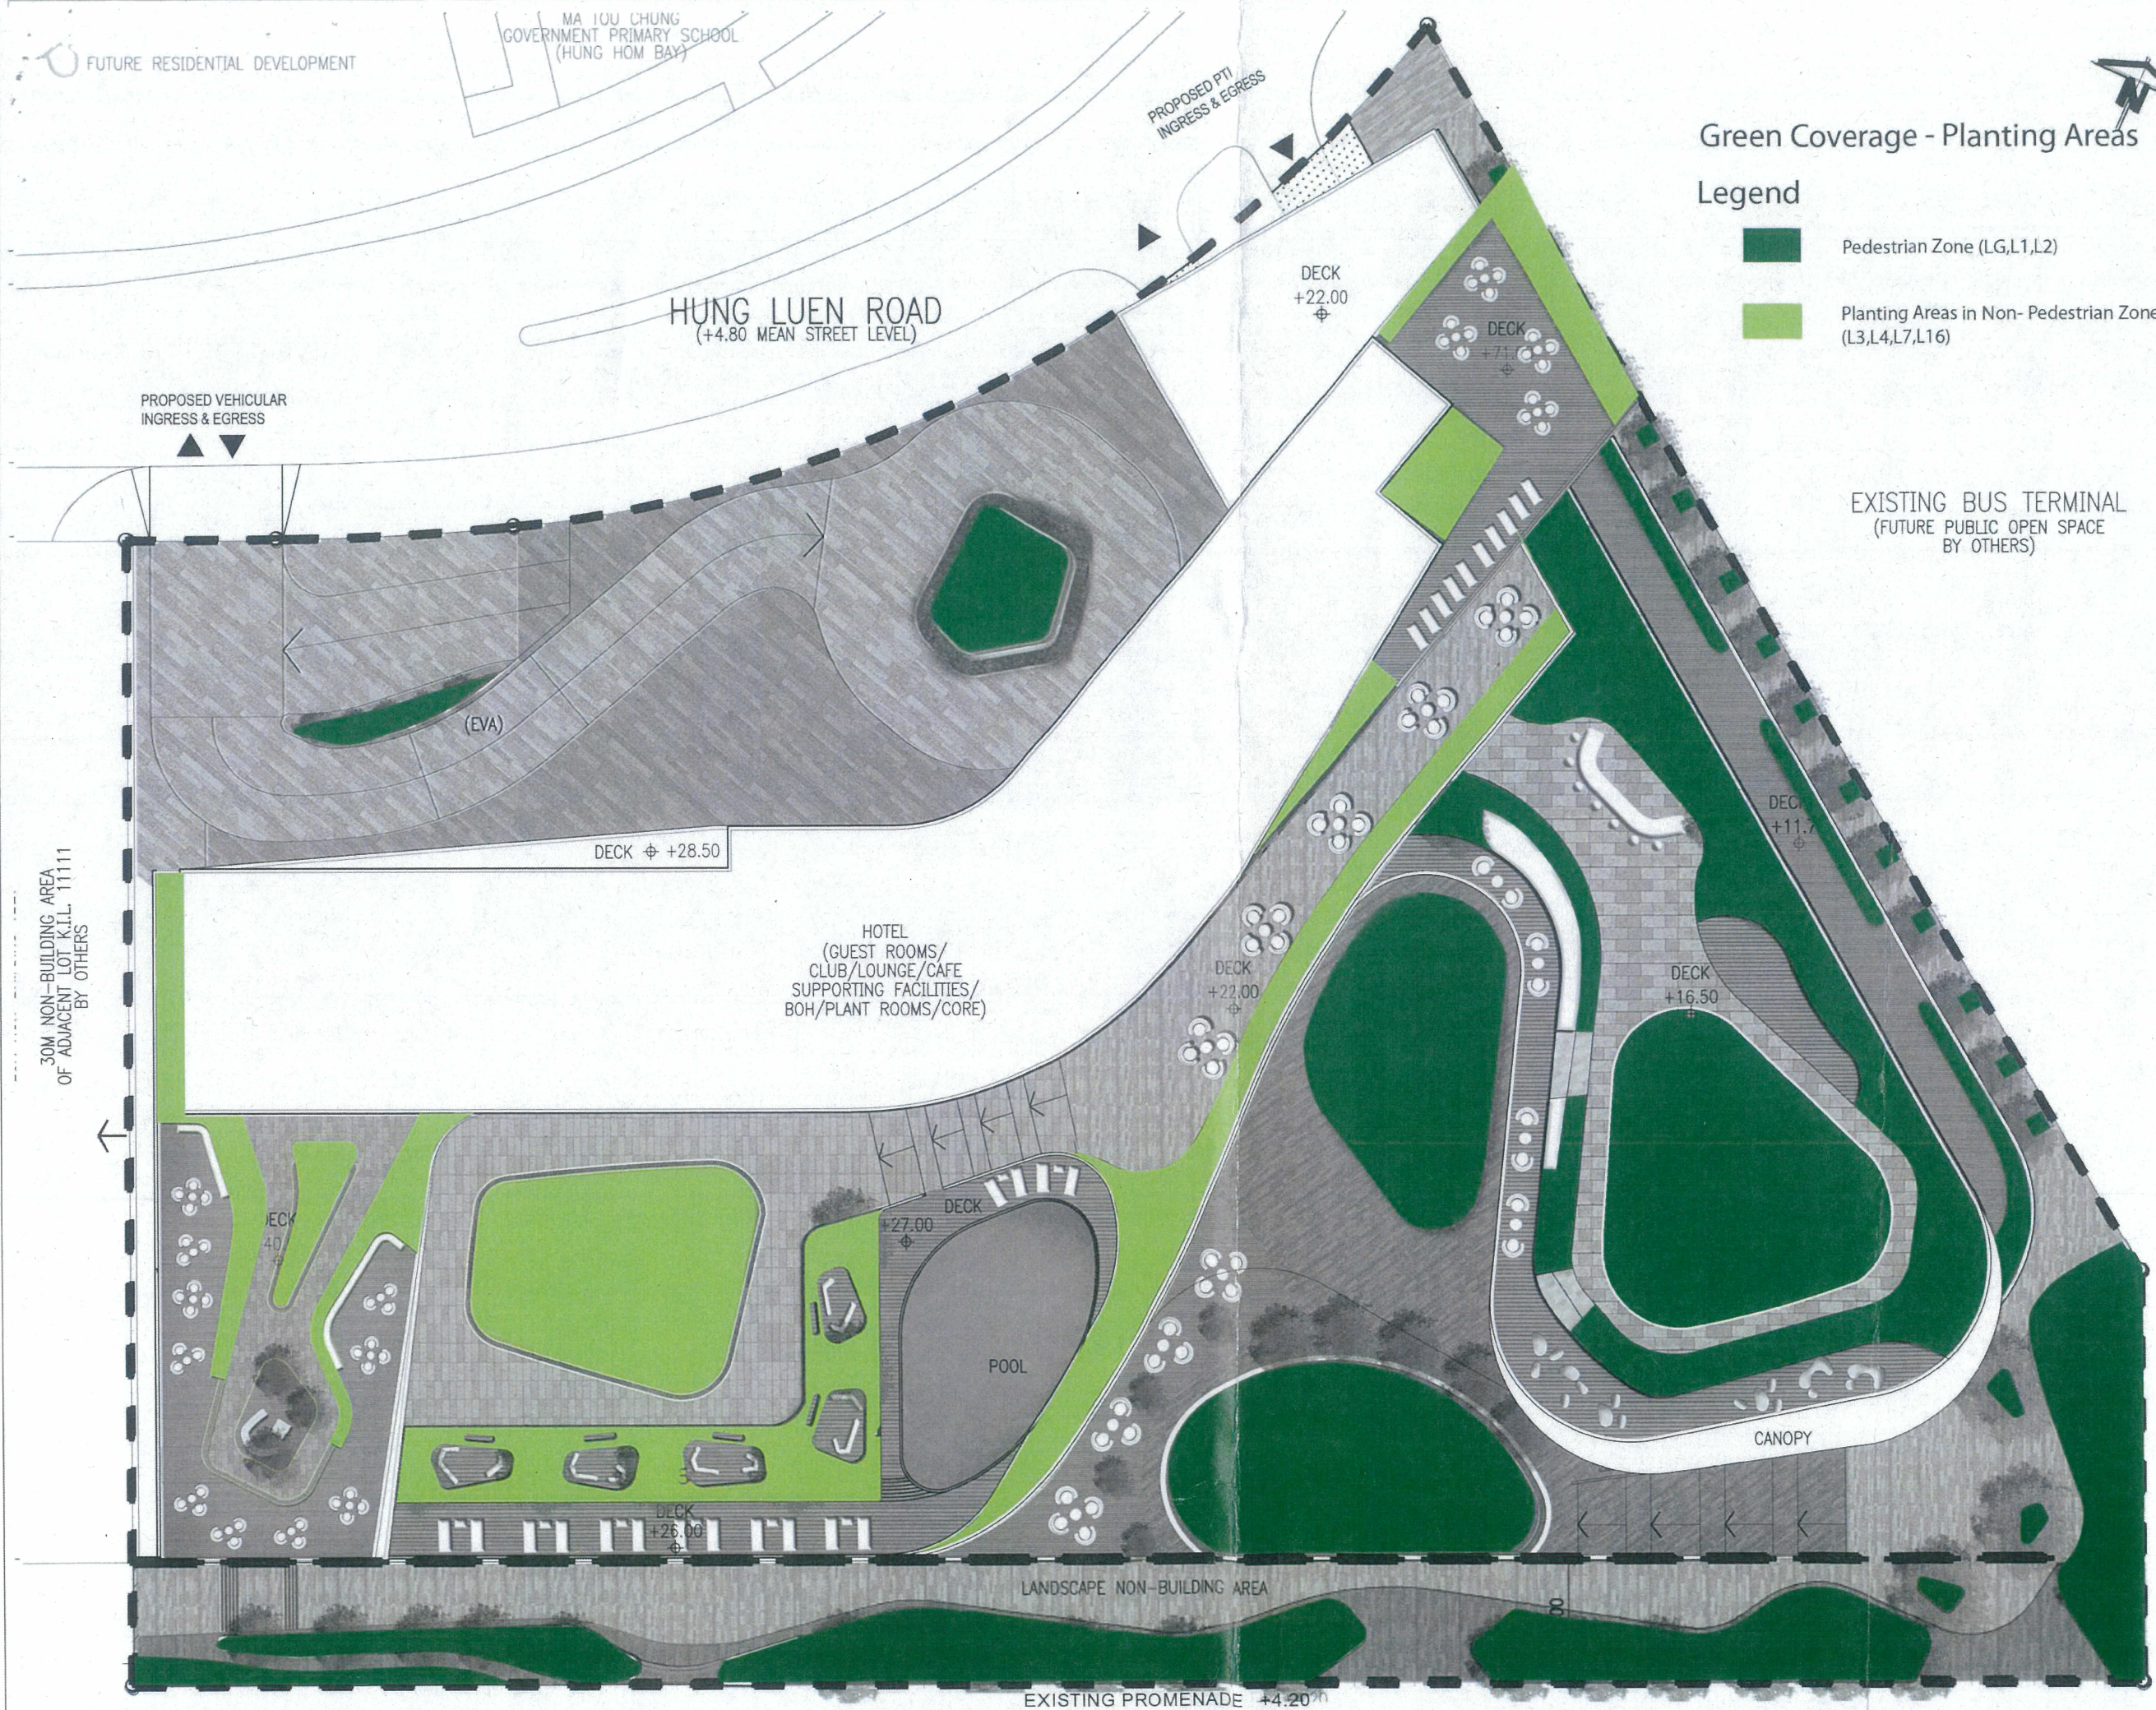

Green Coverage - Planting Areas

- Legend
- Pedestrian Zone (LG,L1,L2)
 - Planting Areas in Non- Pedestrian Zone (L3,L4,L7,L16)

NOTES:
1. The copyright of this drawing belongs to Adrian L. Norman Limited.
2. Do not scale off this drawing.
3. All dimensions are in millimetres unless otherwise stated.
4. This drawing is to be read in conjunction with all relevant architectural, civil/structural, and services engineer's drawings and specifications.
5. Should there be discrepancy between English and Chinese notes, the English note shall be taken as correct. This design and drawing are the exclusive property of ALN Limited. They cannot be used or reported without the written consent of ALN Limited.

LEVELS, DRAINAGE AND IRRIGATION LEGEND

CODE	DESCRIPTION
FL	FINISH LEVEL
TR	TOP OF RAILING
TS	TOP OF SOIL LEVEL
BS	BOTTOM OF SOIL
TL	TOP OF WALL LEVEL
WL	WATER LEVEL
BP	BOTTOM OF POOL
TS	TOP OF SEAT
TK	TOP OF KERB
HP	HIGH POINT

STRUCTURAL CODE LEGEND

CODE	DESCRIPTION
①	MASS CONCRETE FILL TO ENGINEER'S REQUIREMENTS
②	SAND SETTING BED, THICKNESS AS SPECIFIED
③	CONCRETE SLAB AND BASE TO ENGINEER'S DETAIL DIMENSION AND SPECIFICATION (BY MAIN CONTRACTOR)
④	WATERPROOFING LAYER, TO ENGINEER'S DETAIL DIMENSION AND SPECIFICATION
⑤	MORTAR BASE, THICKNESS AS SPECIFIED
⑥	LIGHT WEIGHT SOIL MIX (BY SOFT LANDSCAPE CONTRACTOR)
⑦	MIRACLAN KIDS OR APPROVED EQUAL, DRAINAGE OUTLETS TO ENGINEER'S DETAILS, (BY SOFT LANDSCAPE CONTRACTOR)
⑧	SUBSOIL DRAIN

Rev	Date	Description	Drw	Chk	App

05SEP18 FIRST ISSUED GK LY RL

LANDSCAPE MASTERPLANNING URBAN DESIGN

alN

Unit C, 6/F, Shaw House, Lot 220, Clear Water Bay Road, Kowloon, Hong Kong
香港九龍清水灣道二二零號映翠軒大樓六樓C室
電話 T: 852 2358 2280 傳真 F: 852 2358 2281
電郵 E: adrian@aln.com.hk

Designed by	ANRL/YK
Drawn by	LY
Checked by	RL
Approved by	ALN
Issued by	

Project Title
Shangri-La Hotel Development
KIL 11205, Hung Luen Road
Hung Hom Kowloon, Hong Kong
Drawing Title
Green Coverage

Scale	Job No.	Stage	Drawing No.	Rev.
	A408	DO		
Cad Ref.				Sheet Size A1